



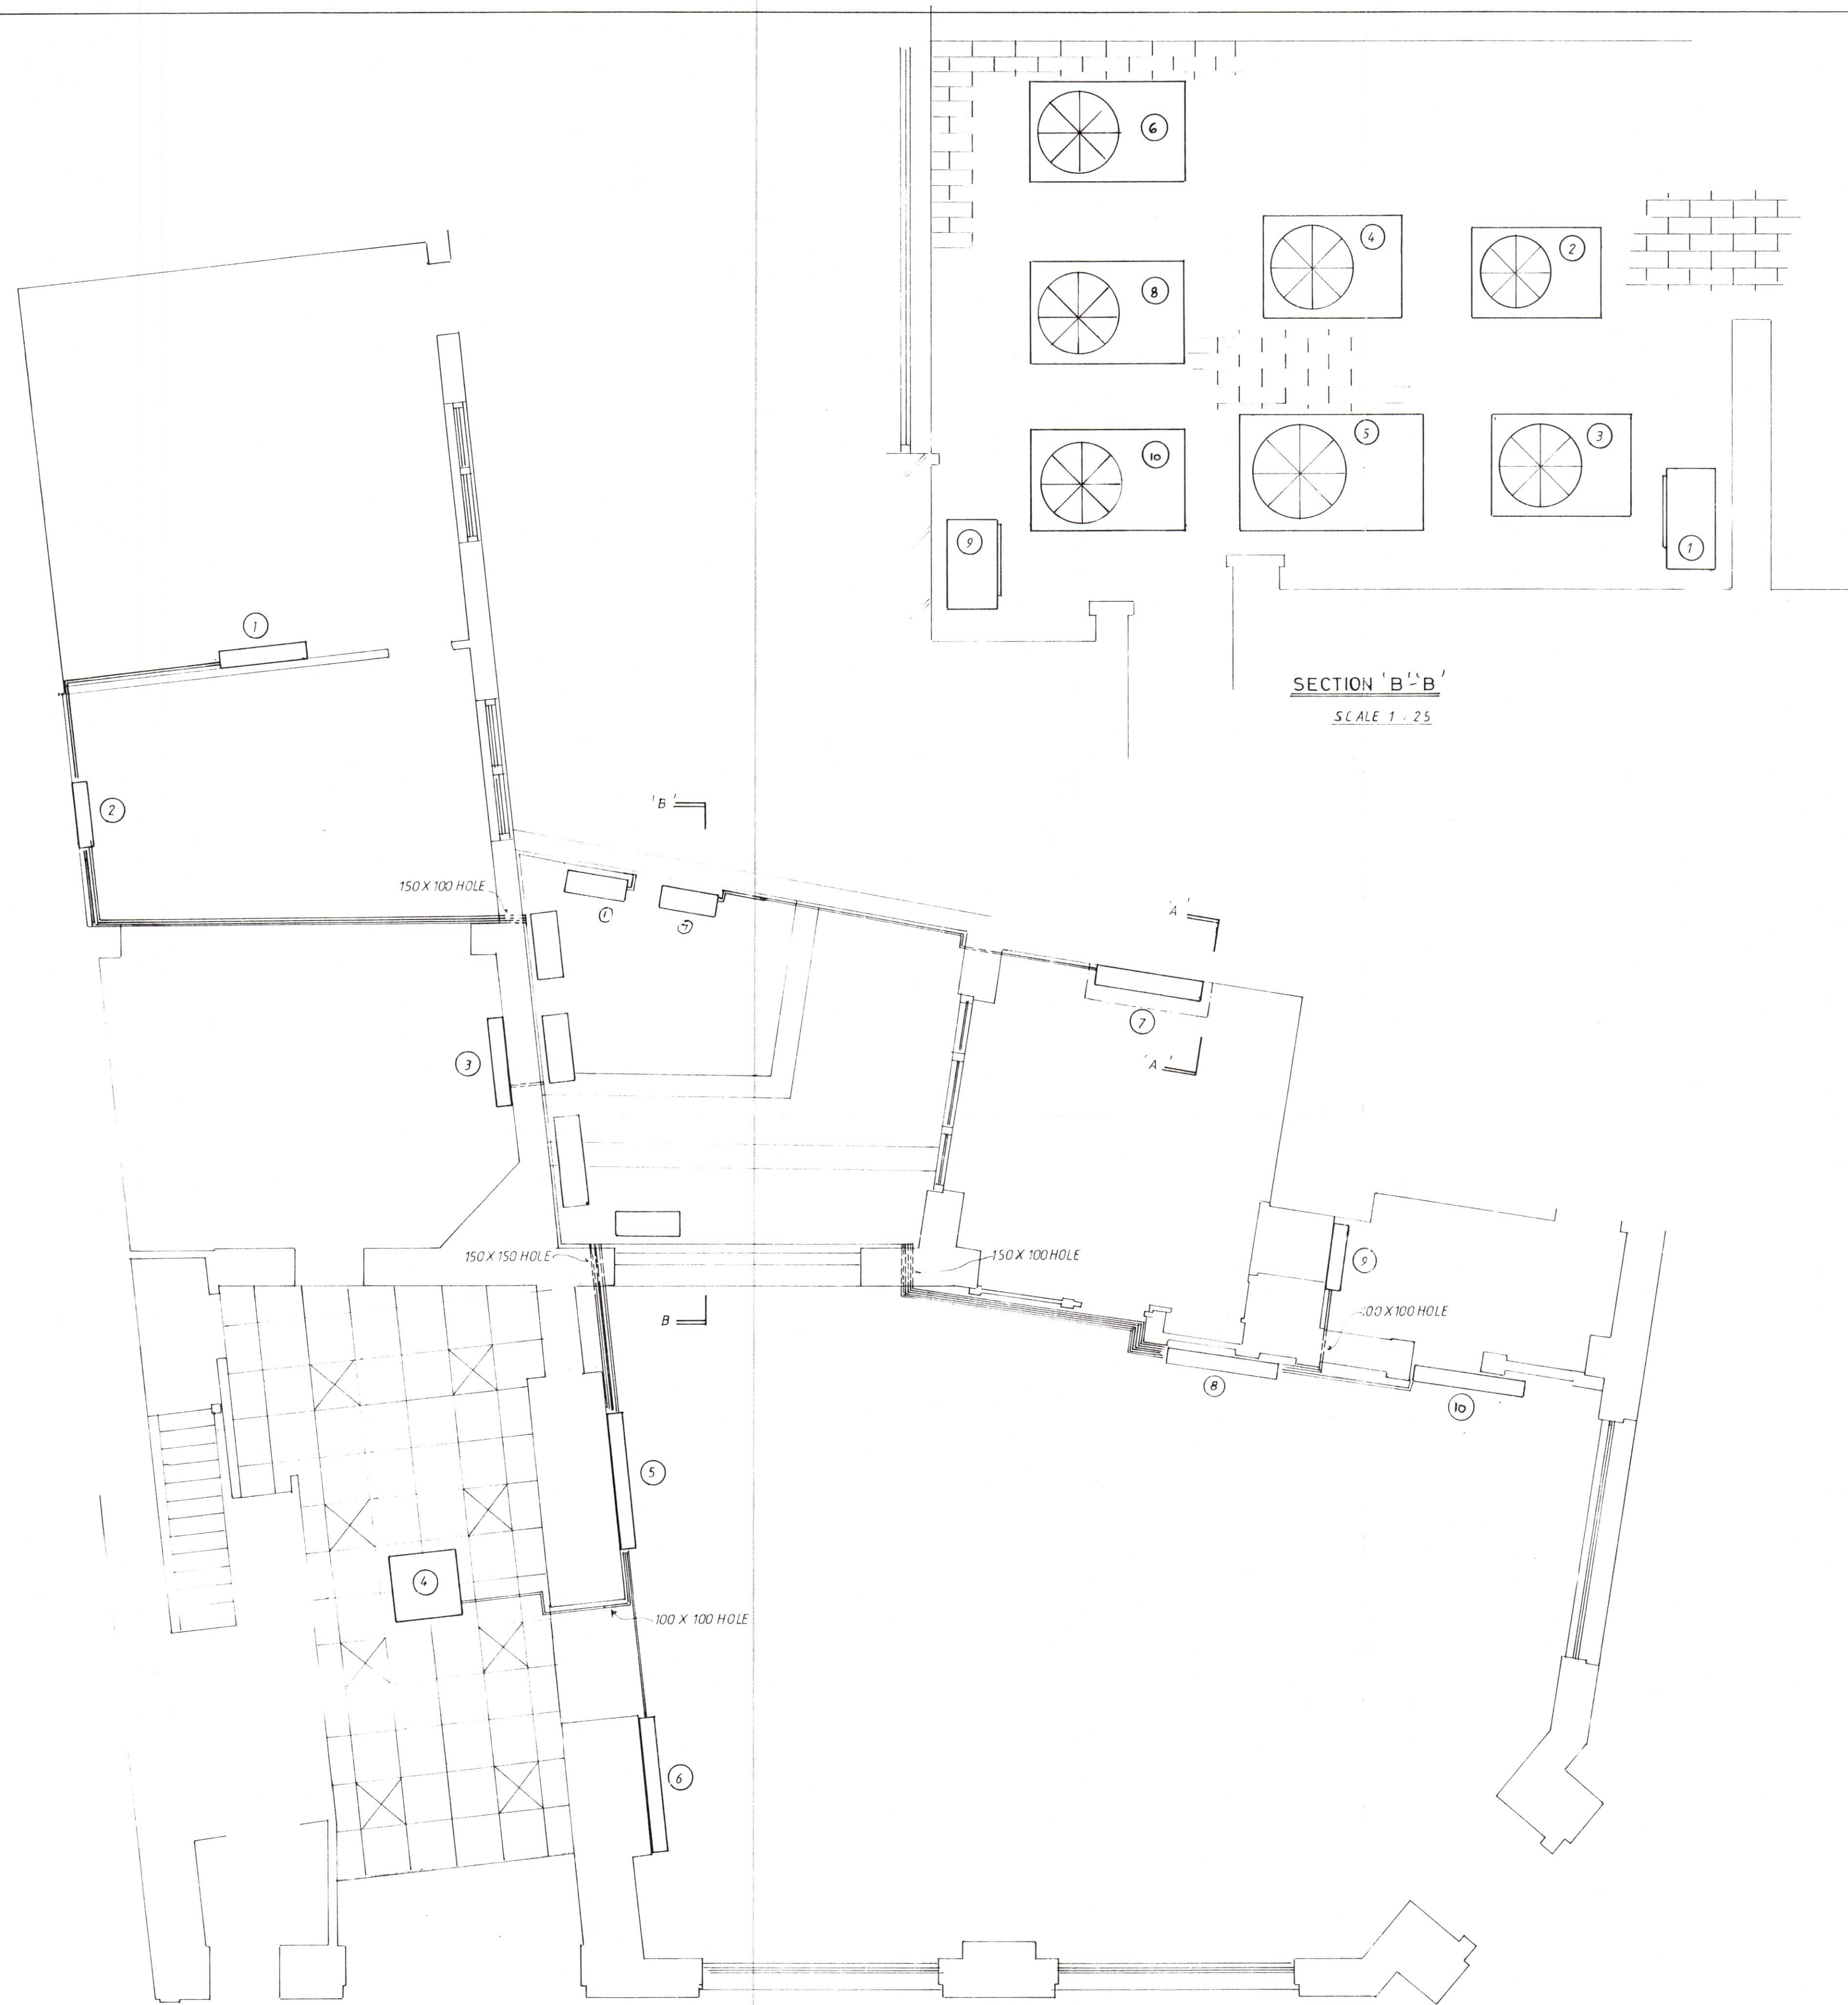


REF	MODEL	Kg	dBa	N c
1	IMPACT 60	24		
1	CUE 60	65	51	46
2	IMPACT 40	20		
2	CUE 40	56	50	47
3	IMPACT 60	24		
3	CUE 60	65	51	46
4	IMAGE 70	41		
4	CUE 80	73	51	45
5	IMPACT 100	34		
5	CUE 100	98	54	48
6	IMPACT 100	34		
6	CUE 100	98	54	48
7	QST 24			
7	QRO 24	64	53	
8	IMPACT 80	30		
8	CUE 90	88	53	47
9	IMPACT 40	20		
9	CUE 40	56	50	47
10	IMPACT 80	30		
10	CUE 90	88	53	47

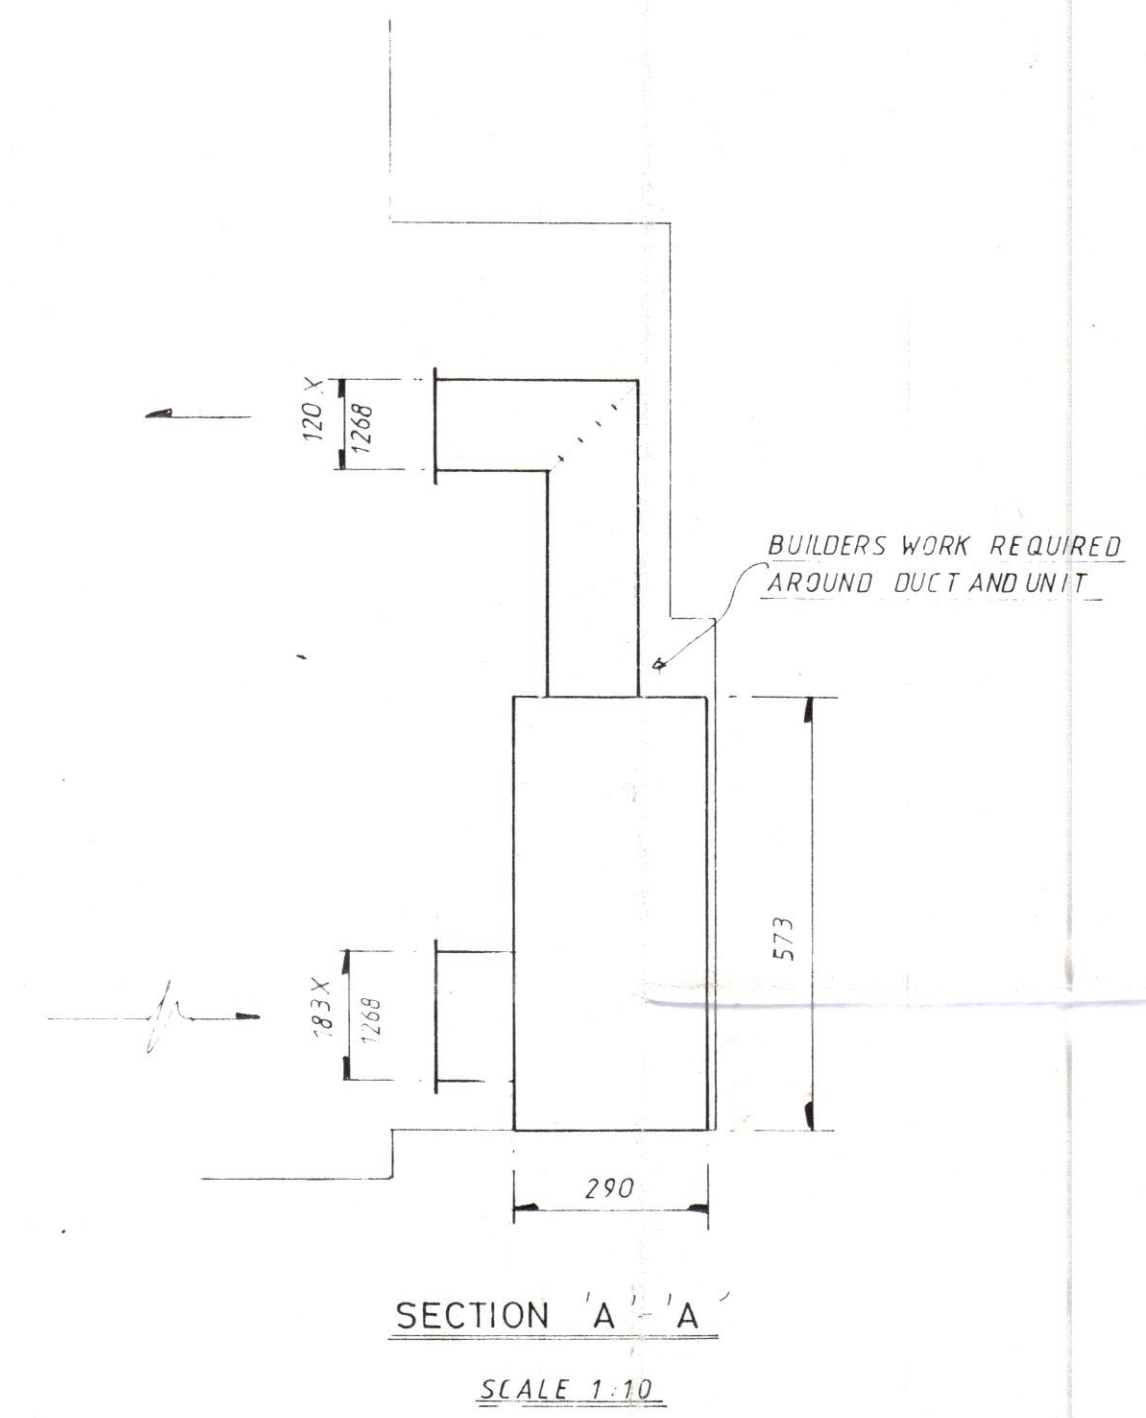


9501355

REV	INTERVIEW ROOM DELETED NEW PUBLIC SPACE A/C DUCTS	5/9/95
REV	COMMENTS	DATE
LLOYDS BANK HAMPSTEAD N.W.3.		
AIR CONDITIONING DETAIL		
OPUS AIR CONDITIONING		
SCALE 1:50	DATE JULY 95	
ATS 1237 / 1		

THE CONTRACTOR IS TO CHECK ALL DIMENSIONS ON SITE
AND TO REPORT ALL DISCREPANCIES TO THE ARCHITECT

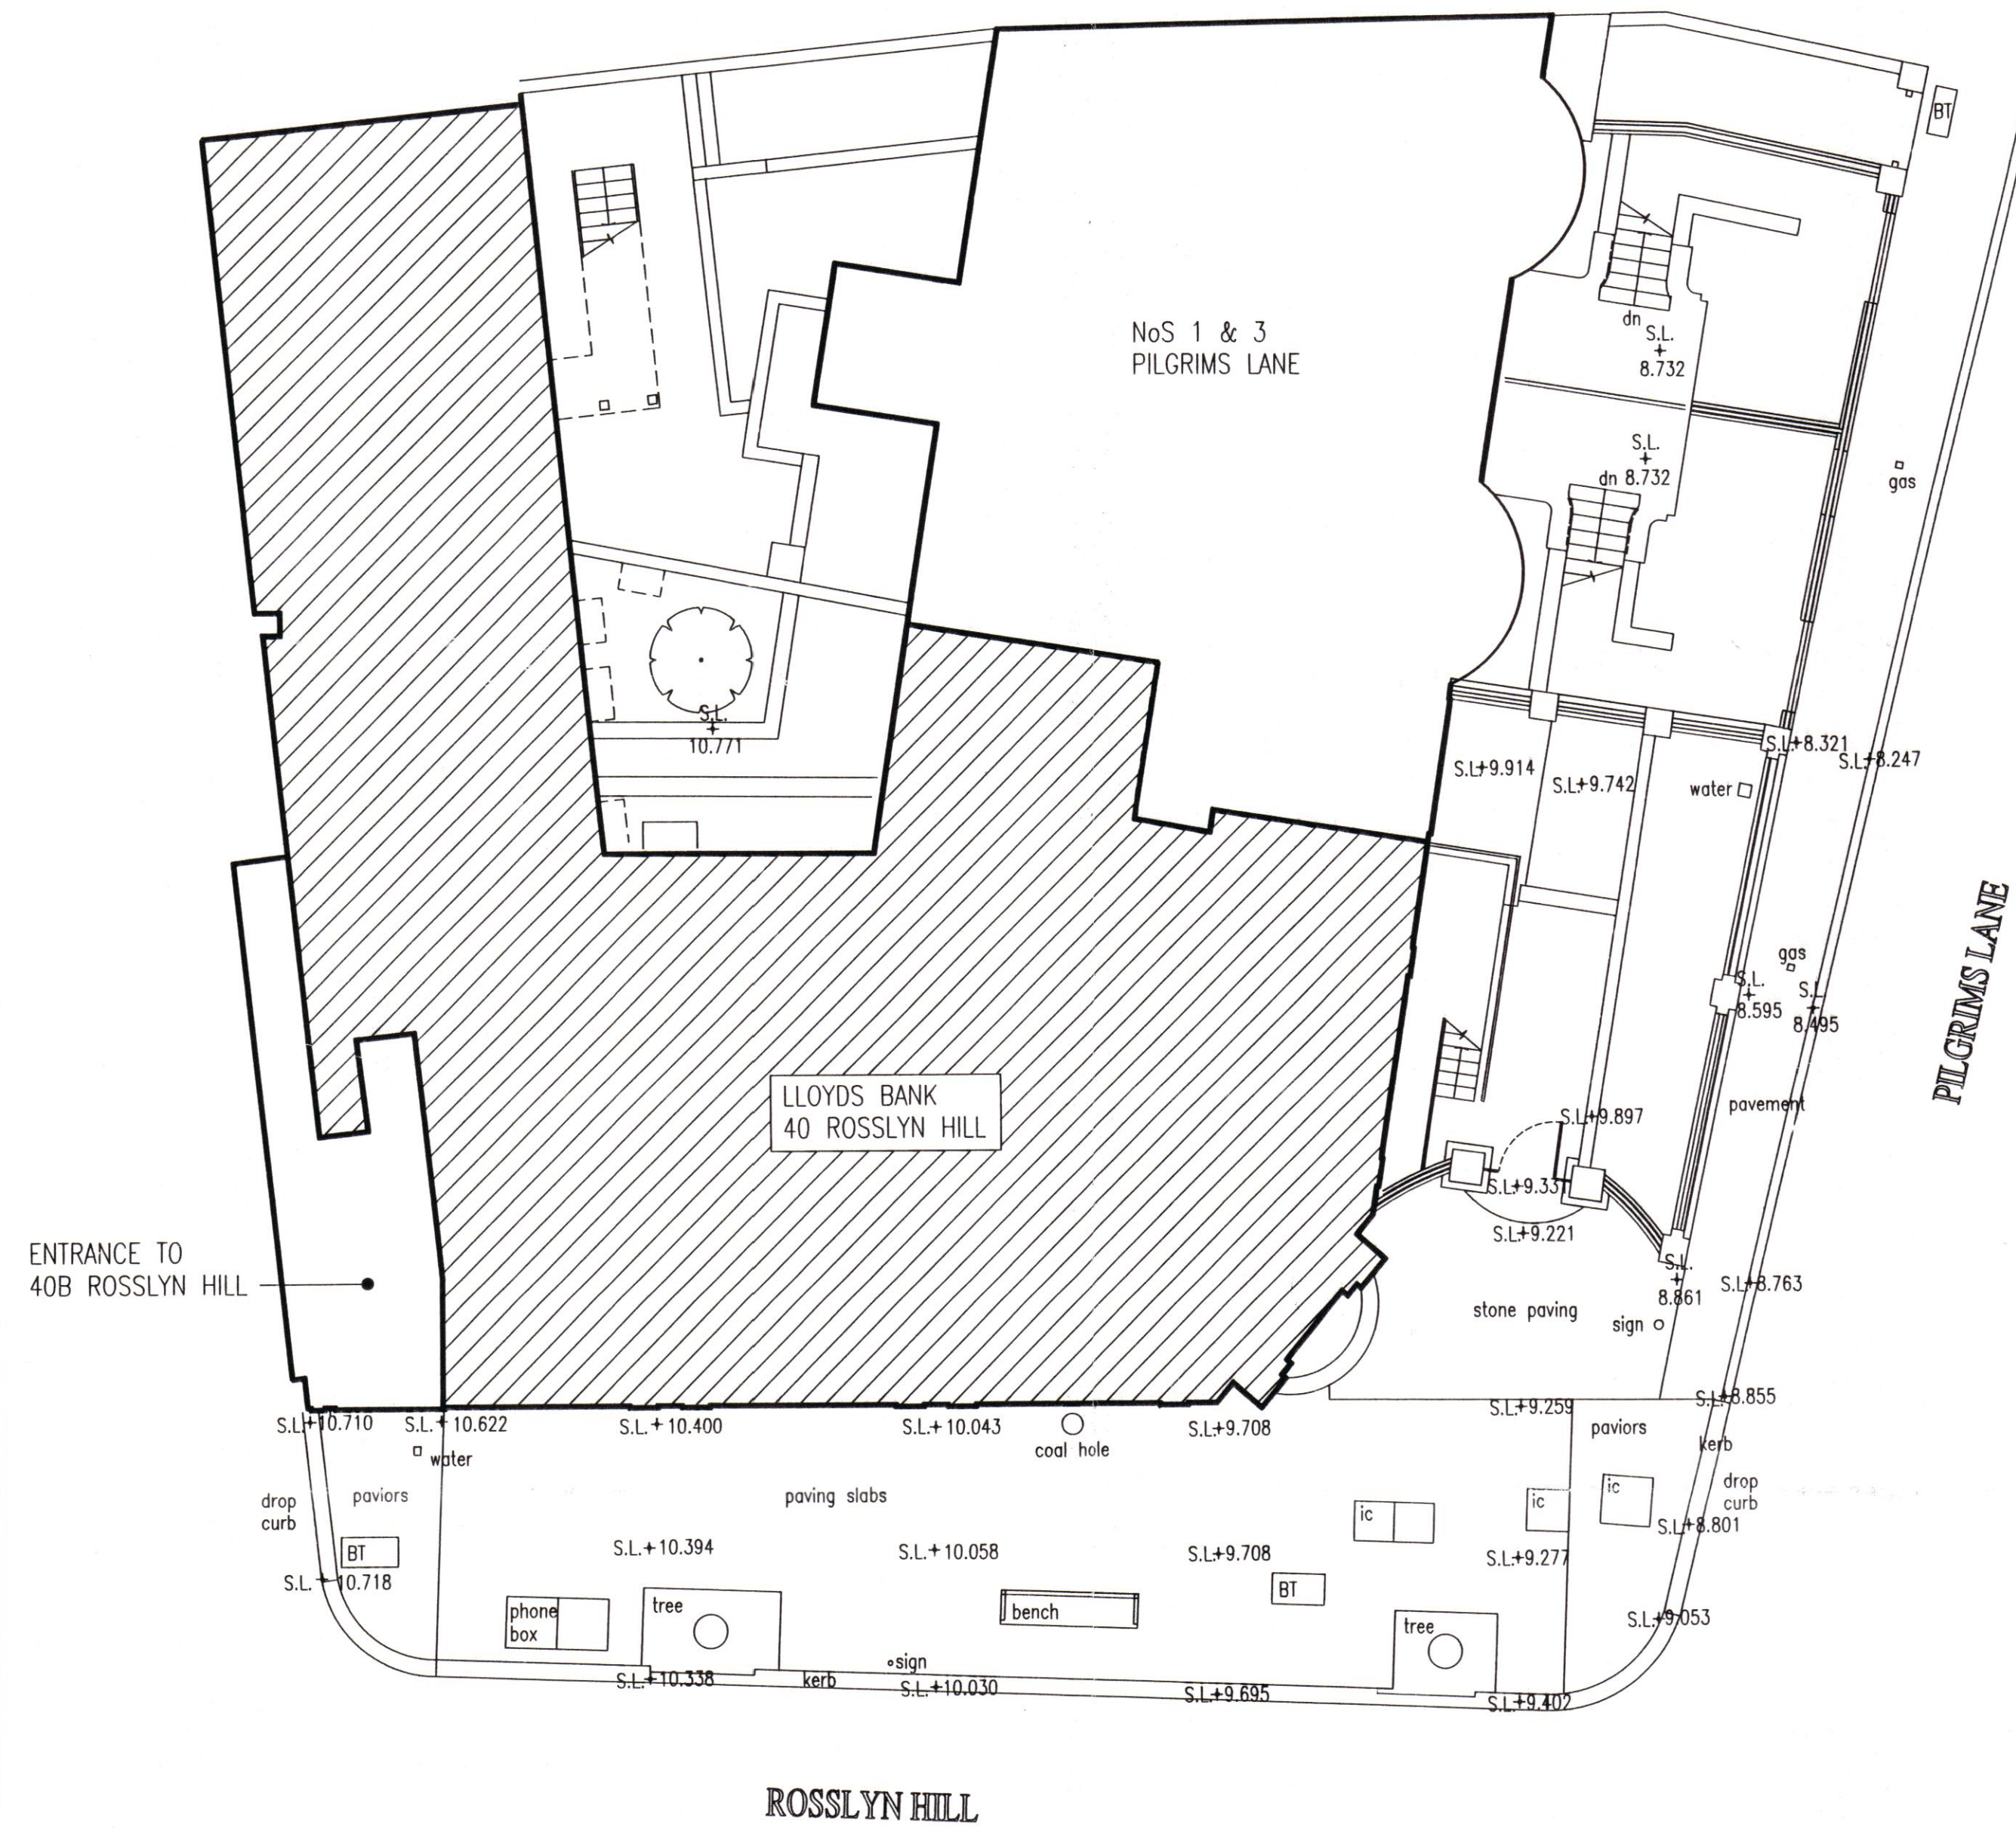

SITE PLAN SCALE 1:100

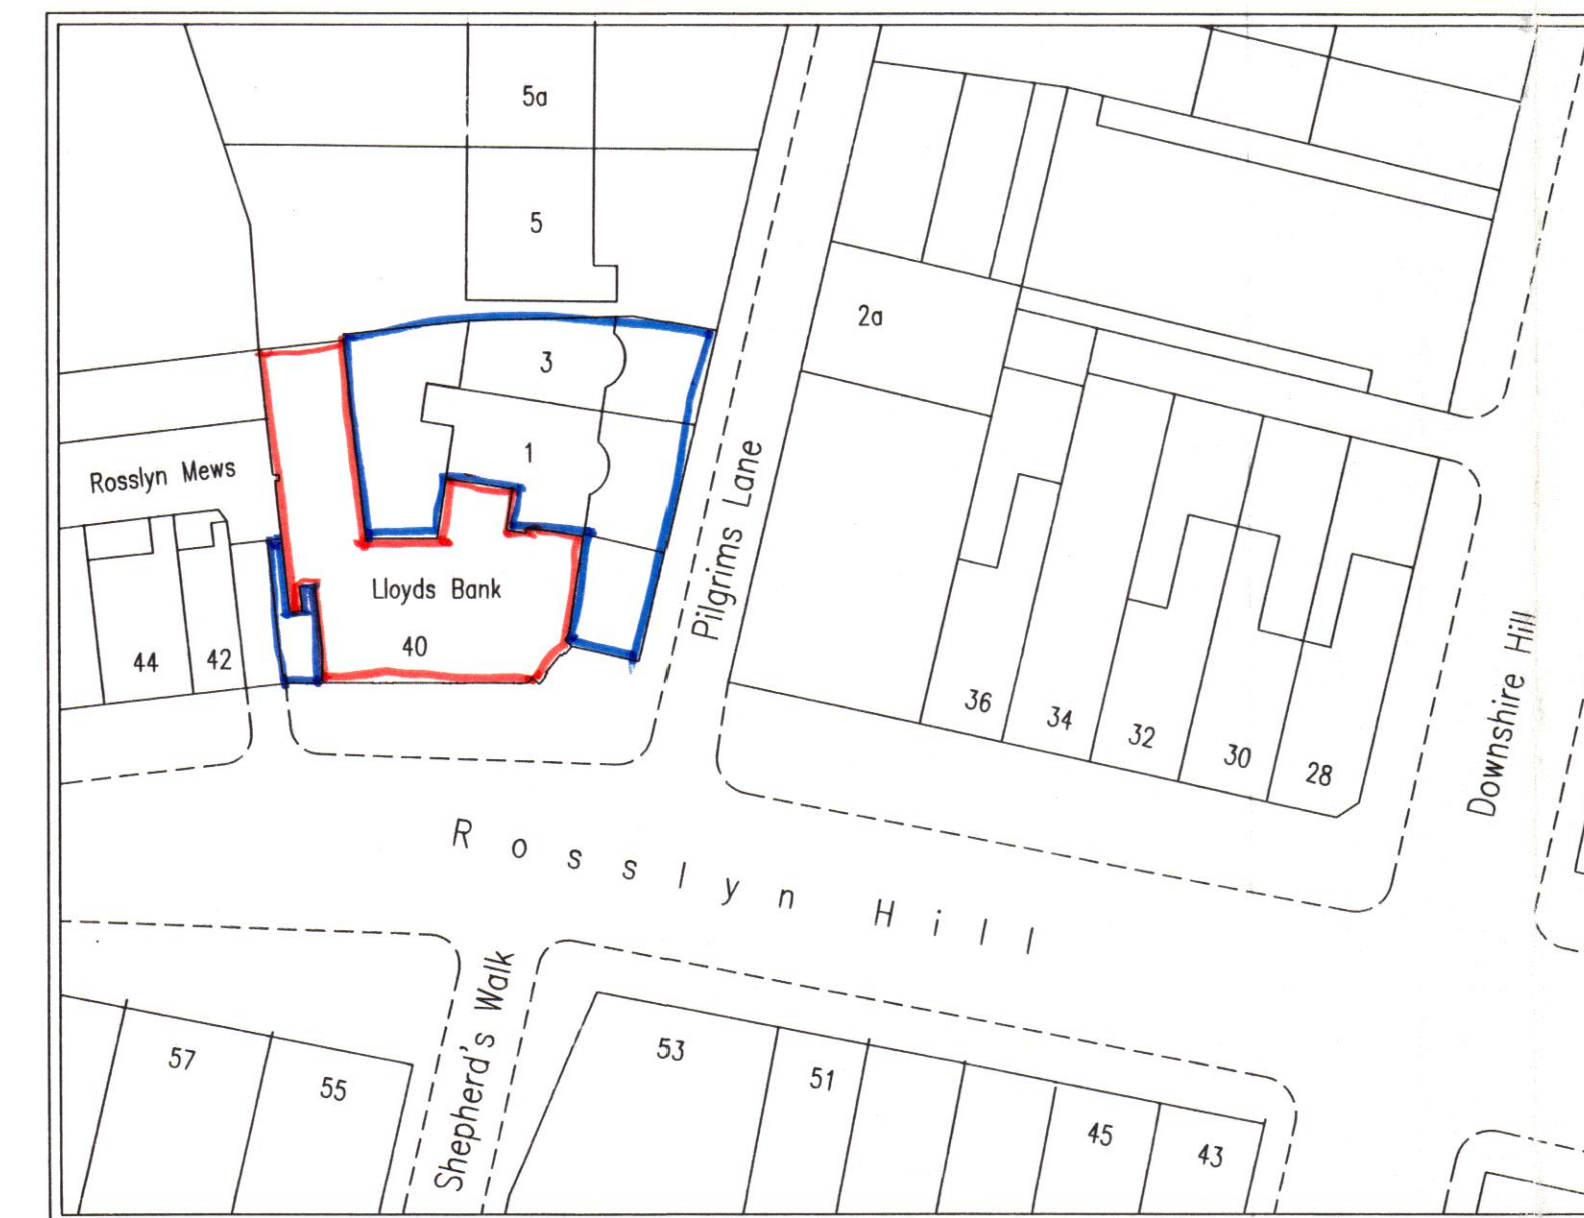

LOCATION PLAN SCALE 1:500 APPROX.

9501355

	date 29 03 95	approved
	scale 1:100	drawn AJB
	dwg no. 2053-102	

HAMPSTEAD
40 Rosslyn Hill
London NW3 1NL

Site & Location Plans

Regional Architect London
London Regional Executive Office
Lloyds Bank Plc.
Brookmount House
62-65 Chandos Place
London WC2N 4HG

TEL: 071-497 0720