


- Notes:
1. Do not scale. Dimensions govern.
  2. All dimensions are in millimeters unless noted otherwise.
  3. All dimensions to be verified on site before proceeding with the work.
  4. The designer shall be notified in writing of any discrepancies.

- GENERAL NOTES:
1. All redundant electrics (sockets, wires, lighting) to be removed
  2. CCTV locations to be reviewed
  3. WIFI network to be upgraded
  4. Smoke detectors to be reviewed

- KEY:
- WALL MOUNTED UP LIGHT
  - ◻ WALL MOUNTED DOWN LIGHT
  - PENDANT LIGHT
  - ⊙ SMOKE DETECTOR
  - ⚡ DIMMER SWITCH
  - ⚡ SWITCH
  - △ TWIN 230v SOCKET
  - △ CAT 6
  - FLOOR BOX
  - PANIC BUTTON

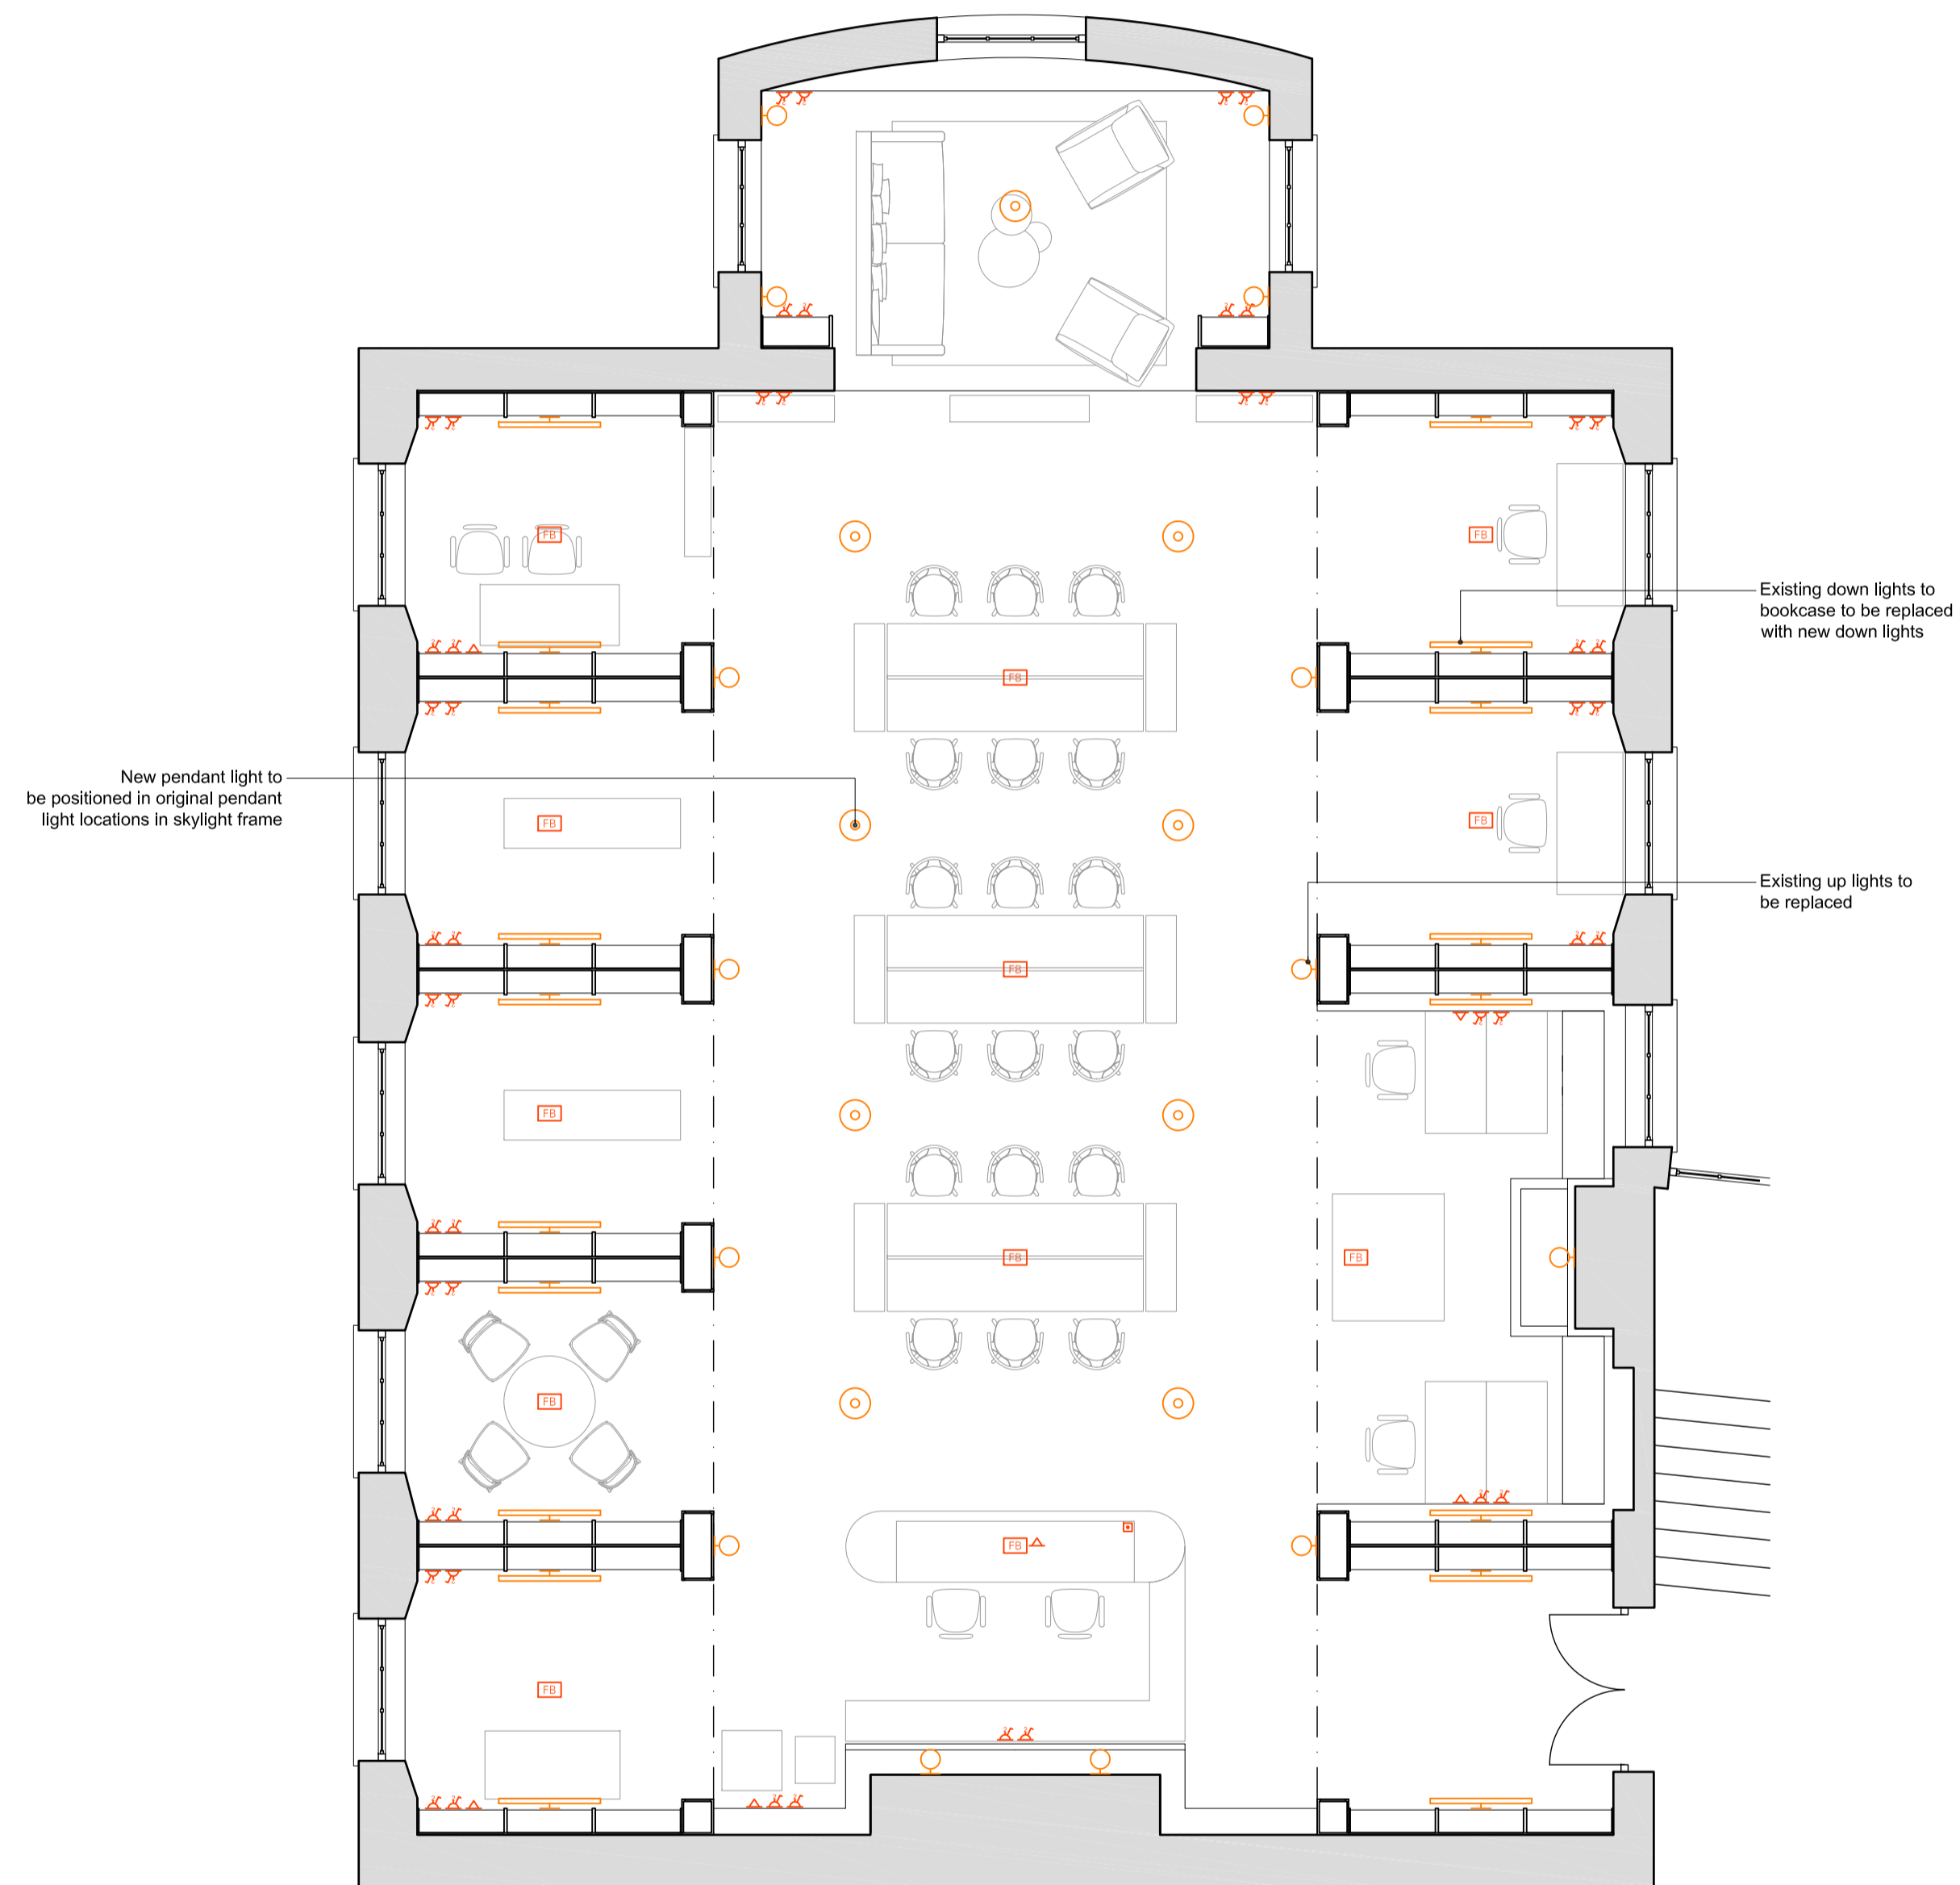

**01 SMALL POWER AND LIGHTING: PROPOSED LIBRARY PLAN**  
1.50

Rev	Date	Description	Drawn By	Checked
-	17.03.23	First Issue	SMc	MO

**Atomik Architecture**

Atomik Architecture  
41 Water Lane, London, E15 4NL  
+44 (0) 208 221 2915  
info@atomikarchitecture.com  
atomikarchitecture.com

Project		
Working Men's College Library		
Title		
Proposed Library Small Power and Lighting Plan		
Project No.	Scale	Drawing Size
0589	1 : 50	A1
	1 : 100	A3
Drawing No.	Revision	
0589 (60) 100	-	

