


NOTES

1. DO NOT SCALE FROM THIS DRAWING.
2. THE CONTRACTOR MUST VERIFY ALL DIMENSIONS, TOLERANCES AND REFERENCES BEFORE PROCEEDING WITH WORKS.
3. ANY DISCREPANCY FOUND BETWEEN THIS DRAWING AND ANY OTHER DOCUMENTS MUST BE REPORTS IMMEDIATELY TO THE CONTRACT ADMINISTRATOR.
4. REMOVE THIS DRAWING FROM CURRENCY WHEN REVISED DRAWING IS ISSUED.
5. COPYRIGHT OF DESIGNS SHOWN ON THIS DRAWING REMAINS WITH DEE SOLUTIONS LTD.
6. THIS DRAWING IS TO BE READ IN CONJUNCTION WITH THE SPECIFICATION AND ALL OTHER CONTRACT PROJECT DOCUMENTS.
7. THE CONTRACTOR SHALL REFER TO ARCHITECTS OR INTERIOR DESIGN DRAWINGS INCLUDING REFLECTED CEILING PLANS AND OTHER SPECIALIST DRAWINGS FOR SETTING OUT ALL VISIBLE WALL AND CEILING MOUNTED EQUIPMENT.
8. ALL OPEN PLAN FCU'S TO HAVE A RETURN AIR SENSOR

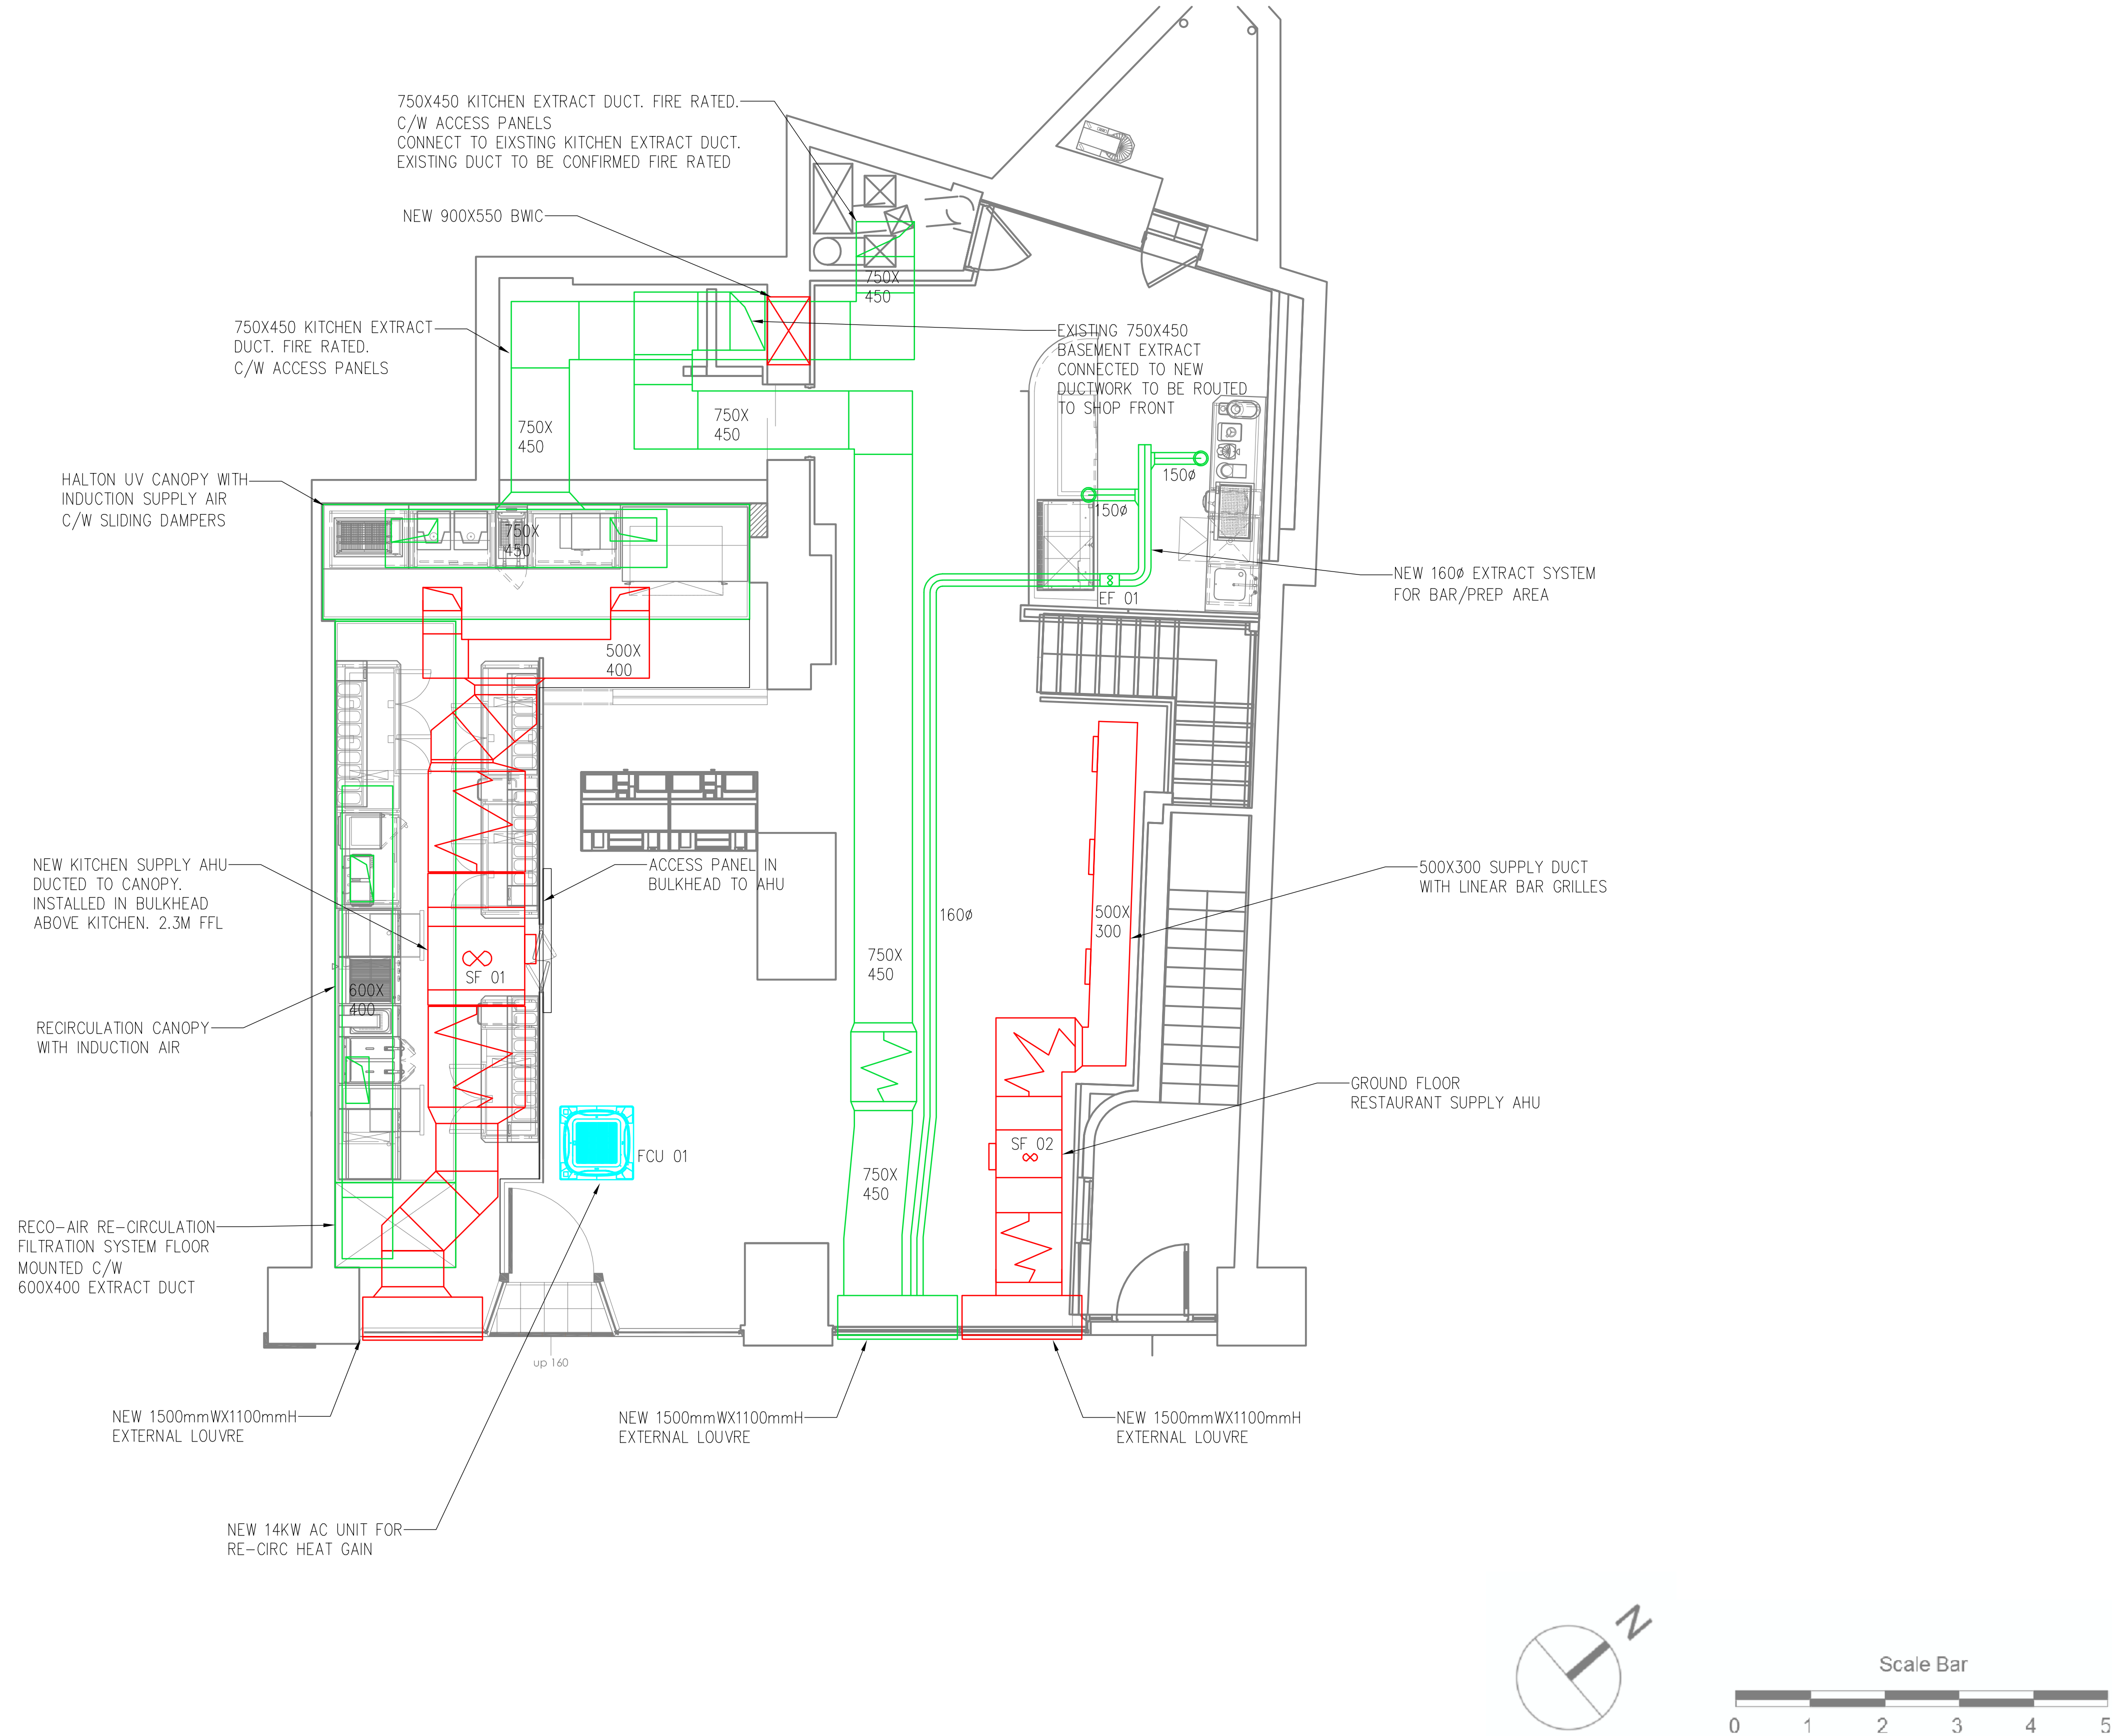

REV	DESCRIPTION	CHK	DATE
-----	-------------	-----	------

Dee Solutions

Building Services Engineers

Suite 1.16, Pure Offices  
Ferneberga House, Alexandra Road  
Farnborough  
Hampshire GU14 6DQ  
01252 757684  
admin@dee-solutions.co.uk  
www.dee-solutions.co.uk

CLIENT

PROJECT

THE SANDWICH SHOP

DRAWING TITLE  
GROUND FLOOR  
MECHANICAL SERVICES

DATE	OCT 2022	SCALE	1:50 @ A1
DRAWN BY	AD	CHECKED BY	NB
DRAWING STATUS	PRELIMINARY		

DRAWING NUMBER	REVISION
937/M/101	P1