




FIRST FLOOR

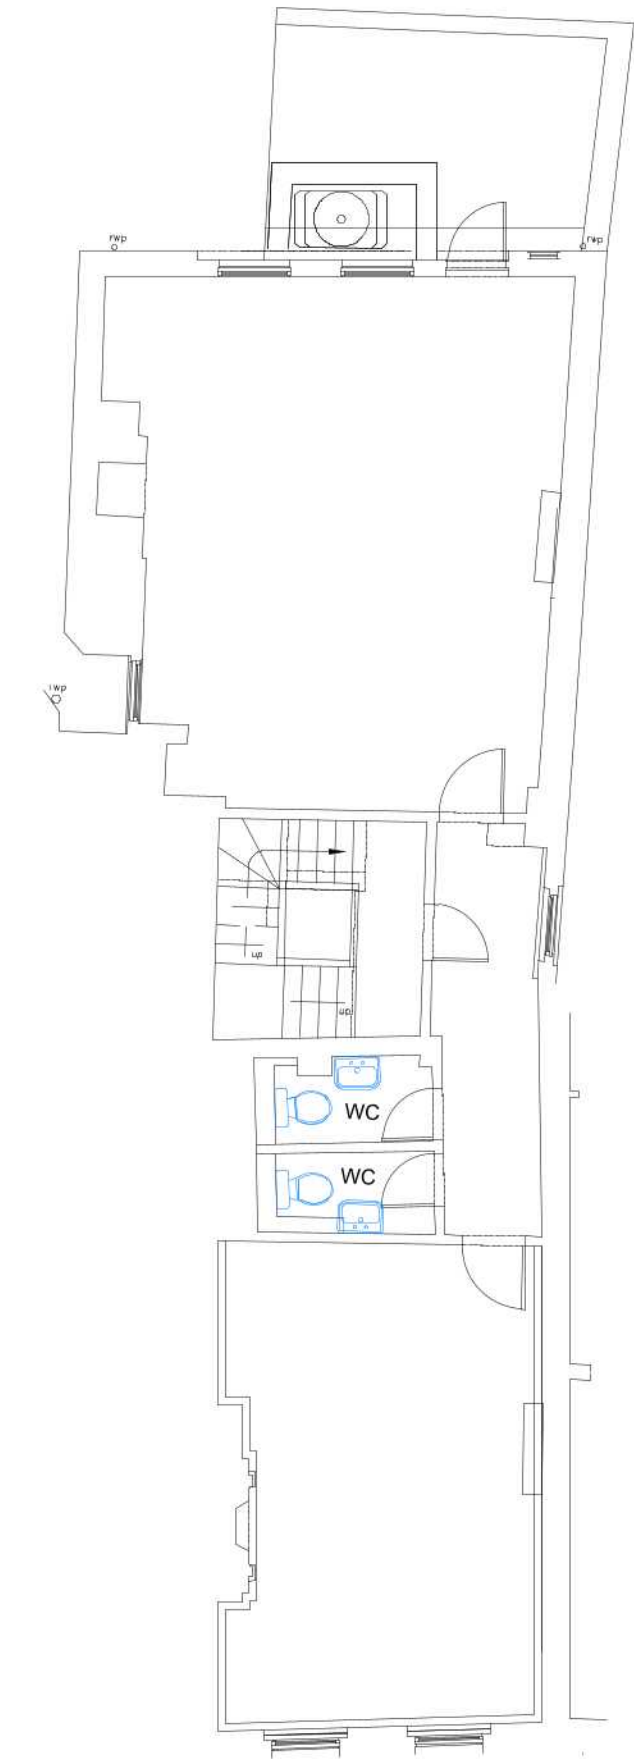

SECOND FLOOR

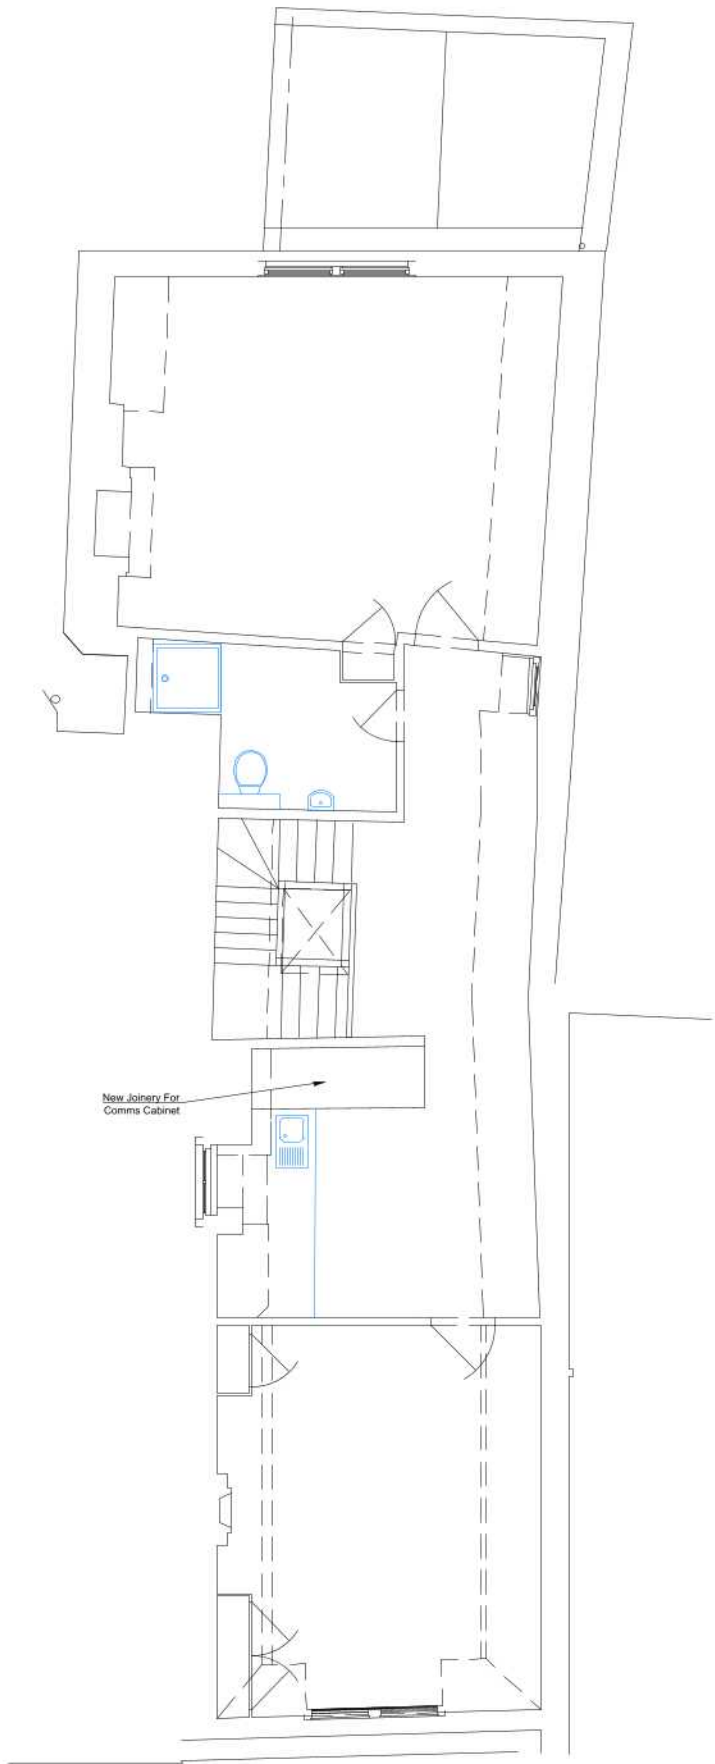

 THIRD FLOOR



NOTES

1. Do not scale. Dimensions govern.
2. All dimensions are in millimeters unless noted otherwise.
3. All dimensions to be verified on site before proceeding with the work
4. The designer shall be notified in writing of any discrepancies.

KEY

 NEW PLUMBING

WORKPAD

16 Stanhope Place, London, W2 2HH
+44 (0) 20 3929 3782
enquiries@workpad.co.uk
www.workpad.co.uk

PROJECT LOCATION

36 Great Queen Street
London
WC2B 5AA

DRAWING TITLE

First, Second & Third Floor
Plumbing Plan

PROJECT NO. WP0105	SCALE 1:100 @ A3
DRAWN BY TV	CHECKED BY EM
DATE 18-08-22	REVISION -