
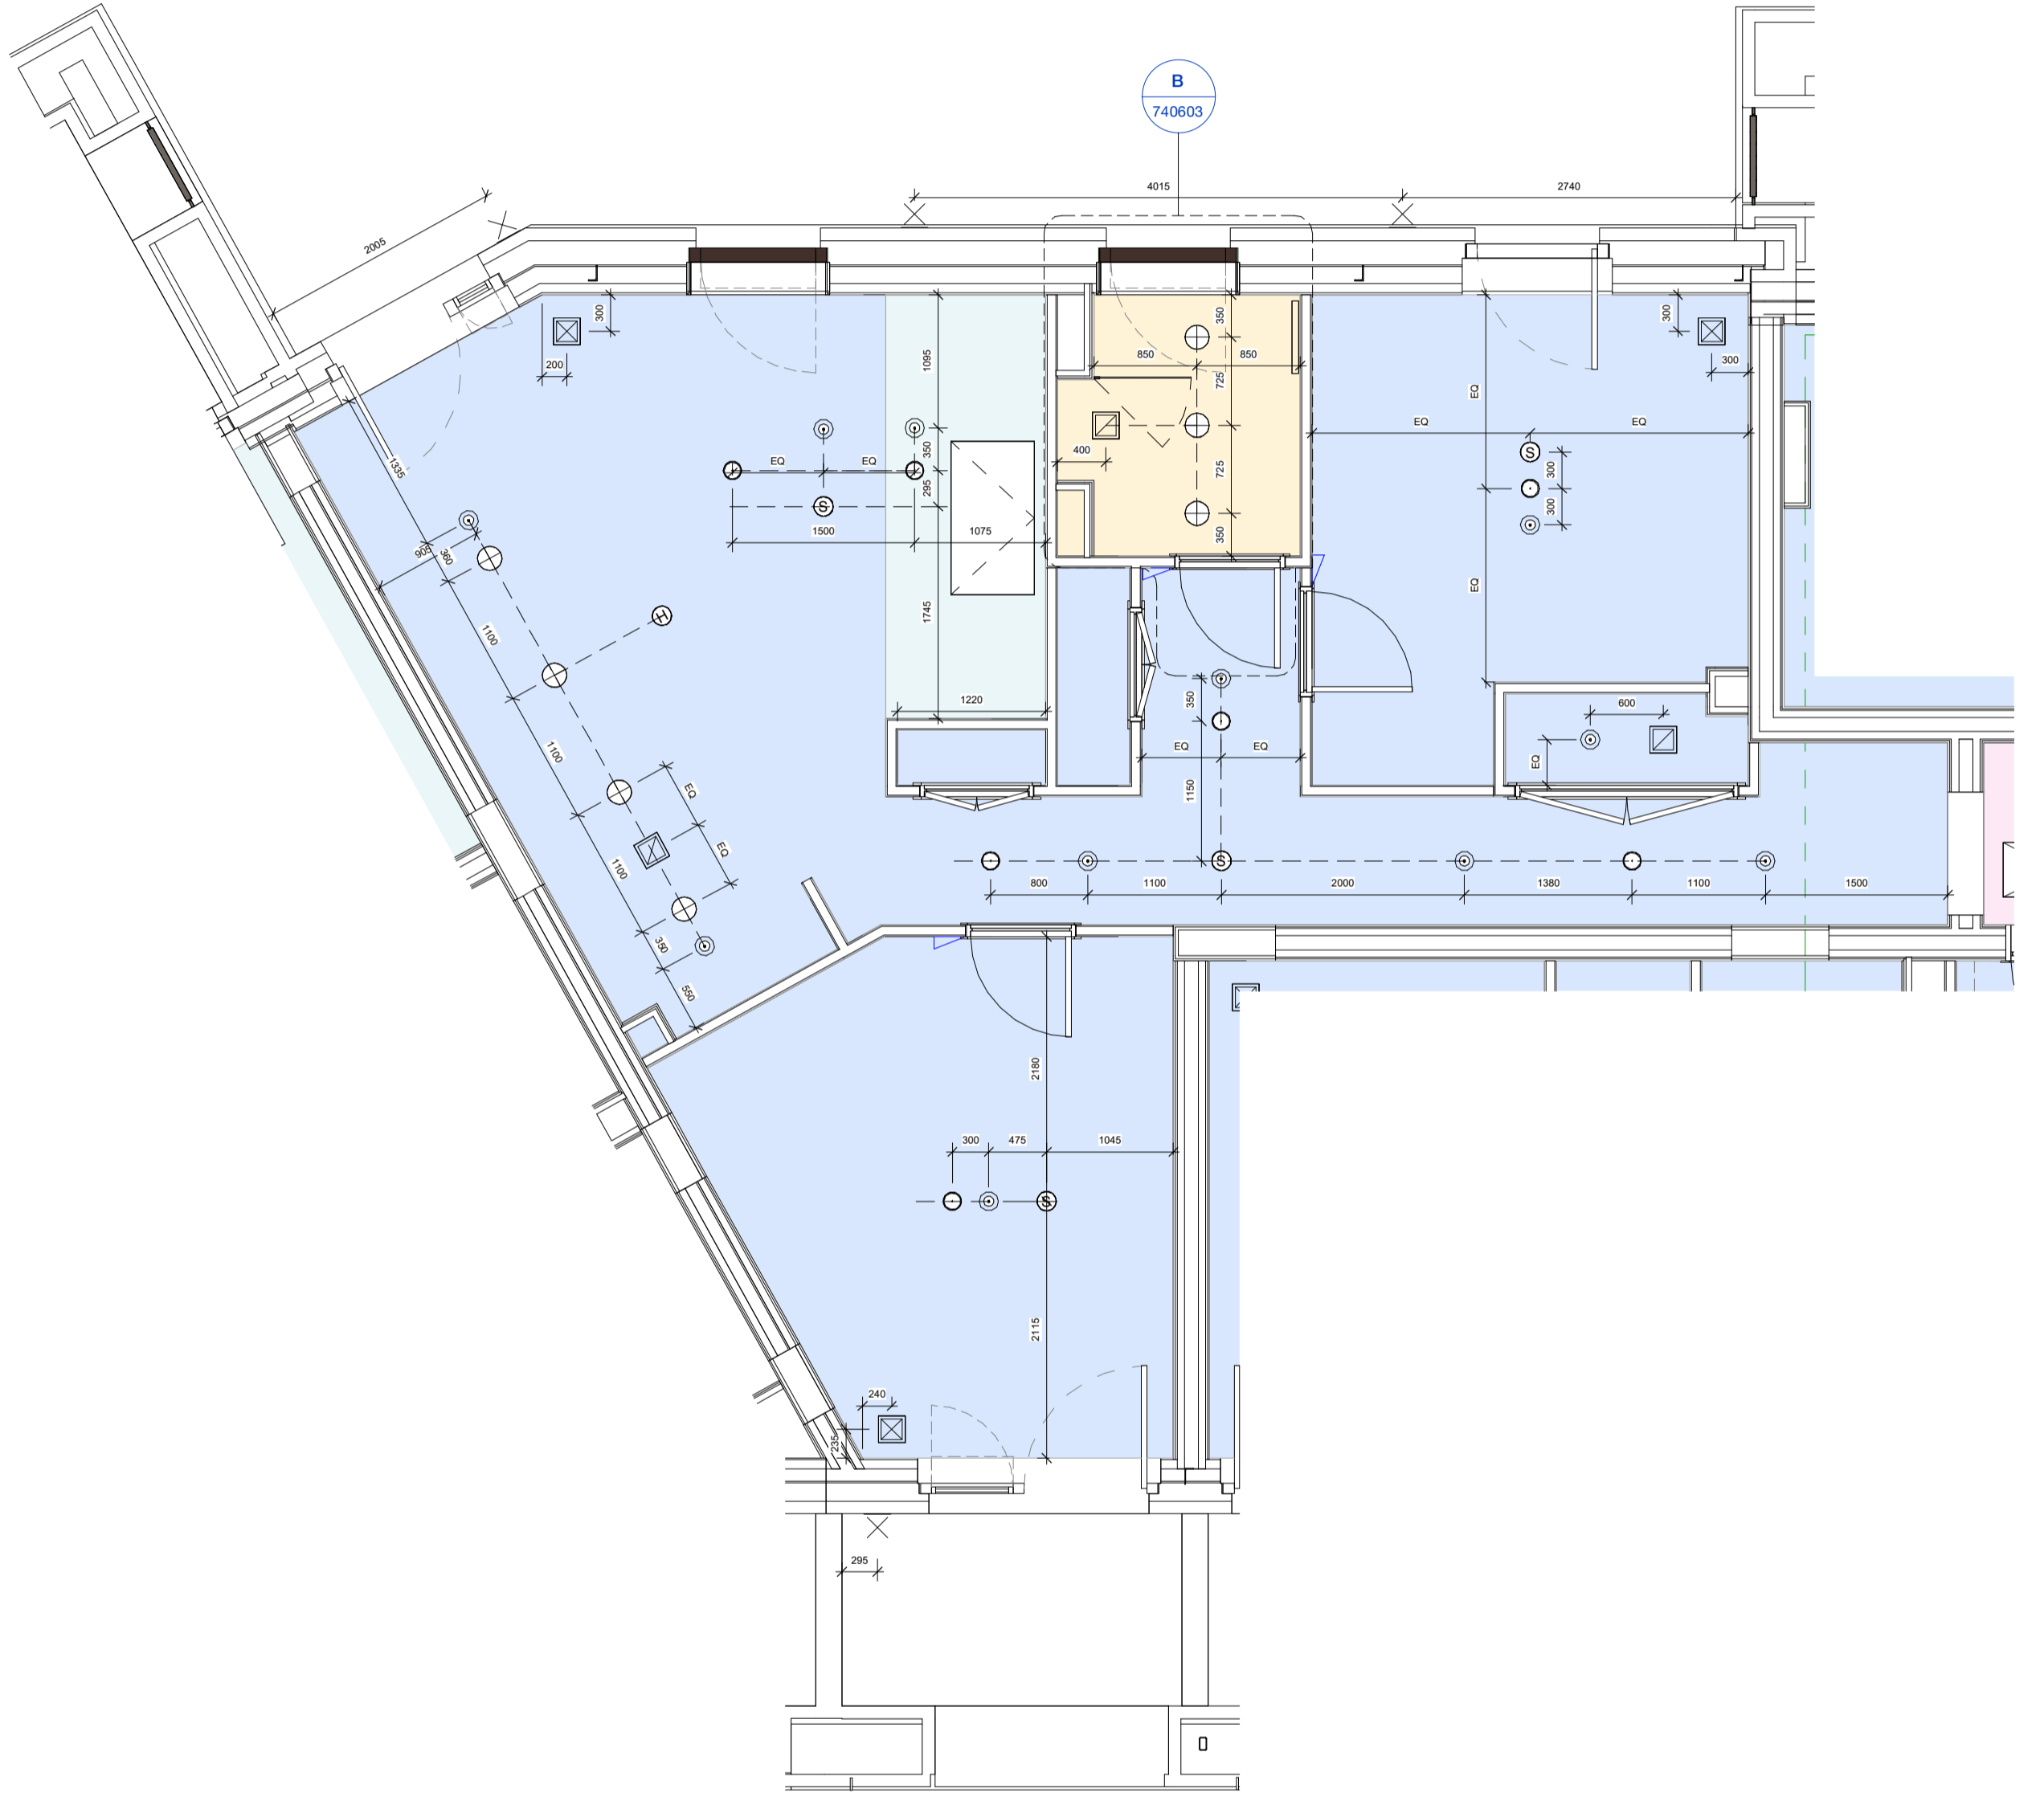


Copyright Hawkins\Brown Architects
 No implied licence exists. This drawing should not be used to calculate areas for the purposes of valuation. Do not scale this drawing. All dimensions to be checked on the site by the contractor and such dimensions to be their responsibility. All work must comply with relevant British Standards and Building Regulations requirements. Drawing errors and omissions to be reported to the architect. To be read in conjunction with Architect's specification and other consultant information.

Rev	Description	Date
P1	Issued for Coordination	23/04/21
P2	Issued for Approval	06/09/21
P3	Issued for Coordination	21/12/21
P4	Comments on Unit Types Coordination	04/03/22
P5	Unit Types Coordination	14/04/22
P6	Updated following Contractor Review	27/06/22
P7	Updated following Contractor Review	22/08/22
P8	Utility cupboard door width updated	19/10/22
P9	Updated to MF comments	13/12/22
P10	Updated to Contractor's comment (RFI 471)	23/03/23

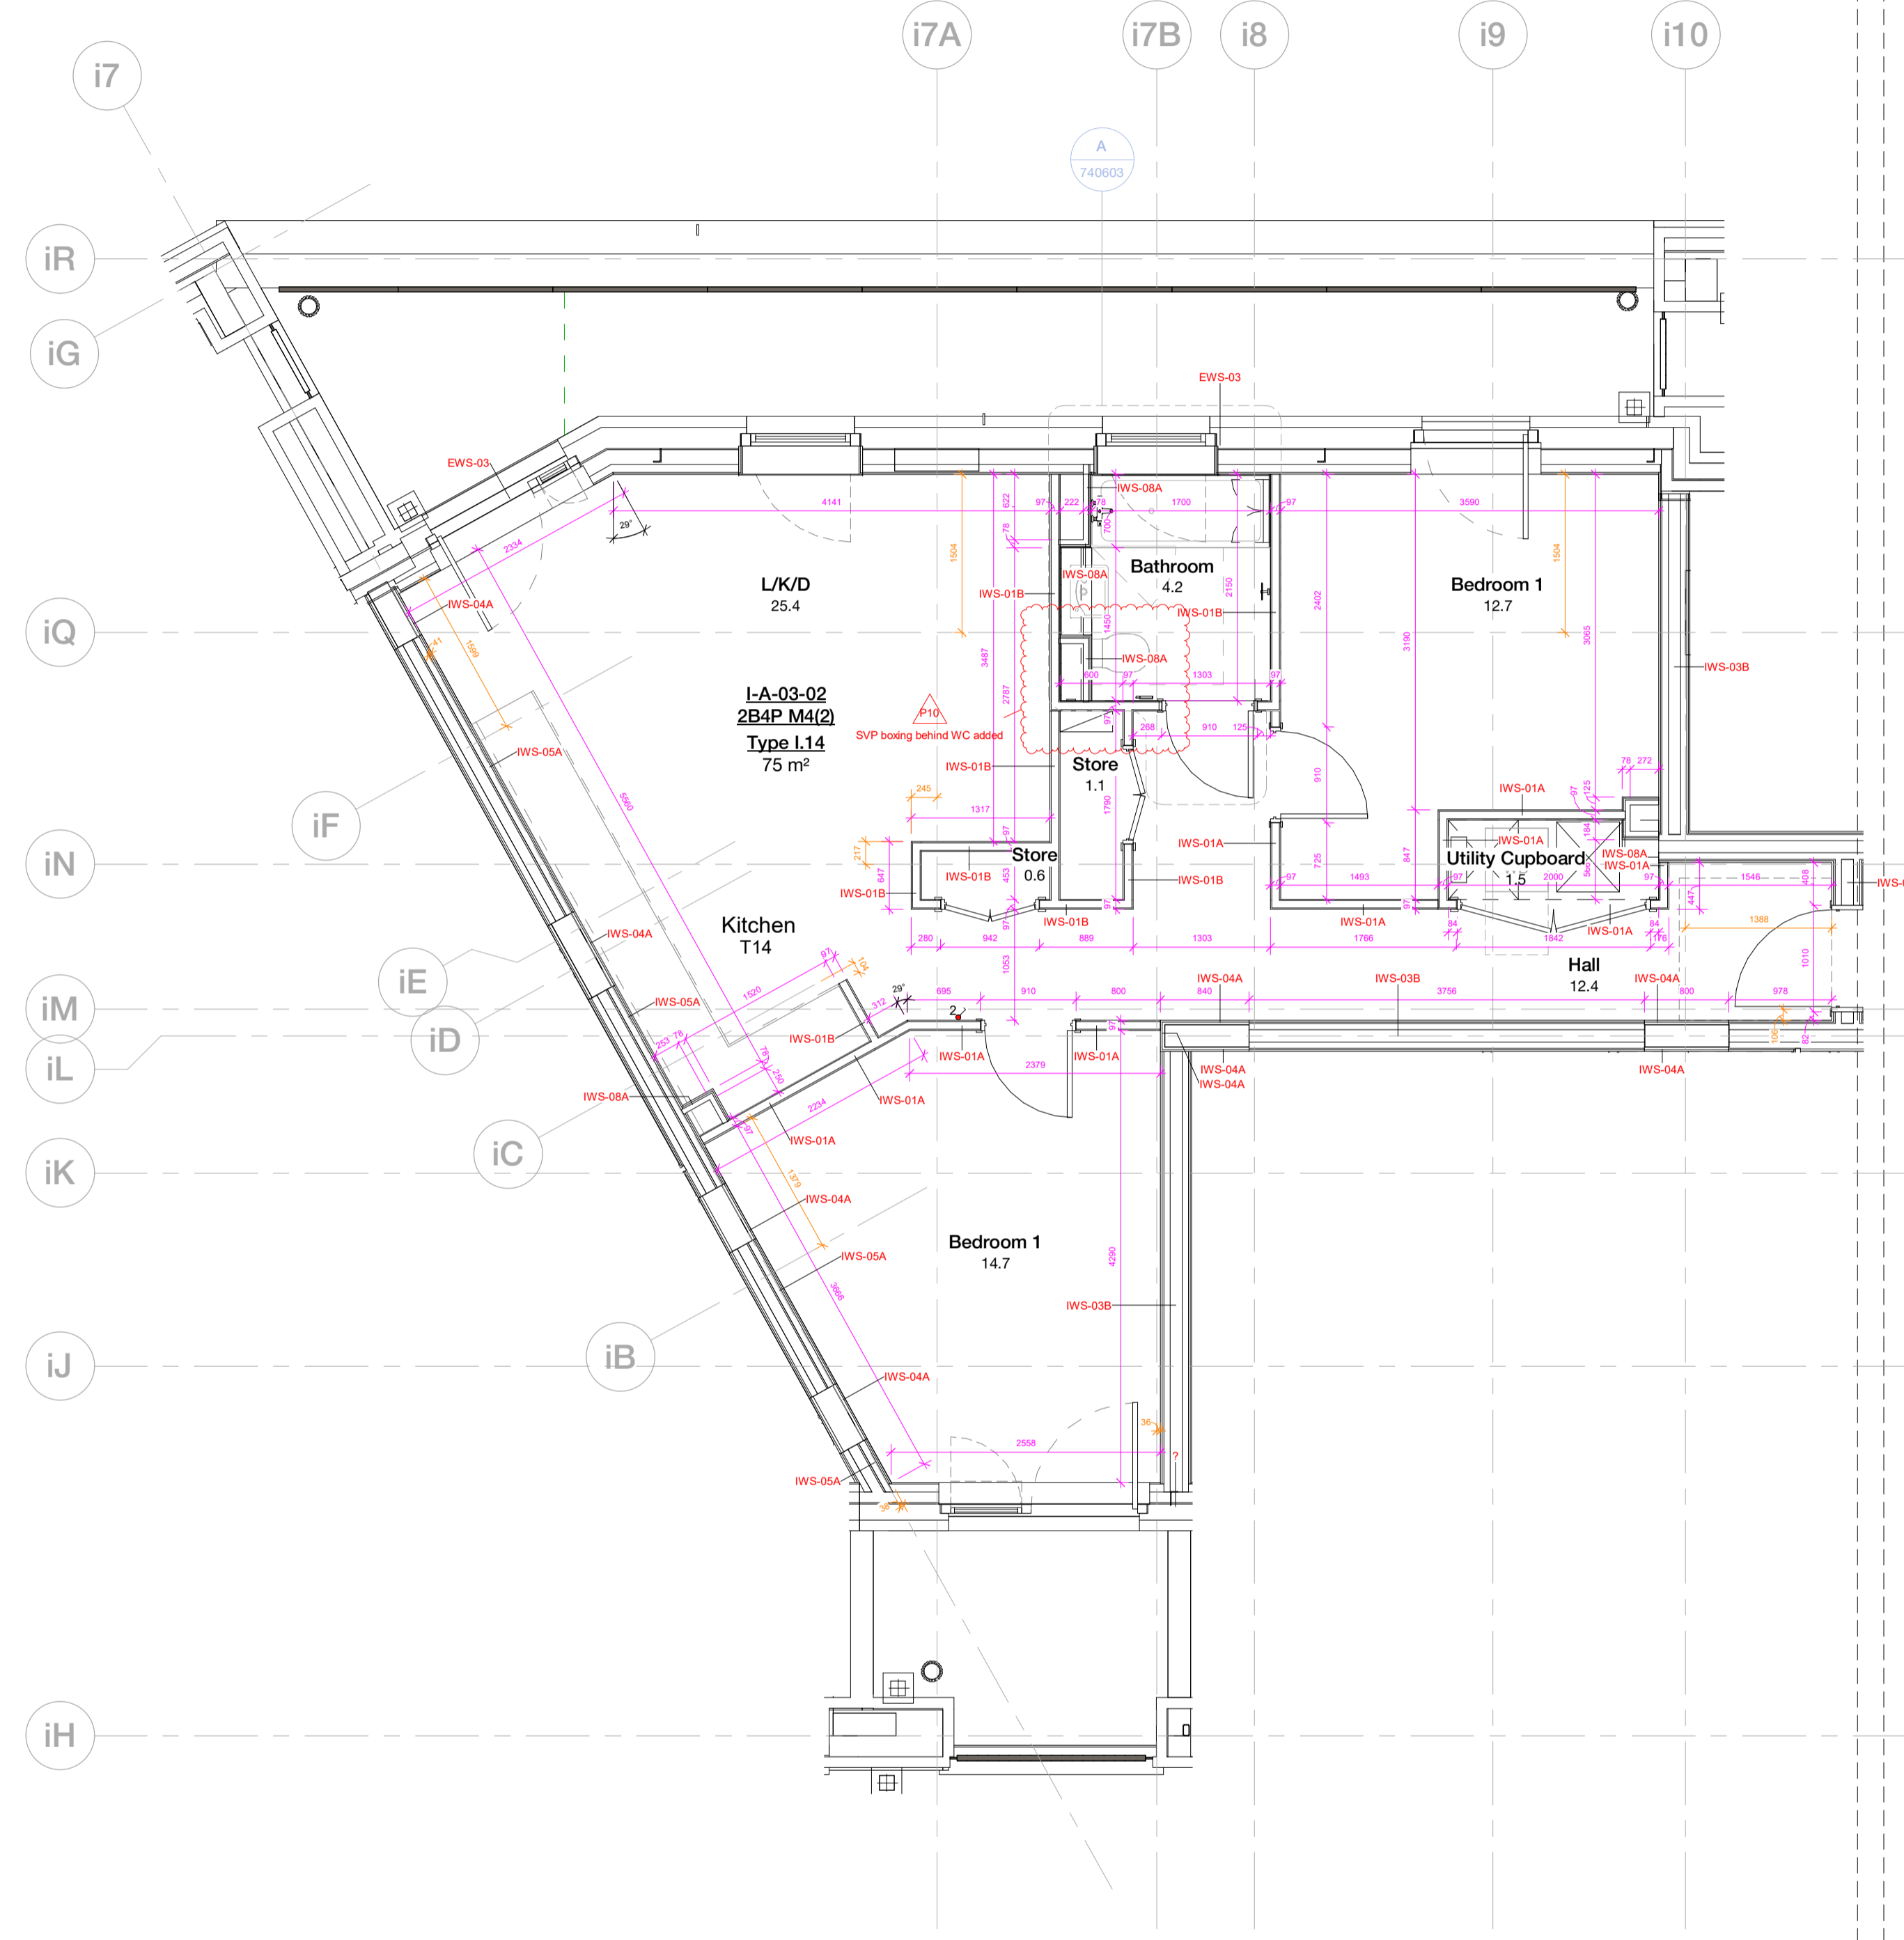


1 Internal Wall Setting Out
 1 : 50

2 Reflected Ceiling Plan
 1 : 50

Key		Note	
⊕	Downlight	Plasterboard - Dwelling	Refer to 35 Series for apartment ceiling details. Service voids and penetrations to be confirmed.
⊙	Pendant Light	Plasterboard - Bulkhead	Switches to lighting work in progress.
⊗	Mechanical Extract	Plasterboard - Bathrooms	Sprinklers required to all units in line with BS standard BS9251-2014. Number and setting out of heads to be reviewed and confirmed by specialist.
⊗	Mechanical Supply	Aluminium - Slatelams	
⊗	Recessed Curtain Track	MVHR Access Panel	
⊗	Heat Detector		
⊗	Smoke Detector		
⊗	Sprinkler Head		
⊗	External Wall Light		
⊗	External Downlight		

Unit Types - Block 1				
Name	Unit Type	Tenure	Count	
Duplex Type 1.01	3B5P M4(3)(2)(b) Duplex	SR	1	
Duplex Type 1.02	2B4P M4(2) Duplex	INT	1	
Duplex Type 1.03	2B4P M4(2) Duplex	INT	1	
Type 1.01	1B2P M4(3)(2)(b)	SR	1	
Type 1.02	1B2P M4(3)(2)(b)	SR	1	
Type 1.03	1B2P M4(2)	SR	1	
Type 1.04	1B2P M4(2)	SR	1	
Type 1.05	2B3P M4(2)	INT	5	
Type 1.06	1B3P M4(2)	INT	3	
Type 1.07	2B4P M4(2)	INT	2	
Type 1.08	1B2P M4(2)	INT	2	
Type 1.09	1B2P M4(2)	INT	2	
Type 1.10	2B3P M4(2)	INT	2	
Type 1.10 A	2B3P M4(2)	INT	1	
Type 1.10 B	2B3P M4(2)	INT	1	
Type 1.11	1B2P M4(2)	INT	2	
Type 1.12	1B2P M4(2)	INT	4	
Type 1.13	1B1P M4(2)	INT	1	
Type 1.14	2B4P M4(2)	INT	1	
Type 1.15	1B2P M4(2)	INT	1	
Type 1.16	1B2P M4(2)	INT	1	
Type 1.16 B	1B3P M4(2)	INT	1	
Type 1.17	1B2P M4(2)	INT	2	
Type 1.18	1B2P M4(2)	INT	2	
Unit Type 12	Terrace		1	
Grand total:			41	

Gridline i11x is Gridline i11 on Structural engineers plans.

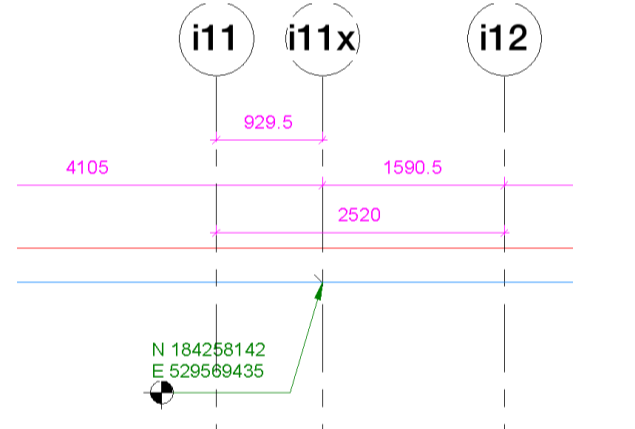

159 St John Street
 London EC1V 4QJ
 mail@hawkinsbrown.com
 hawkinsbrown.com

Hawkins\Brown

Project
 Agar Grove Phase 1c
 Block 1

Drawing
 Unit Type 14 1/2

Scale @ A1
 As indicated

Date
 Sept 2021

Drawn By
 CM

Checked By
 JW

Job Number
 1423-C

Status
 S1

Purpose of Issue
 Coordination

Drawing No.
 AGV-HBA-I-ZZ-DR-A-200414

Rev
 P10