


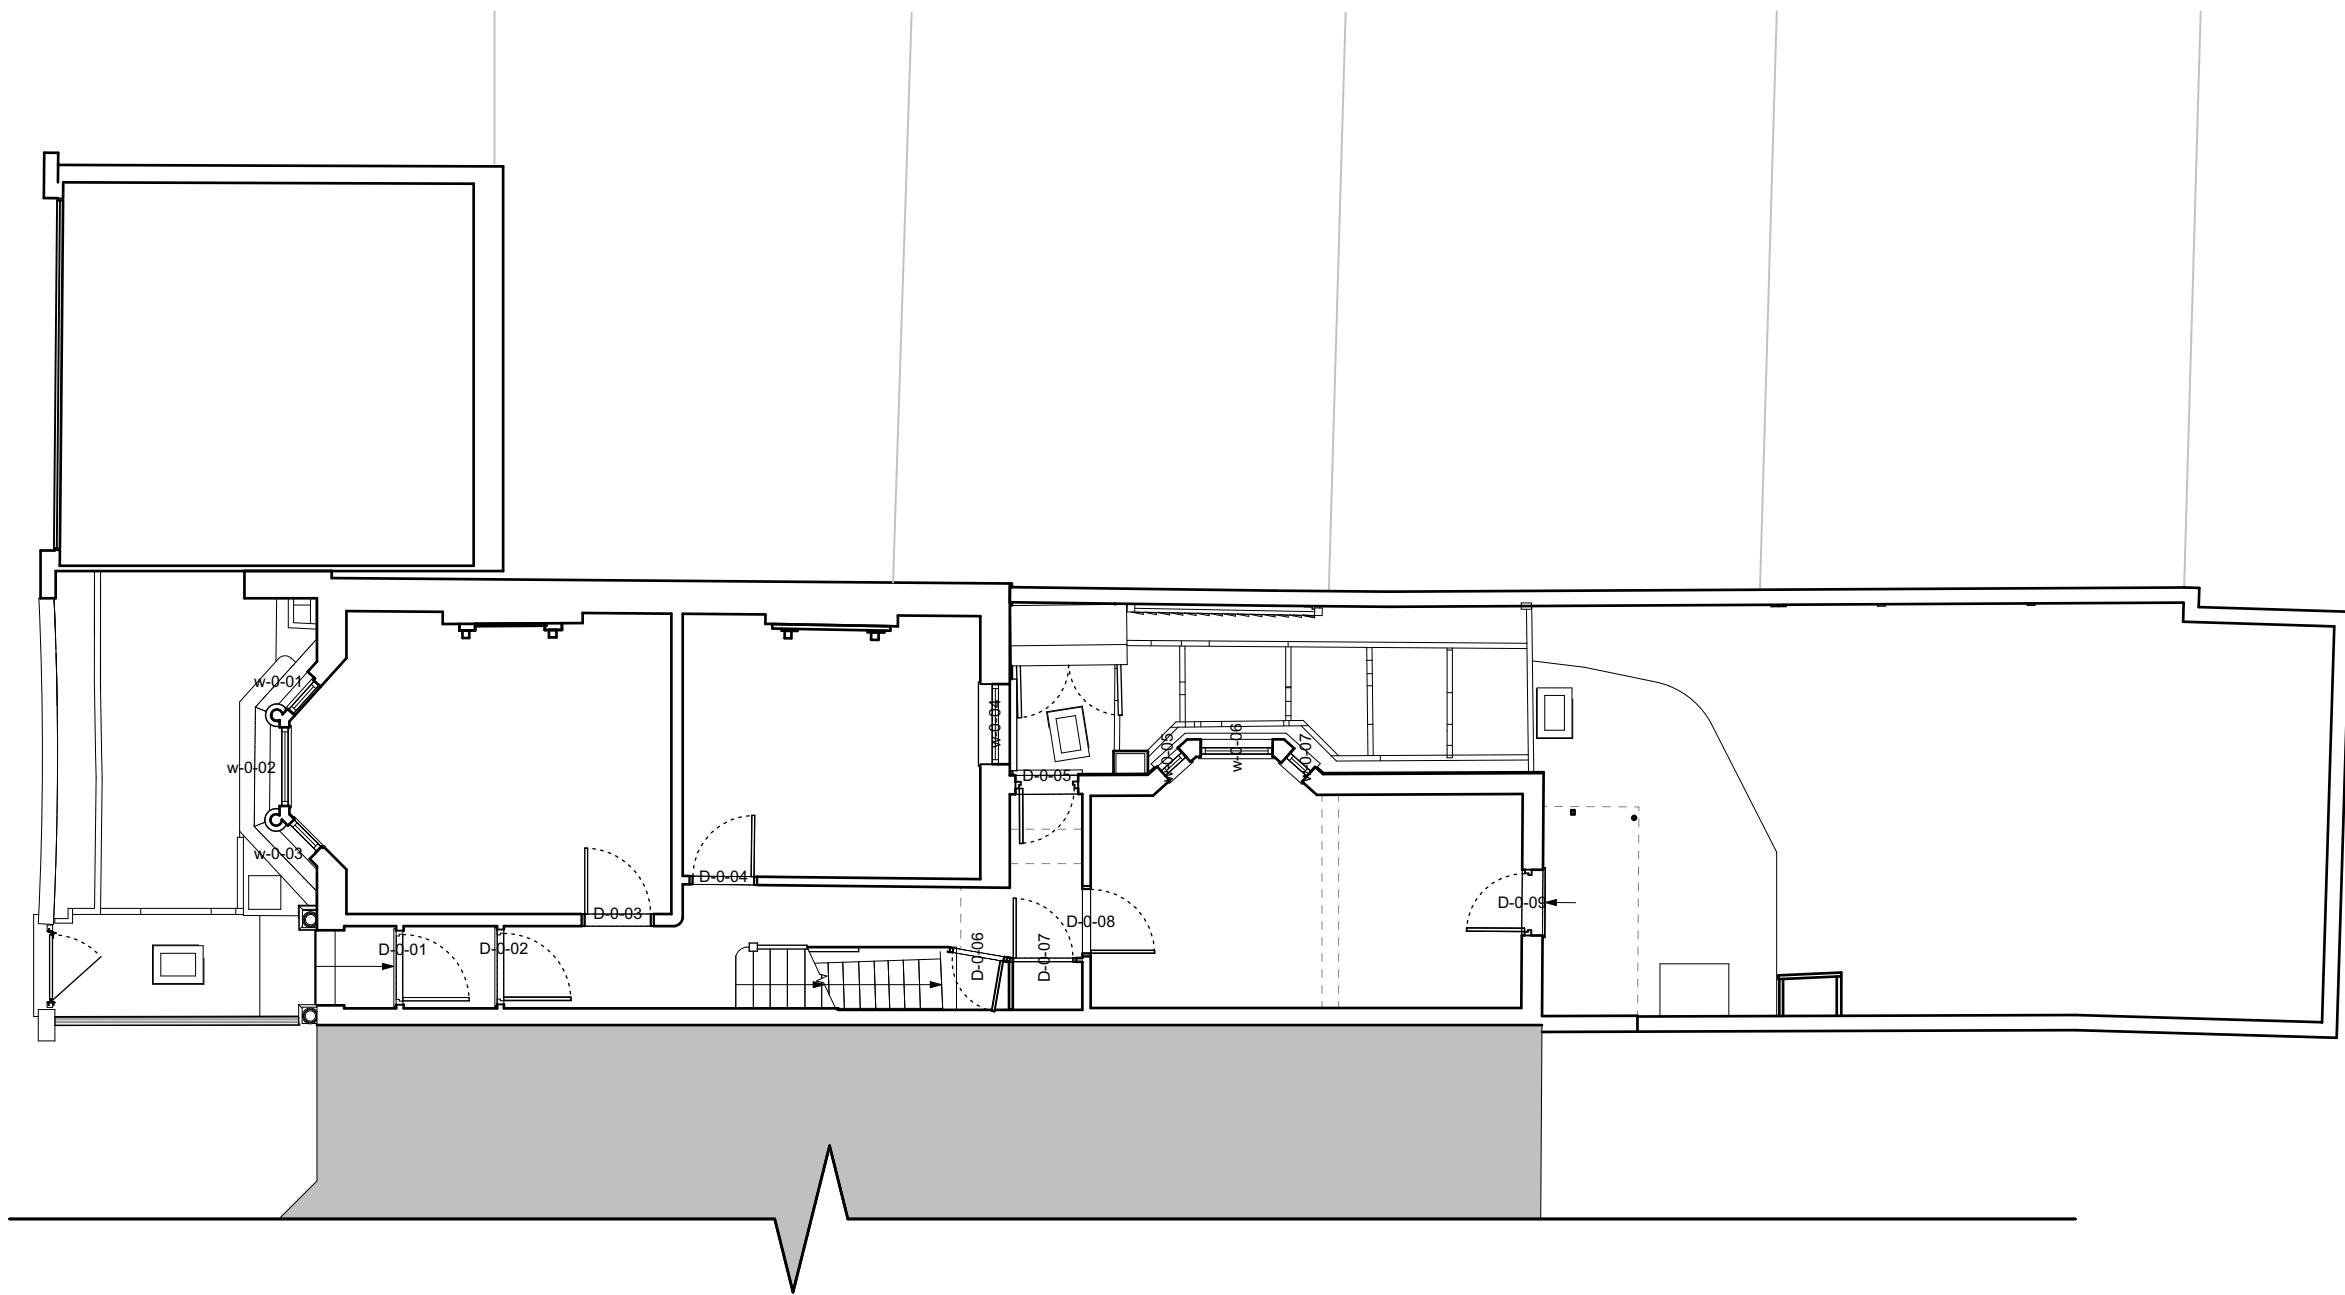

Existing Ground Floor Plan

Courthope House

Drawn By WM
Scale 1:100
Status Issue
Project Stage Survey

Paul Archer Design Ltd



Issue	Notes	Date
-------	-------	------


Unit D204 Lana House	116 Commercial Street	London	E1 6NF	Tel. 020 3668 2668
----------------------	-----------------------	--------	--------	--------------------

916.002

paul archer
design

www.paularcherdesign.co.uk

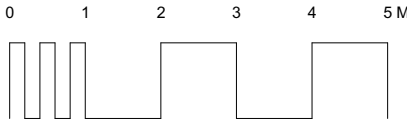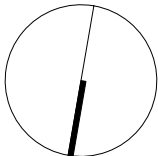

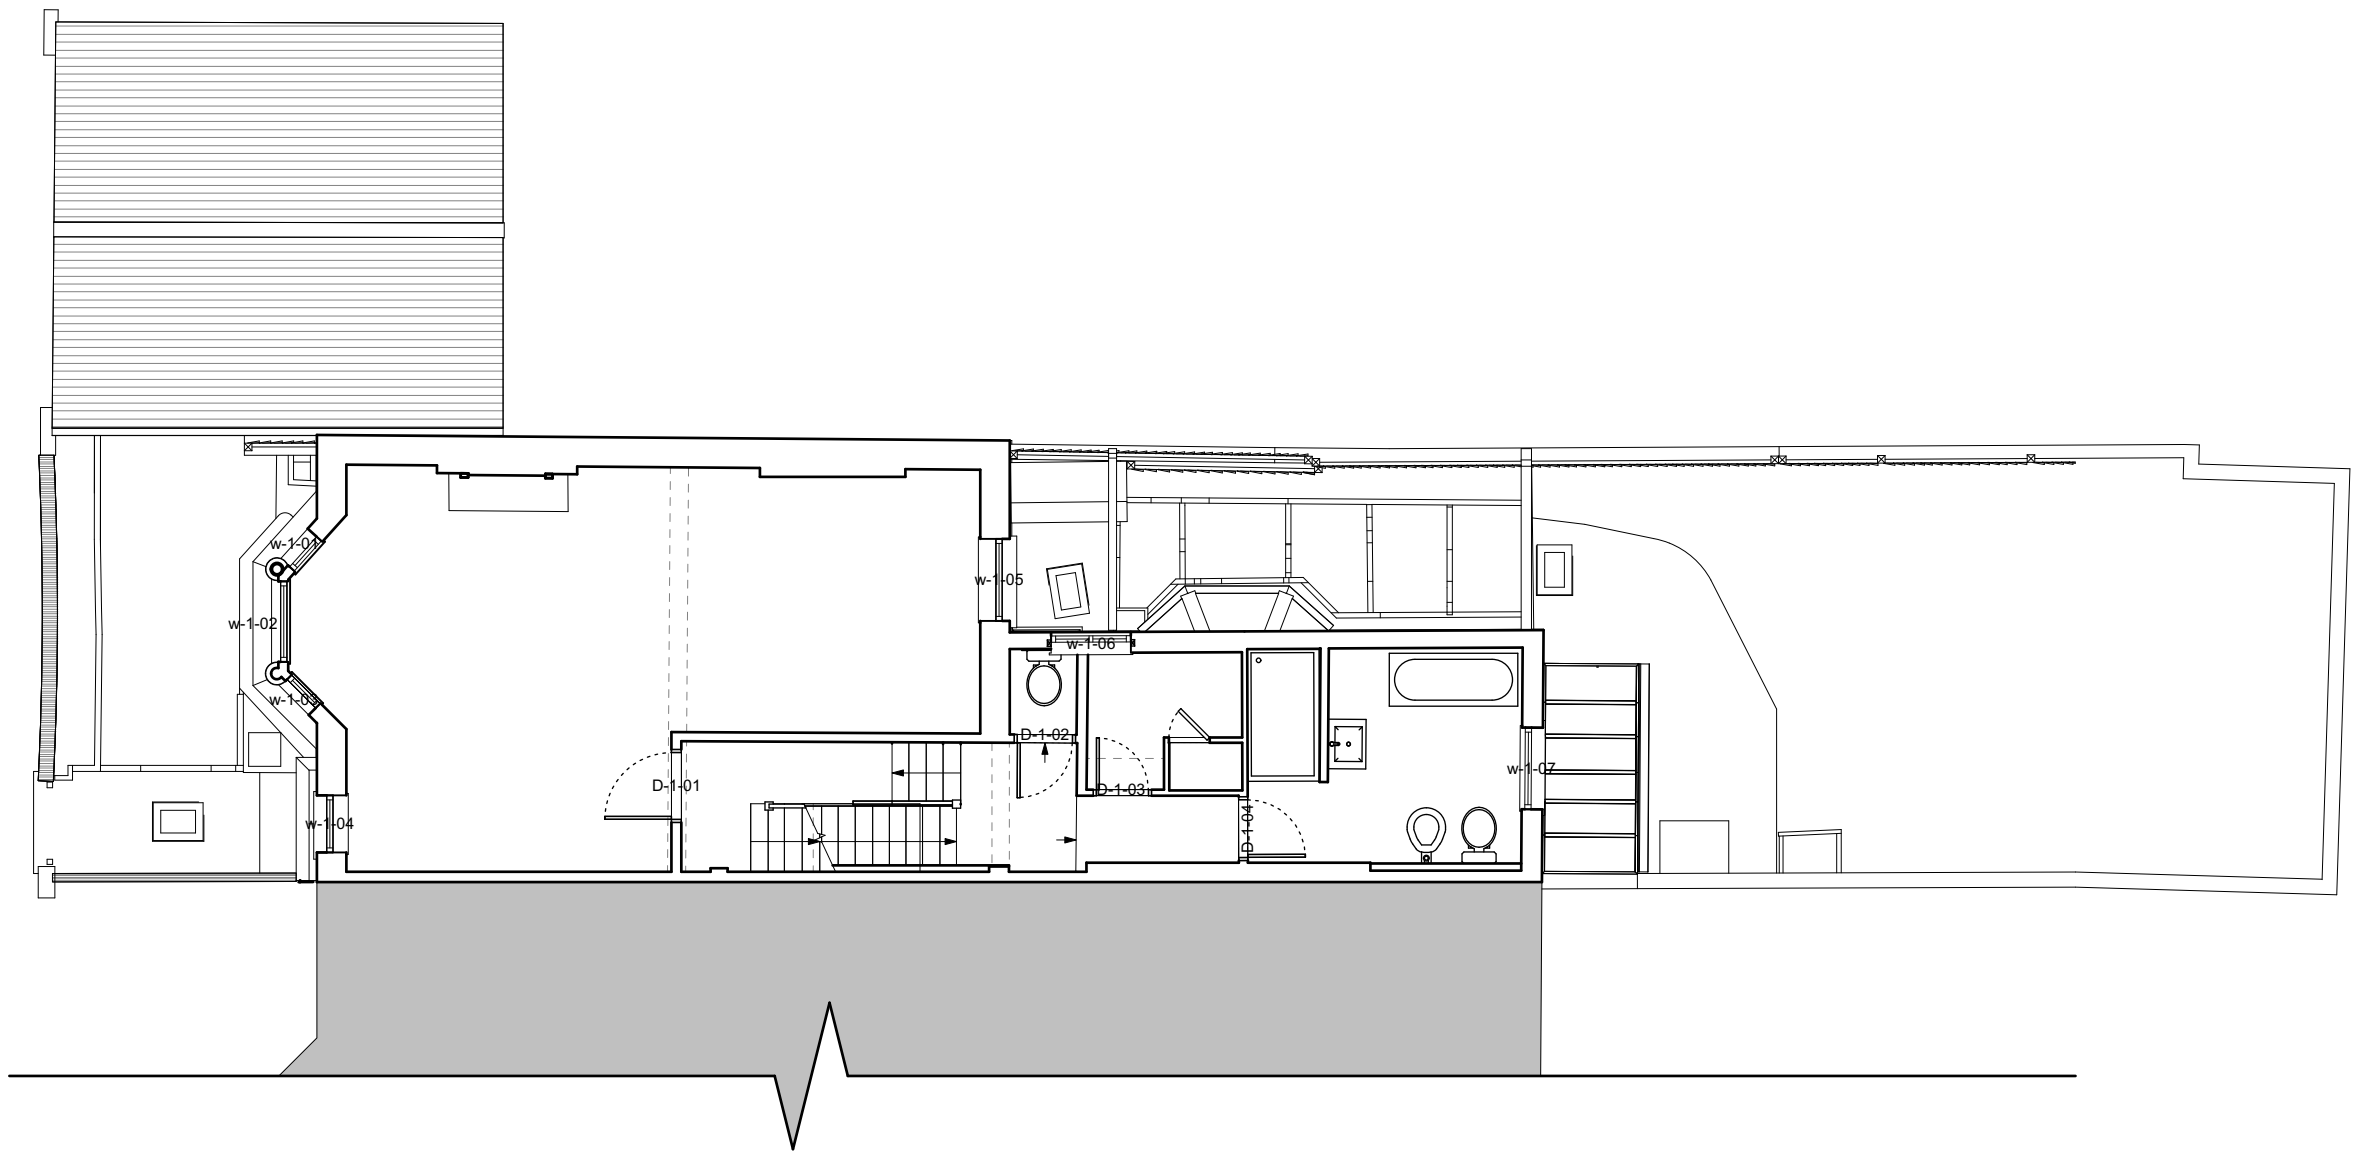

Existing First Floor Plan

Courthope House

Issue Notes

Date

Drawn By WM
Scale 1:100
Status Issue
Project Stage Survey

Paul Archer Design Ltd



Unit D204 Lana House 116 Commercial Street London E1 6NF


Tel. 020 3668 2668

916.003

paul archer
design

www.paularcherdesign.co.uk

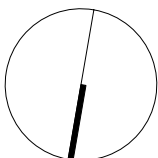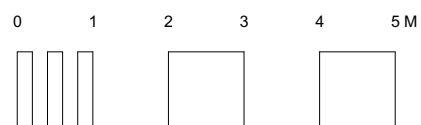

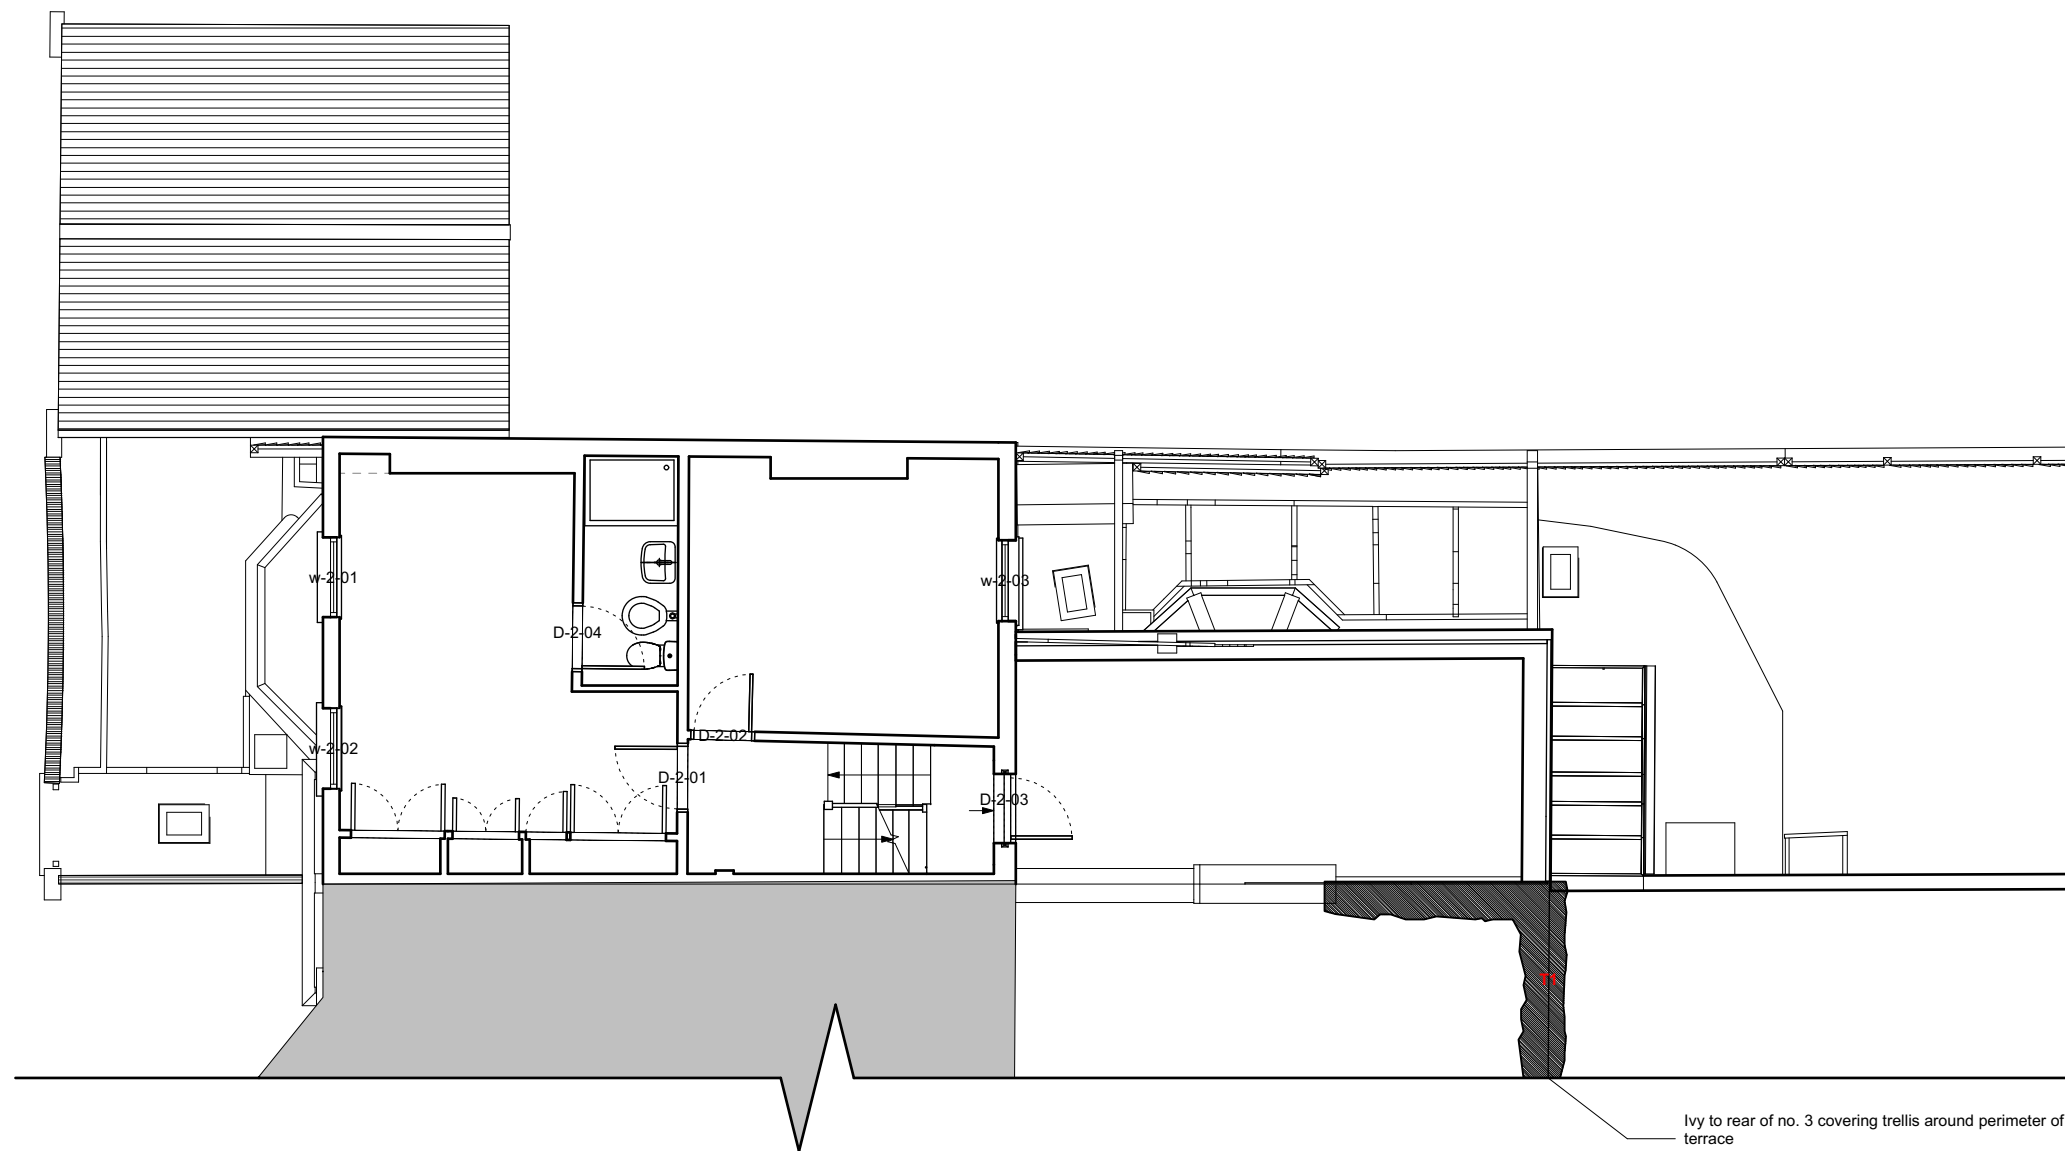

Existing Second Floor Plan

Courthope House

Drawn By WM
Scale 1:100
Status Issue
Project Stage Survey

Paul Archer Design Ltd

Issue	Notes	Date


Unit D204 Lana House 116 Commercial Street London E1 6NF


Tel. 020 3668 2668

916.004

paul archer
design

www.paularcherdesign.co.uk

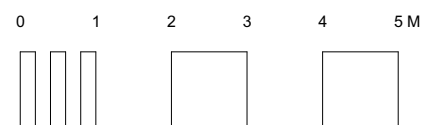

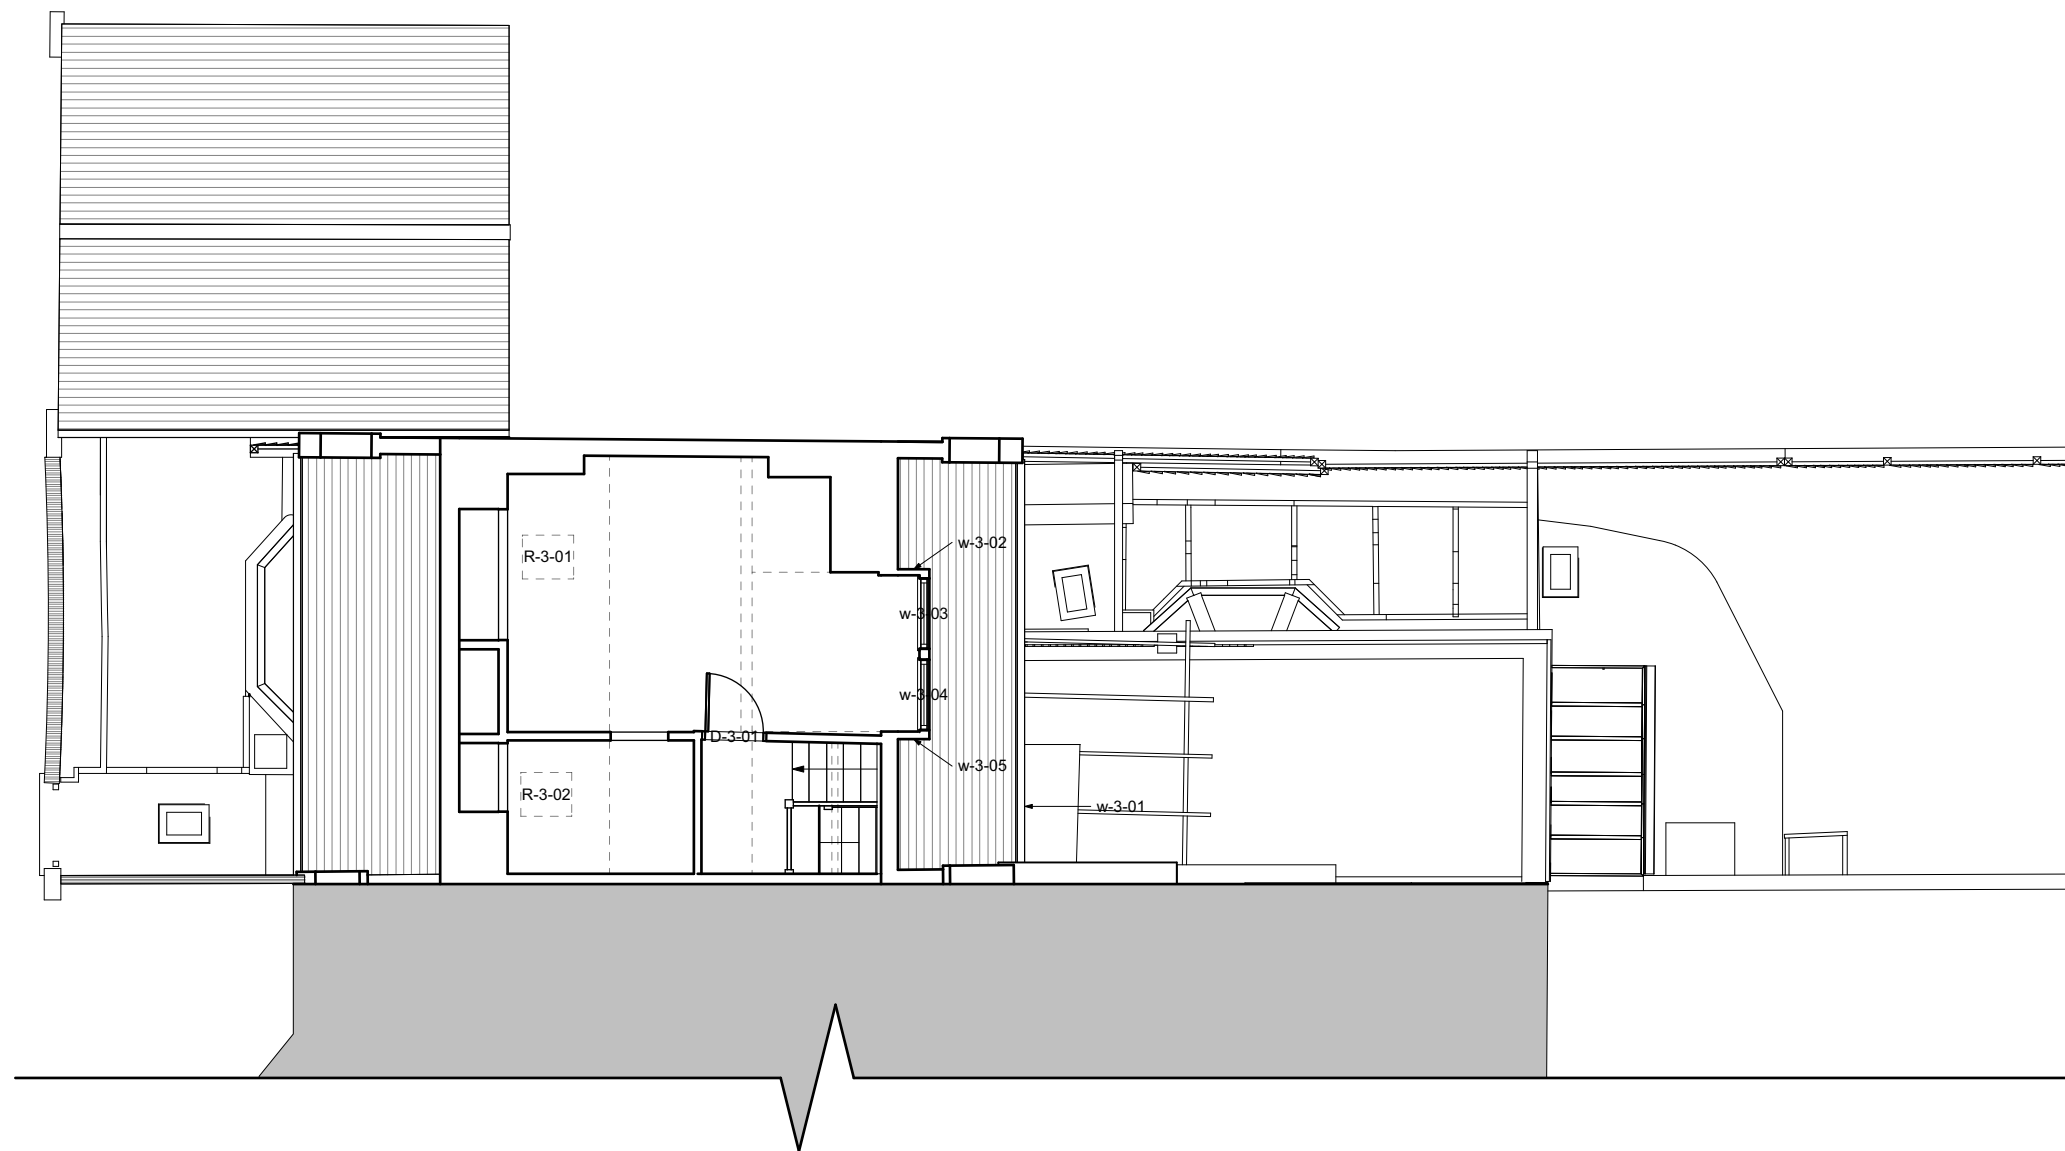

Existing Loft Plan

Courthope House

Drawn By WM
Scale 1:100
Status Issue
Project Stage Survey

Paul Archer Design Ltd

Issue	Notes	Date
-------	-------	------


Unit D204 Lana House 116 Commercial Street London E1 6NF


Tel. 020 3668 2668

916.005

paul archer
design

www.paularcherdesign.co.uk

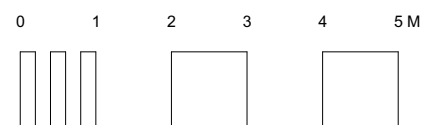

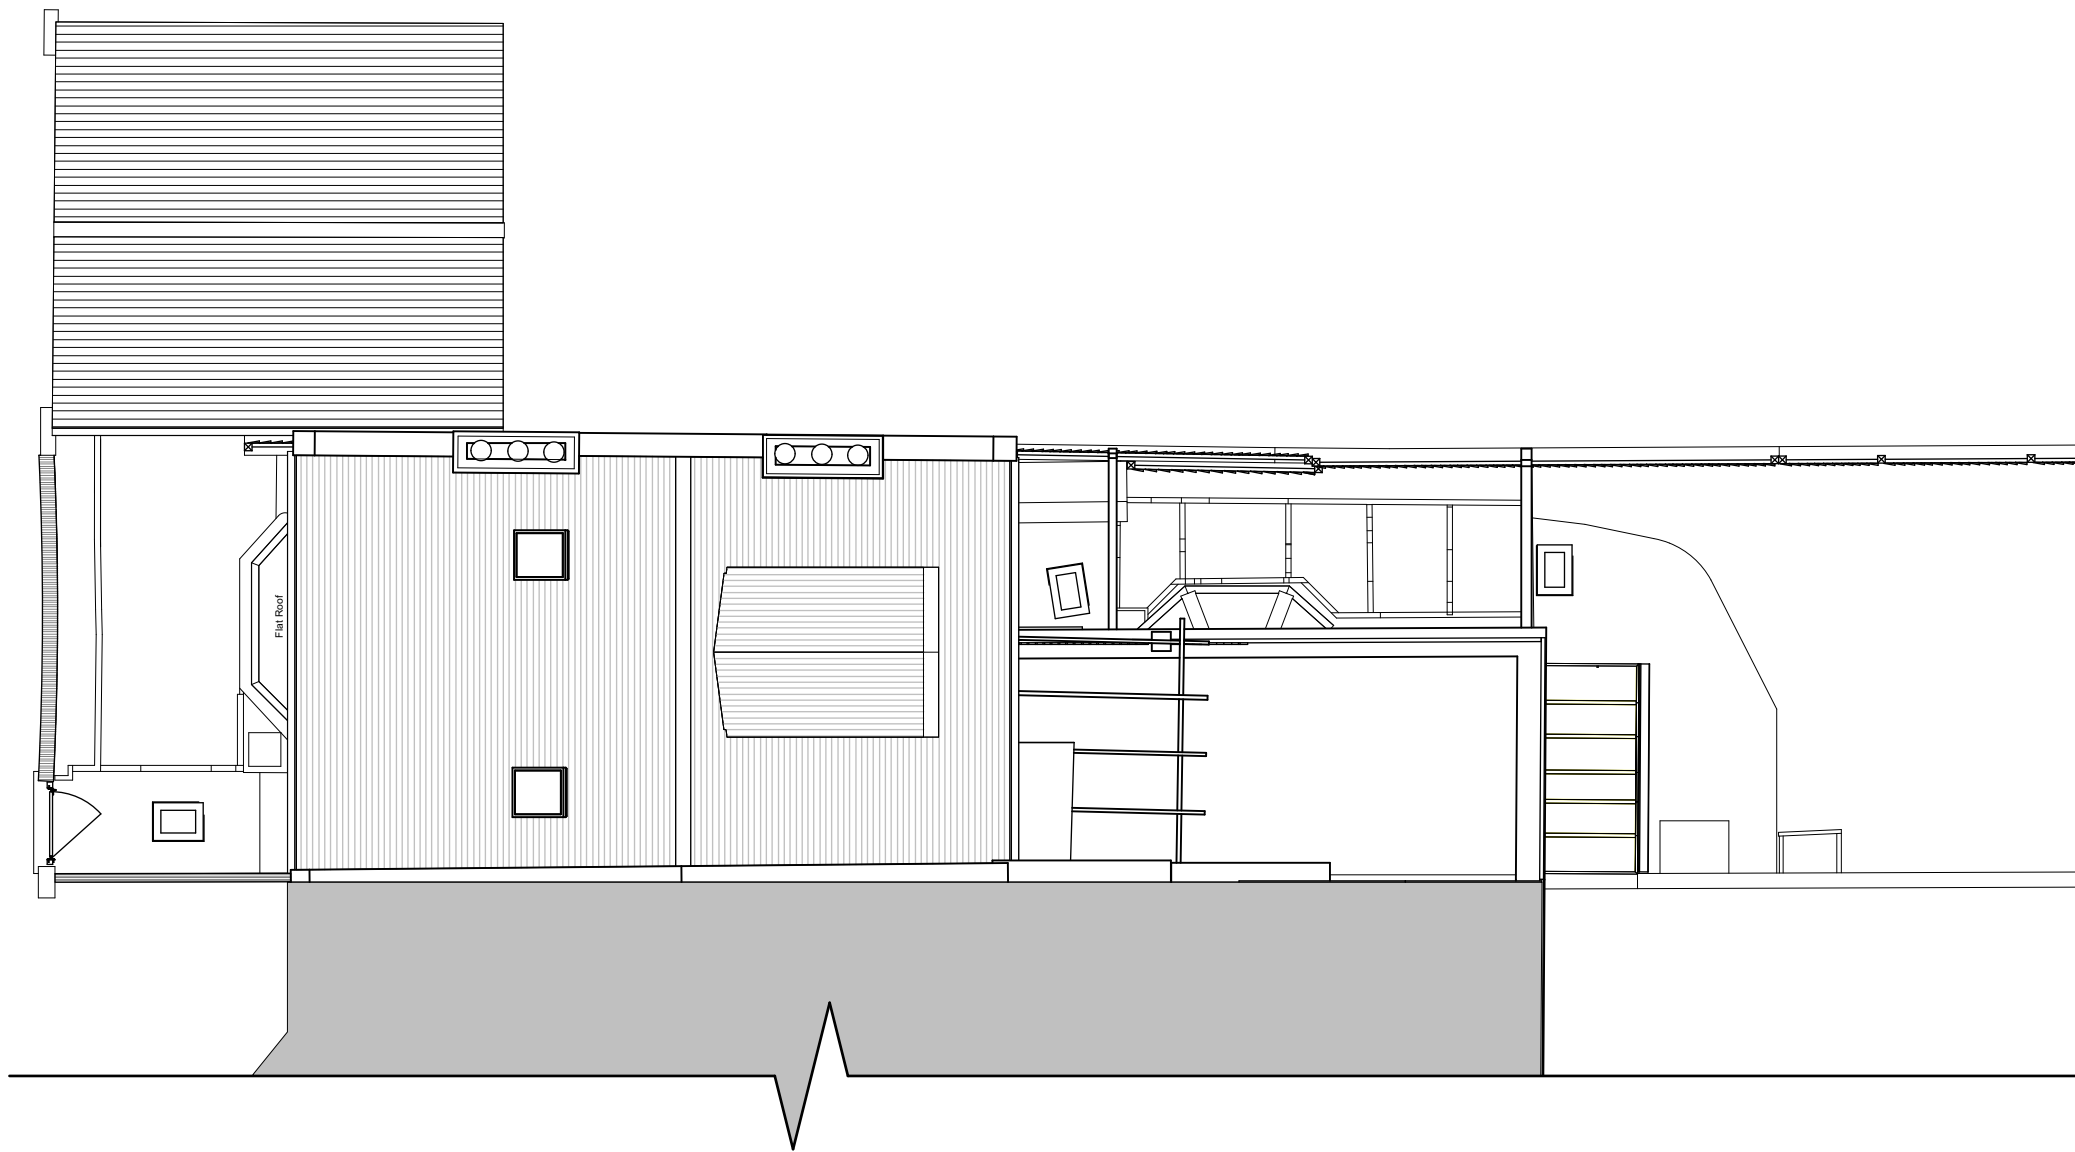

Existing Roof Plan

Courthope House

Drawn By WM
Scale 1:100
Status Issue
Project Stage Survey

Paul Archer Design Ltd



Issue	Notes	Date
A	Update with electrical layouts	22/03/2023

Unit D204 Lana House 116 Commercial Street London E1 6NF Tel. 020 3668 2668

916.010A

paul archer
design

www.paularcherdesign.co.uk

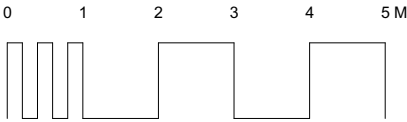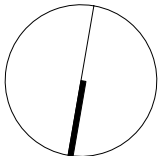




Front Elevation



Rear Elevation

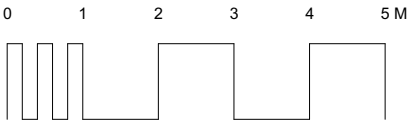

Existing Front + Rear Elevations

Courthope House

Drawn By WM
Scale 1:100
Status Issue
Project Stage Survey

Paul Archer Design Ltd


Issue Notes Date

Unit D204 Lana House 116 Commercial Street London E1 6NF Tel. 020 3668 2668


916.007

paul archer
design

www.paularcherdesign.co.uk

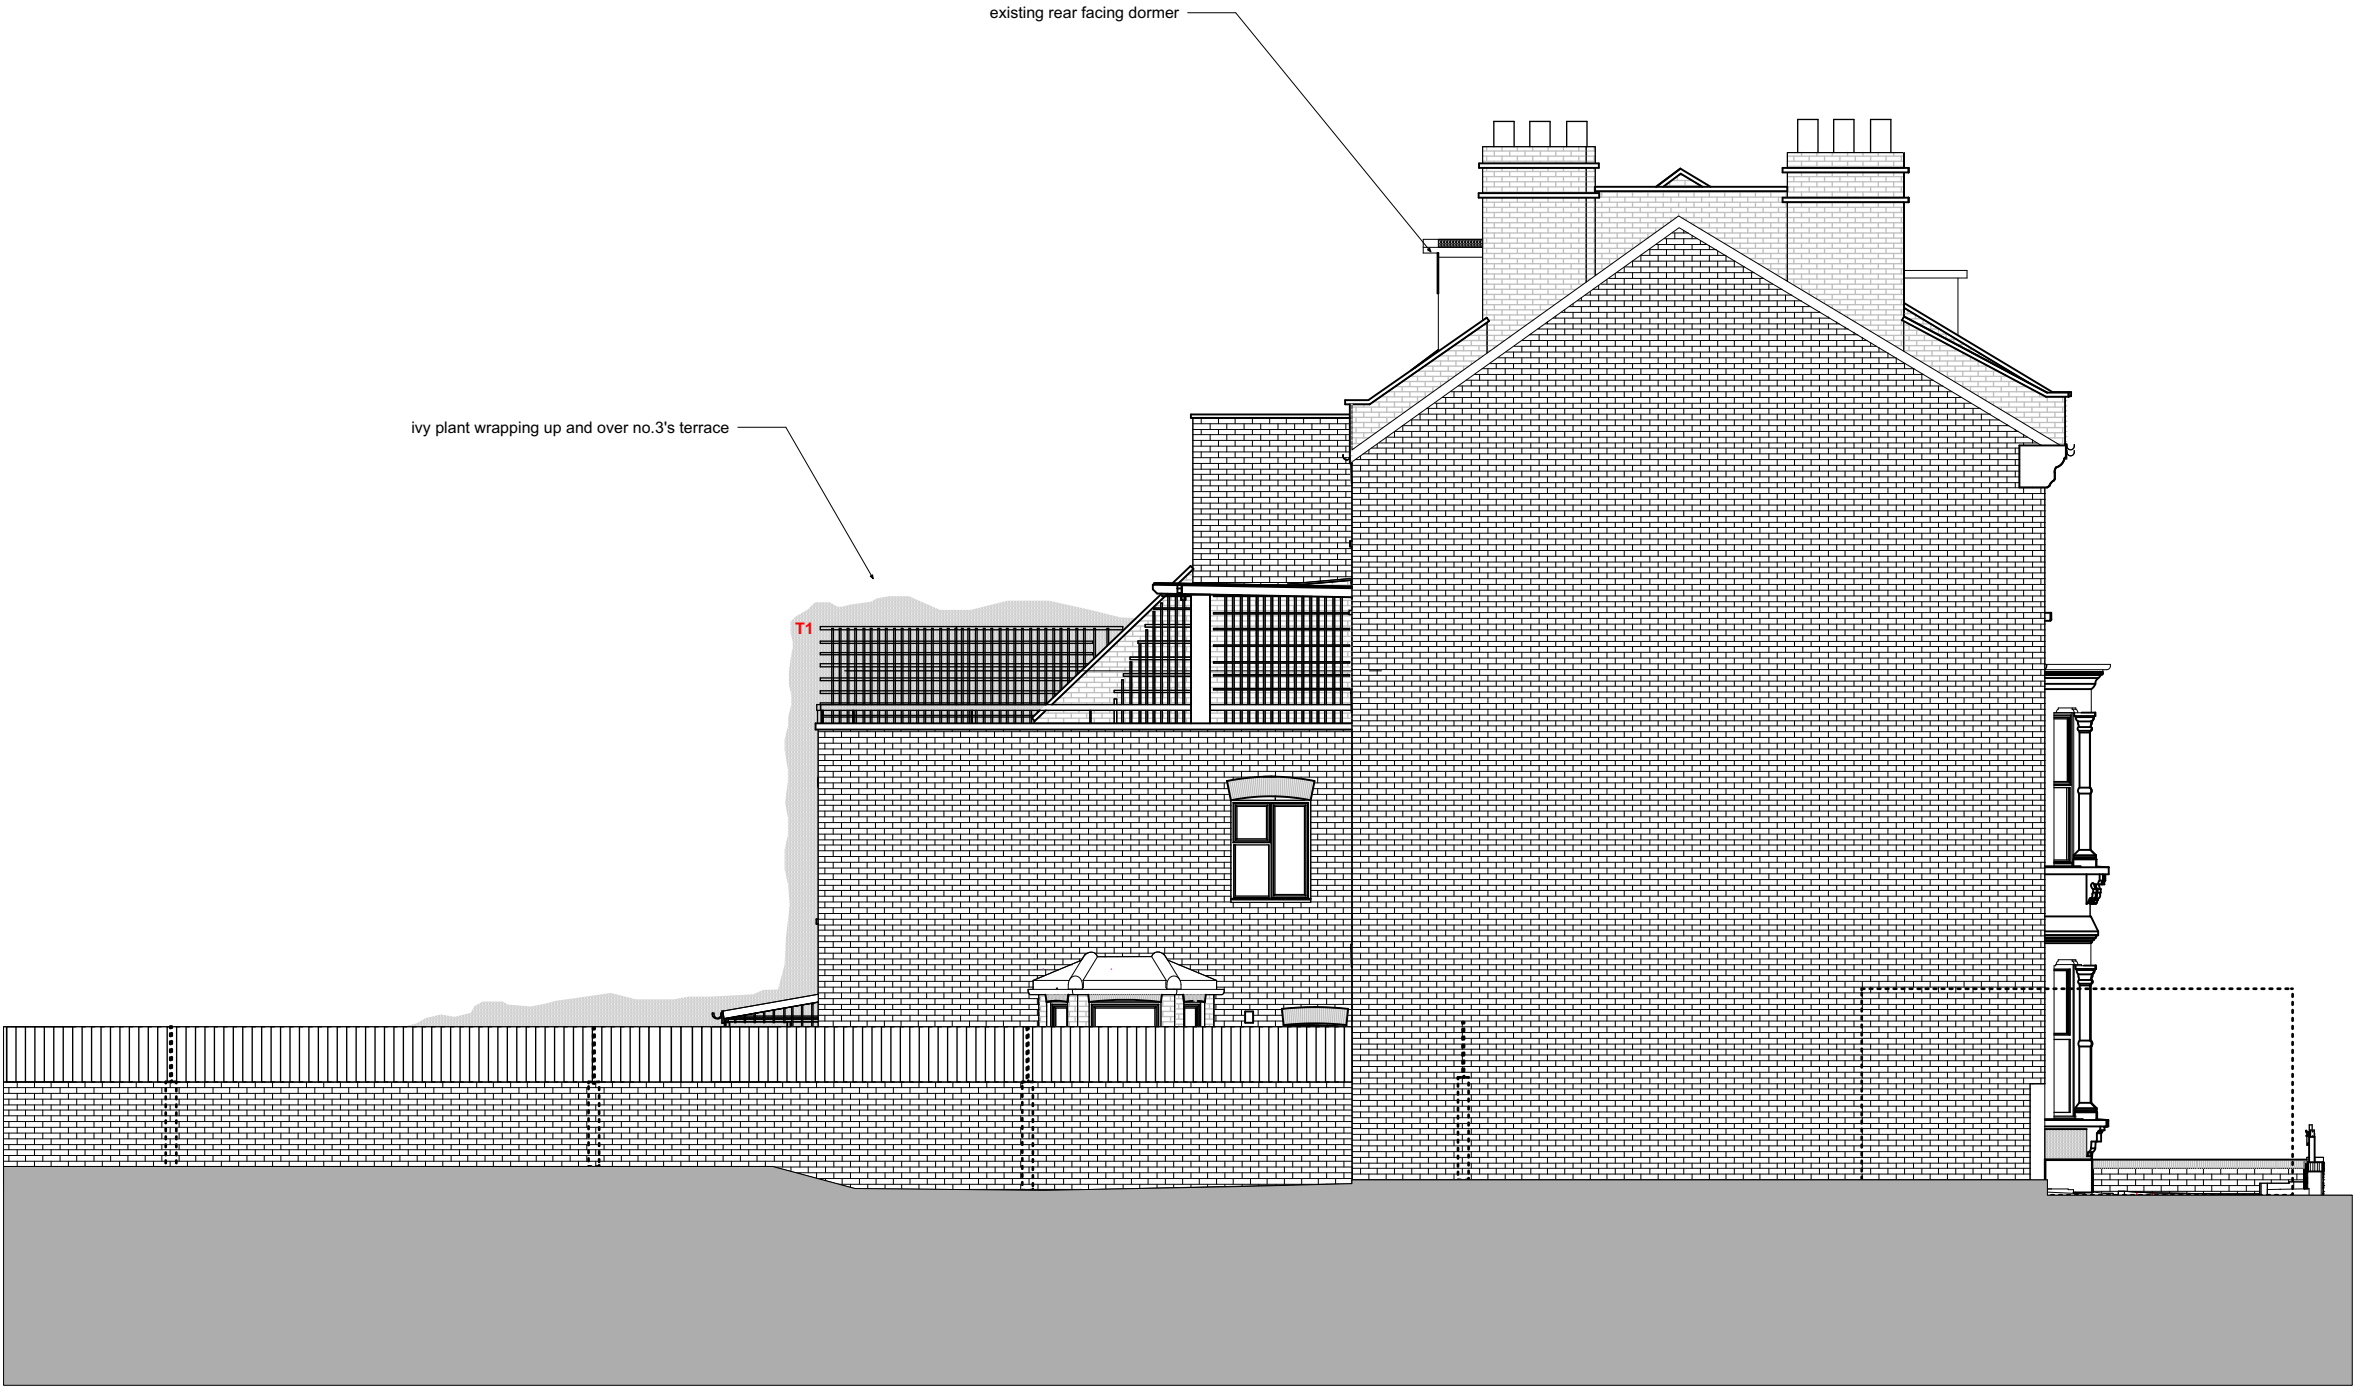

South Elevation

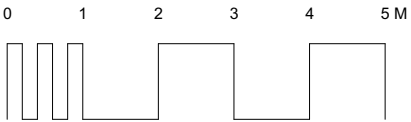

Existing Side Elevations

Courthope House

Drawn By WM
Scale 1:100
Status Issue
Project Stage Survey

Paul Archer Design Ltd


Issue	Notes	Date
A	Update with electrical layouts	22/03/2023

Unit D204 Lana House 116 Commercial Street London E1 6NF Tel. 020 3668 2668


916.008A

paul archer
design

www.paularcherdesign.co.uk

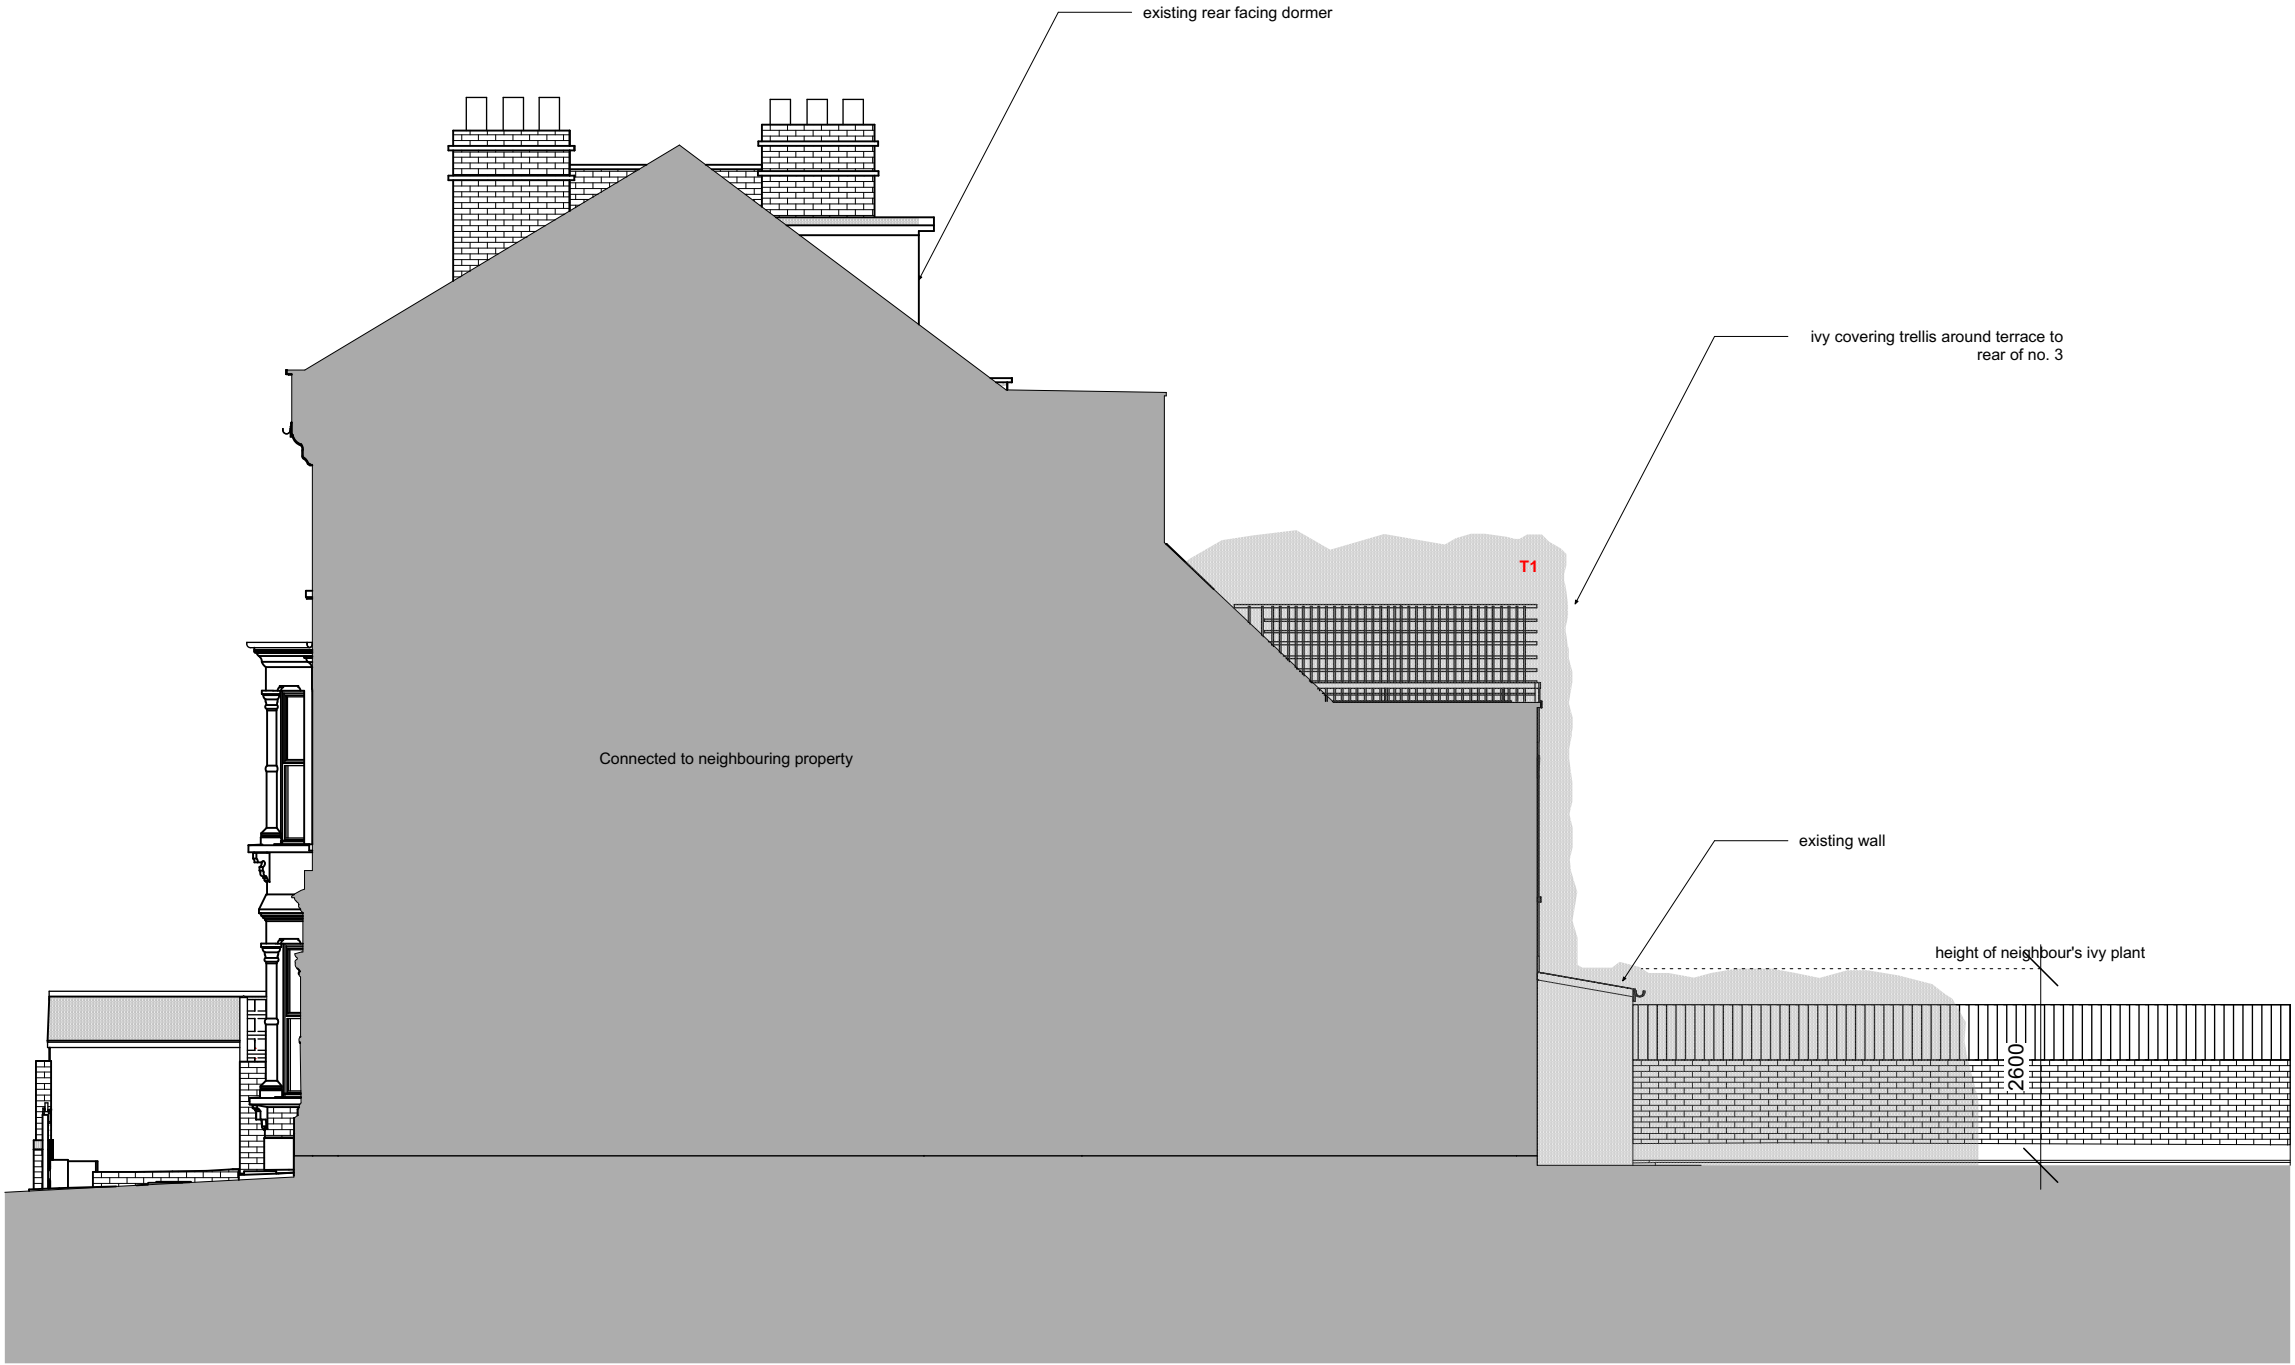

North Elevation

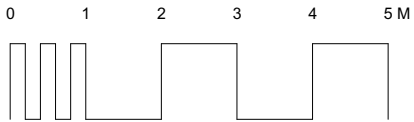

Existing Side Elevations

Courthope House

Drawn By WM
Scale 1:100
Status Issue
Project Stage Survey

Paul Archer Design Ltd

Issue	Notes	Date
A	Update with electrical layouts	22/03/2023

Unit D204 Lana House 116 Commercial Street London E1 6NF Tel. 020 3668 2668

916.009A

paul archer
design

www.paularcherdesign.co.uk