

- VENTILATION NOTES**
- WHERE DUCT WORK PASSES THROUGH A FIRE COMPARTMENT IT SHALL BE SATISFIED BY FIRE STOPPING.
 - FALL & EXH DUCTWORK SHALL BE INSULATED, EXCEPT WITHIN PLANTROOM.
 - ALL FANS TO BE INSTALLED ON ANTI-VIBRATION MOUNTS.
 - FOR ACOUSTIC REQUIREMENTS PLEASE REFER TO SPECIALISTS REPORT.

- VENTILATION LEGEND**
- EXH EXTRACT DUCTWORK (EXH)
 - EXT EXTRACT AIR DUCTWORK (EXT)
 - FAN FAN COIL UNIT
 - FRESH FRESH AIR DUCTWORK (FAN)
 - SUPPLY SUPPLY DUCTWORK (SUP)
 - INSULATION

- VENTILATION ABBREVIATIONS**
- HRU AIR HANDLING UNIT
 - ATT ATTENUATOR
 - DTG DOOR TRANSFER GRILLE
 - FCU FAN COIL UNIT
 - FD FLEXIBLE DUCT
 - EF EXTRACT FAN
 - EG EXTRACT GRILLE
 - EXH EXTRACT AIR
 - EXT EXTRACT AIR
 - FAN FAN COIL UNIT
 - FRESH FRESH AIR INTAKE
 - FCU FAN COIL UNIT
 - FD FLEXIBLE DUCT
 - FD MECHANICAL VENTILATION HEAT RECOVERY
 - FA RETURN AIR
 - RA RETURN AIR GRILLE
 - RS RETURN AIR
 - SPL SUPPLY AIR
 - VAV VARIABLE AIR VOLUME
 - VCD VOLUME CONTROL DAMPER

- DRAWING NOTES**
- THE DRAWING SHALL BE READ IN CONJUNCTION WITH ALL PROJECT RELEVANT DOCUMENTS INFORMATION, THE CONTRACT SPECIFICATION, ALL ARCHITECTS & CONSULTANTS LATEST INFORMATION & ALL RELEVANT THIRD PARTY INFORMATION.
 - ALL DIMENSIONS ARE IN MILLIMETRES (MM) UNLESS OTHERWISE STATED.

- ELECTRICAL LEGEND**
- PBR TO BE EXTENDED TO UNDERSIDE OF SERVICES ON CONDUIT AS SCOPE OF WORKS DETAIL C
 - PBR TO BE RAISED TO UNDERSIDE OF SERVICES ON BEZEL BOX AS SCOPE OF WORKS LIGHTING DETAIL D
 - FIRE ALARM DEVICE TO BE REPOSITIONED TO SUIT PROPOSED ARRANGEMENT


- AIR CONDITIONING LEGEND**
- RE ROOFING EYE
 - CHILLED WATER (CHW)
 - REFRIGERANT PIPework
 - RETURNS DUCTWORK
 - SUPPLY DUCTWORK

SERVICE ROUTE LEGEND

- DIRECTION OF SERVICE
- SERVICE UNDER FLOOR / GROUND
- SERVICE RUN AT ML / LL
- SERVICE RUN ABOVE CEILING
- FROM ABOVE / TO ABOVE
- FROM BELOW / TO BELOW
- TEE TO BELOW
- TEE TO ABOVE
- PIPE CONNECTION

GENERAL ABBREVIATIONS

- ACCESS PANEL
- COMPLETE WITH
- CEILING GRID
- FROM ABOVE / FROM BELOW
- FINISHED FLOOR LEVEL
- LOW LEVEL / HIGH LEVEL / MID LEVEL
- SET DOWN / SET UP
- TO ABOVE / TO BELOW

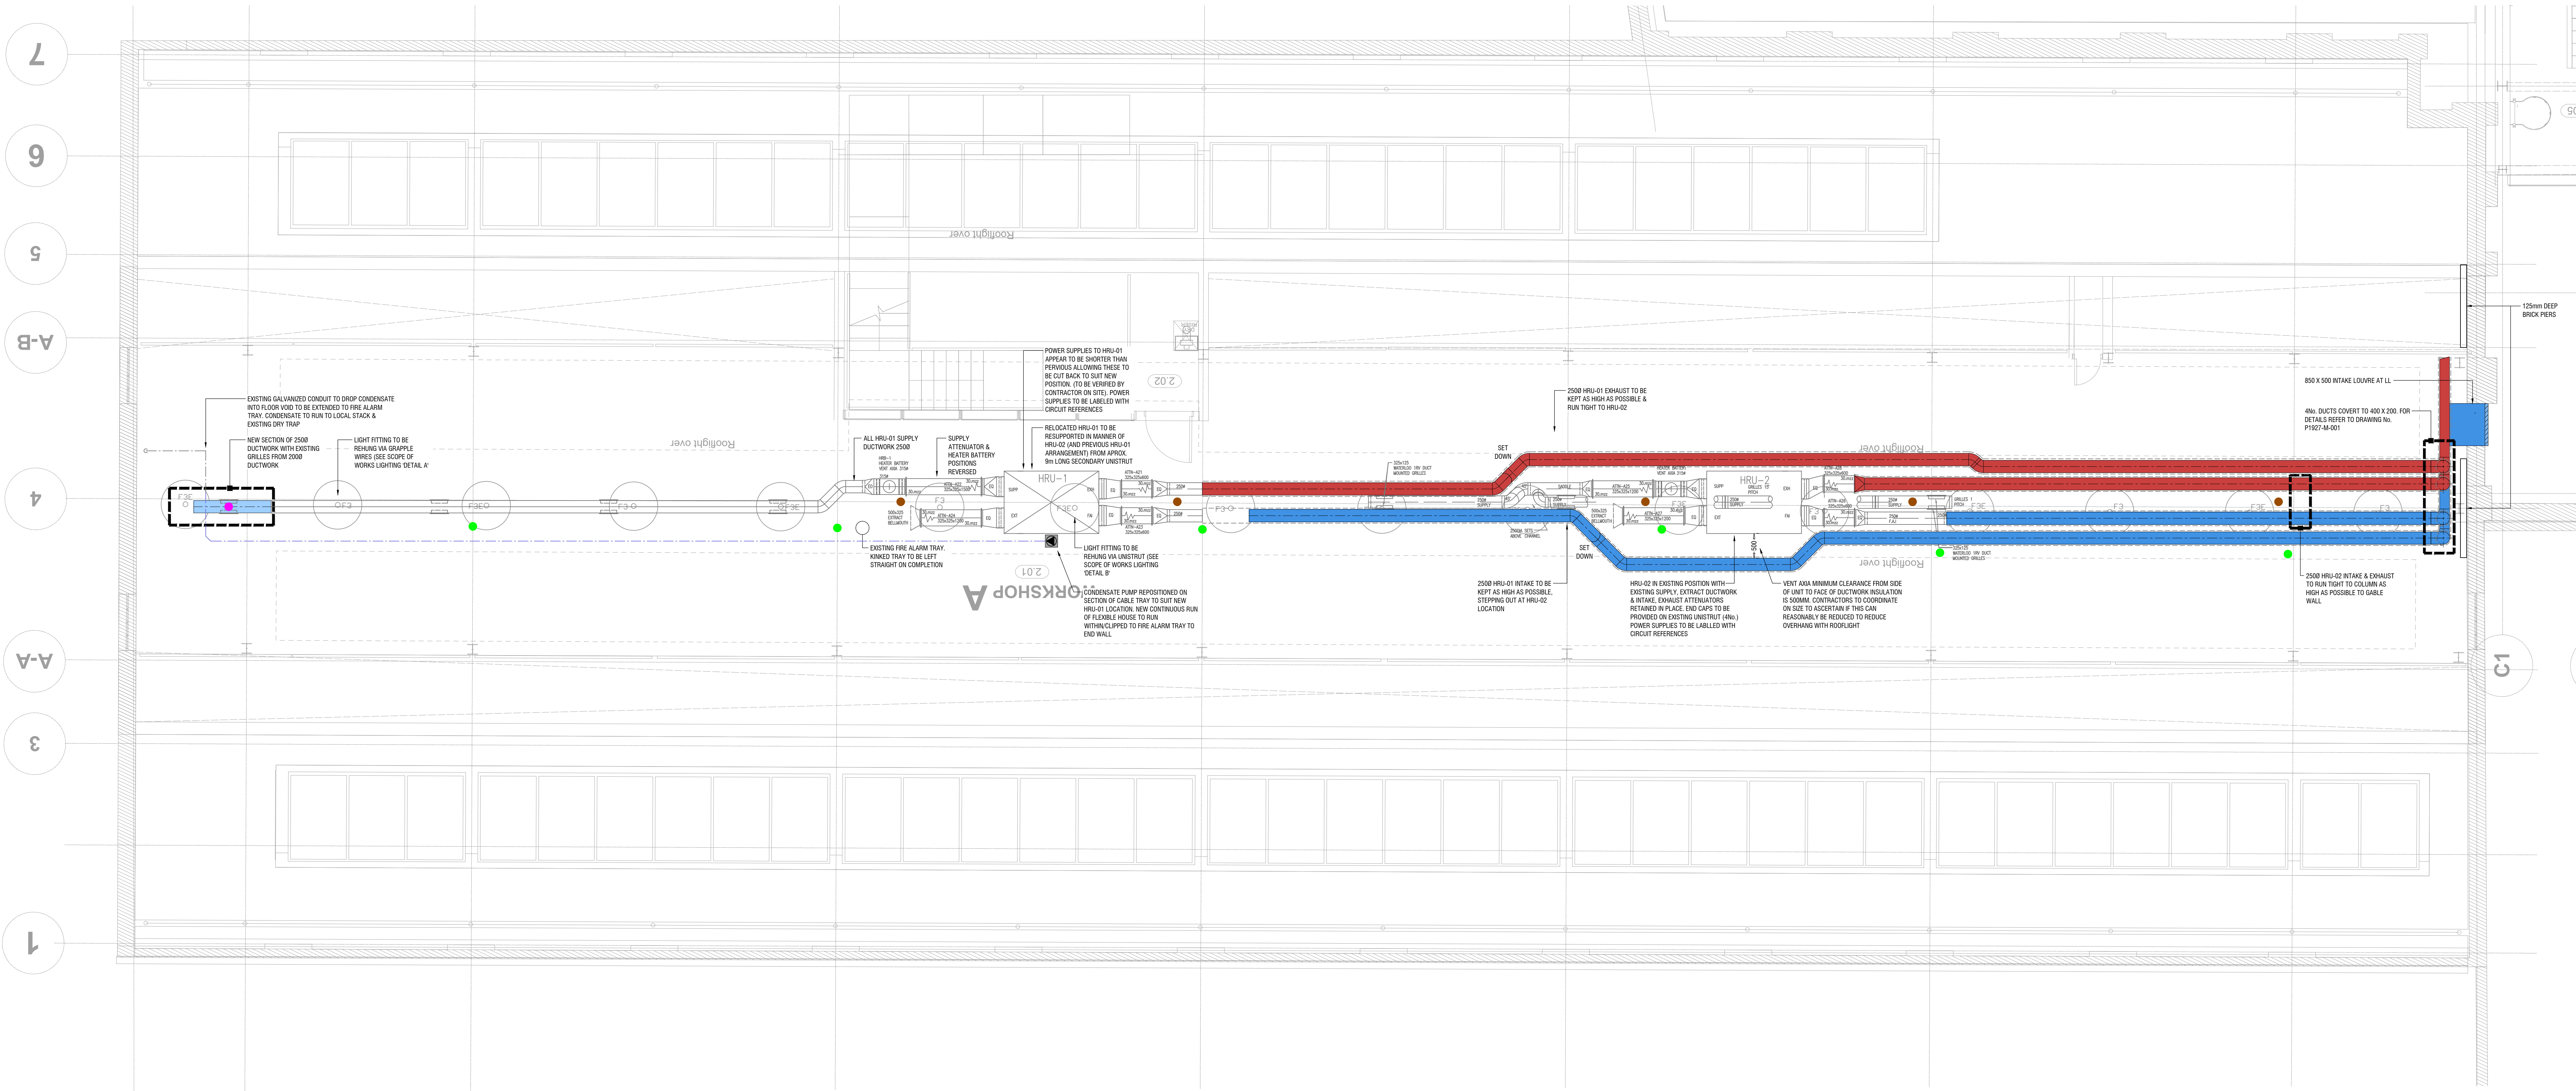

FOR COMMENT

PROJECT
FORTRESS GROVE
KENTISH TOWN

QuinnRoss
CONSULTANTS LTD

KENT | MED BRAY
LONDON | ST ALBANS
T: 01783 841035
W: www.qrconsultants.com
E: info@qrconsultants.com

CLIENT
WEST1

TITLE
2ND FLOOR
COMBINED SERVICES
PROPOSED HRU RELOCATION LAYOUT

SCALE
1:50

SIZE
A0

PLOTTED
ZGRAY

DRAWING No
P1927-C-001

REV
P1

REV	DATE	DESCRIPTION	DRN	CHK
P1	27.01.23	ISSUED FOR COMMENT	20	DC
© THIS DRAWING IS THE PROPERTY OF QUINNROSS CONSULTANTS LTD. IT IS ISSUED IN CONFORMANCE OF BEST PRACTICE. CANNOT BE REPRODUCED OR TRANSMITTED IN ANY FORM OR BY ANY MEANS WITHOUT WRITTEN PERMISSION OF THE COMPANY.				