


1 DEMOLITION REFLECTED CEILING PLAN - E91, E93, E94, E97
 Scale: 1:100

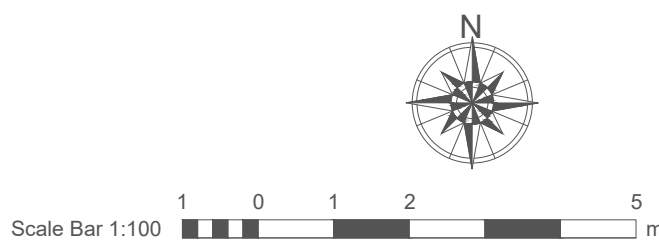

- LEGEND**
- CH= EXISTING CEILING HEIGHT
 - PIR EXISTING PIR
 - SD EXISTING SMOKE DETECTORS
 - FCU EXISTING FCU UNIT
 - W EXISTING WIFI ROUTER
 - ⊗ EXISTING LIGHTING
 - REMOVE OR DEMOLISH
 - Retain/Set Aside

| Rev | Description | By | QA | DD.MM.YY |
|-----|-------------|----|----|------------|
| T1 | TENDER | GA | DL | 24.03.2023 |

© This drawing and any design hereon is the copyright of Potter Raper and must not be reproduced without their written consent. All drawings remain the property of Potter Raper. Figured dimension only to be taken from this drawing. All dimensions to be checked on site. Please inform Potter Raper immediately of any discrepancies before work proceeds.

Client
 UNIVERSITY COLLEGE LONDON

Project Name
 BEAMS PHYSICS CORRIDOR

Project Location
 PHYSICS BUILDING
 GOWER STREET, LONDON
 WC1E 6BT

Sheet Name
 DEMOLITION REFLECTED CEILING
 PLAN - E91, E93, E94, E97

Project Status
 PRE-CONTRACT

Drawing Nr.
 LB032-SW2207-003

Scale As indicated @ A3



101 St Martin's Lane
 London
 WC2N 4AZ
 Tel: 020 7436 5005