


1 EXISTING GROUND FLOOR RCP LIGHTING PLAN
Scale 1:20

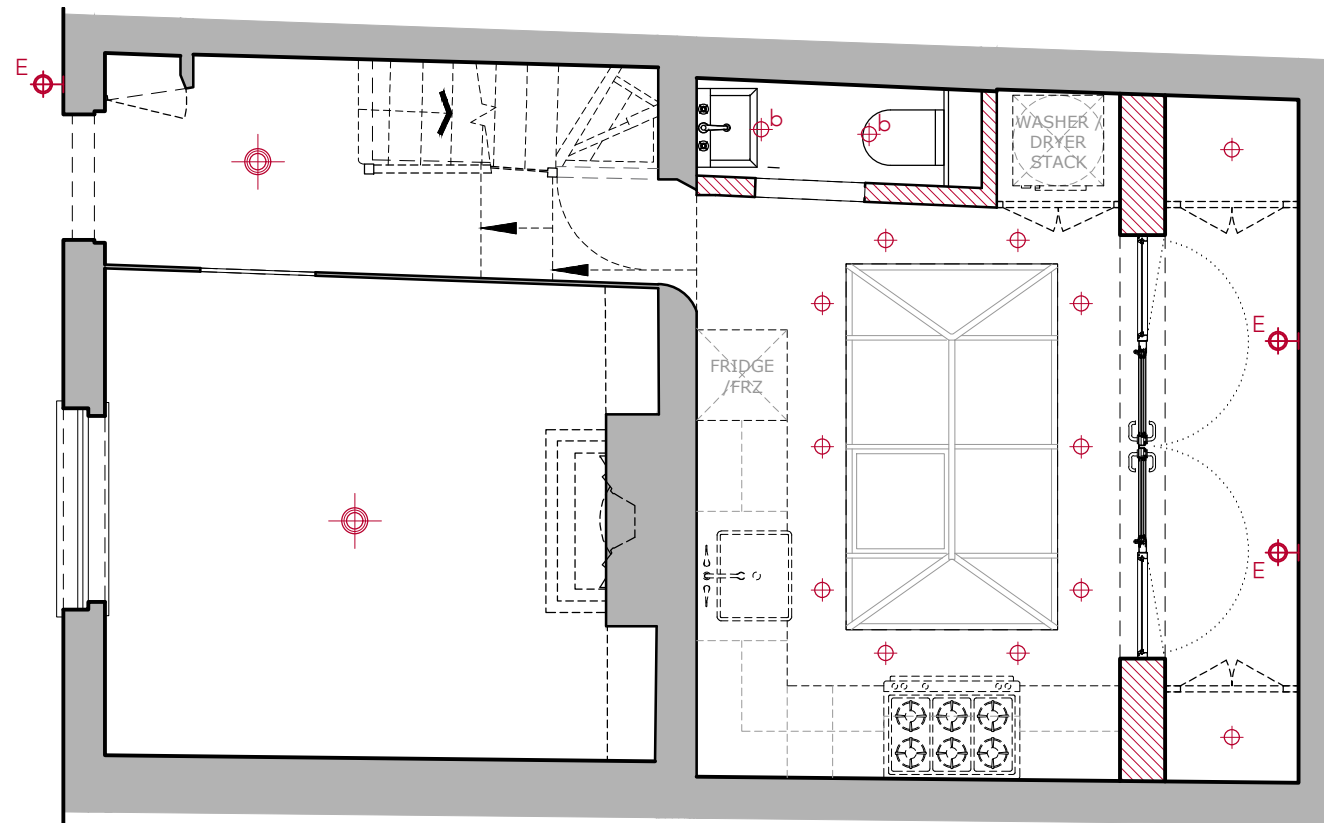

2 PROPOSED GROUND FLOOR RCP LIGHTING PLAN
Scale 1:20

Symbol	DESCRIPTION
⊕	RECESSED DOWN LIGHT
⊕ ^b	RECESSED DOWN LIGHT FOR BATHROOMS
⊕ ⁺	SUSPENDED / PENDANT LIGHT
⊕ ^W	WALL LIGHT
⊕ ^{bW}	WALL LIGHT FOR BATHROOMS
⊕ ^E	EXTERNAL WALL LIGHT



This drawing is protected under Copyright and at no time should any portion of this drawing be reproduced or copied without the permission of the Architect. (Design Copyright Act 1968)

This drawing must not be used for purposes other than that for which it is provided. It is supplied without liability for any errors or omissions.

Drawings only to be scaled for planning application purposes, all dimensions to be checked on site. All drawings subject to Statutory Authority Approval.

Notes

No	Rev	Date
1	PLANNING	04.05.2023

PLANNING



ARCHITECTS + INTERIOR DESIGNERS

91A - 91B HEATH STREET
LONDON NW3 6SS
Tel 020 7636 3838

INFO WWW.TG-STUDIO.CO.UK

Project
2 BENHAMS PLACE
NW3 6QX

Date
04.05.2023
Scale @ A3
1:100

Drawing
EXISTING & PROPOSED
RCP LIGHTING PLANS
GROUND FLOOR

Drawn by
AL
Checked by
TG

Job No.
270
Dwg No.
P-410
Rev
1