


1 EXISTING FIRST FLOOR RCP LIGHTING PLAN
Scale 1:20



2 PROPOSED FIRST FLOOR RCP LIGHTING PLAN
Scale 1:20

Symbol	DESCRIPTION
	RECESSED DOWN LIGHT
	RECESSED DOWN LIGHT FOR BATHROOMS
	SUSPENDED / PENDANT LIGHT
	WALL LIGHT
	WALL LIGHT FOR BATHROOMS
	EXTERNAL WALL LIGHT

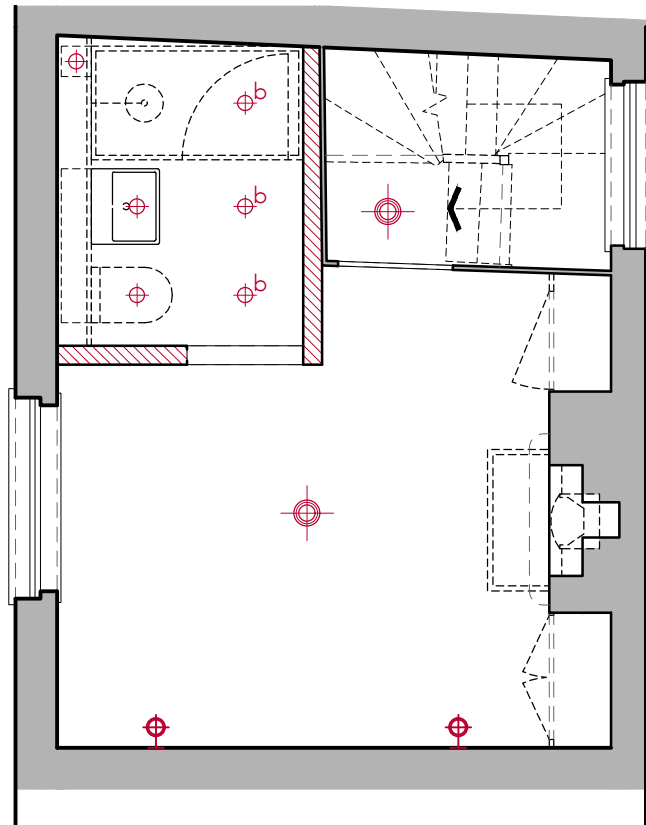

This drawing is protected under Copyright and at no time should any portion of this drawing be reproduced or copied without the permission of the Architect. (Design Copyright Act 1968)

This drawing must not be used for purposes other than that for which it is provided. It is supplied without liability for any errors or omissions.

Drawings only to be scaled for planning application purposes, all dimensions to be checked on site. All drawings subject to Statutory Authority Approval.

Notes	
1	PLANNING 04.05.2023
No	Date
Rev	

Status **PLANNING**



ARCHITECTS + INTERIOR DESIGNERS

91A - 91B HEATH STREET
LONDON NW3 6SS
Tel 020 7 636 3838

INFO WWW.TG-STUDIO.CO.UK

Project 2 BENHAMS PLACE
NW3 6QX

Date 04.05.2023
Scale @ A3 1:100

Drawing EXISTING & PROPOSED
RCP LIGHTING PLANS
FIRST FLOOR

Drawn by AL
Checked by TG

Job No. 270
Dwg No. P-411
Rev 1