


1 EXISTING SECOND FLOOR RCP LIGHTING PLAN  
Scale 1:20



2 PROPOSED SECOND FLOOR RCP LIGHTING PLAN  
Scale 1:20

Symbol	DESCRIPTION
	RECESSED DOWN LIGHT
	RECESSED DOWN LIGHT FOR BATHROOMS
	SUSPENDED / PENDANT LIGHT
	WALL LIGHT
	WALL LIGHT FOR BATHROOMS
	EXTERNAL WALL LIGHT

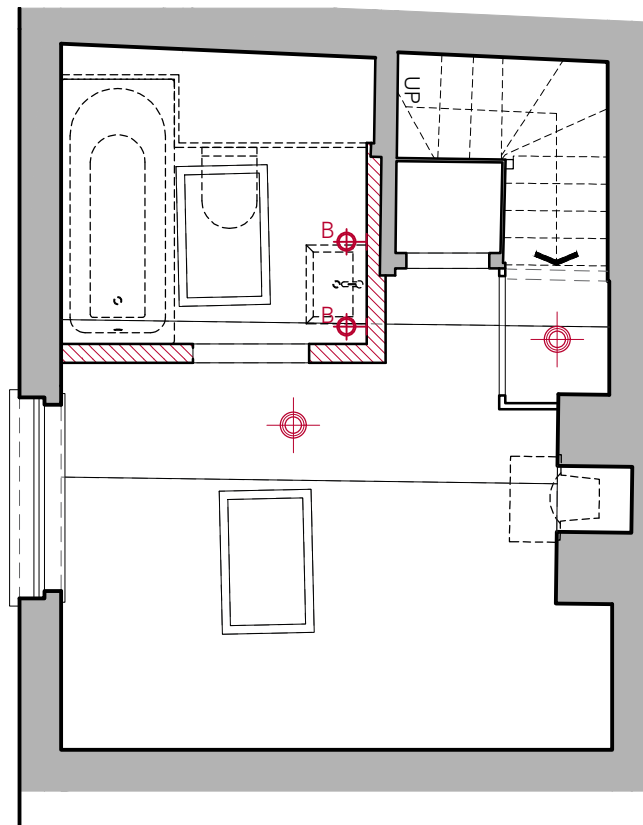

This drawing is protected under Copyright and at no time should any portion of this drawing be reproduced or copied without the permission of the Architect. (Design Copyright Act 1968)

This drawing must not be used for purposes other than that for which it is provided. It is supplied without liability for any errors or omissions.

Drawings only to be scaled for planning application purposes, all dimensions to be checked on site. All drawings subject to Statutory Authority Approval.

Notes	
1	PLANNING 04.05.2023
No Rev	Date

Status **PLANNING**



ARCHITECTS + INTERIOR DESIGNERS

91A - 91B HEATH STREET  
LONDON NW3 6SS  
Tel 020 7636 3838

INFO WWW.TG-STUDIO.CO.UK

Project 2 BENHAMS PLACE  
NW3 6QX

Date 03.05.2023  
Scale @ A3 1:100

Drawing EXISTING & PROPOSED  
RCP LIGHTING PLANS  
SECOND FLOOR

Drawn by AL  
Checked by TG

Job No. 270  
Dwg No. P-412  
Rev 1