

| QUANTITY | LEGEND OF SYMBOLS | | |
|----------|-------------------|---|---------|
| | | 60W LED 1500mm THORPROOF ANTI CORROSIVE LUMINAIRE | |
| | | THORLUX CAT No. TP15907L | HAL REF |
| | | 60W EMERGENCY LED 1500mm THORPROOF ANTI CORROSIVE LUMINAIRE | |
| | | THORLUX CAT No. ETP15907L | HAL REF |

COPYRIGHT
This drawing is copyright and may not be altered, reproduced or used other than for the Contract Works for which it is issued without written permission.

STATUS OF DRAWING
The purpose of this drawing when issued as a Tender Drawing is to enable tenders to interpret correctly the design and submit competitive tenders for the Works.


TENDER
A Tender Drawing whether original or amended shall not be used as an Installation Drawing except under the terms contained in the Conditions of Tender.

WARNING
Do not scale this drawing. Verify all dimensions and structural details on site. If in doubt, ask before acting.

RELATED DOCUMENTS
Read this drawing in conjunction with the appropriate Specifications.

CHECKING
This drawing has been generated using a Computer Drafting System. As the system generates a new drawing at each revision, only the latest edition shall be installed as checked.

| Revision | Revision Date | Revision Notes |
|----------|---------------|----------------|
| | | |

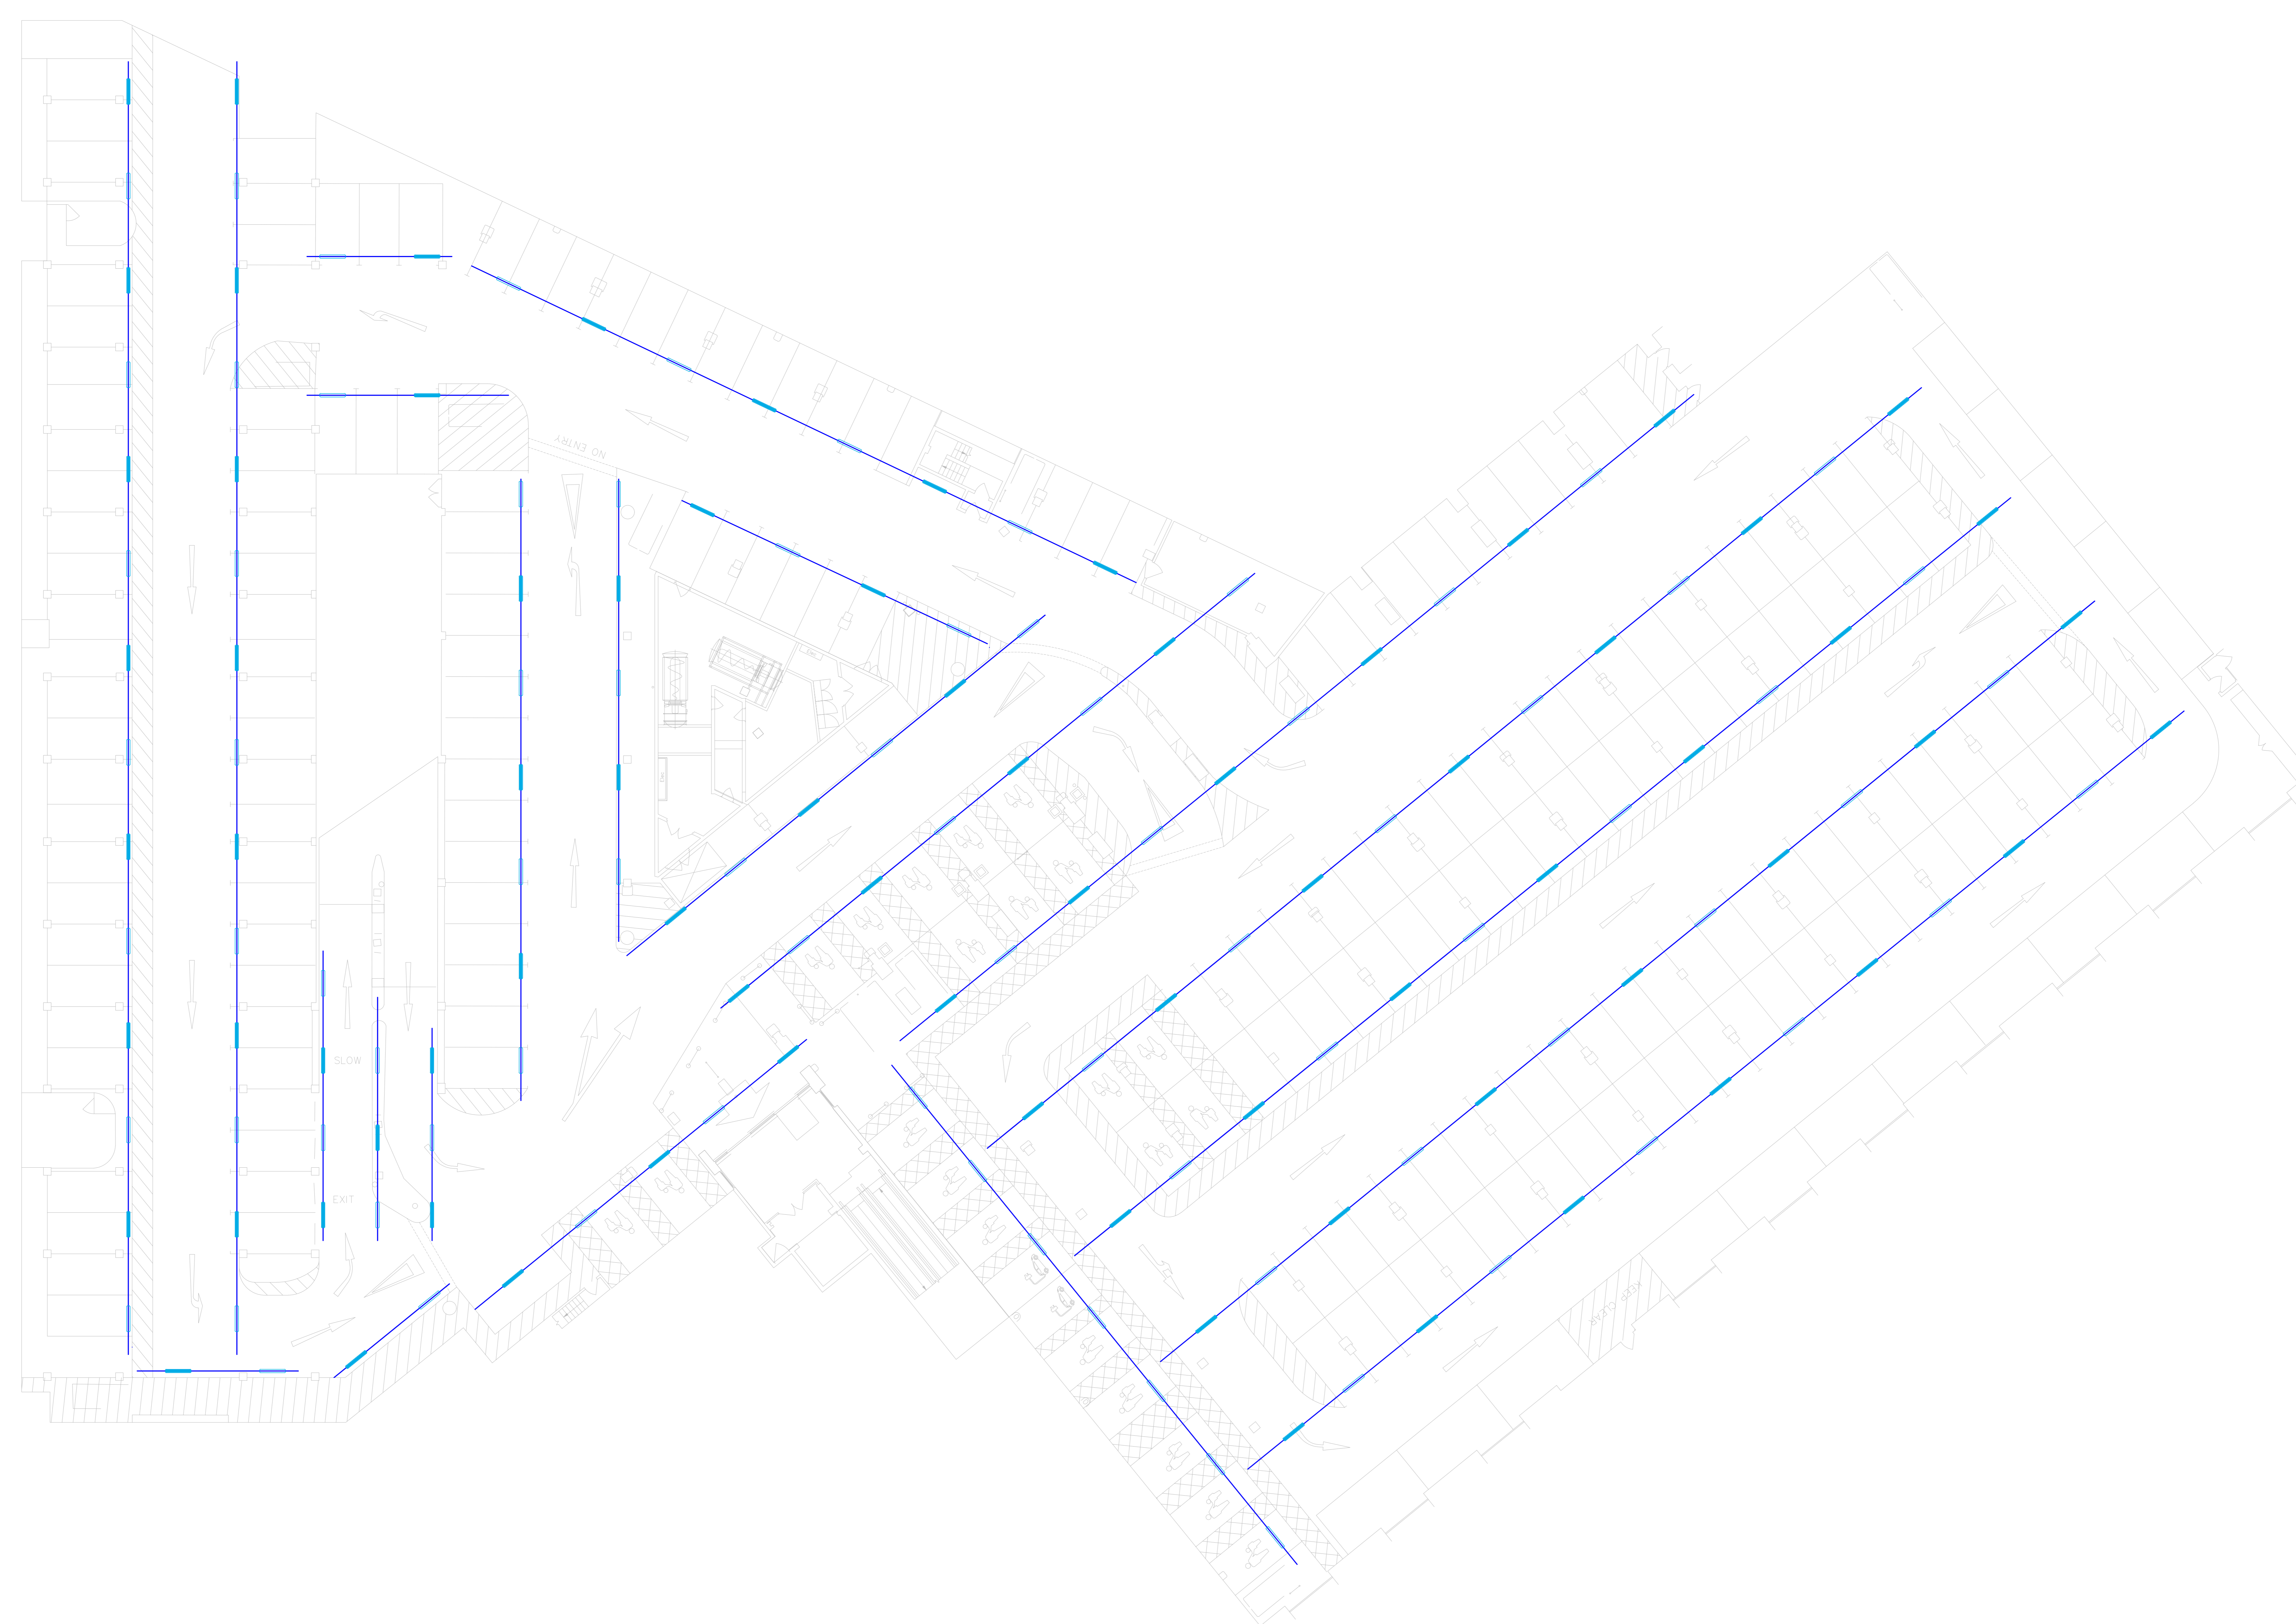

THIS DRAWING WAS CREATED WITH

PRELIMINARY ISSUE



CLIENT: **Sainsbury's**

Project: **SAINSBURY'S CAMDEN 2020**

Drawing Title: **BASEMENT LIGHTING LAYOUT**

| | | | |
|-----------|------|----------|------------|
| Designed: | CAD: | Checked: | Date: |
| NSI | LP | NSI | APRIL 2020 |

Scale: **A0@1:150** Project No.:

Drawing Number: **XX-XXXX-XXXX-HAL-ZZZ-B1-DR-E-6308** Revision: