 

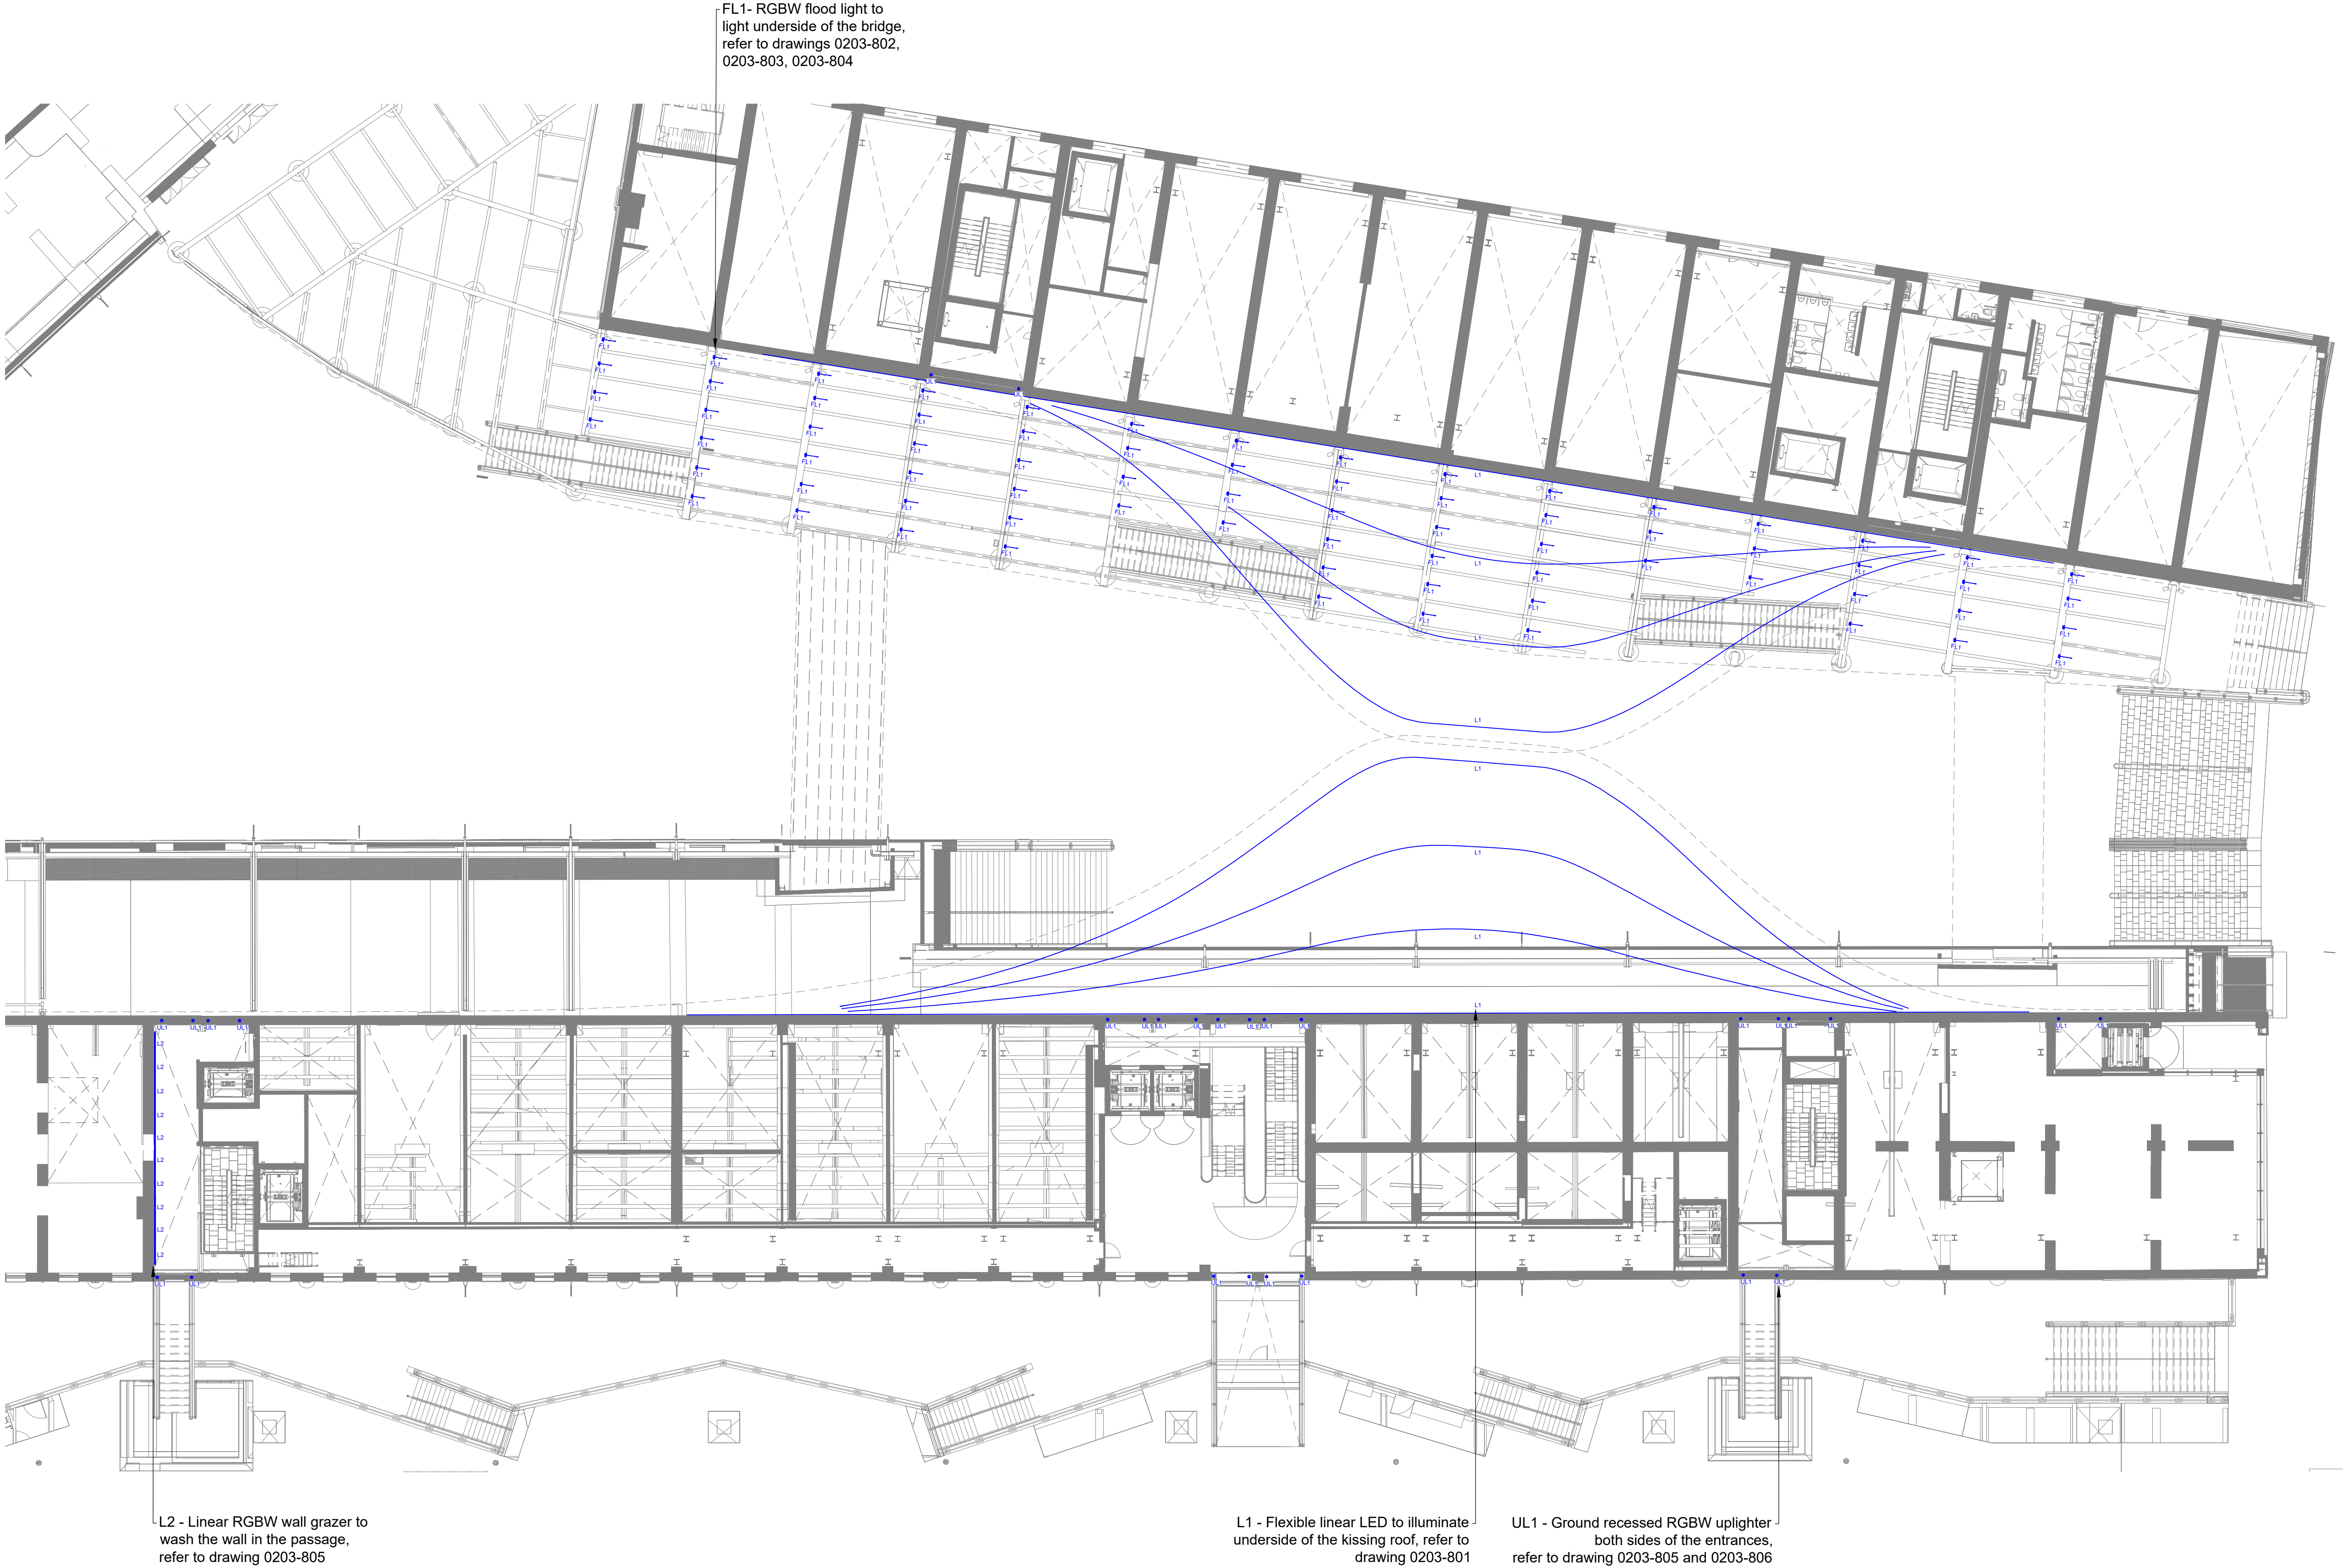


LEGEND		 L2	Linear wall grazer RGBW/55W/IP66
TYPE	DESCRIPTION		
 FL1	RGBW floodlight Elliptical beam/38W/IP67	 UL1	Ground recessed RGBW uplighter RGBW/19.8W/m/IP67
 L1	Tunable white linear LED 2100K-4400K/12W/m/IP67		

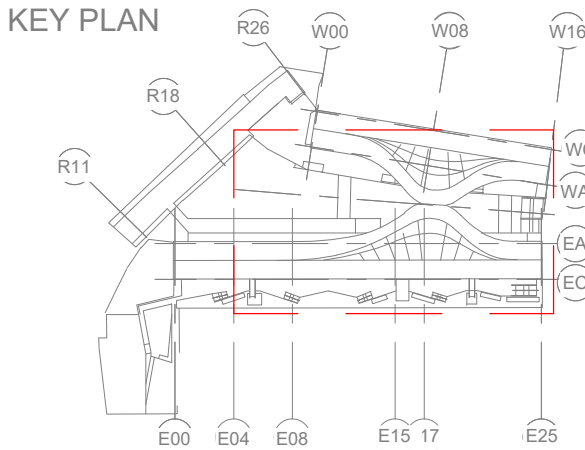

Date	Rev	Description
------	-----	-------------


Notes

Important Note

Where Dimensions are not given, drawings must not be scaled.



For complete luminaire breakdown refer to schedules

In the event of conflict between this drawing and lead consultants drawing the matter must be referred prior to proceeding

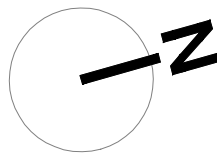

CLIENT	Argent	
PROJECT	CDY - Gateways	PROJECT NO. 0203
STATUS	FOR PLANNING	
SCALE	Scale 1:200@A1 Scale 1:400@A3	DATE 18/01/2023
TITLE	CDY - Lighting Plan	
DRAWING NO.	0203-201	REVISION -

LEGEND	
TYPE	DESCRIPTION
L1	Flexible tunable white linear LED 12W/2100K-4400K/IP66

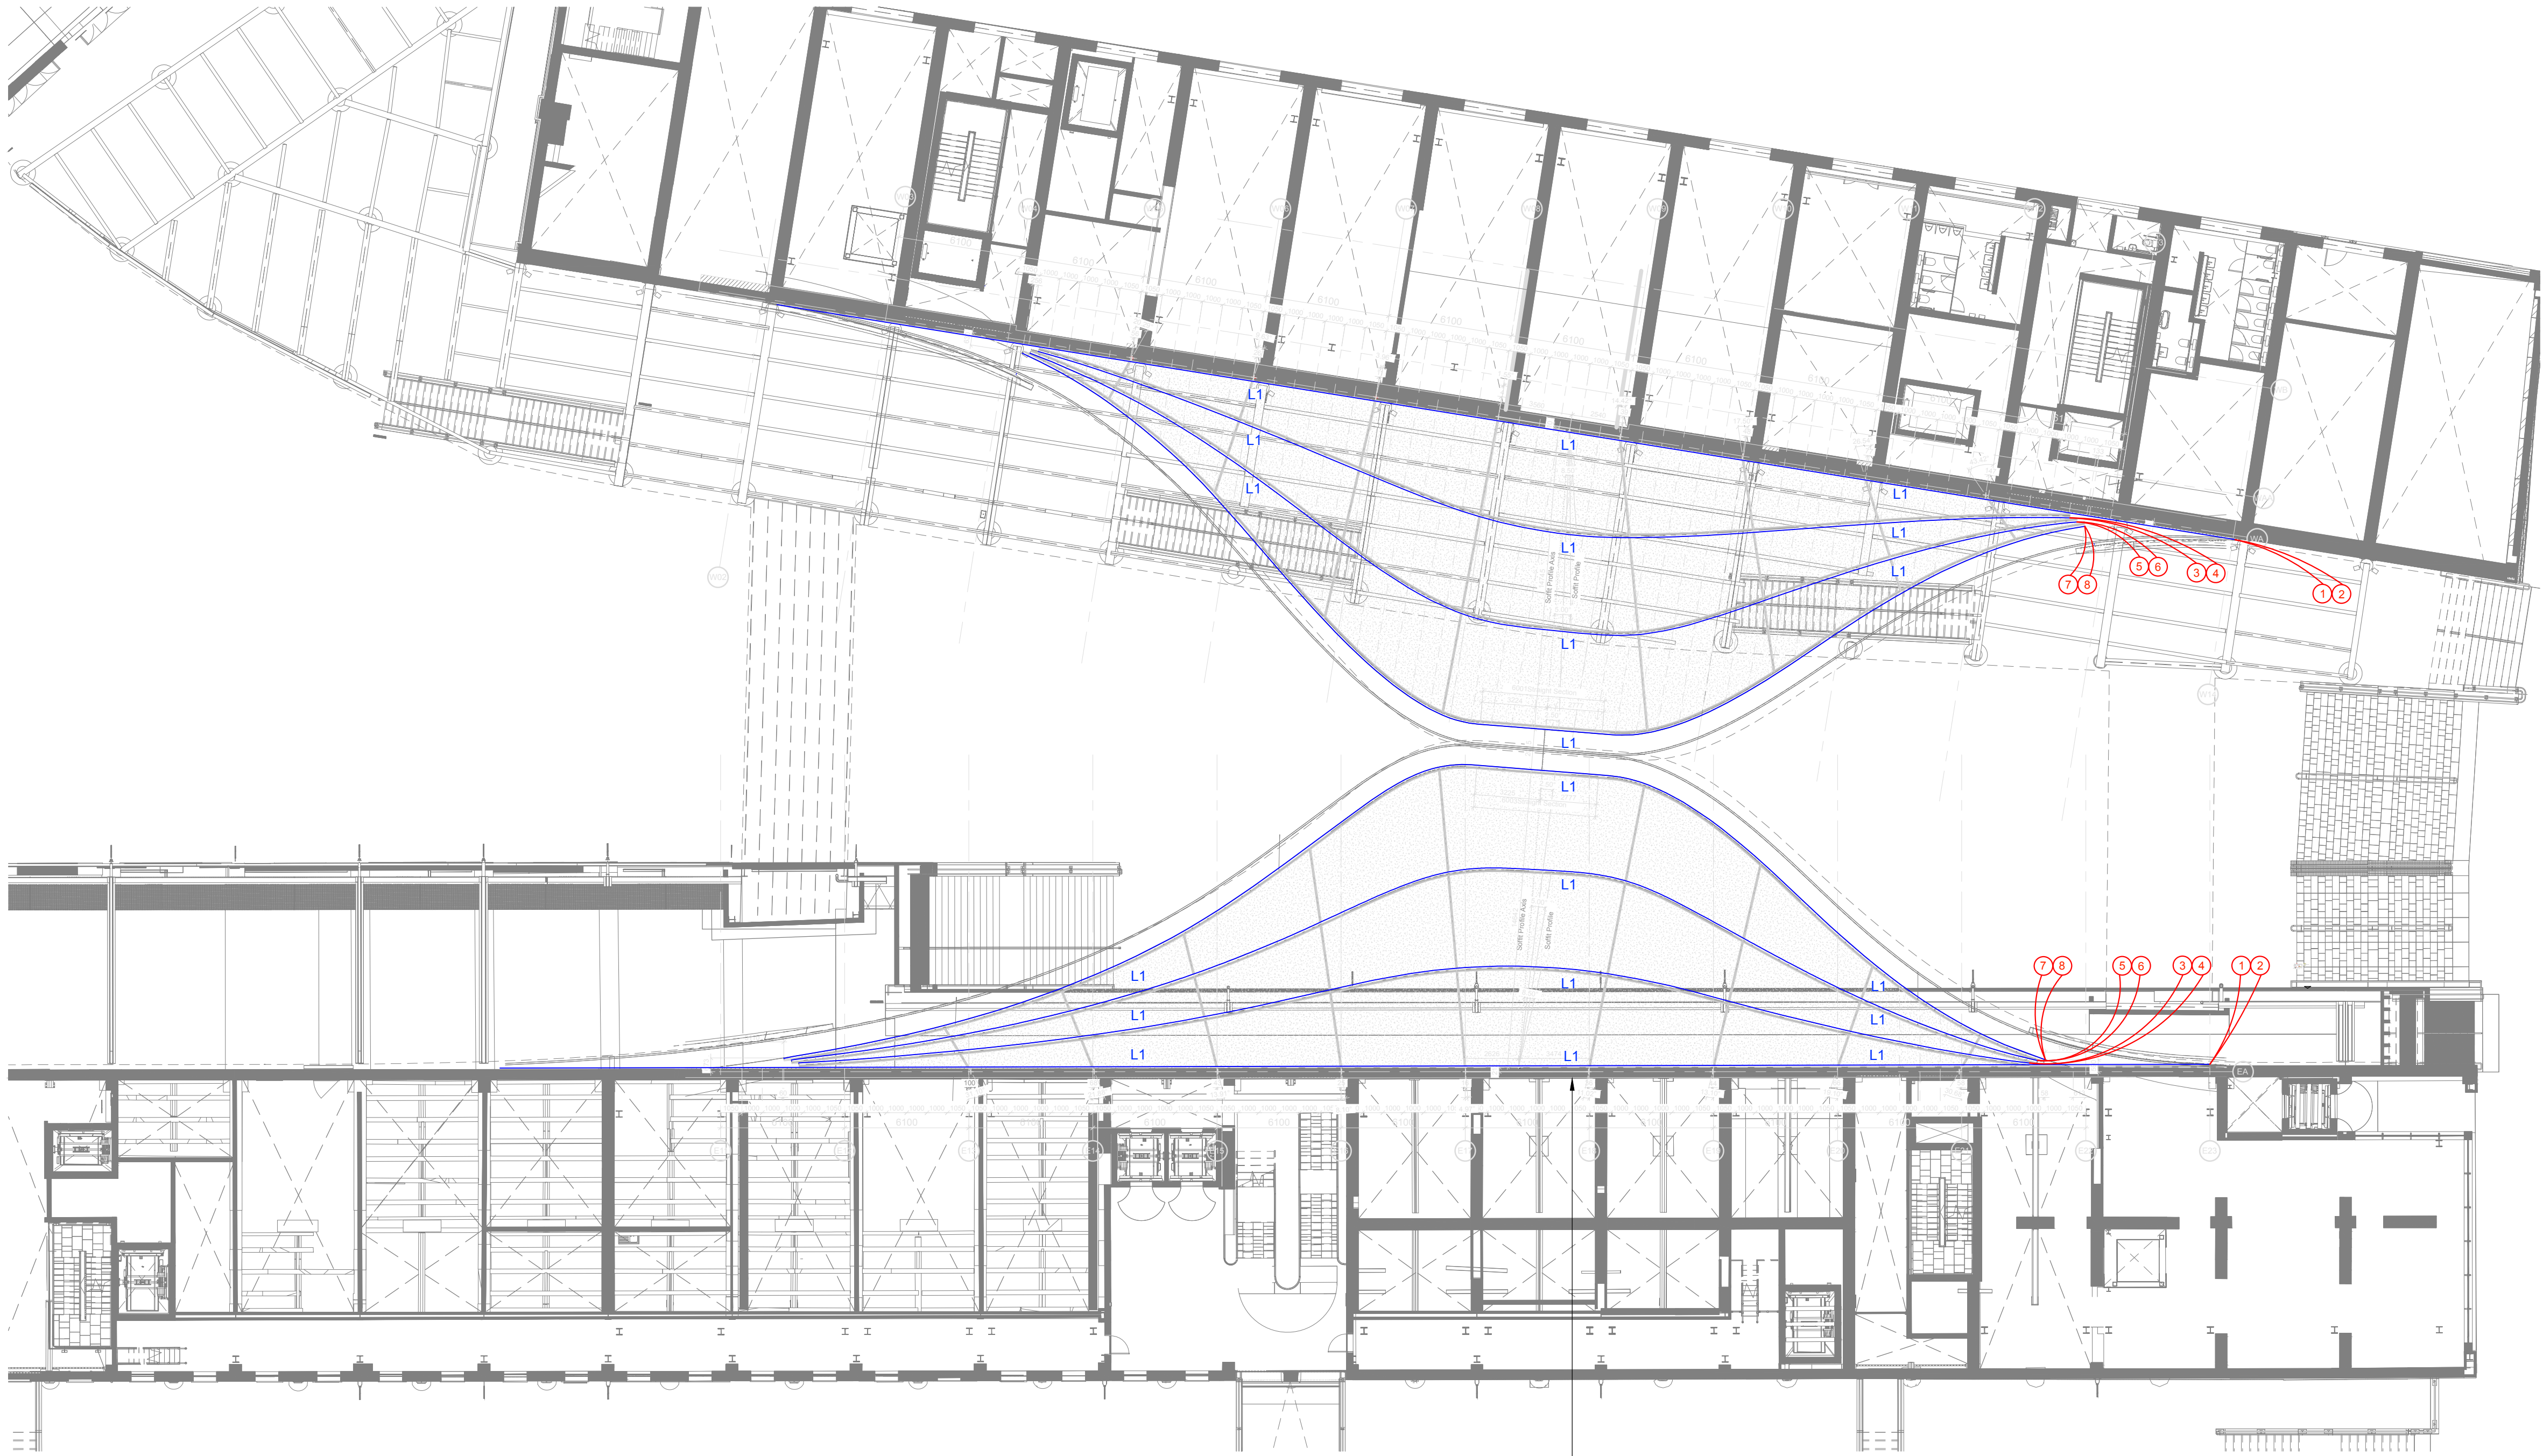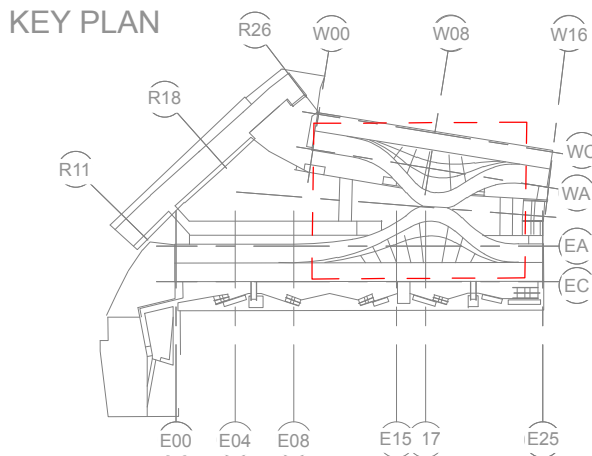

Kissing Roof - Lighting Control Channels
Scale 1:200@ A1

L1 - Flexible linear LED to illuminate
underside of the kissing roof



24.03.2023 - For Planning

Date	Rev	Description
------	-----	-------------


Notes

Important Note

Where Dimensions are not given, drawings must not be scaled.


For complete luminaire breakdown refer to schedules

In the event of conflict between this drawing and lead consultants drawing the matter must be referred prior to proceeding

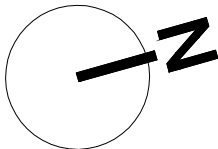


CLIENT	Argent
PROJECT	CDY - Gateways
PROJECT NO.	0204
STATUS	FOR PLANNING
SCALE	Scale 1:200@A1 Scale 1:400@A3
DATE	18/01/2023
TITLE	Kissing Roof - Lighting Control Channels
DRAWING NO.	0203- 801
REVISION	-

LEGEND	
TYPE	DESCRIPTION
 FL1	RGBW floodlight Elliptical beam/38W/IP67

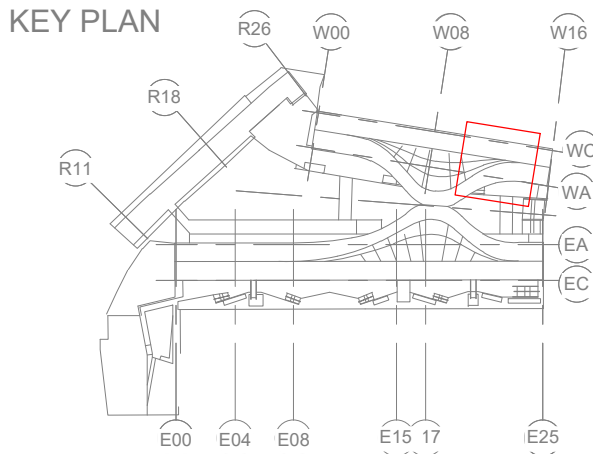


CONTINUATION ON DRAWING 0203-802

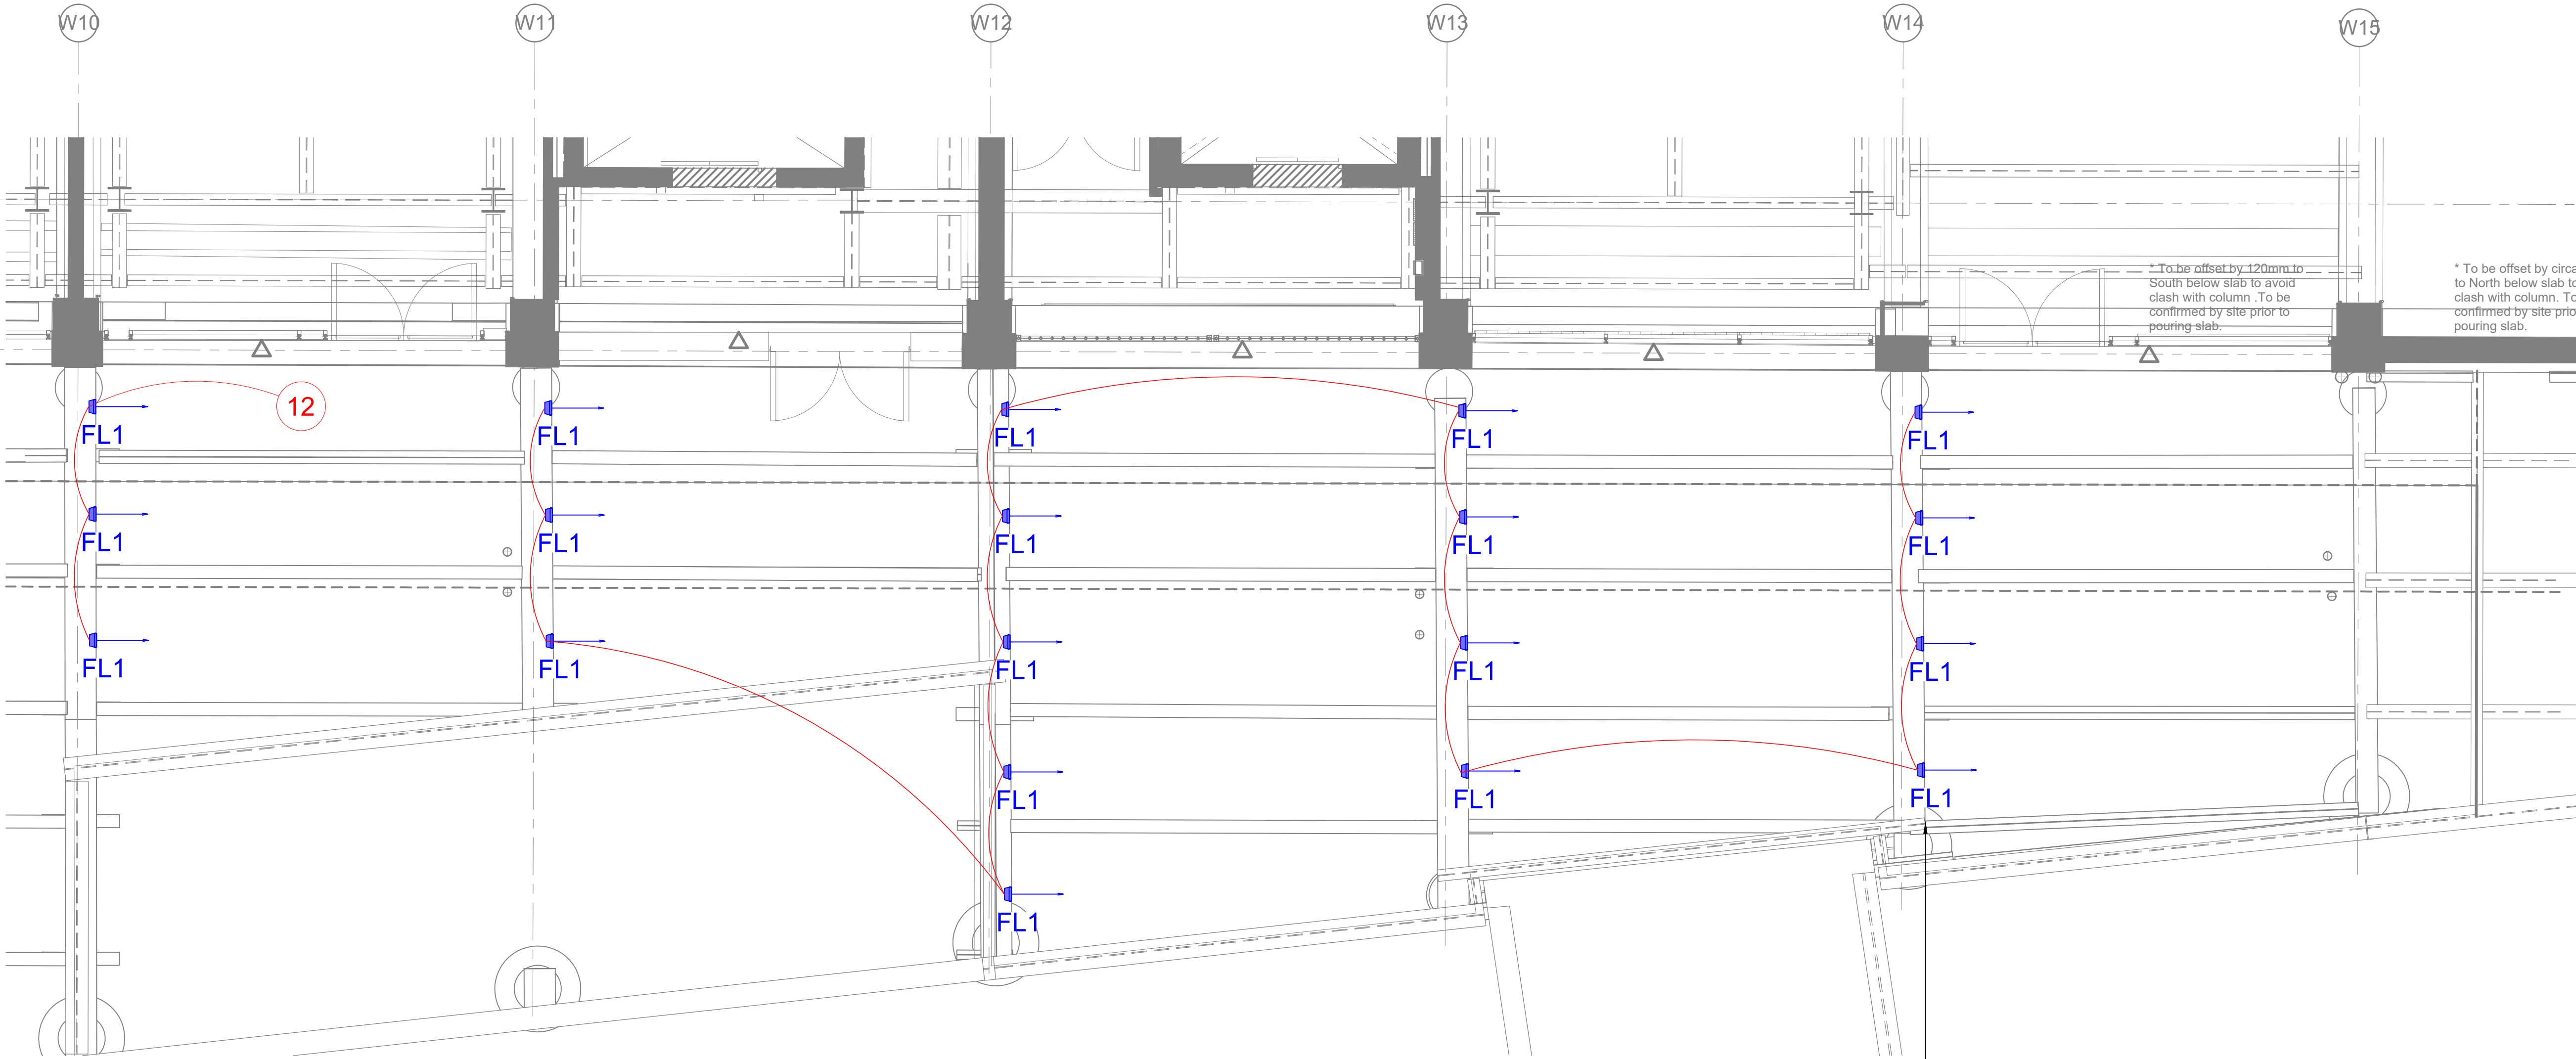

GF VIADUCT LEVEL - 01
Scale 1:50@ A1

FL1- RGBW flood light to
light underside of the bridge

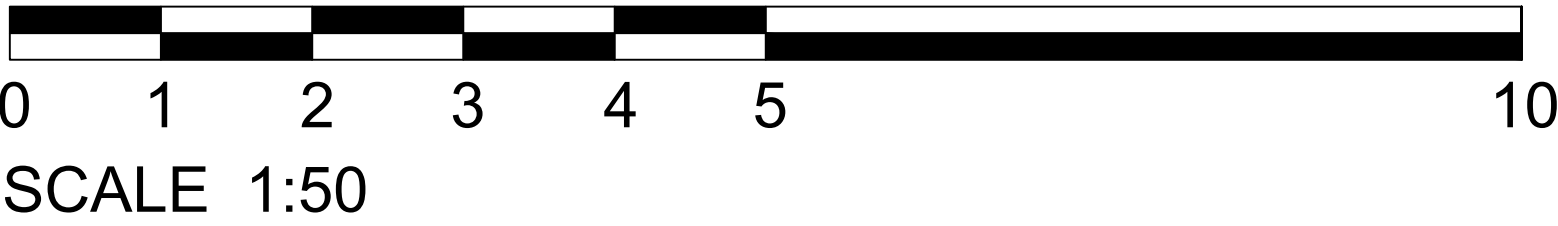

Studio 29 The Boathouse,
1A Putney Embankment, London SW15 1LB
t: 020 8780 9006 w: studio29lighting.com

24.03.2023 - For Planning

Date	Rev	Description
------	-----	-------------


Notes

Important Note


Where Dimensions are not given, drawings must not be scaled.



For complete luminaire breakdown refer to schedules

In the event of conflict between this drawing and lead consultants drawing the matter must be referred prior to proceeding

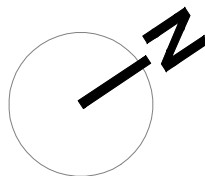


CLIENT	Argent	
PROJECT	CDY - Gateways	PROJECT NO. 0203
STATUS	FOR PLANNING	
SCALE	Scale 1:50@A1	DATE 18/01/2023
	Scale 1:100@A3	
TITLE	GF Viaduct Level - 01 - Lighting Control Channels	
DRAWING NO.	0203-802	REVISION -

 LEGEND	
TYPE	DESCRIPTION
 FL1	RGBW floodlight Elliptical beam/38W/IP67

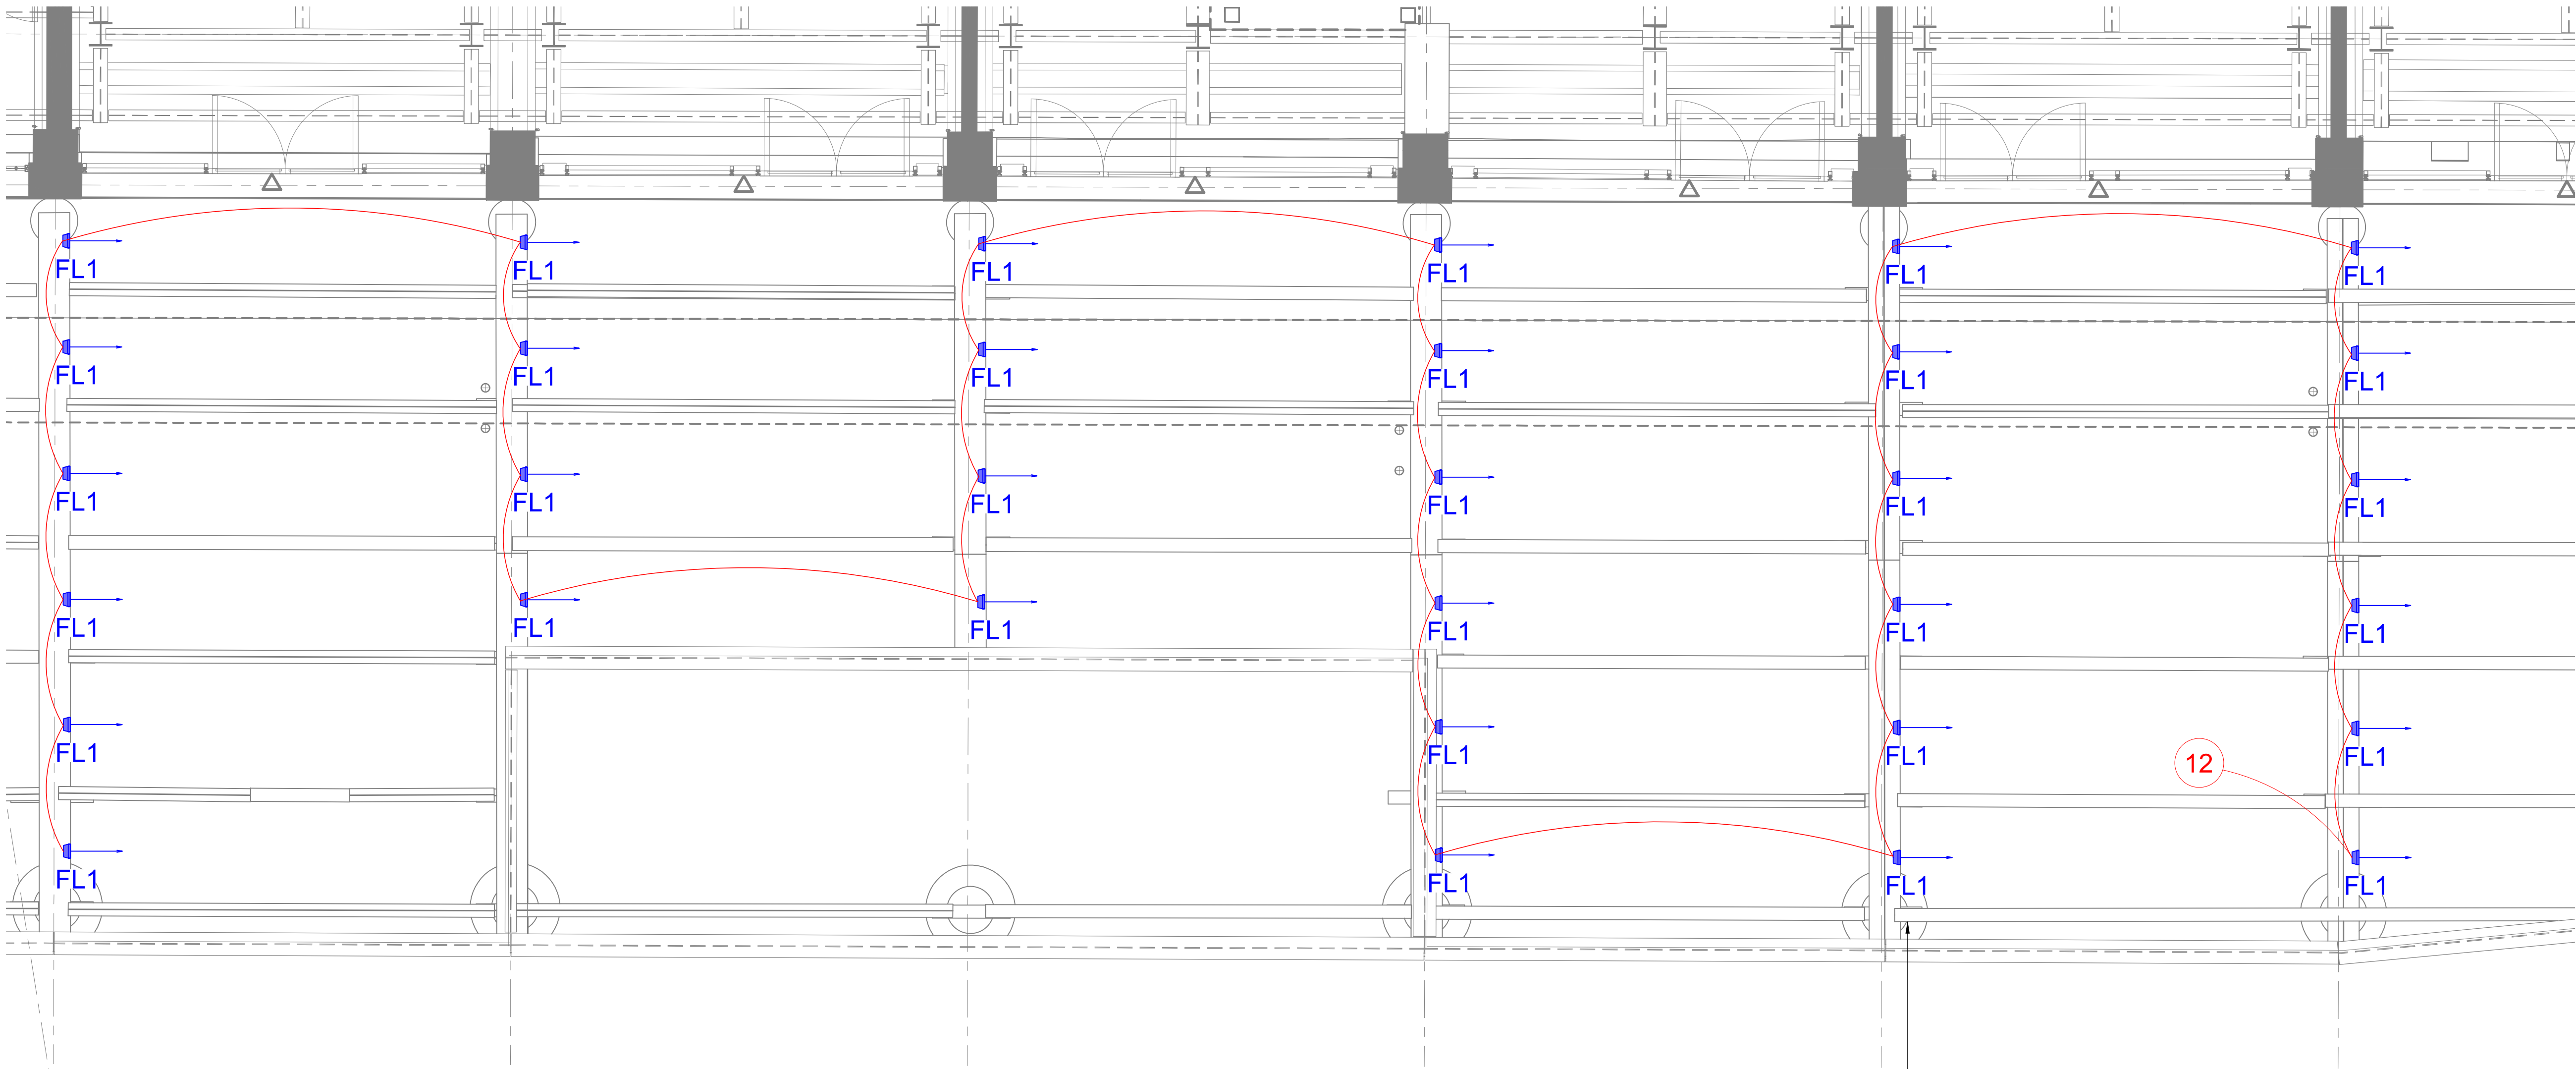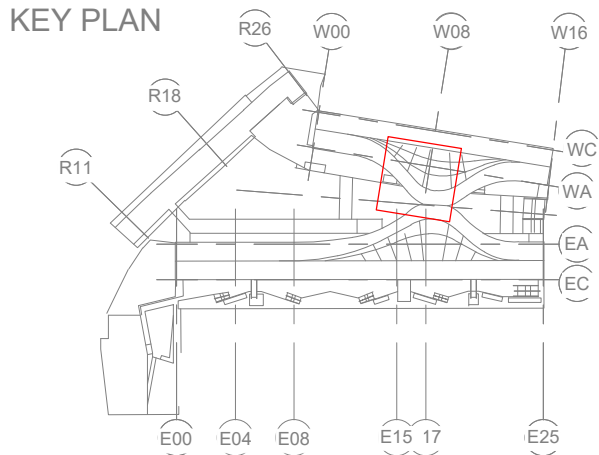

GF VIADUCT LEVEL - 02
Scale 1:50@ A1

FL1- RGBW flood light to
light underside of the bridge

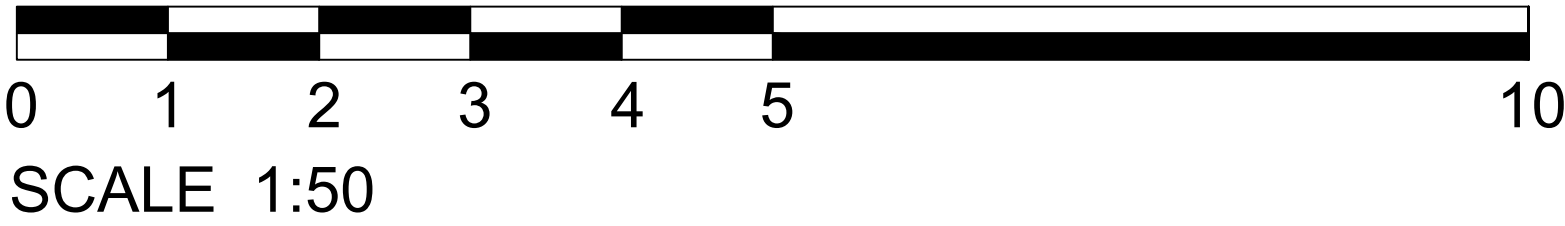

24.03.2023 - For Planning

Date	Rev	Description
------	-----	-------------


Notes

Important Note


Where Dimensions are not given, drawings must not be scaled.



For complete luminaire breakdown refer to schedules

In the event of conflict between this drawing and lead consultants drawing the matter must be referred prior to proceeding

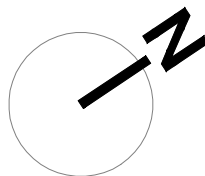


CLIENT	Argent
PROJECT	CDY - Gateways
PROJECT NO.	0203
STATUS	FOR PLANNING
SCALE	Scale 1:50@A1
DATE	18/01/2023
SCALE	Scale 1:100@A3
TITLE	GF Viaduct Level - 02 Lighting Control Channels
DRAWING NO.	0203-803
REVISION	-

 LEGEND	
TYPE	DESCRIPTION
 FL1	RGBW floodlight Elliptical beam/38W/IP67

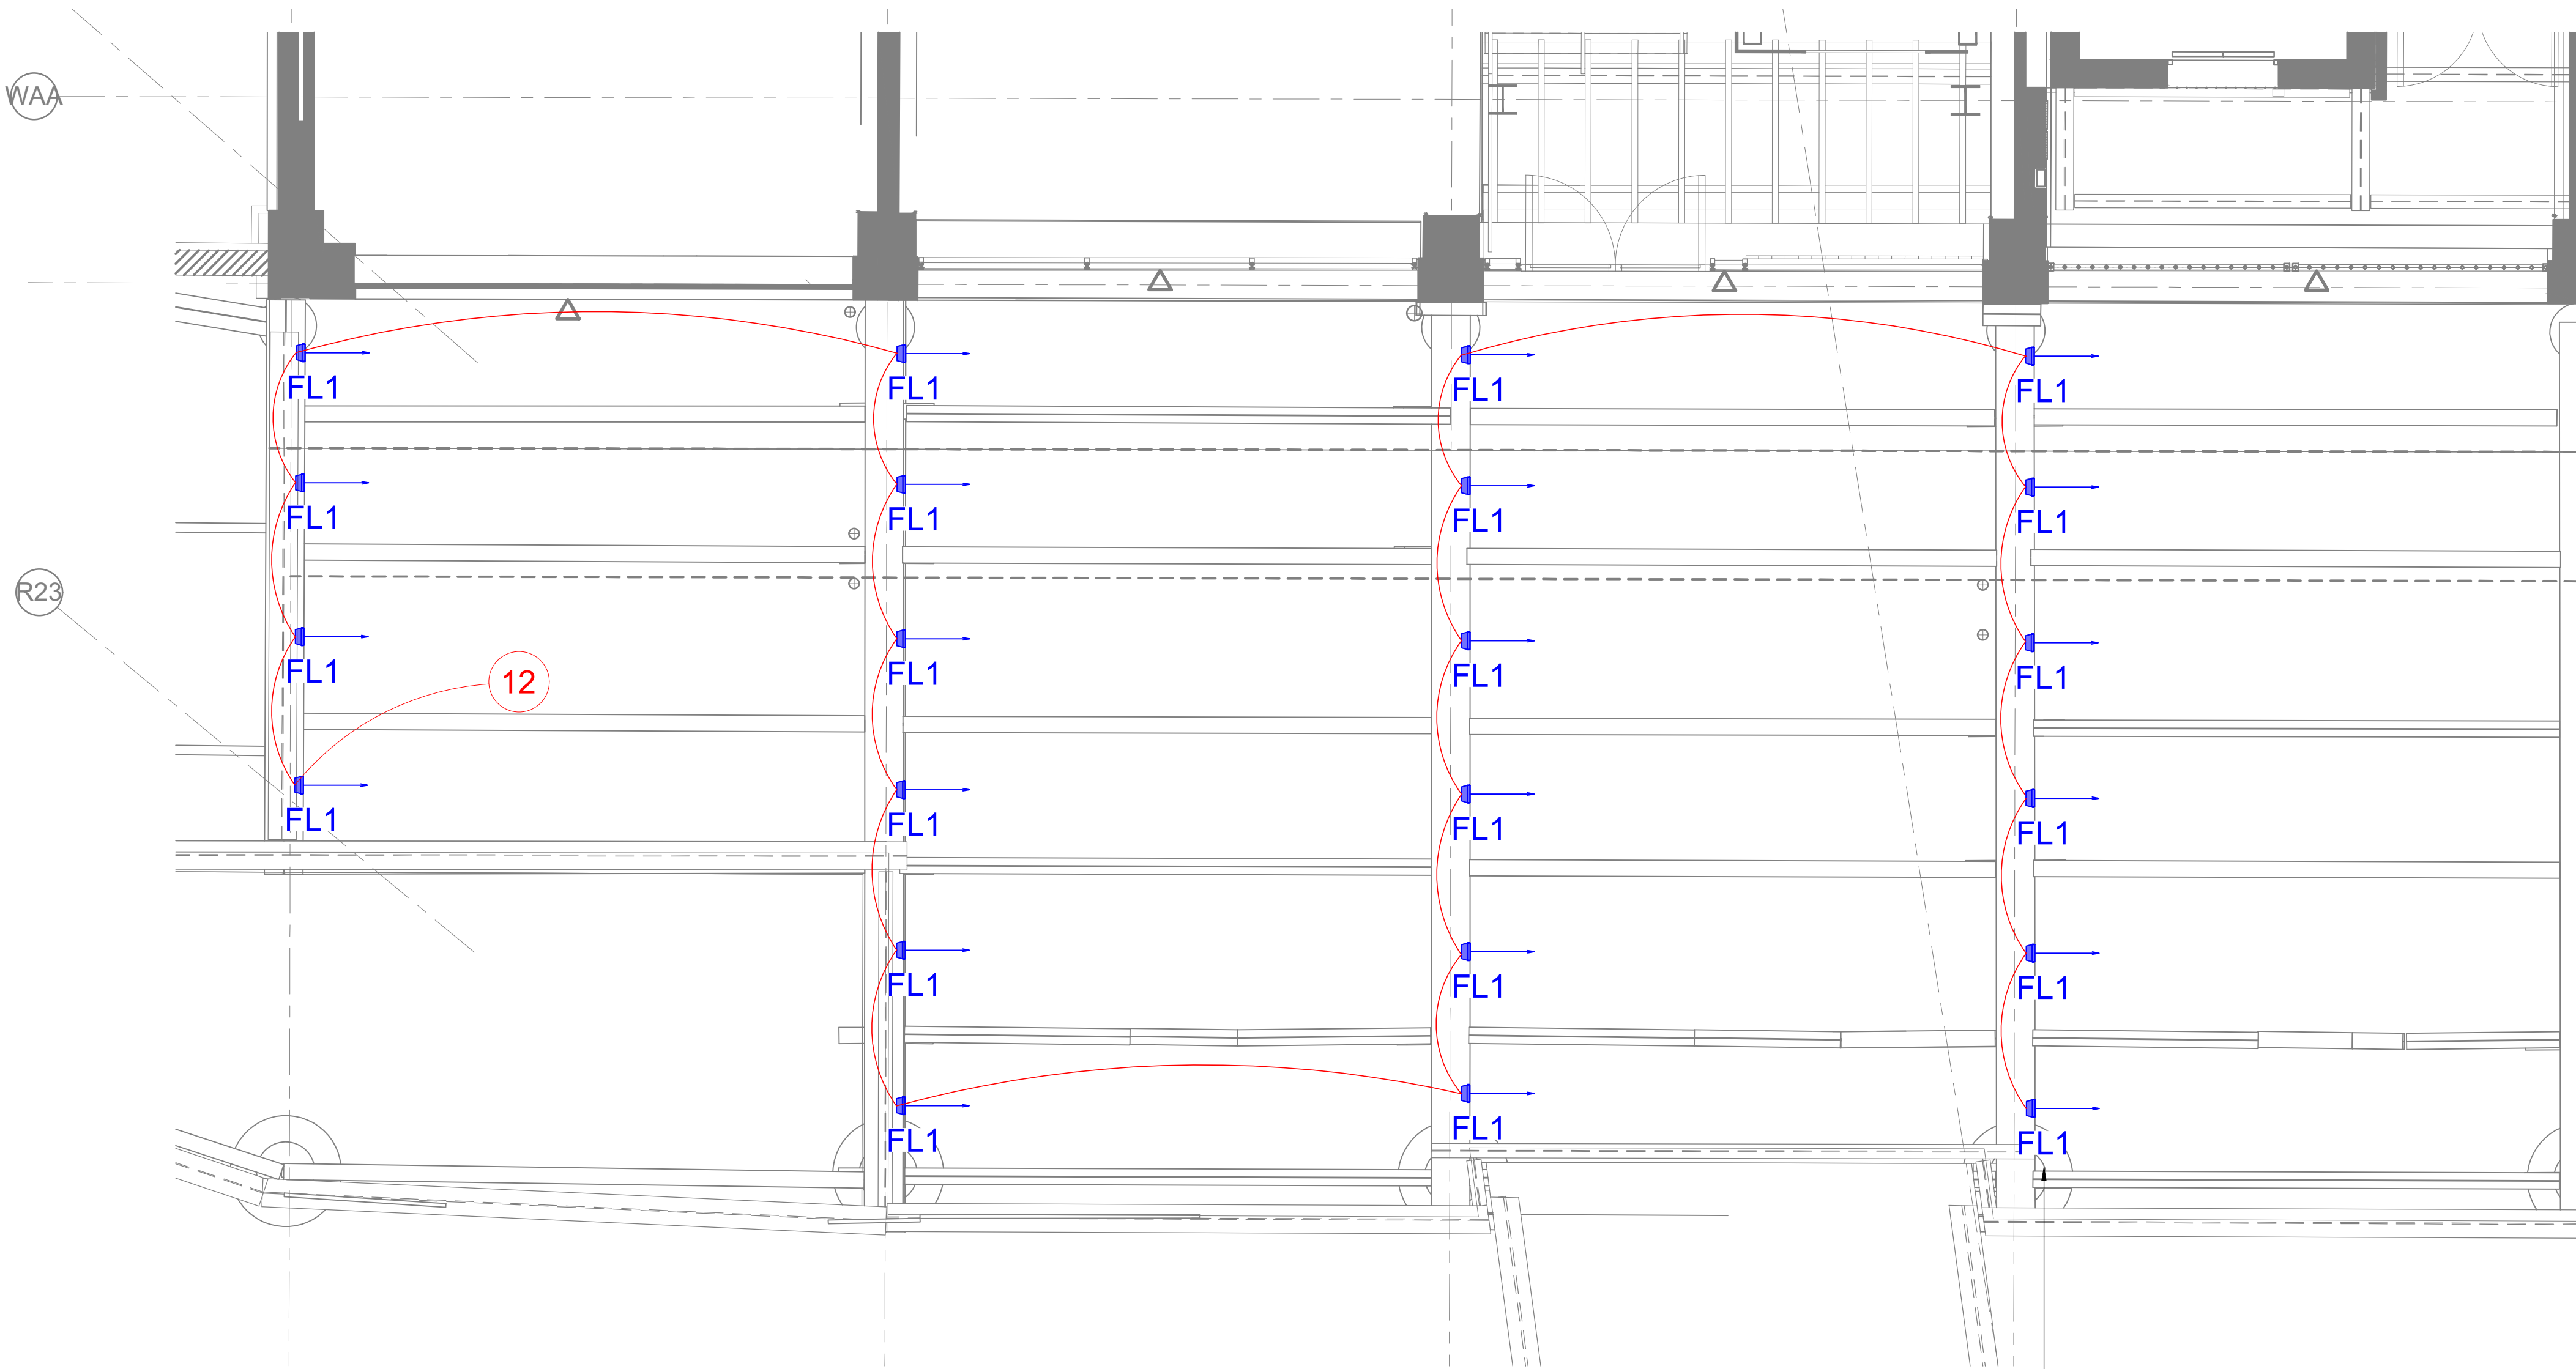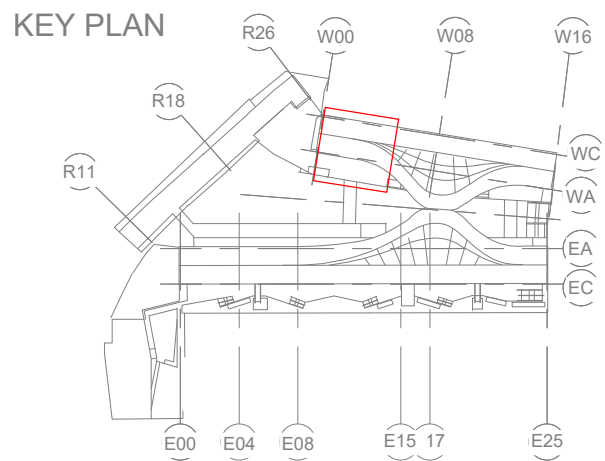

GF VIADUCT LEVEL - 03
Scale 1:50@ A1

FL1- RGBW flood light to
light underside of the bridge

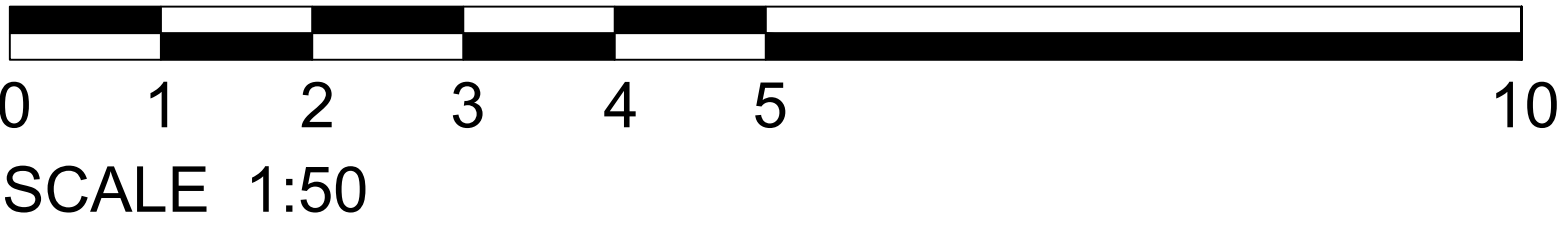



Studio 29 The Boathouse,
1A Putney Embankment, London SW15 1LB
t: 020 8780 9006 w: studio29lighting.com

24.03.2023	-	For Planning
Date	Rev	Description


Notes

Important Note


Where Dimensions are not given, drawings must not be scaled.


For complete luminaire breakdown refer to schedules

In the event of conflict between this drawing and lead consultants drawing the matter must be referred prior to proceeding

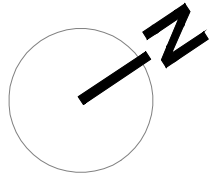


CLIENT	Argent	
PROJECT	CDY - Gateways	PROJECT NO. 0203
STATUS	FOR PLANNING	
SCALE	Scale 1:50@A1 Scale 1:100@A3	DATE 18/01/2023
TITLE	GF Viaduct Level - 03 - Lighting Control Channels	
DRAWING NO.	0203-804	REVISION -

 LEGEND	
TYPE	DESCRIPTION
 L2	Tunable white linear LED 2100K-4400K/12W/m/IP67
 UL1	Ground recessed RGBW uplighter RGBW/19.8W/m/IP67

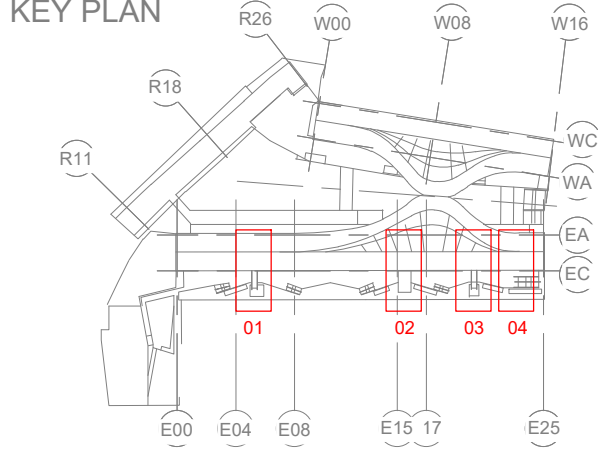


L2 - Linear RGBW fitting to graze the wall


UL1 - Ground recessed RGBW uplighter both sides of the arched doorways,
UL1 in all entrances in both East and West wings to be located on same control channel

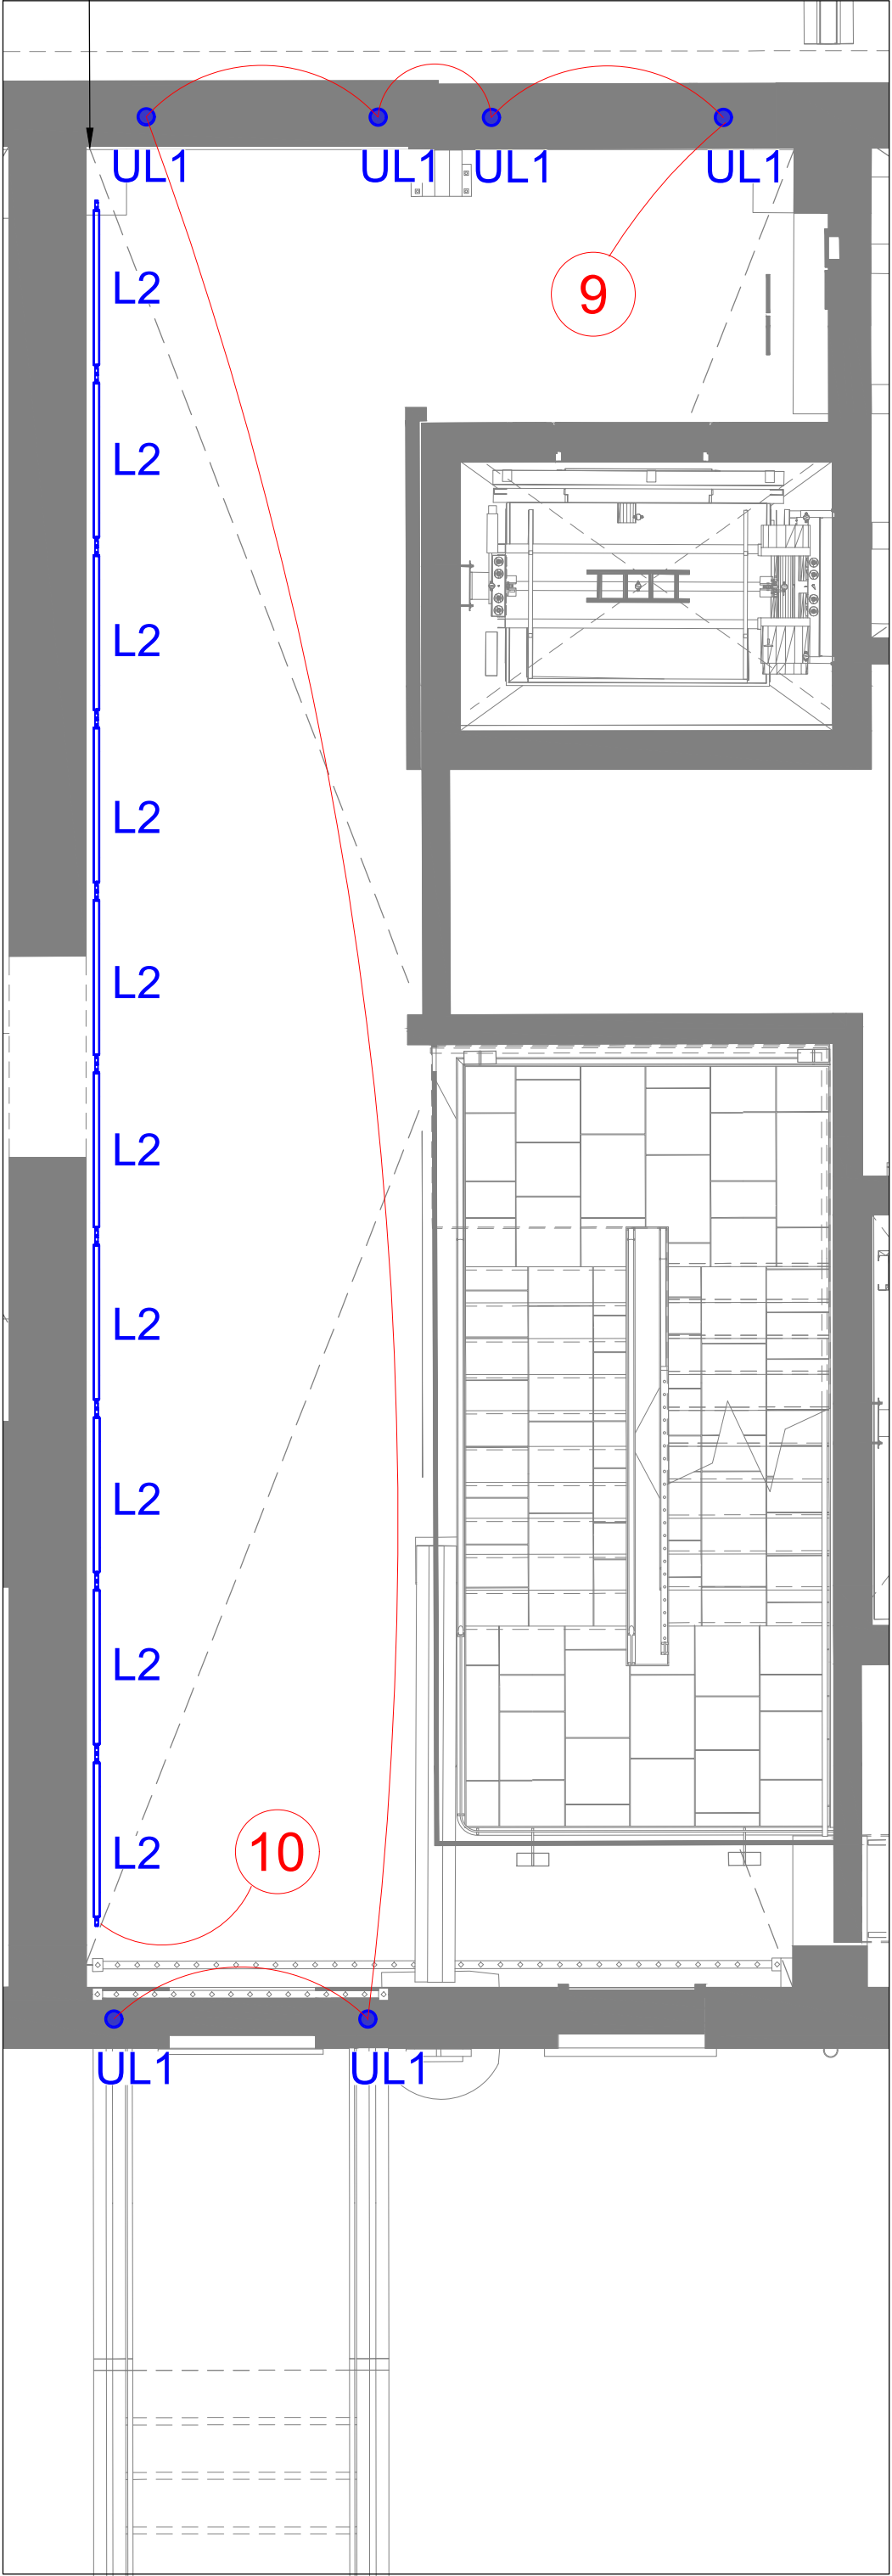


EAST WING ENTRANCE - 01
Scale 1:50@ A1

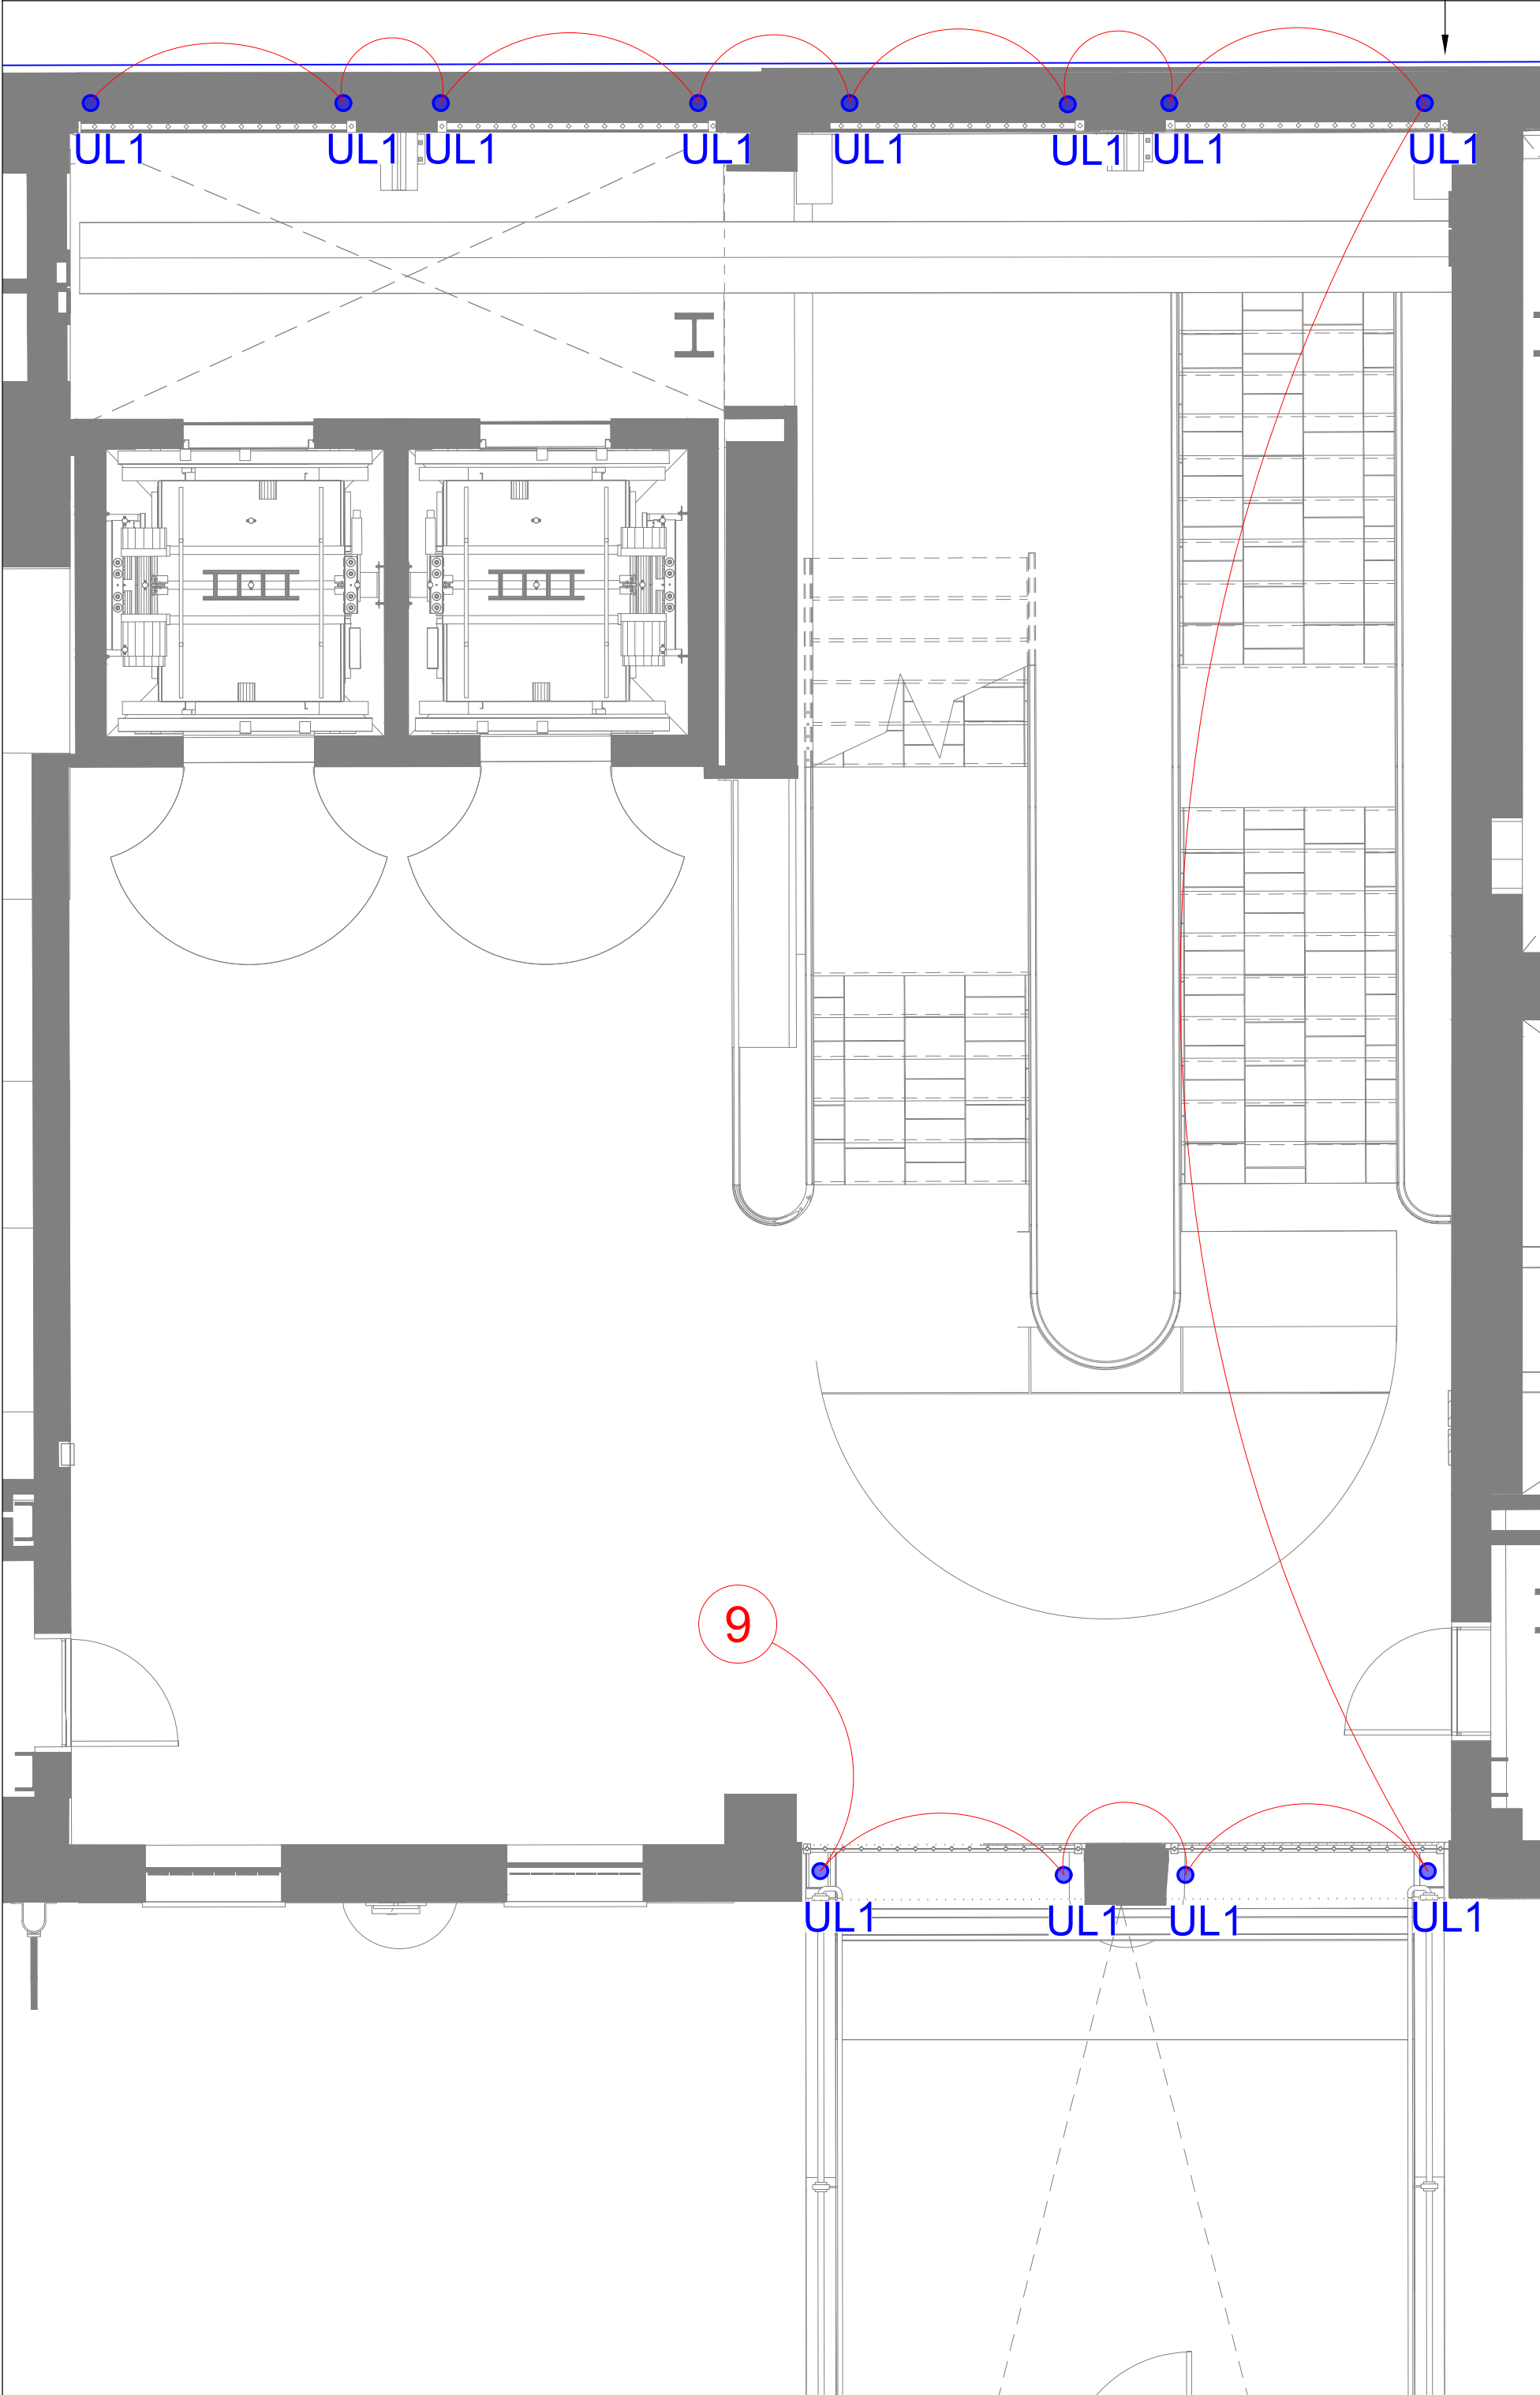


EAST WING ENTRANCE - 02
Scale 1:50@ A1

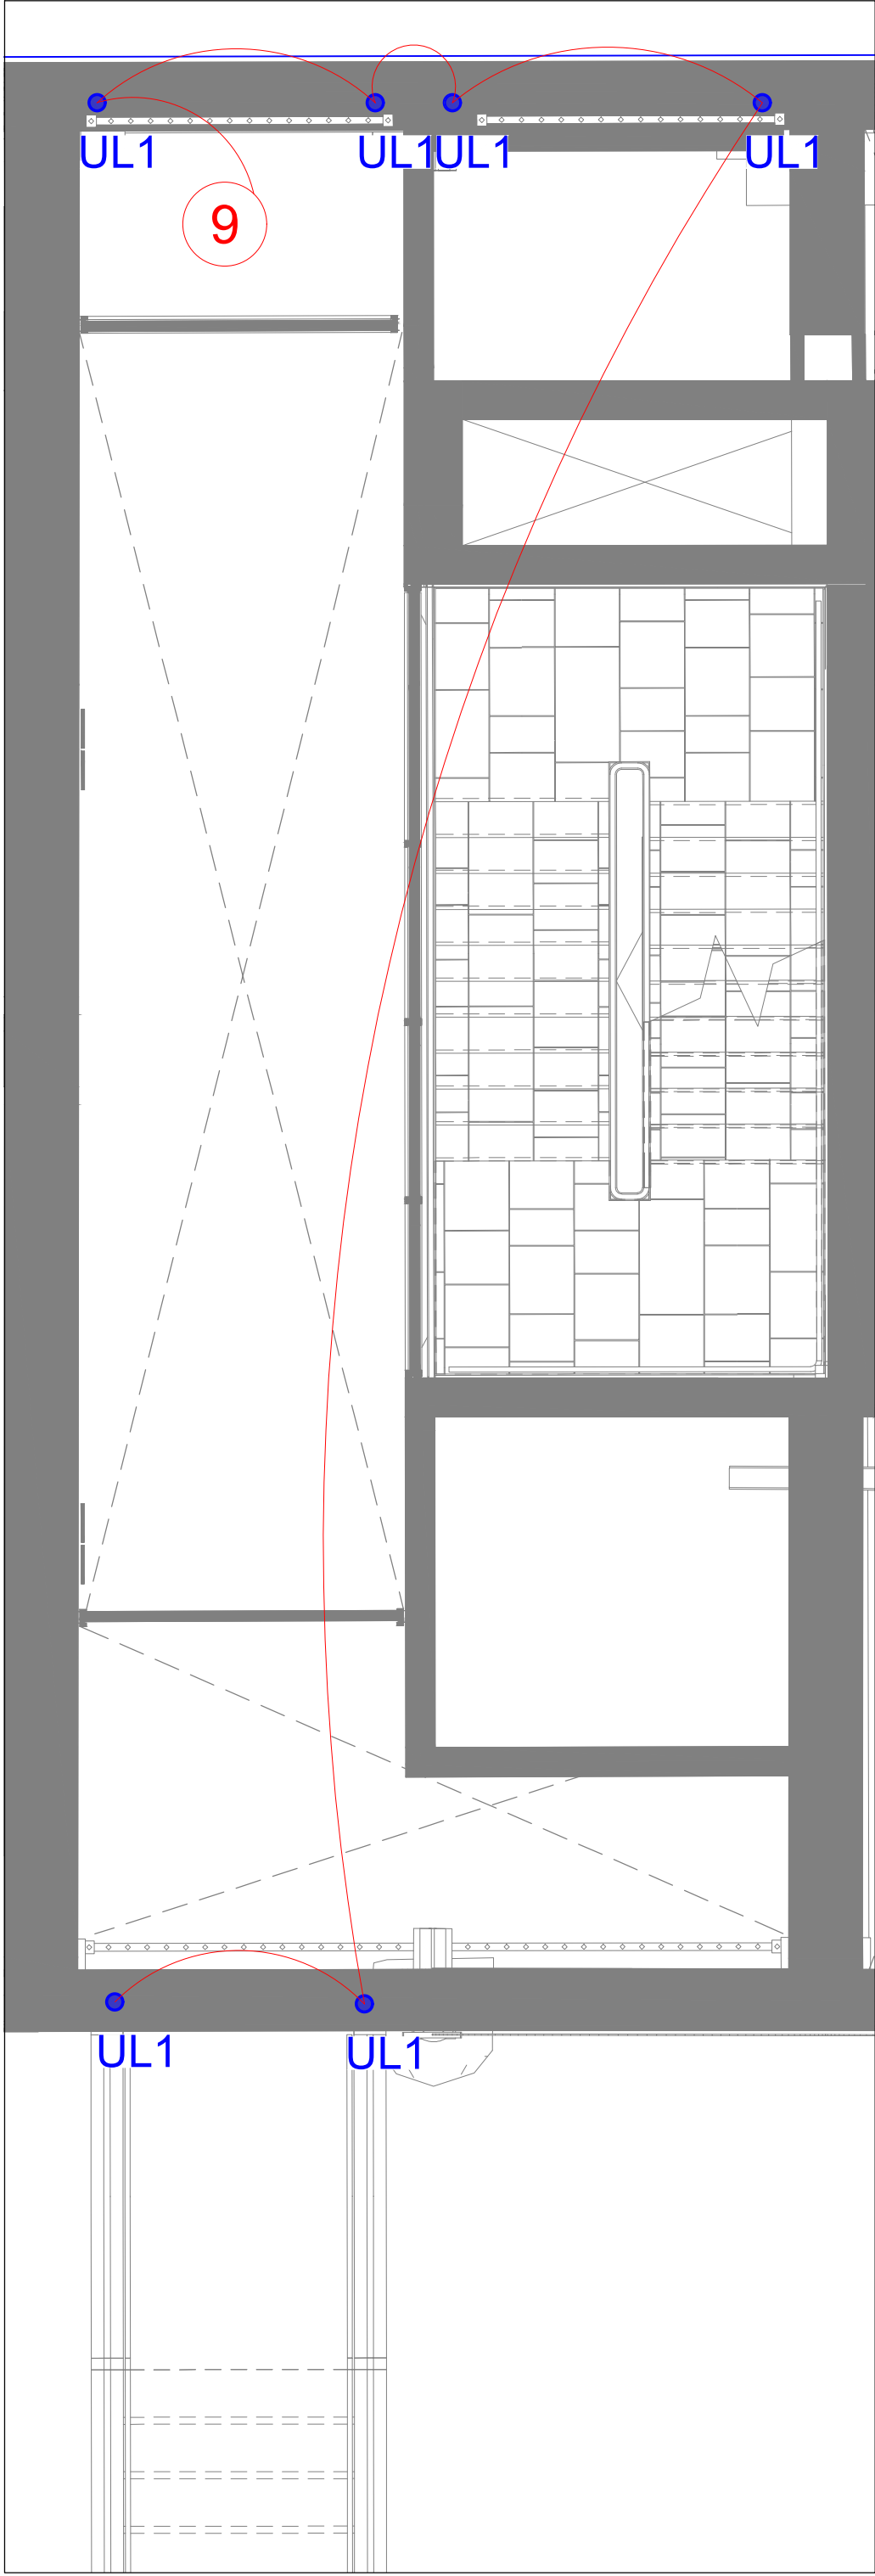

EAST WING ENTRANCE - 03
Scale 1:50@ A1

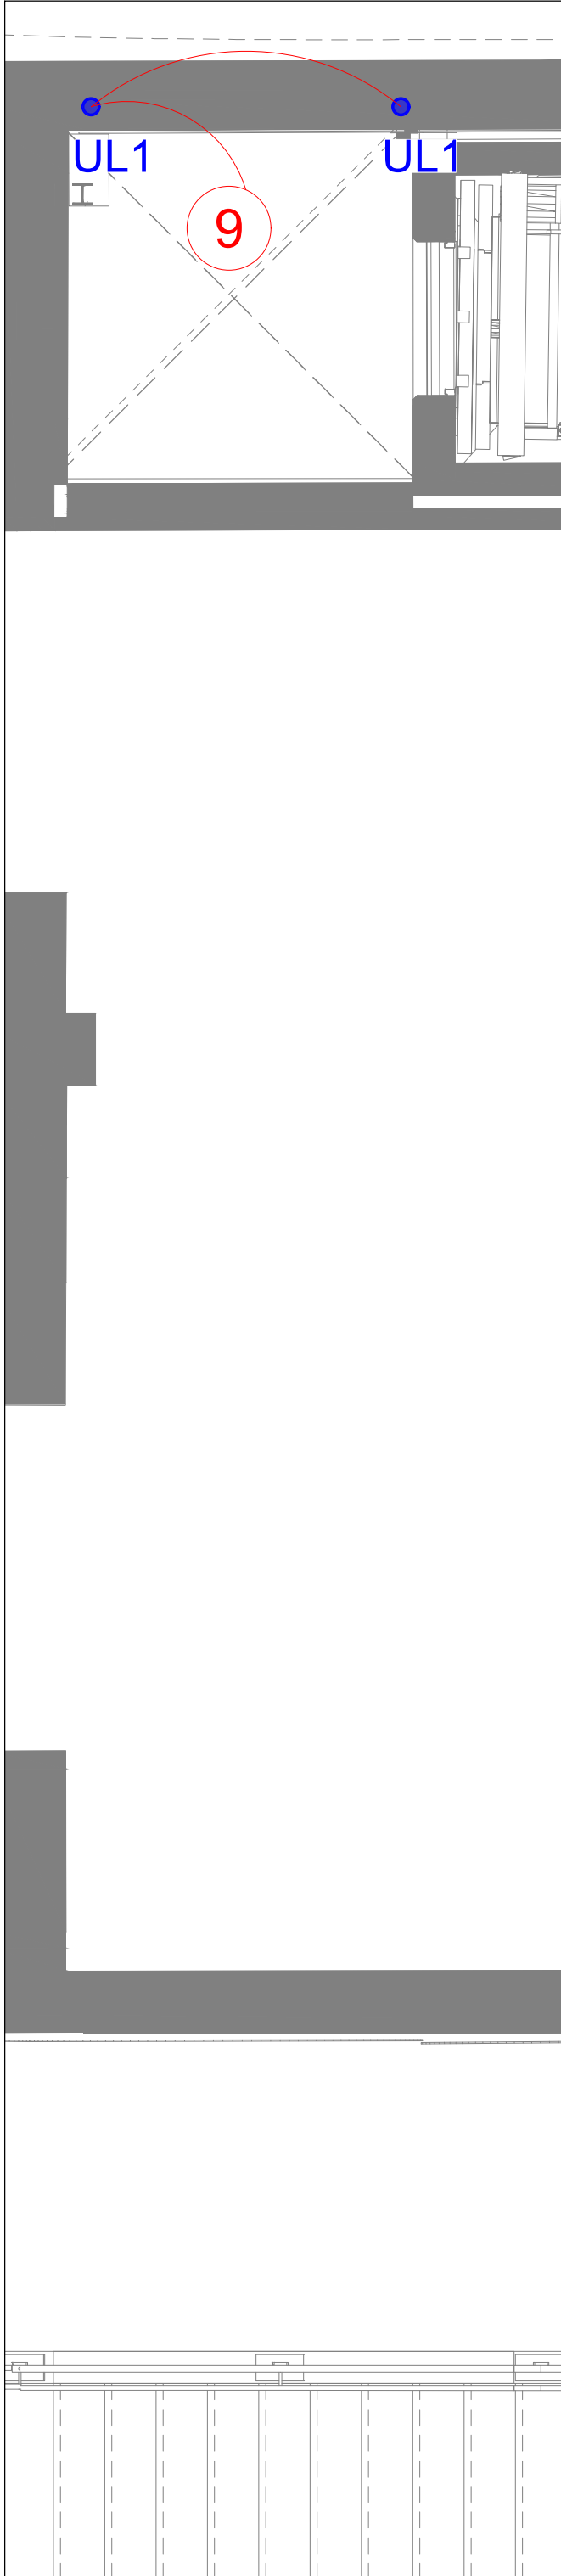

EAST WING ENTRANCE - 04
Scale 1:50@ A1

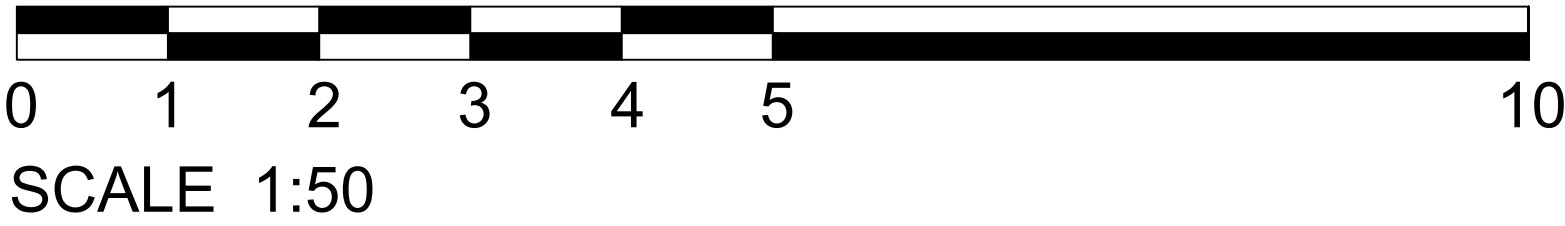

24.03.2023 - For Planning

Date	Rev	Description
------	-----	-------------


Notes

Important Note

Where Dimensions are not given, drawings must not be scaled.


For complete luminaire breakdown refer to schedules

In the event of conflict between this drawing and lead consultants drawing the matter must be referred prior to proceeding

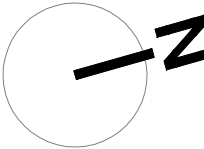


CLIENT	Argent	
PROJECT	CDY - Gateways	PROJECT NO. 0203
STATUS	FOR PLANNING	
SCALE	Scale 1:50@A1	DATE 18/01/2023
	Scale 1:100@A3	
TITLE	East Wing Entrances 01,02,03,04 - Lighting Control Channels	
DRAWING NO.	0203-805	REVISION -


LEGEND	
TYPE	DESCRIPTION
● UL1	Ground recessed RGBW uplighter RGBW/19.8W/m/IP67

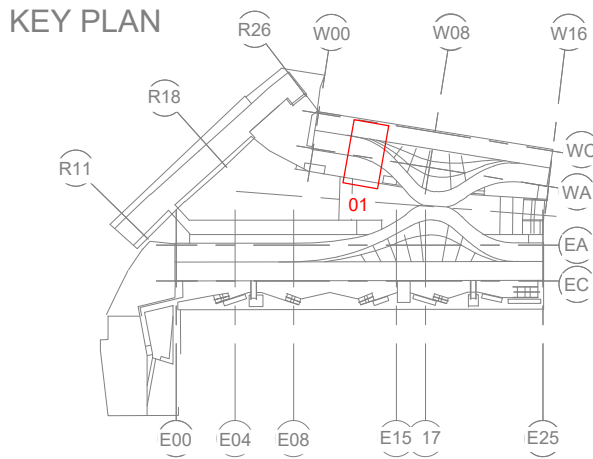

UL1 - Ground recessed RGBW uplighter both
sides of the arched doorways,
UL1 in all entrances in both East and West wings
to be located on same control channel

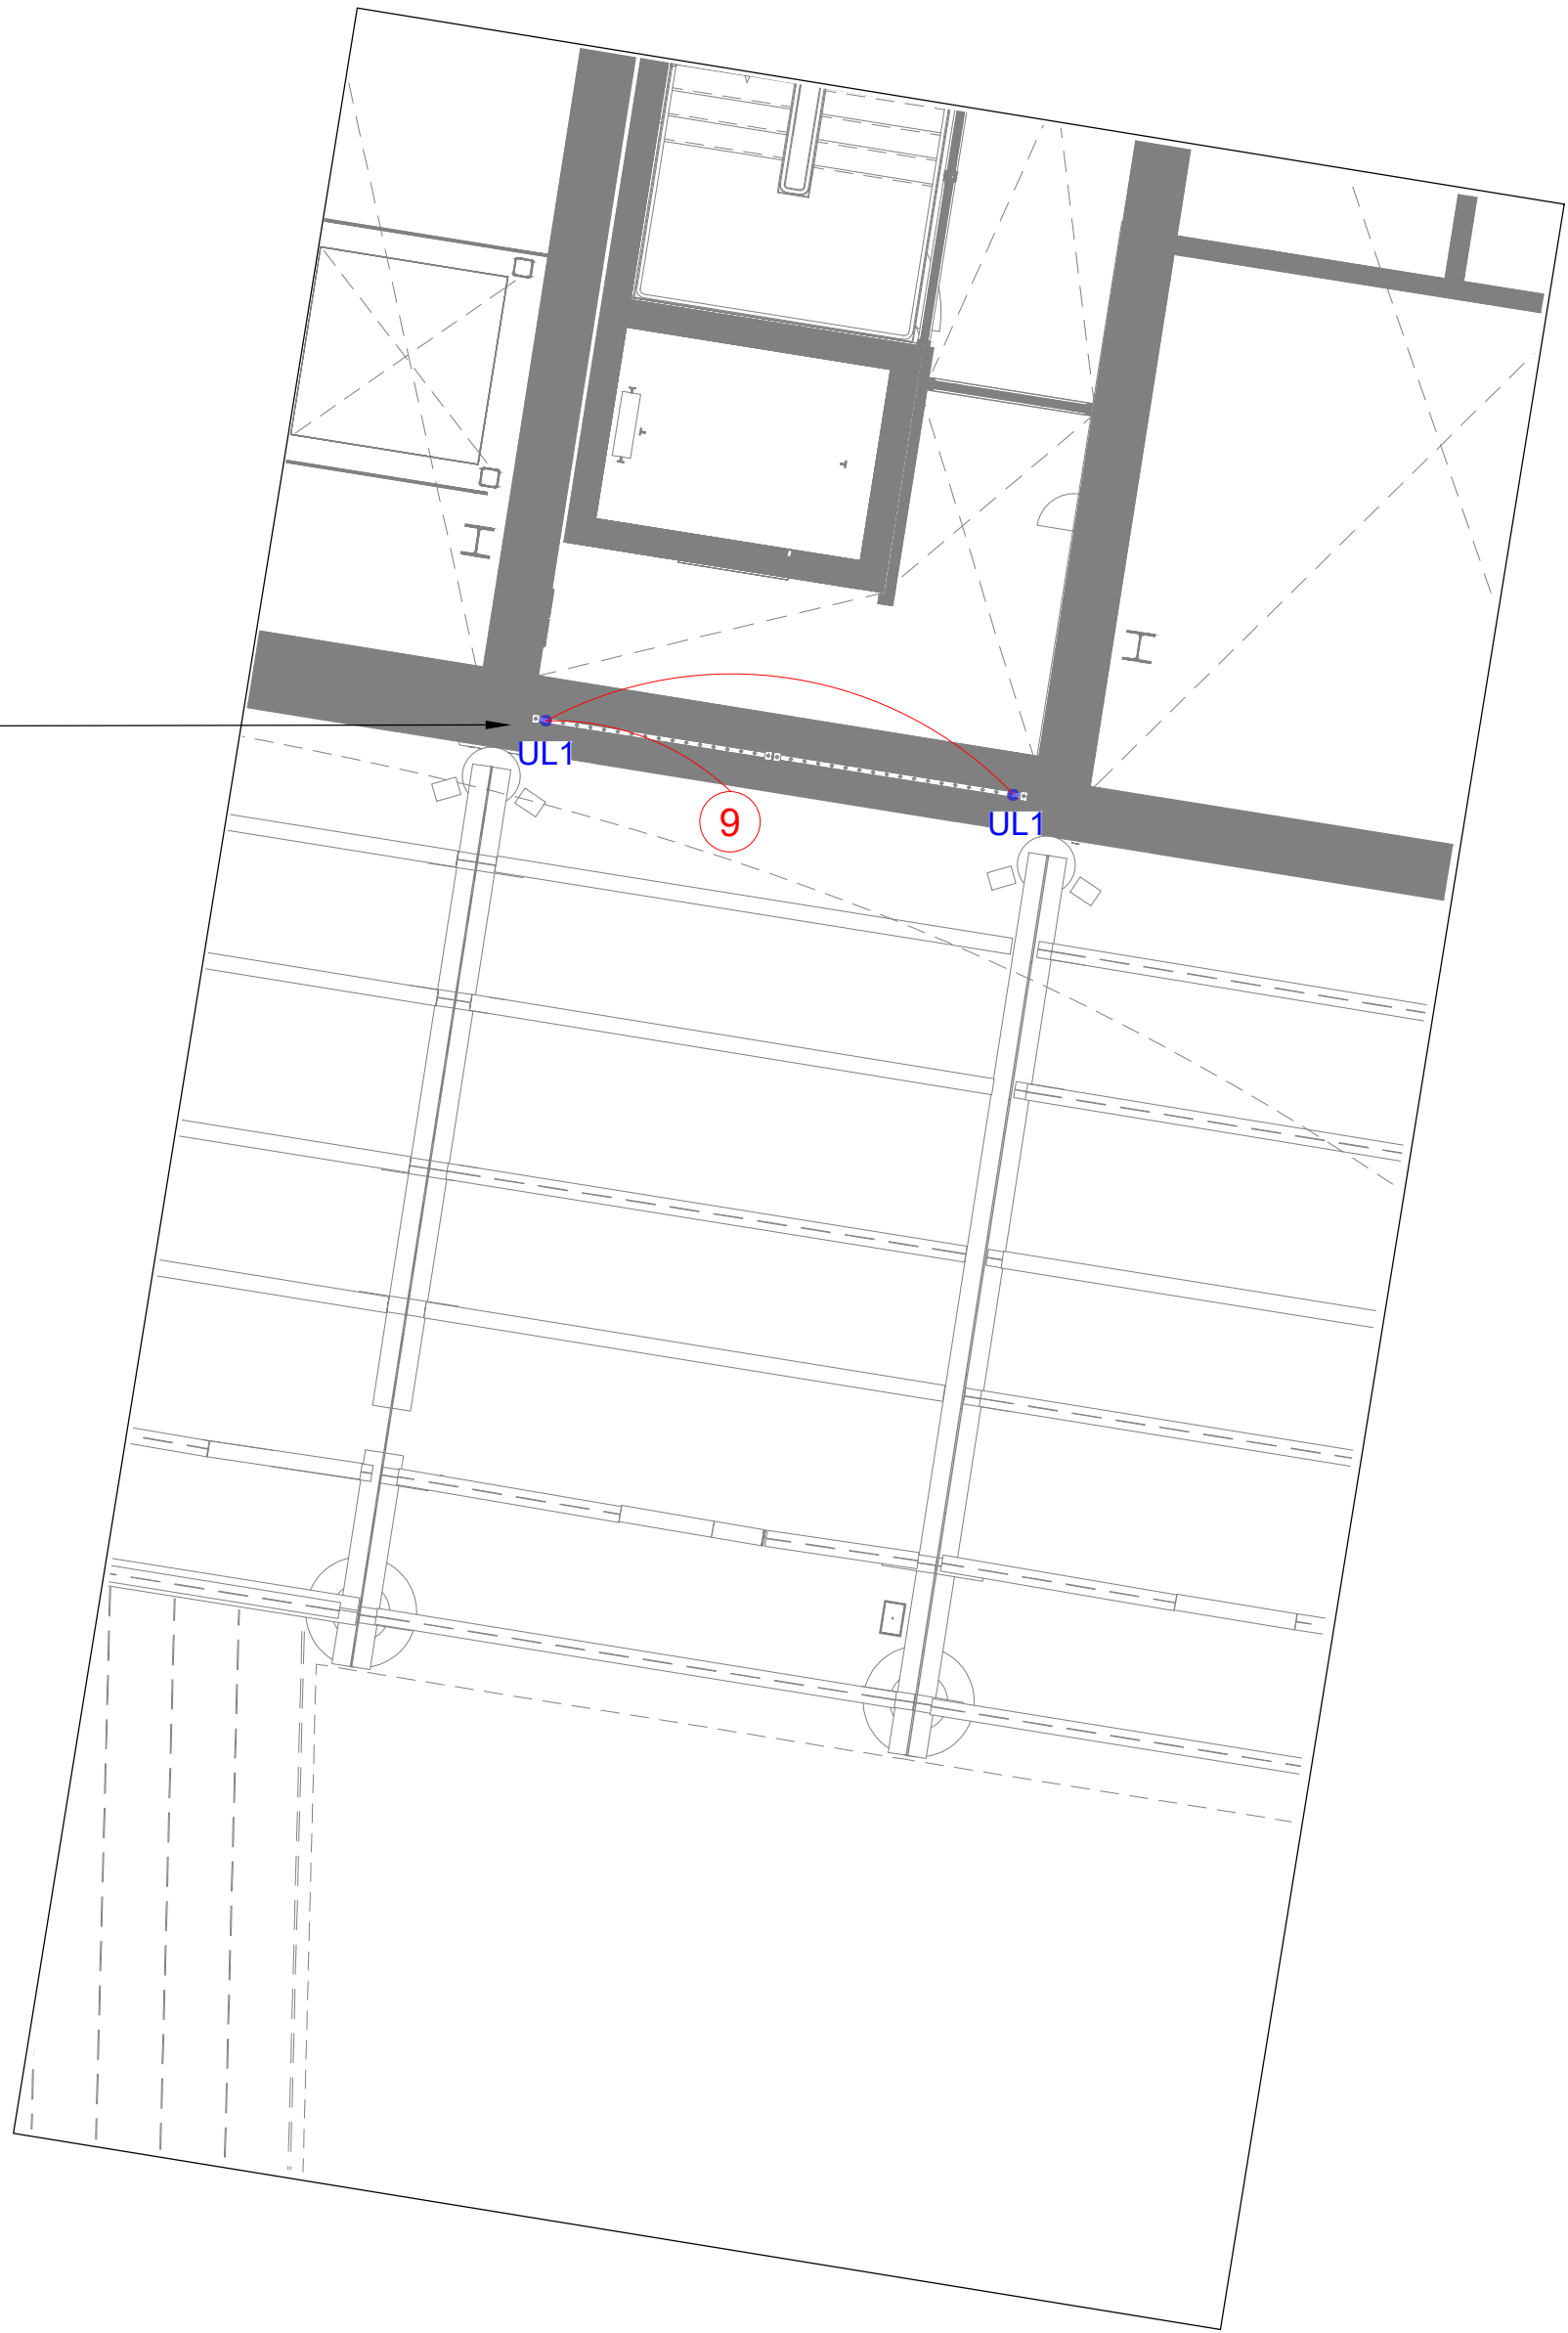

WEST WING ENTRANCE - 01
Scale 1:50@ A1

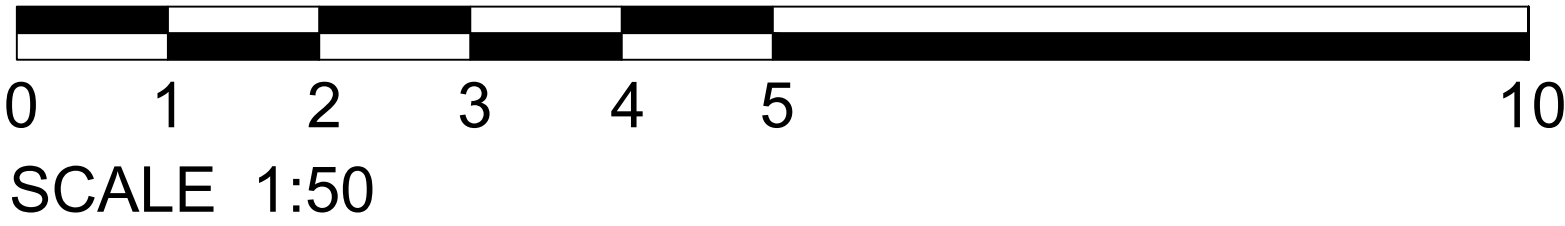

Studio 29 The Boathouse,
1A Putney Embankment, London SW15 1LB
t: 020 8780 9006 w: studio29lighting.com

24.03.2023 - For Planning

Date	Rev	Description
------	-----	-------------


Notes

Important Note

Where Dimensions are not given, drawings
must not be scaled.

For complete luminaire breakdown refer to
schedules

In the event of conflict between this drawing
and lead consultants drawing the matter must
be referred prior to proceeding

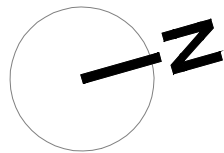

CLIENT	Argent	PROJECT NO.	0203
PROJECT	CDY - Gateways		
STATUS	FOR PLANNING		
SCALE	Scale 1:50@A1	DATE	18/01/2023
	Scale 1:100@A3		
TITLE	West Wing Entrance 01 - Lighting Control Channels		
DRAWING NO.	0203-806	REVISION	-