


GROUND FLOOR PLAN

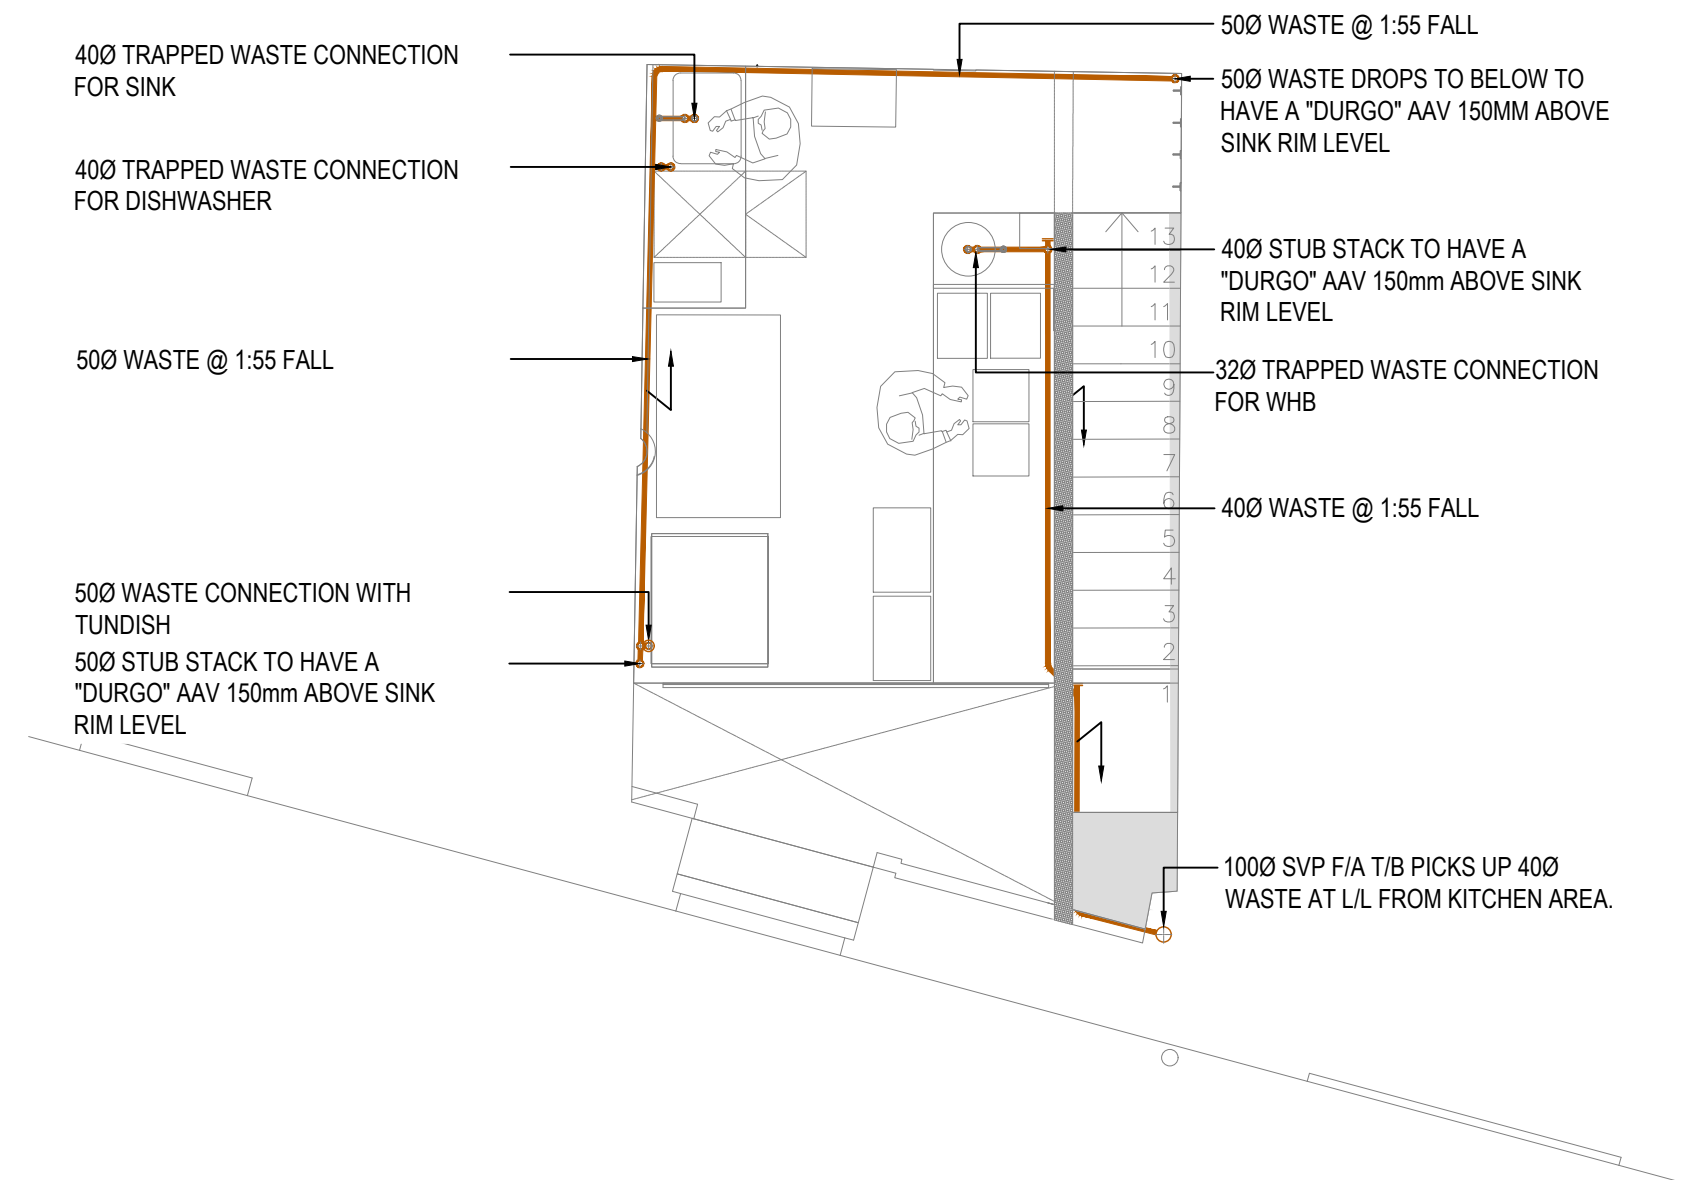

FIRST FLOOR PLAN

**NOTES**

1. **INDICATIVE SCHEME ONLY** DEPENDANT UPON THE REQUIREMENT OF THE LOCAL ENVIRONMENTAL HEALTH OFFICES AND PLANNING REQUIREMENTS

REV	DATE	DESCRIPTION
P2	11/05/23	OVEN WASTE SIZE AND DETAIL AMENDED



ENVIRONMENTAL  
ENGINEERING  
PARTNERSHIP  
CONSULTING ENGINEERS

www.eep.co.uk  
01494 464 544

CLIENT	-	DRAWN	M.W.	SCALE	1:50@A3
PROJECT	HUMBLE CRUMBLE, EARLHAM St	CHECKED	N.R.	DATE	APRIL 2023
TITLE	PRELIMINARY MECHANICAL LAYOUT	DRAWING No.	4234/PH/100		REVISION P2