
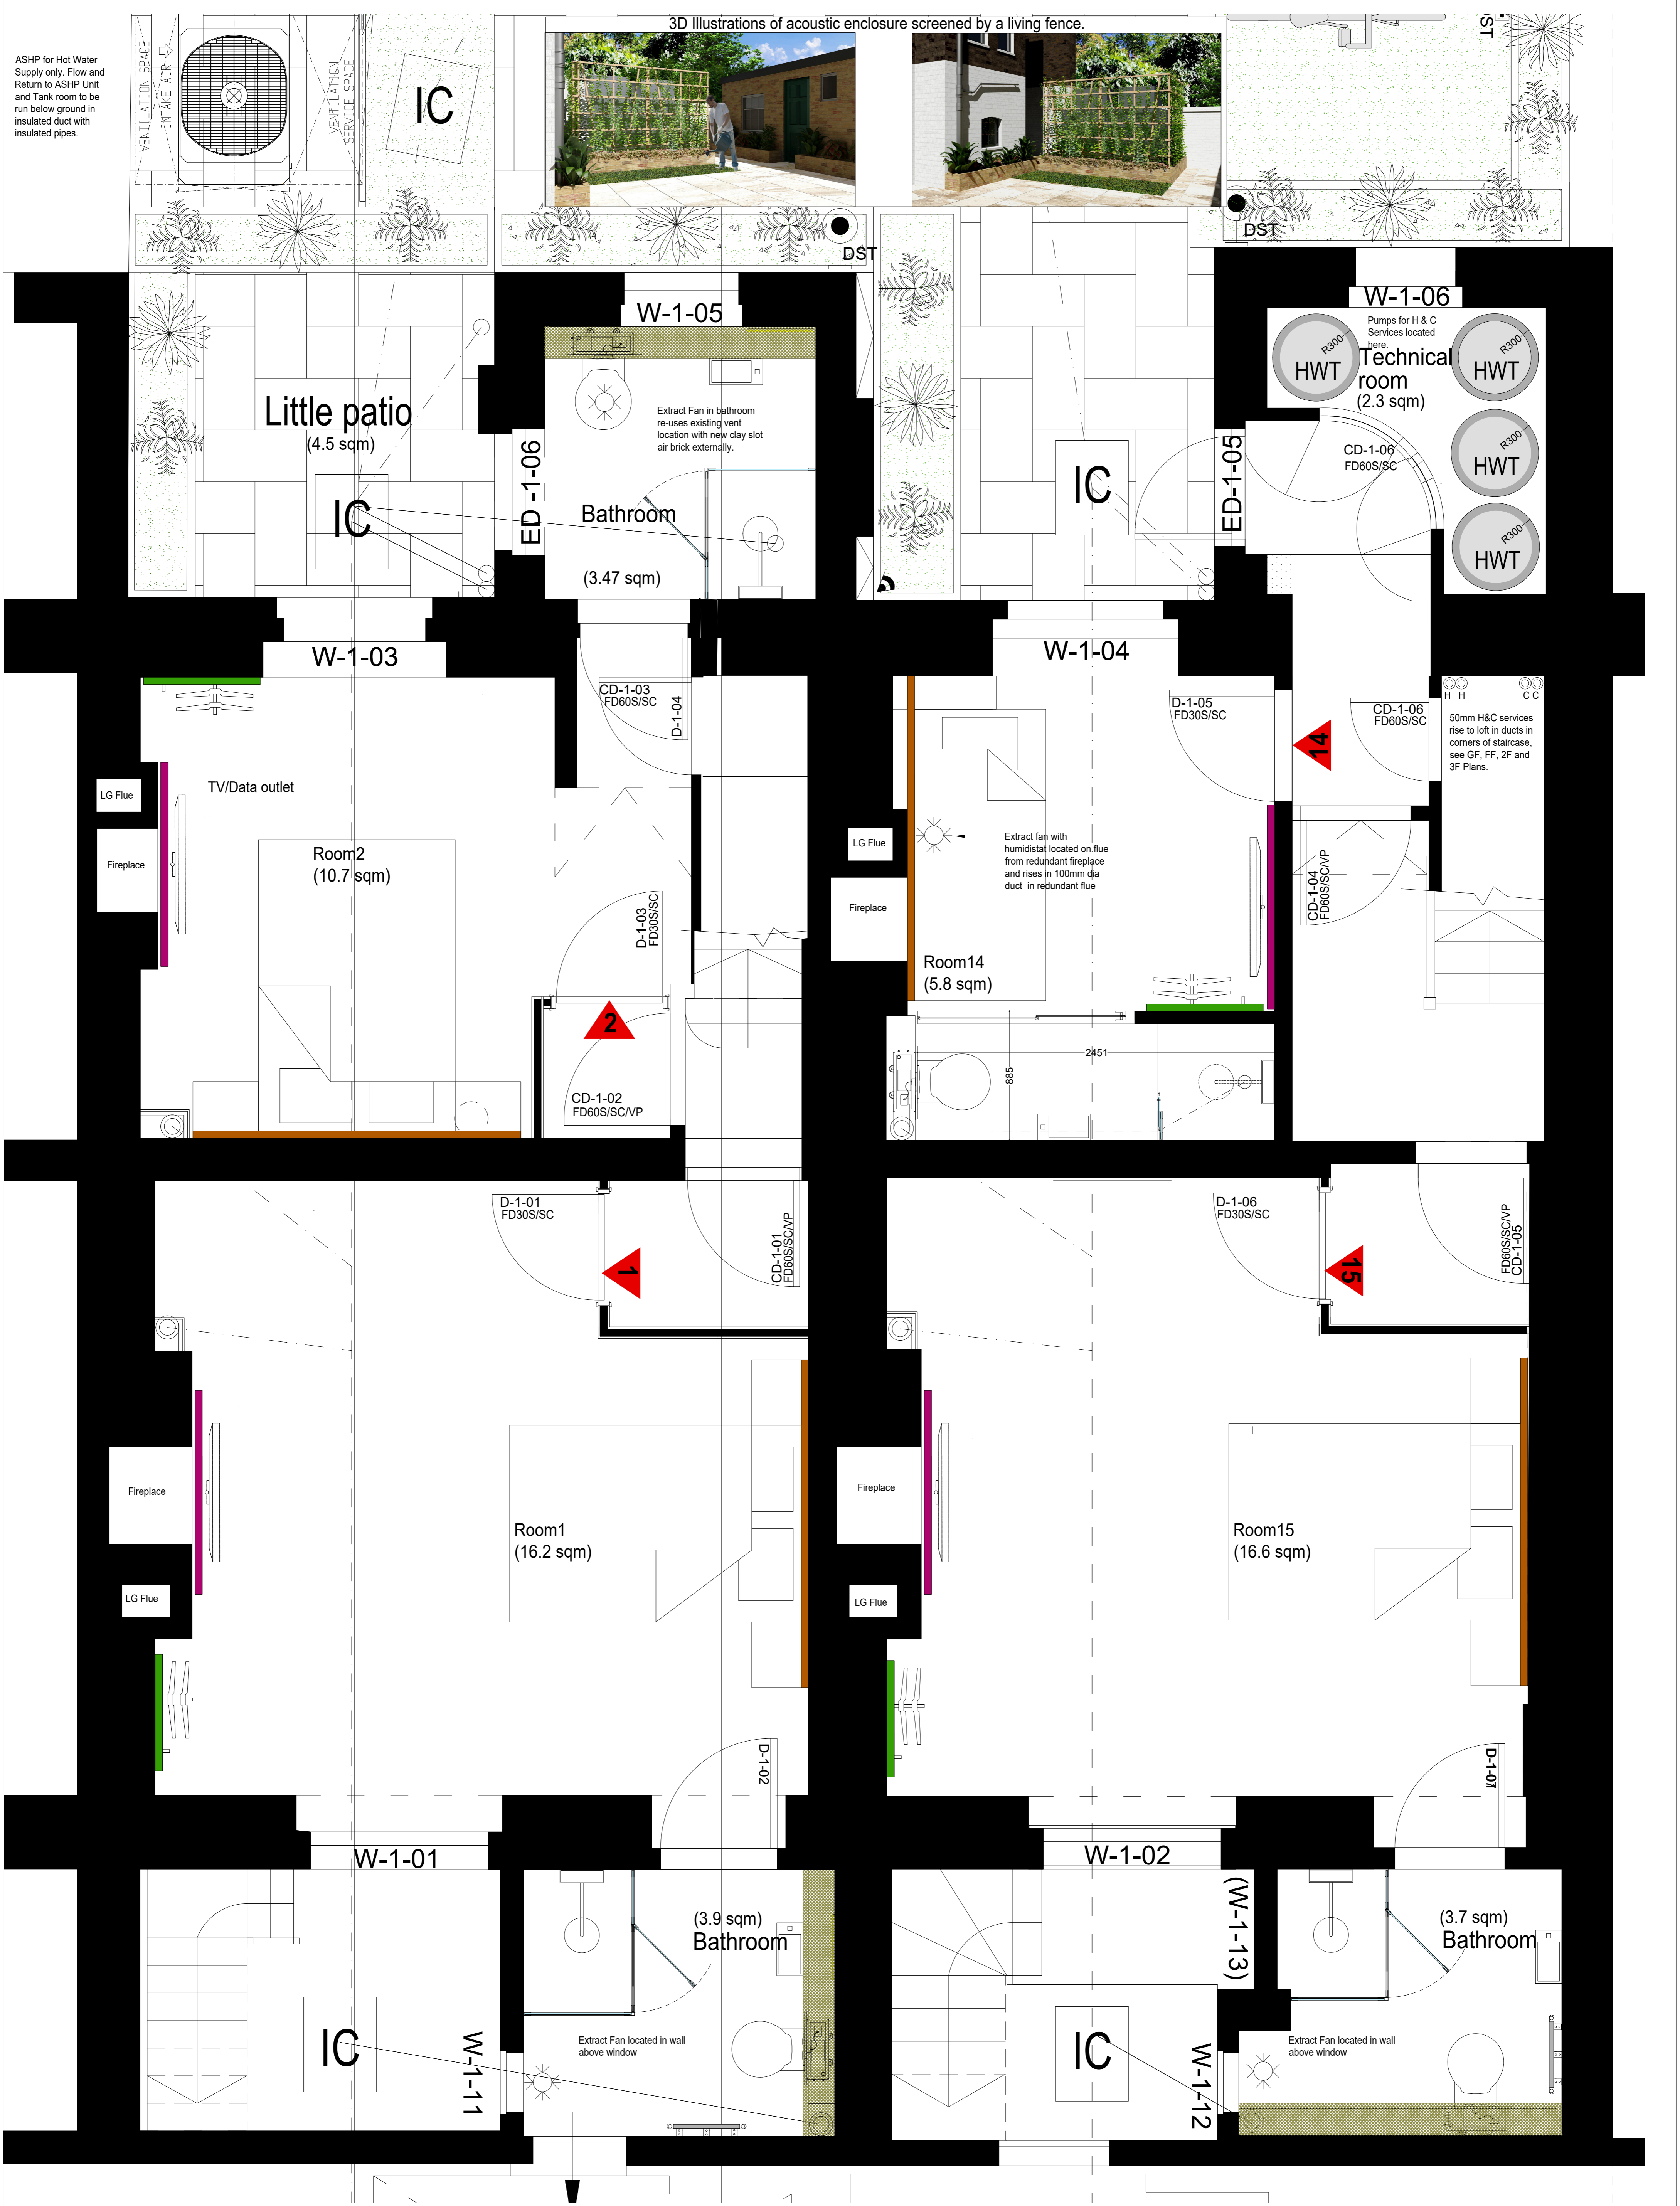


ASHP for Hot Water Supply only. Flow and Return to ASHP Unit and Tank room to be run below ground in insulated duct with insulated pipes.


3D Illustrations of acoustic enclosure screened by a living fence.

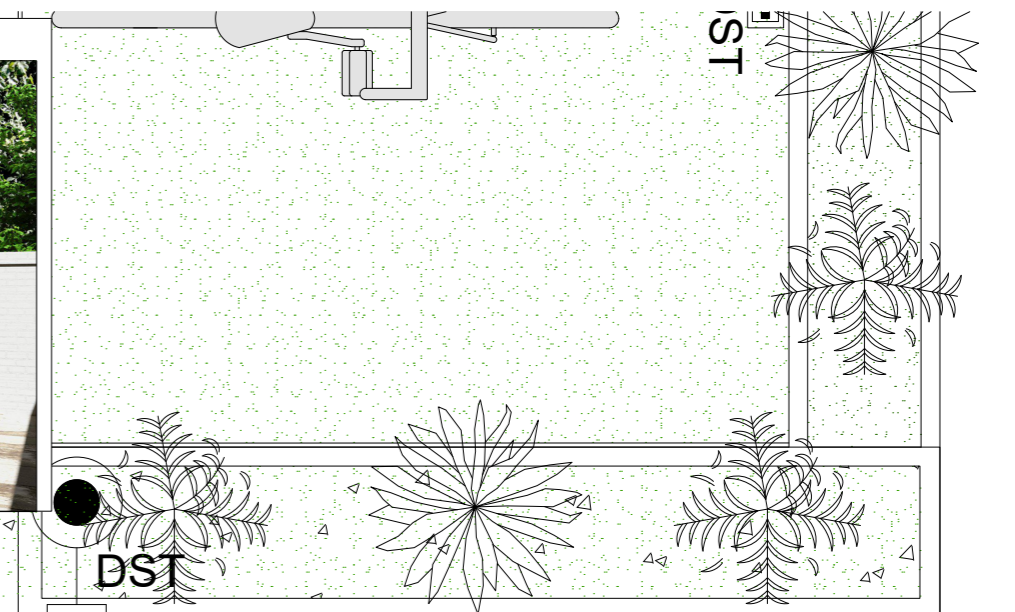

Proposed Lower Ground Floor Plan

GENERAL NOTES:

Copyright of this document (including its electronic form) and the designs described reside with PHD Associates. This document is protected under the COPYRIGHT, Designs & Patents Act 1988. Please do not scale from prints made from pdfs without verifying the scale using the scale bars or marked dimensions. Prints and Photocopies are distorted by the printing process. Dimensions are in millimetres. Site checking All dimensions and levels indicated must be site checked prior to commencement of works, and any discrepancies found must be reported. Please consult with the architect in the event of an anomaly or conflicting information. Please also refer to the structural engineer's details and specification for structural information and the services engineer's details and manufacture drawing

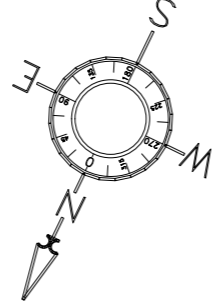

REV	DATE	DESCRIPTION	DATE	DESCRIPTION
1	23-08-2022	Initial Issue		

P.H.D. ASSOCIATES BRAEMAR HOUSE WATER LAKE STANFORD, ESSEX CM24 8DU TEL: 01279 817342 FAX: 01279 647086 EMAIL: INFO@PHDASSOCIATES.CO.UK	Project: Oxford House Hostel Tavistock Place, London WC1H 9RE Drawing: M&E Water Supplies Lower Ground floor plans	Date: 23-08-2022 Drawn By: SHD/VM Scale: 1-20 at A1 Drawing Number: 2105/BC/WS
---	--	---