
 


FLOOR PLAN - ROOM B91

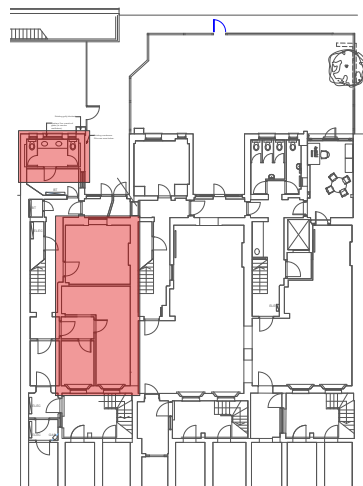


KEY PLAN

# CEILING - SW24 - 49 GORDON SQUARE PROPOSED BASEMENT






Scale 1:50 @ A3

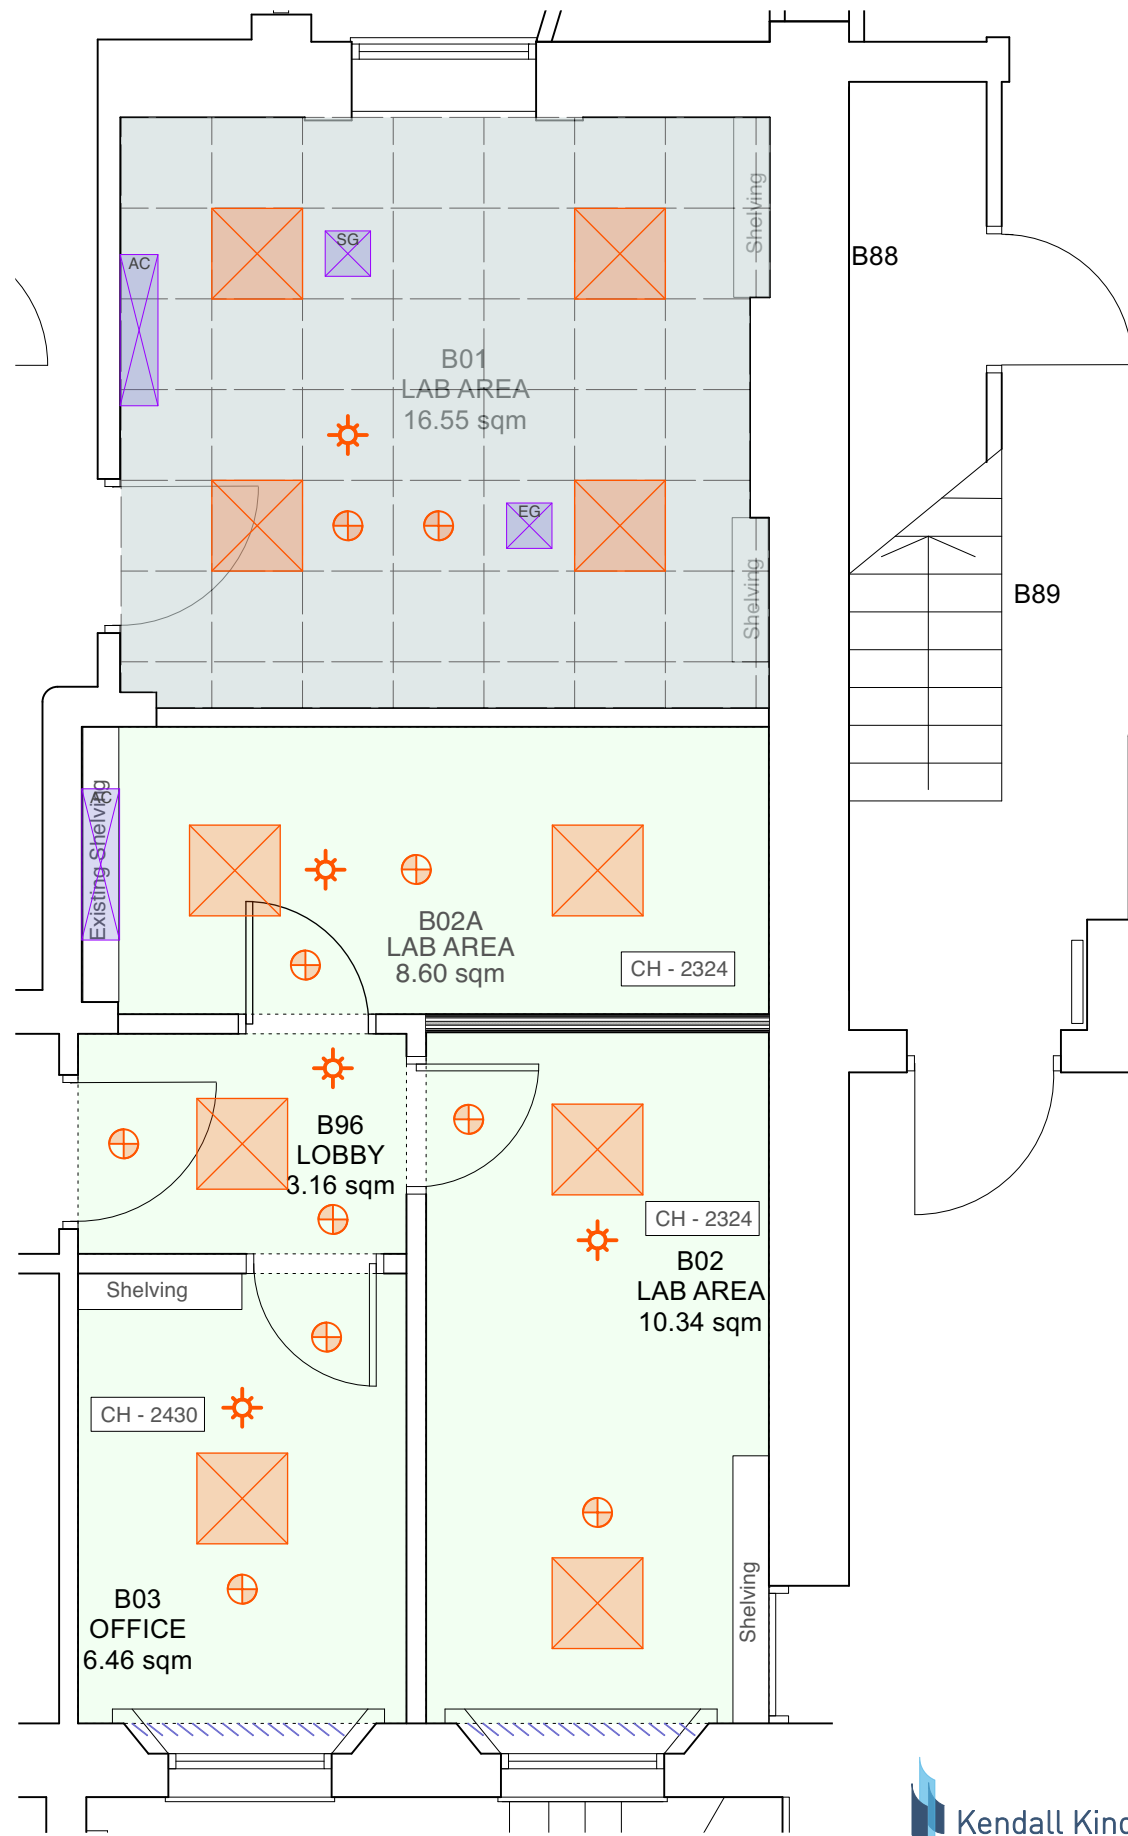



FLOOR PLAN ROOM B01, B02, B03 & B96
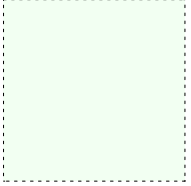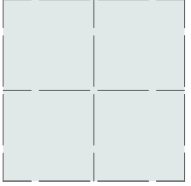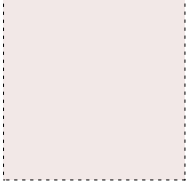
## CEILING TYPE KEY:

 <b>TYPE 1</b> EXISTING CEILING Clean, make good, and redecorate. Colour as per finishes schedule.	 <b>TYPE 2</b> NEW MINERAL FIBRE CEILING TILES Refer clause K45/40 Colour as per finishes schedule. Allow access panels if required.
 <b>TYPE 3</b> NEW SUSPENDED MR PLASTERBOARD CEILING Refer clause K40/21. Colour as per finishes schedule. Allow access panels if required.	<div style="border: 1px solid black; padding: 2px; display: inline-block;">CH - xxxx</div> Indicated ceiling height

## MECHANICAL AND ELECTRICAL KEY:

 <b>ELECTRICAL:</b> Refer to M&E specification for electrical details.	 <b>MECHANICAL:</b> Refer to M&E specification for mechanical details. Refer to M&E specification for light presence detector. Emergency lighting.
-------------------------------------------------------------------------------------------------------------------------------------------------------------------	-----------------------------------------------------------------------------------------------------------------------------------------------------------------------------------------------------------------------------------------------------

## MECHANICAL AND ELECTRICAL NOTES:

For information relating to the mechanical and electrical work please refer to the package contained within Document 1 Volume 3 - Mechanical and Electrical Specification and Drawings. Please advise the CA if any discrepancies are identified between this this drawing and M&E information.



Chartered Architects  
Chartered Building Surveyors  
Interior Designers  
CDM Services

Suite 3, Sandford House,  
1b Claremont Road,  
Teddington, TW11 8DH  
+44 (0)20 8943 5300  
www.kendallkingscott.co.uk

Project  
Life and Medical Sciences - Small Works  
Ceiling - SW24 - 49 Gordon Square  
Proposed Basement

Client  
University College London

Scale 1:50  
Paper Size ISO A3  
Filename 220593-UCL-Contract B -C1  
Author AC.vwx  
Date 23/06/2022  
Drawn ML  
Checked KS

C1 20/01/2023 ML KS STAGE 5 - Construction Issue  
P2 09/11/2022 ML KS STAGE 4 - Issued  
P1 14/10/2022 ML KS STAGE 3 - Issued  
Rev Date By Ap Note

Drawing Title  
Project Number Drawing Number Revision

**220593(SW24)-2500 C1**

Date 23/06/2022 Drawn ML Checked KS Purpose/Status CONSTRUCTION  
Check all dimensions and levels on site

Only to be used on the site for which designed. The electronic transmission of designs/information contained in this drawing is carried out entirely at the User's risk and Kendall Kingscott Ltd. will have no liability for any errors or inaccuracies arising therefrom. The production of amended or updated information from the said designs/information by the User is entirely the responsibility of the User and Kendall Kingscott Ltd. shall have no responsibility in respect thereof whatsoever.