


PROPOSED LICENSING FLOOR PLAN

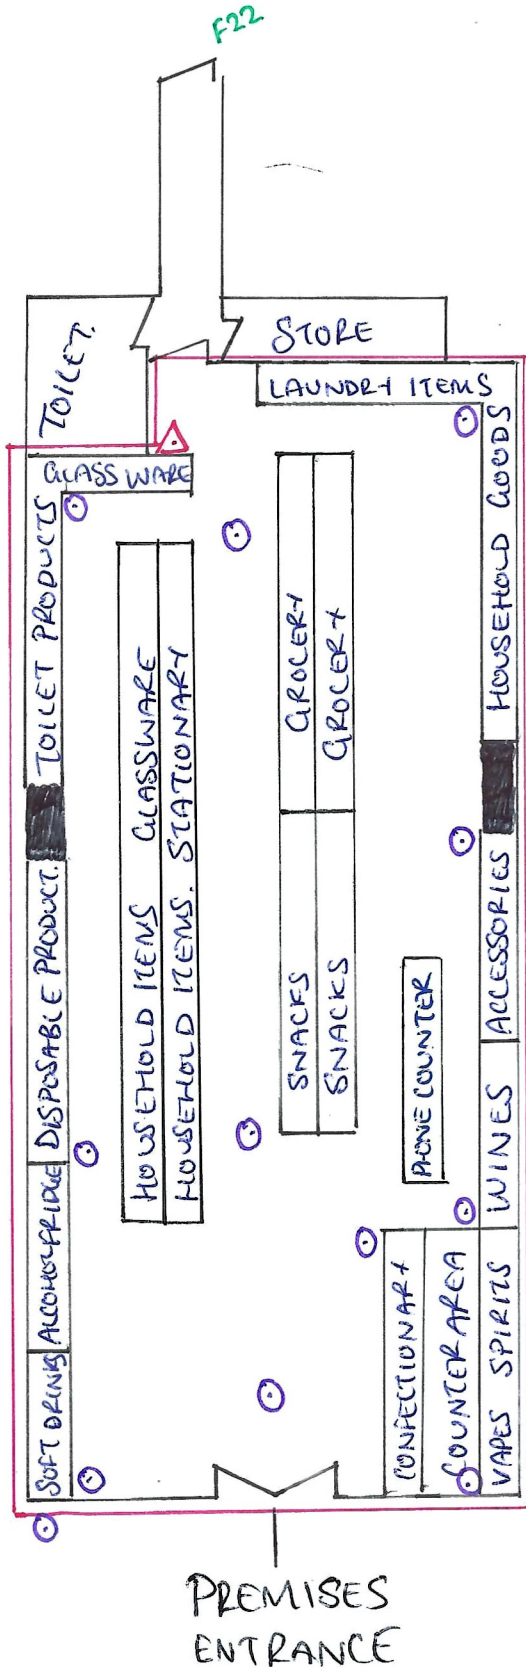

PREMISES DETAILS:
 MPM BIG STORE
 129 FINCHLEY ROAD
 LONDON
 NW3 6HT

KEY:

LICENSABLE ACTIVITY AREA

○ CCTV

F22 FIRE EXIT.

△ FIRE EXTINGUISHER.

SCALE: 1:100