


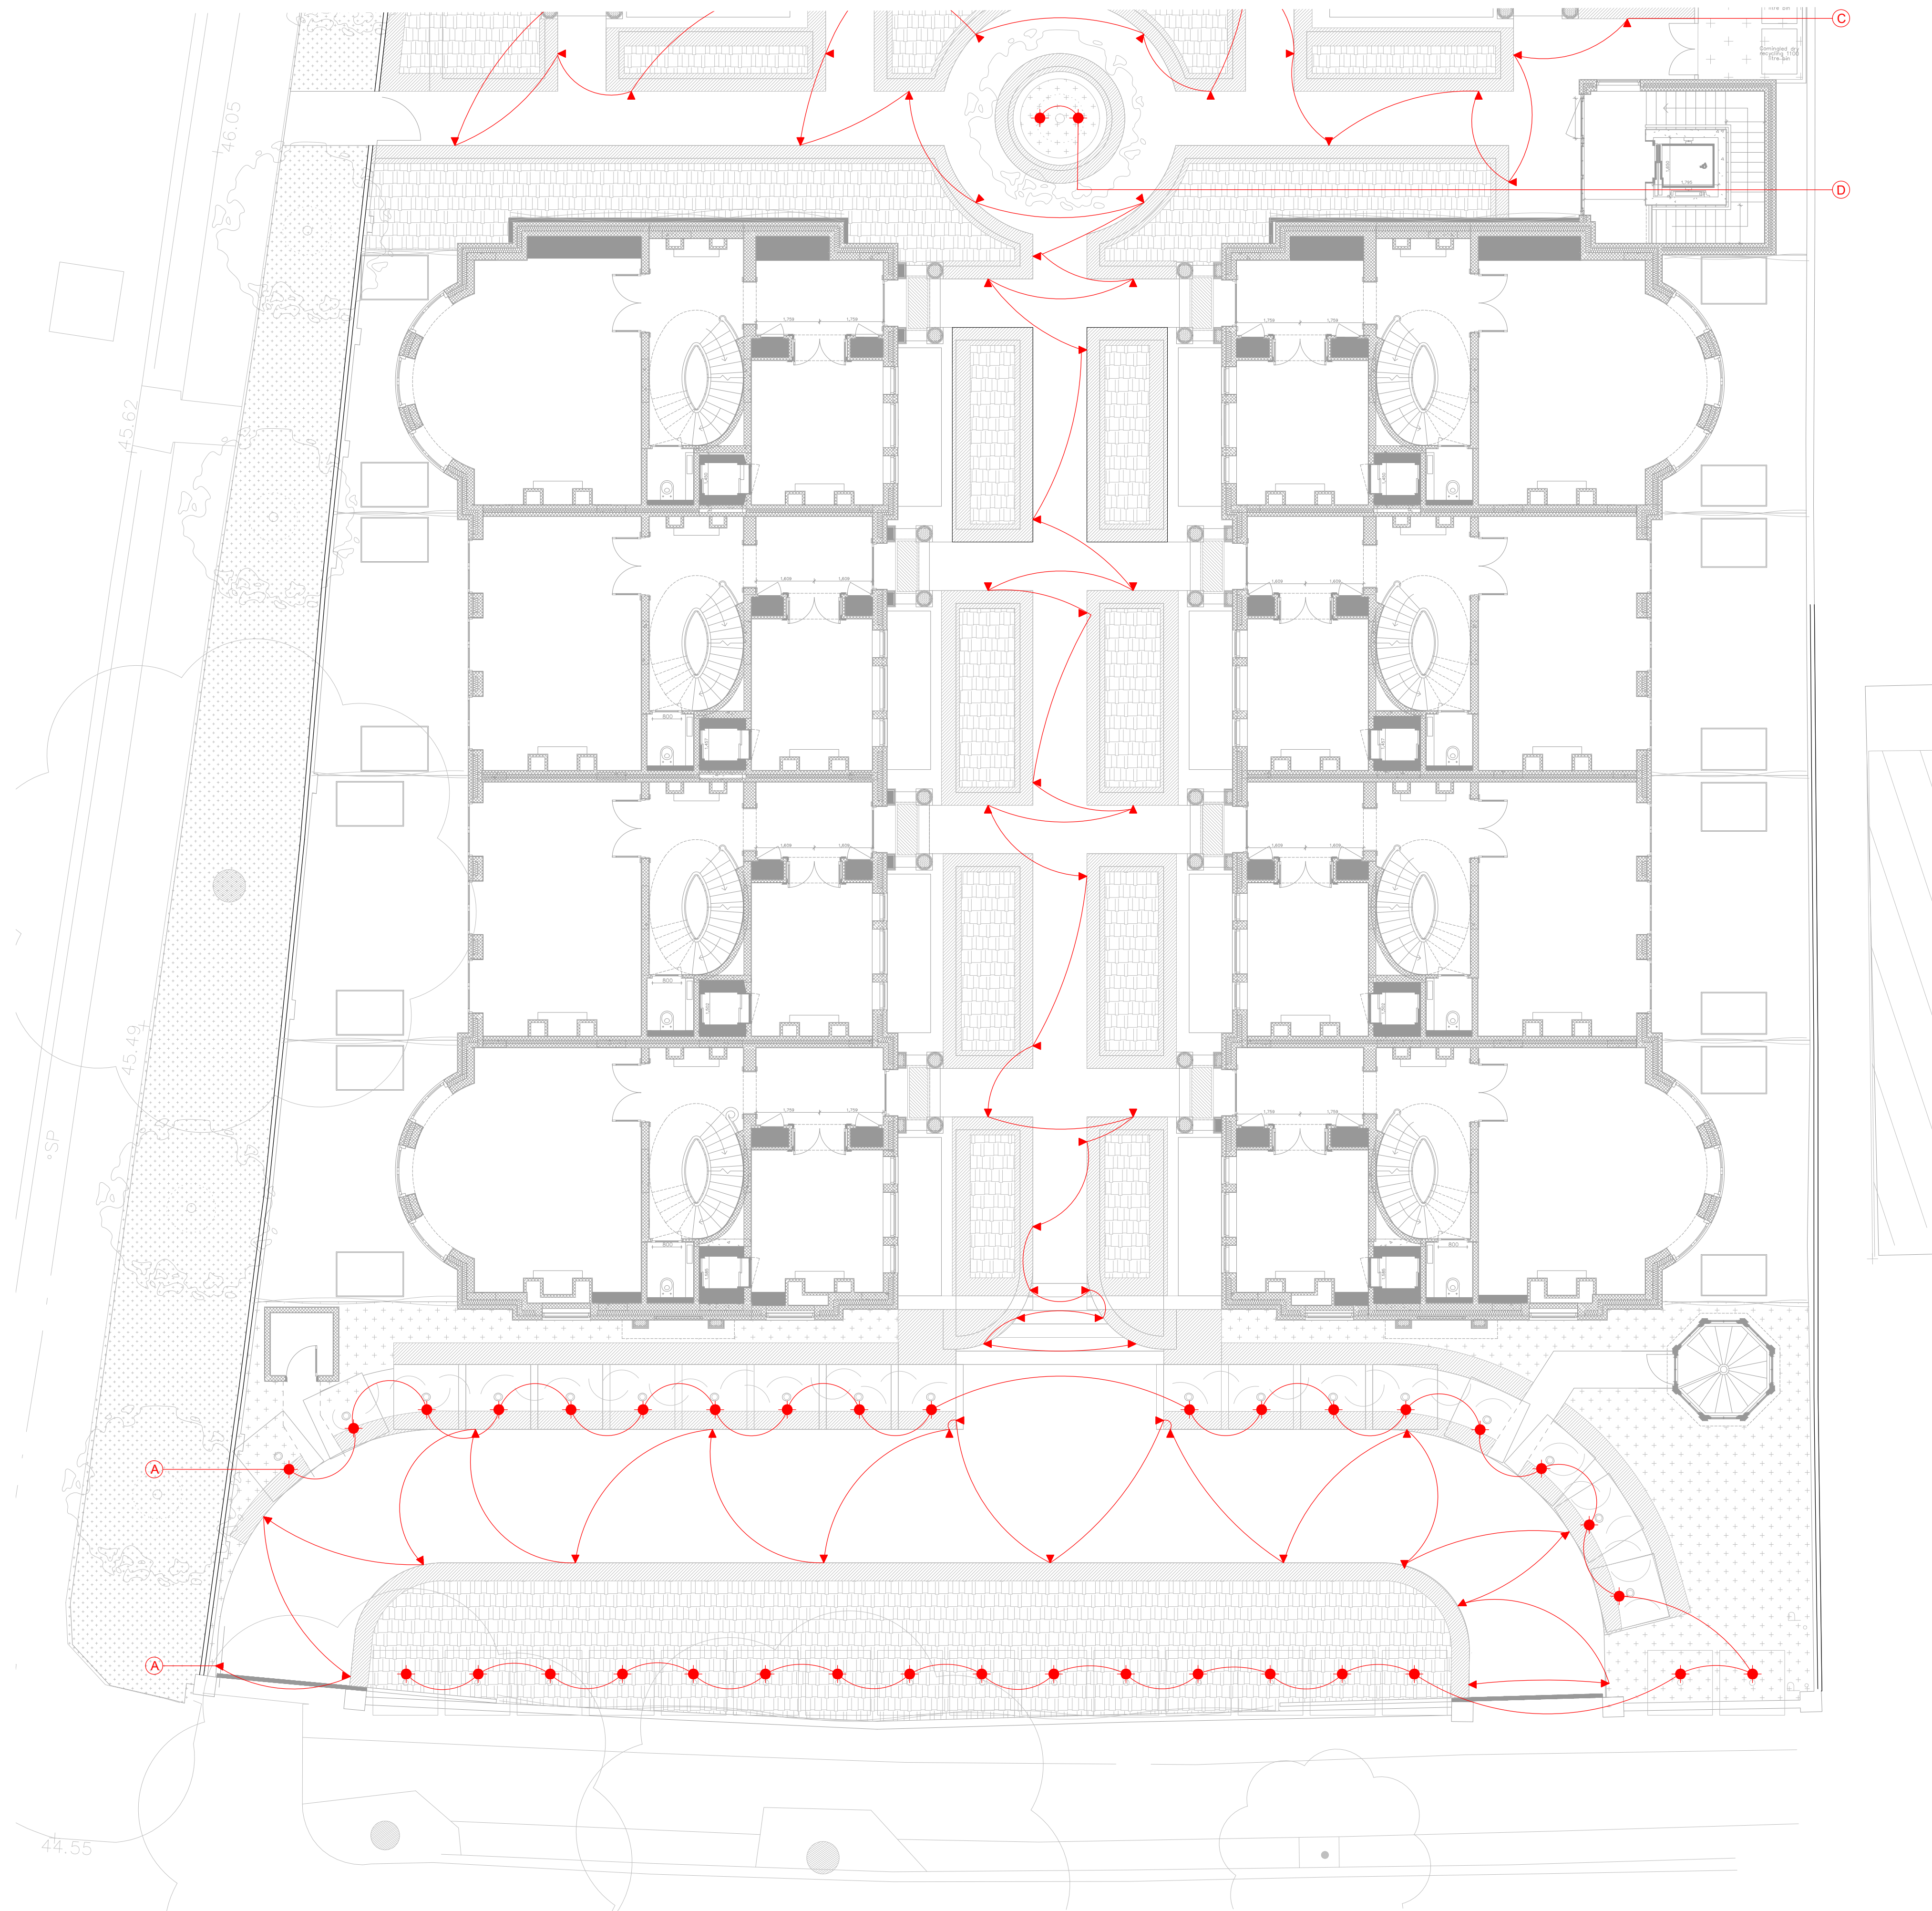

DOMVS
LONDON

WWW.DOMVSLONDON.COM

PROJECT:
52 AVENUE ROAD

TITLE:
PROPOSED LANDSCAPE
LIGHTING PLAN SHEET 1

Date: MAY 2023

Scale: 1:100 @ A1 **Drawn:** JCGD

DRAWING NUMBER: 132-106