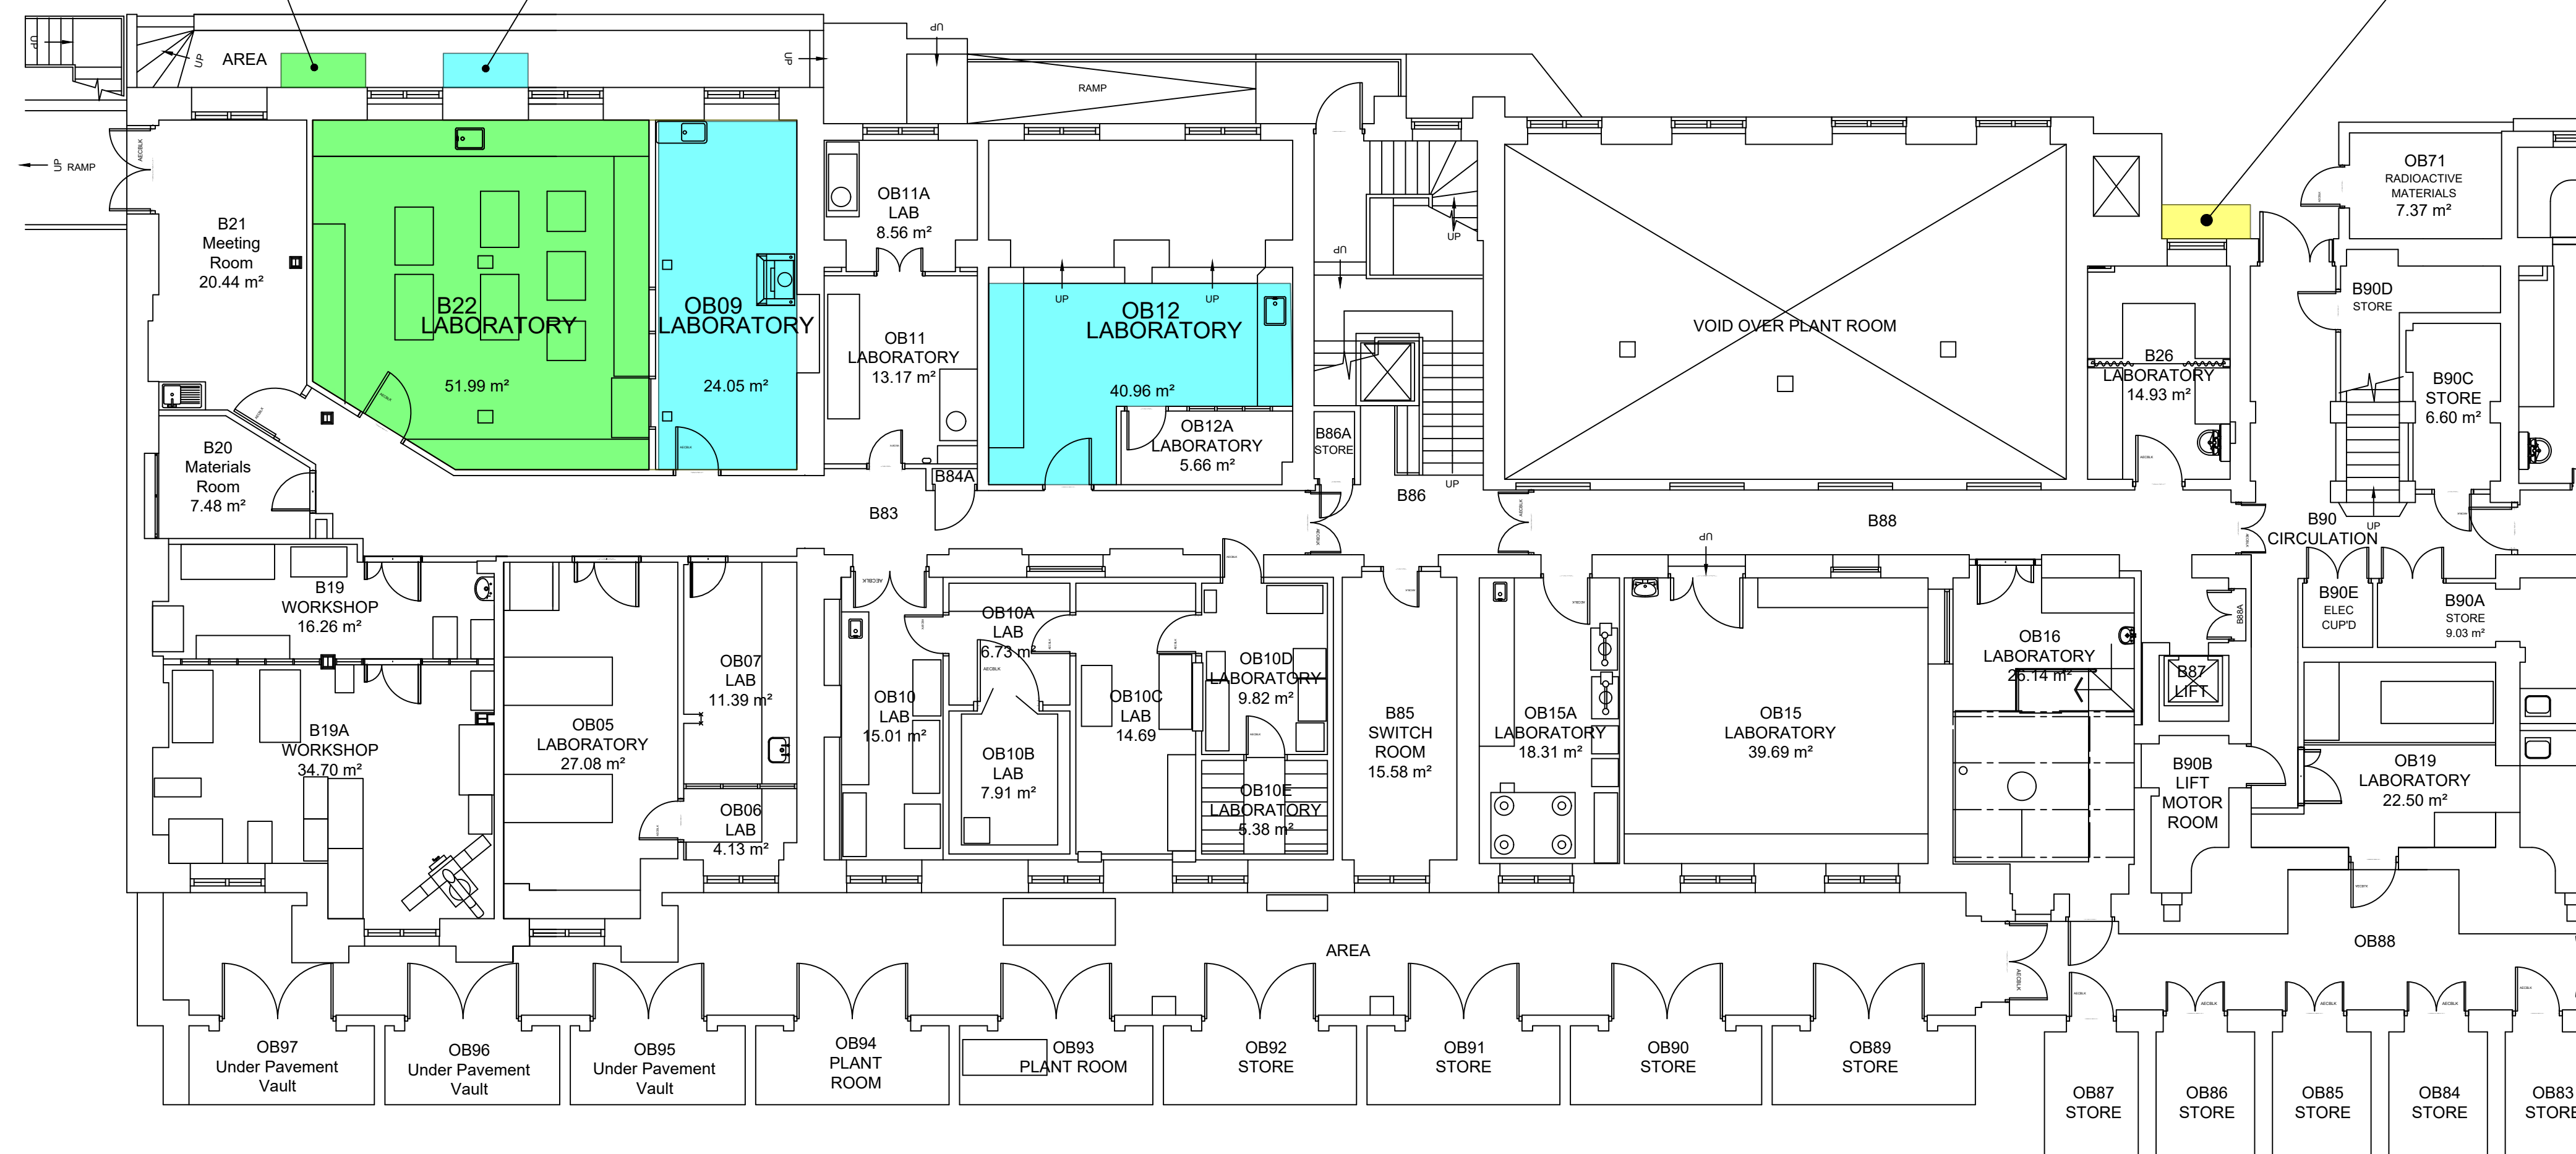


— GOWER COURT SERVICE YARD
FOUR GAS CYLINDER CAGE LOCATION TO
SUPPLY DRY LAB OB09 AND OB12 (ROOMS
HIGHLIGHTED BLUE)

— THREE GAS CYLINDER CAGE LOCATION
(STORAGE CAGE)

[illegible]

This drawing and any design hereon is the copyright of Potter Raper and must not be reproduced without their written consent. All drawings remain the property of Potter Raper. Figured dimension only to be taken from this drawing. All dimensions to be checked on site. Please inform Potter Raper immediately of any discrepancies before work proceeds.

Client
UNIVERSITY COLLEGE LONDON

Project Name	KLB GAS SUPPLY
--------------	----------------

Project Location

KATHLEEN LONSDALE BUILDING
GOWER STREET
LONDON, WC1E 6BT

Sheet Name

PROPOSED BASEMENT
FLOOR PLAN

Project Status	TENDER
----------------	--------

Drawing Nr.
LB032-SW2215-001

Scale 1:100@ A1

**POTTER
RAPER**
101 St Martin's Lane
London
WC2N 4AZ
Tel: 020 7436 5005

Scale Bar 1:100

1 LOCATION PLAN (BASEMENT)
Scale: 1:100