

DO NOT SCALE


THE CONTRACTOR IS TO CHECK AND VERIFY ALL BUILDING AND SITE DIMENSIONS, LEVELS AND SEWER INVERT LEVELS AT CONNECTION POINTS BEFORE WORK STARTS.

THIS DRAWING IS TO BE READ AND CHECKED IN CONJUNCTION WITH ENGINEERS AND OTHER SPECIALIST DRAWINGS & SPECIFICATIONS.


THE DRAWING AND THE WORKS DEPICTED ARE THE COPYRIGHT OF PAWLK+WIEDMER LTD AND MAY NOT BE REPRODUCED EXCEPT BY WRITTEN PERMISSION.

NOTES

TO BE READ IN CONJUNCTION WITH DEMOLITION GA PLANS, SECTIONS, ELEVATIONS, FINISHES PLANS AND HERITAGE STATEMENT. REFER ALSO TO MEP ENGINEERS' STRIP OUT AND BUILDERSWORK INFORMATION AND LIGHTING LAYOUTS.

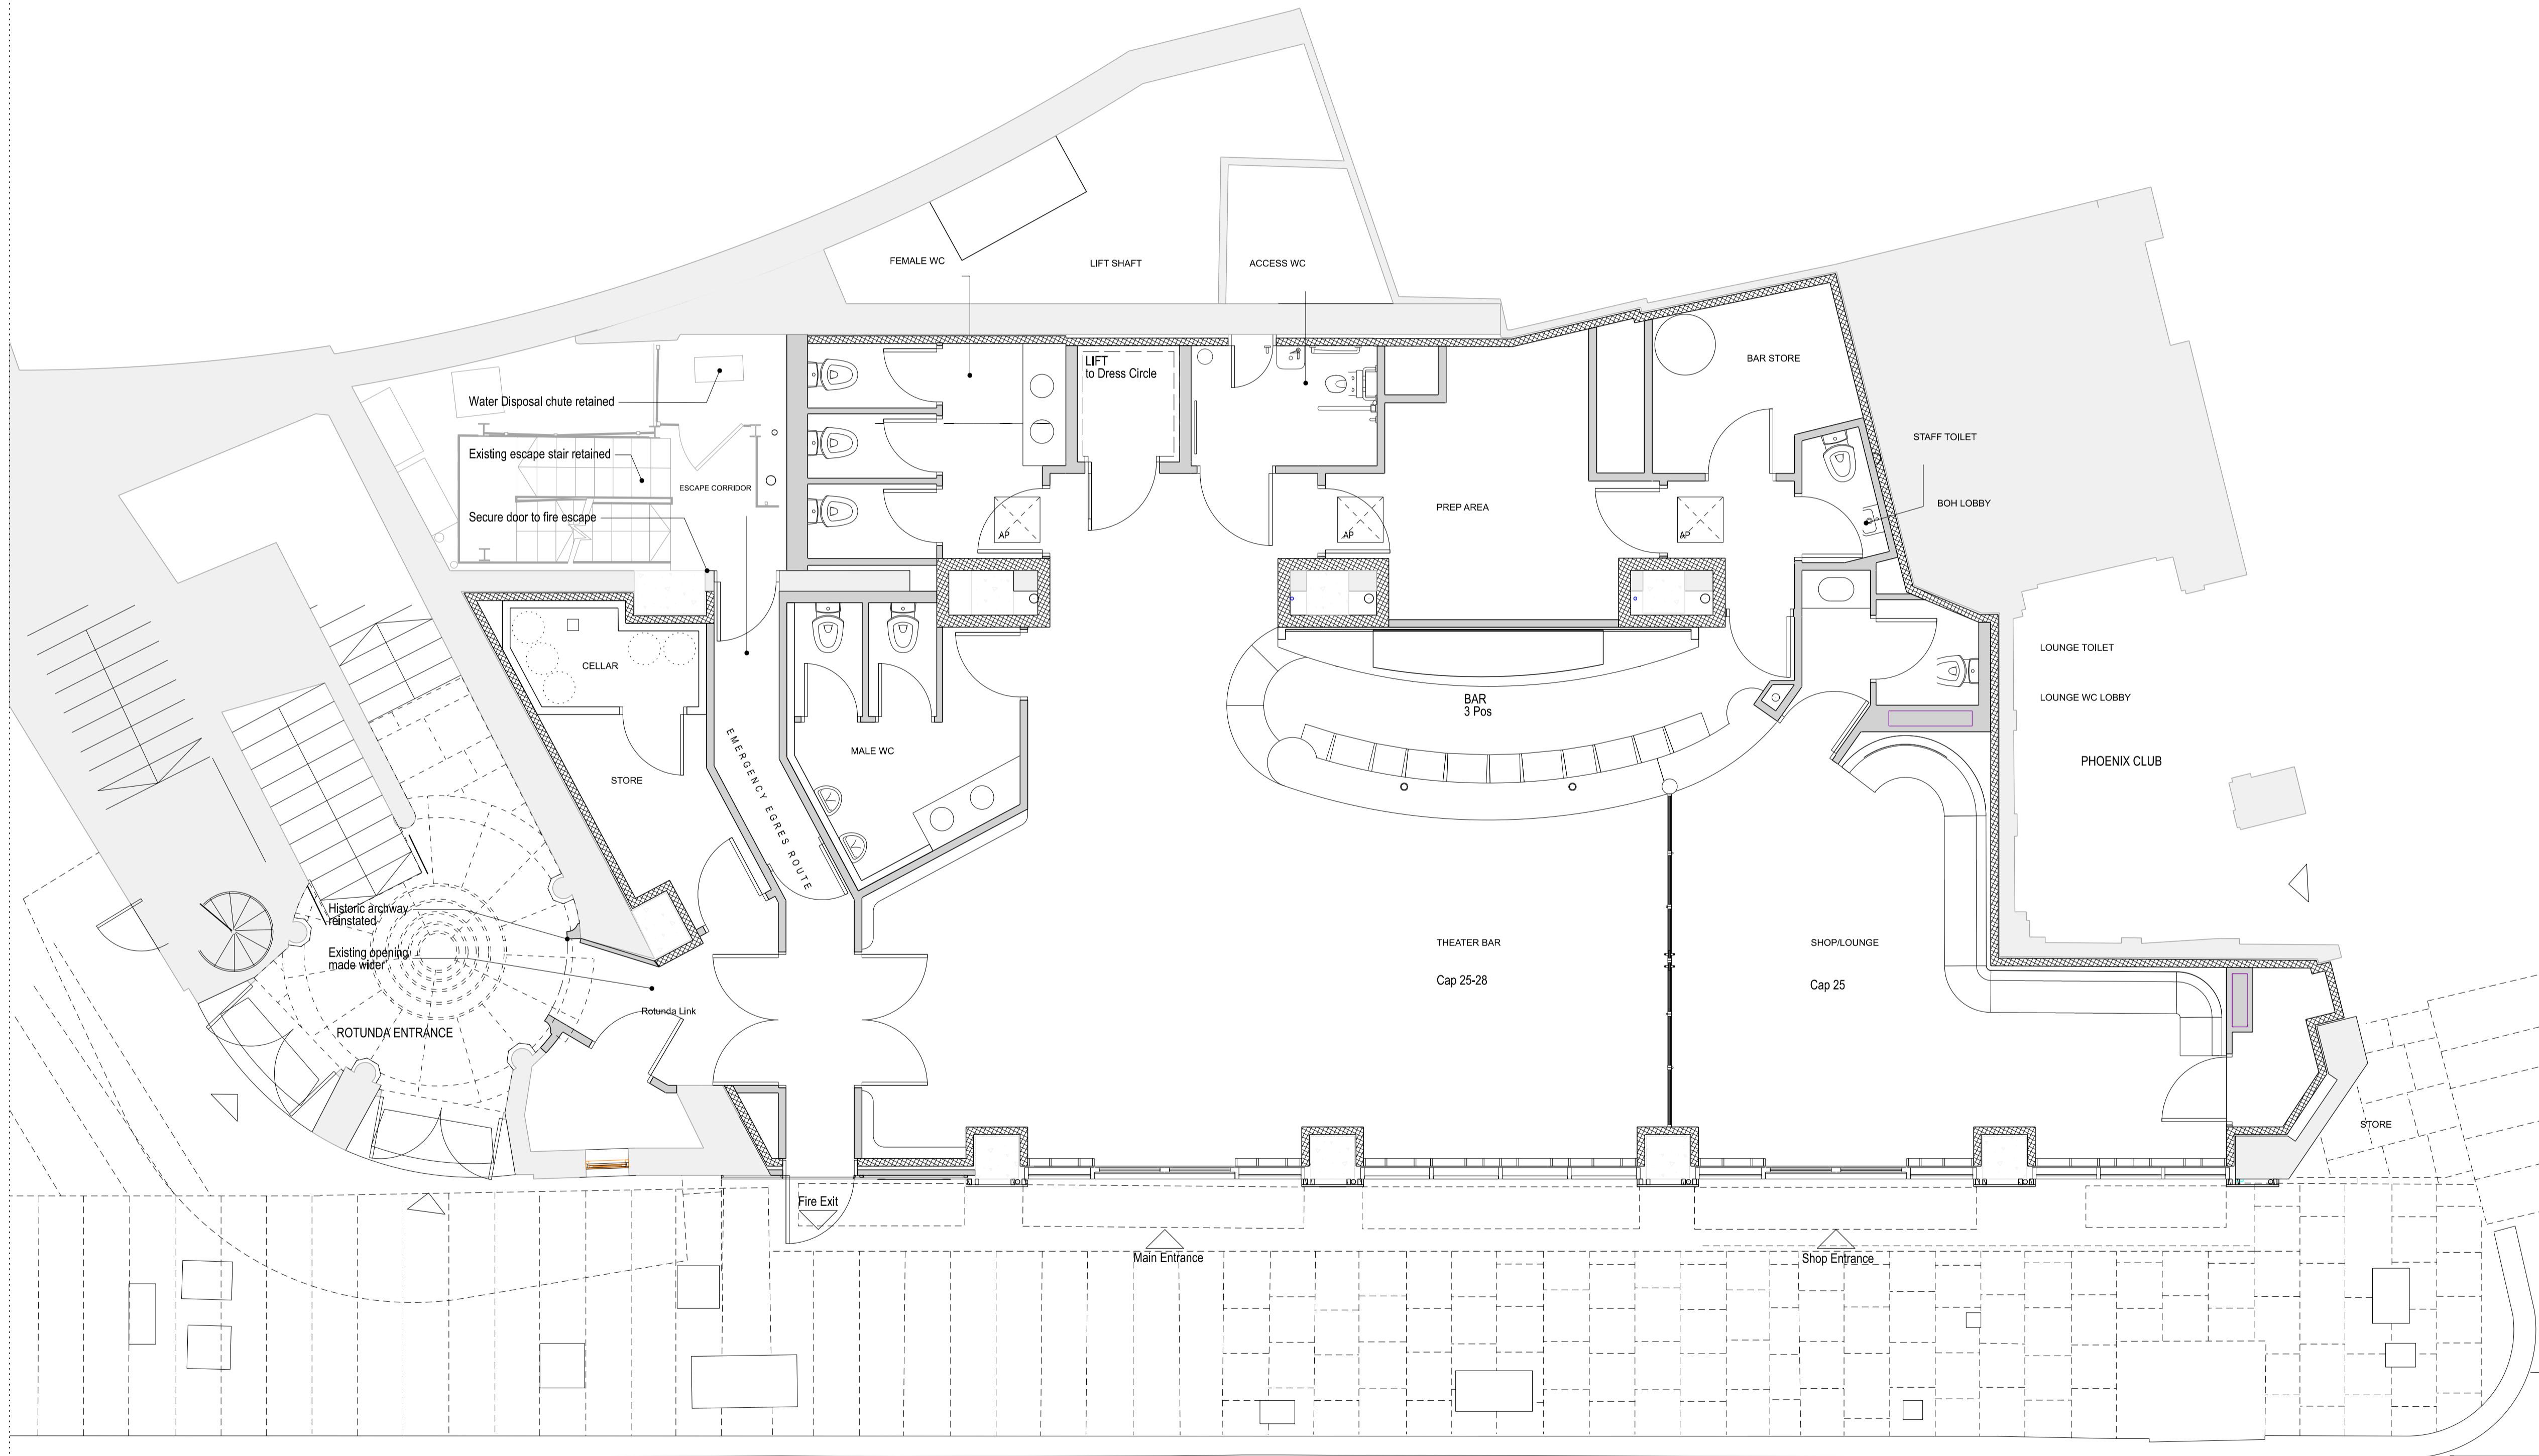

Rev	Date	Reason For Issue	Chk
P1	23.05.2023	Window alteration omitted	NP
-	-	-	-
-	-	-	-
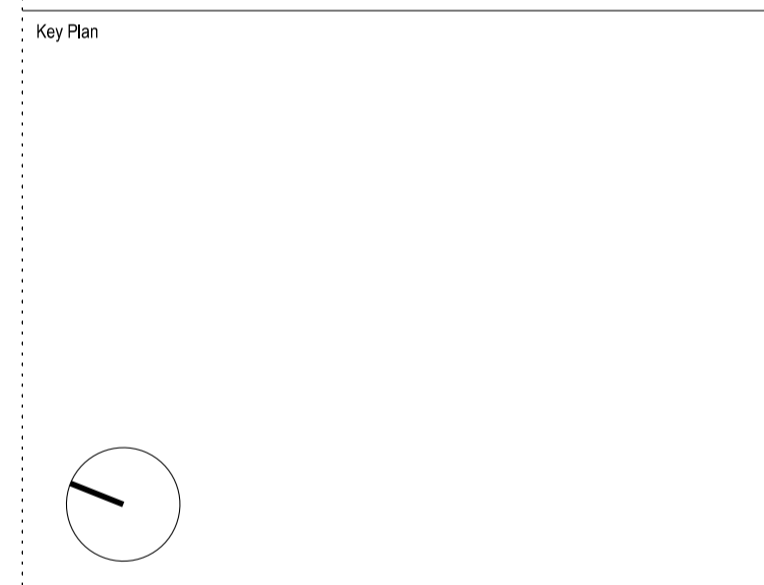

pawlik + wiedmer
 8-12 Creekside
 London
 SE8 3DX
 london@pawlikwiedmer.com
 Registered in England & Wales No: 8155464
 Registered Office: 27 Mortimer Street, W1T 3BL, UK

Client
Phoenix Theatre
 Charing Cross Road
 Ambassador Theatre Group

Project
Project Ash
 Phoenix Theatre
 Charing Cross Road

Title
Ground Floor Plan
 Proposed

Status
INFORMATION

Project Number	Date	Checked By
559	SEPT 2022	-
Revision	Scale @ ISO A1	Approved By
P1	1:50@A1	-
Drawing Number 559-PWL-ZZ-ZZ-DR-A-PL_100		

