

THE CONTRACTOR IS TO CHECK AND VERIFY ALL BUILDING AND SITE DIMENSIONS, LEVELS AND SEWER INVERT LEVELS AT CONNECTION POINTS BEFORE WORK STARTS.


THIS DRAWING IS TO BE READ AND CHECKED IN CONJUNCTION WITH ENGINEERS AND OTHER SPECIALIST DRAWINGS & SPECIFICATIONS.

THE DRAWING AND THE WORKS DEPICTED ARE THE COPYRIGHT OF PAWLUK+WEDMER LTD AND MAY NOT BE REPRODUCED EXCEPT BY WRITTEN PERMISSION.

NOTES

TO BE READ IN CONJUNCTION WITH DEMOLITION GA PLANS, SECTIONS, ELEVATIONS, FINISHES PLANS AND HERITAGE STATEMENT. REFER A2 TO A4 FOR DEEP ENGINEERS' STRIP OUT AND BUILDERS' WORK INFORMATION AND LIGHTING LAYOUTS.

TO BE READ IN CONJUNCTION WITH DEMOLITION GA
PLANS, SECTIONS, ELEVATIONS, FINISHES PLANS AND
HERITAGE STATEMENT. REFER ALSO TO MEP
ENGINEERS' STRIP OUT AND BUILDERSWORK
INFORMATION AND LIGHTING LAYOUTS .

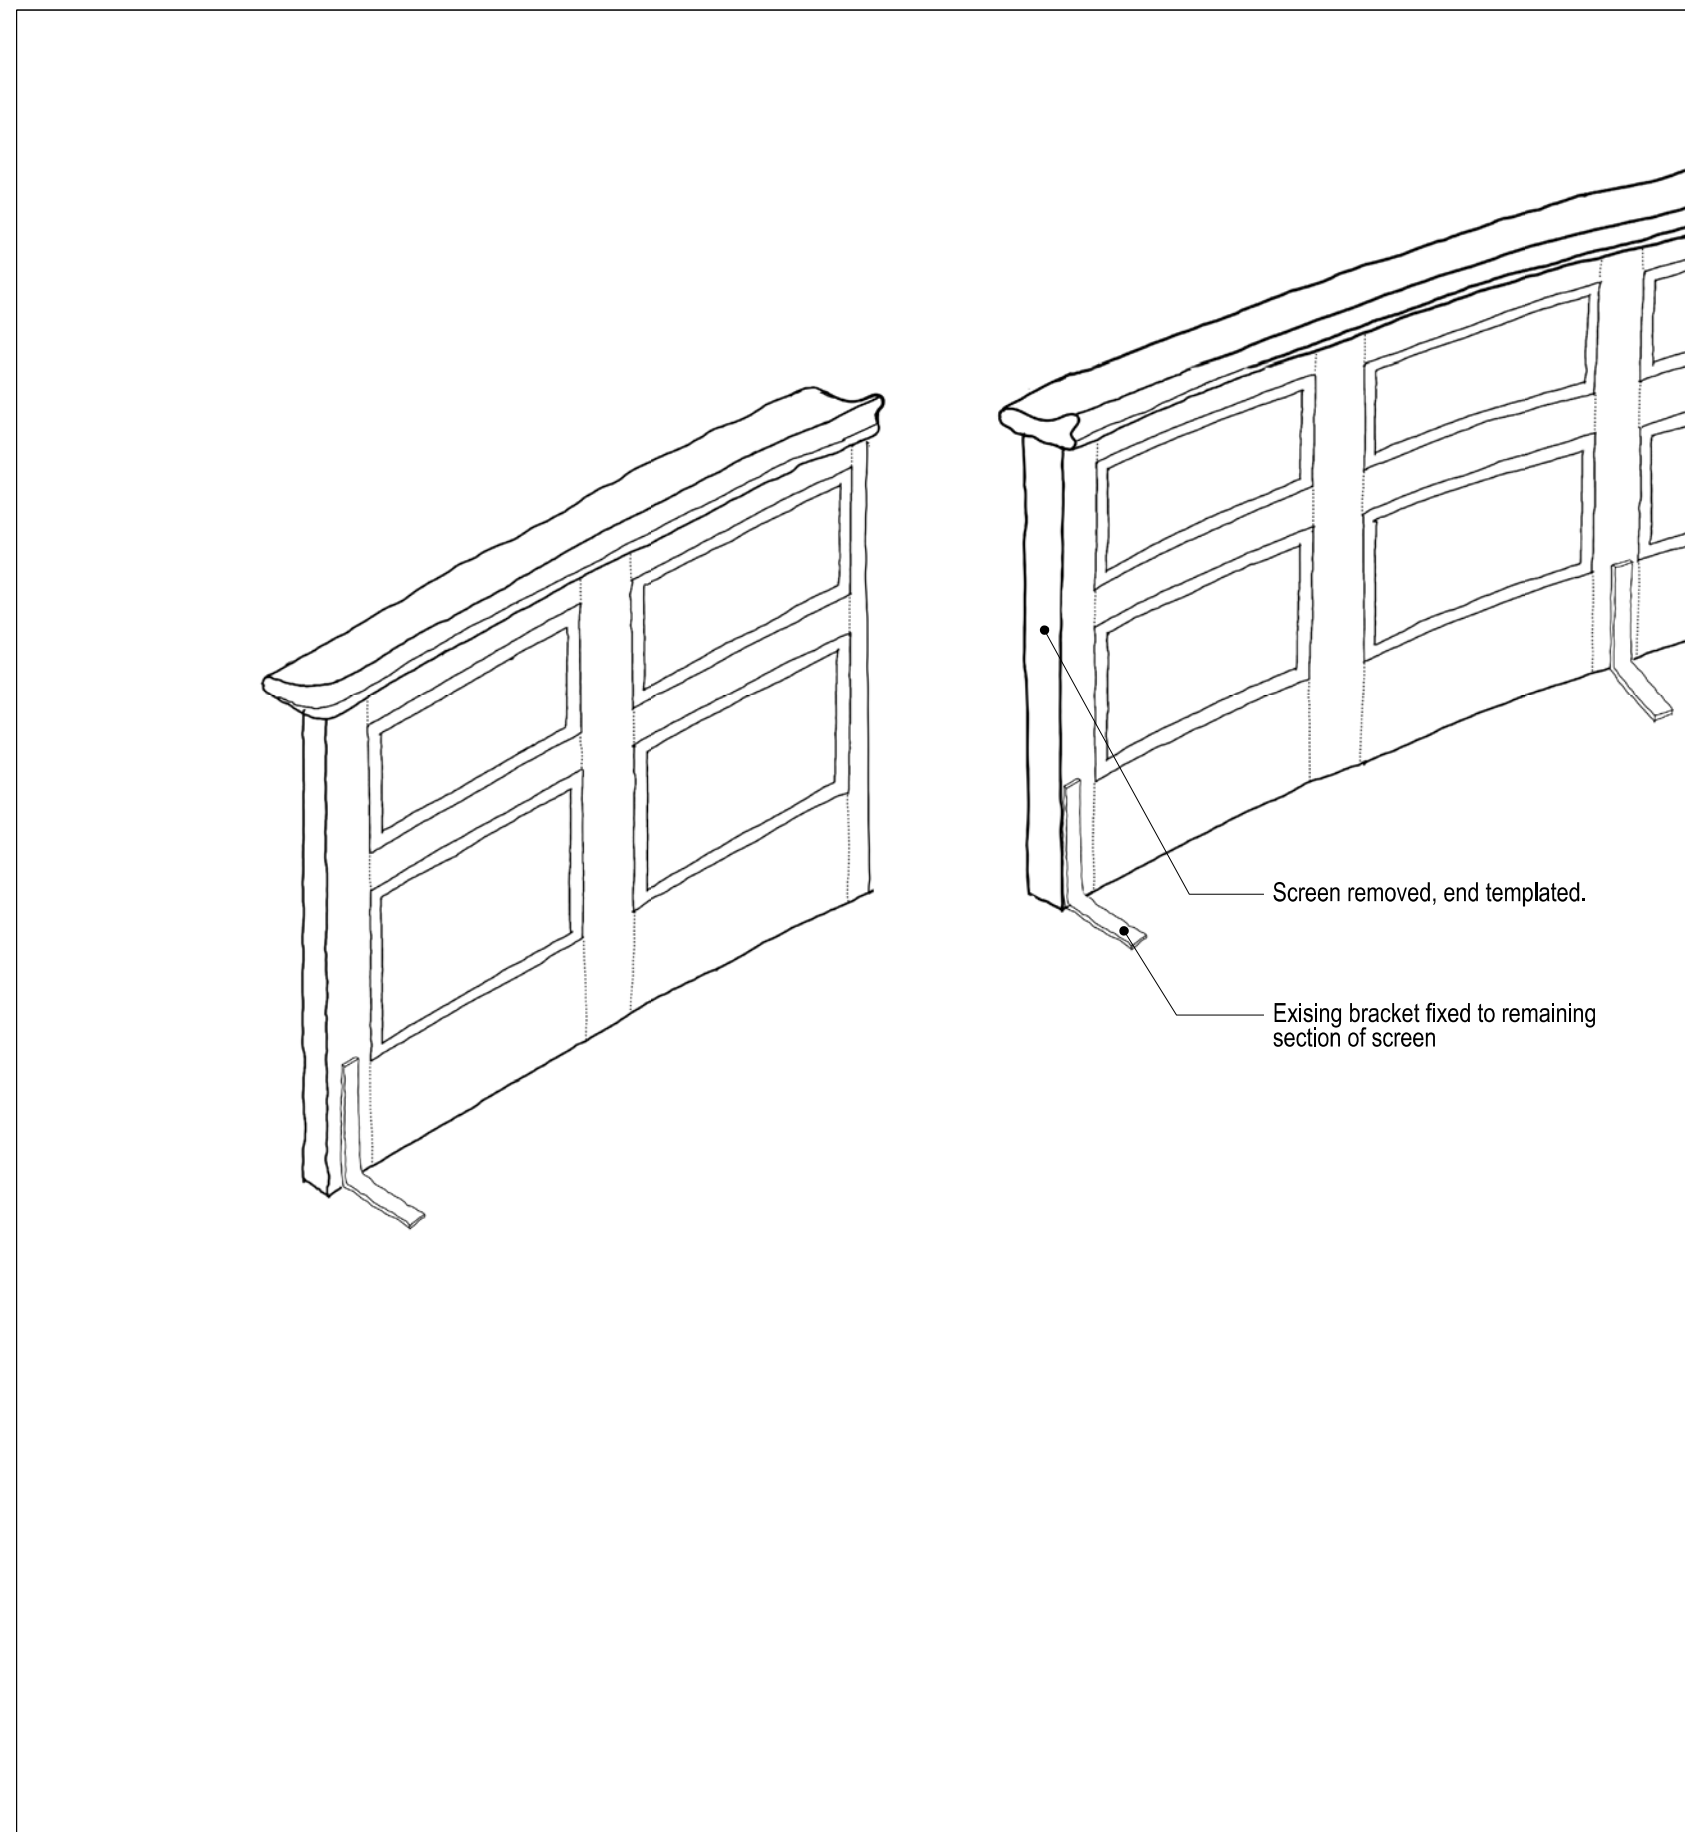

3 STEP - 03 NTS

Support Brakets are amended

[illegible]

Project Number 559	Date May 2023	Checked By -
Revision -	Scale @ ISO A1 NTS	Approved By -

Drawing Number
559-PWL-ZZ-ZZ-DR-A-01_415