

DO NOT SCALE


THE CONTRACTOR IS TO CHECK AND VERIFY ALL BUILDING AND SITE DIMENSIONS, LEVELS AND SEWER INVERT LEVELS AT CONNECTION POINTS BEFORE WORK STARTS.

THIS DRAWING IS TO BE READ AND CHECKED IN CONJUNCTION WITH ENGINEERS AND OTHER SPECIALIST DRAWINGS & SPECIFICATIONS.


THE DRAWING AND THE WORKS DEPICTED ARE THE COPYRIGHT OF PAWLIK+WIEDMER LTD AND MAY NOT BE REPRODUCED EXCEPT BY WRITTEN PERMISSION.

NOTES


TO BE READ IN CONJUNCTION WITH DEMOLITION GA PLANS, SECTIONS, ELEVATIONS, FINISHES PLANS AND HERITAGE STATEMENT. REFER ALSO TO MEP ENGINEERS' STRIP OUT AND BUILDERSWORK INFORMATION AND LIGHTING LAYOUTS .

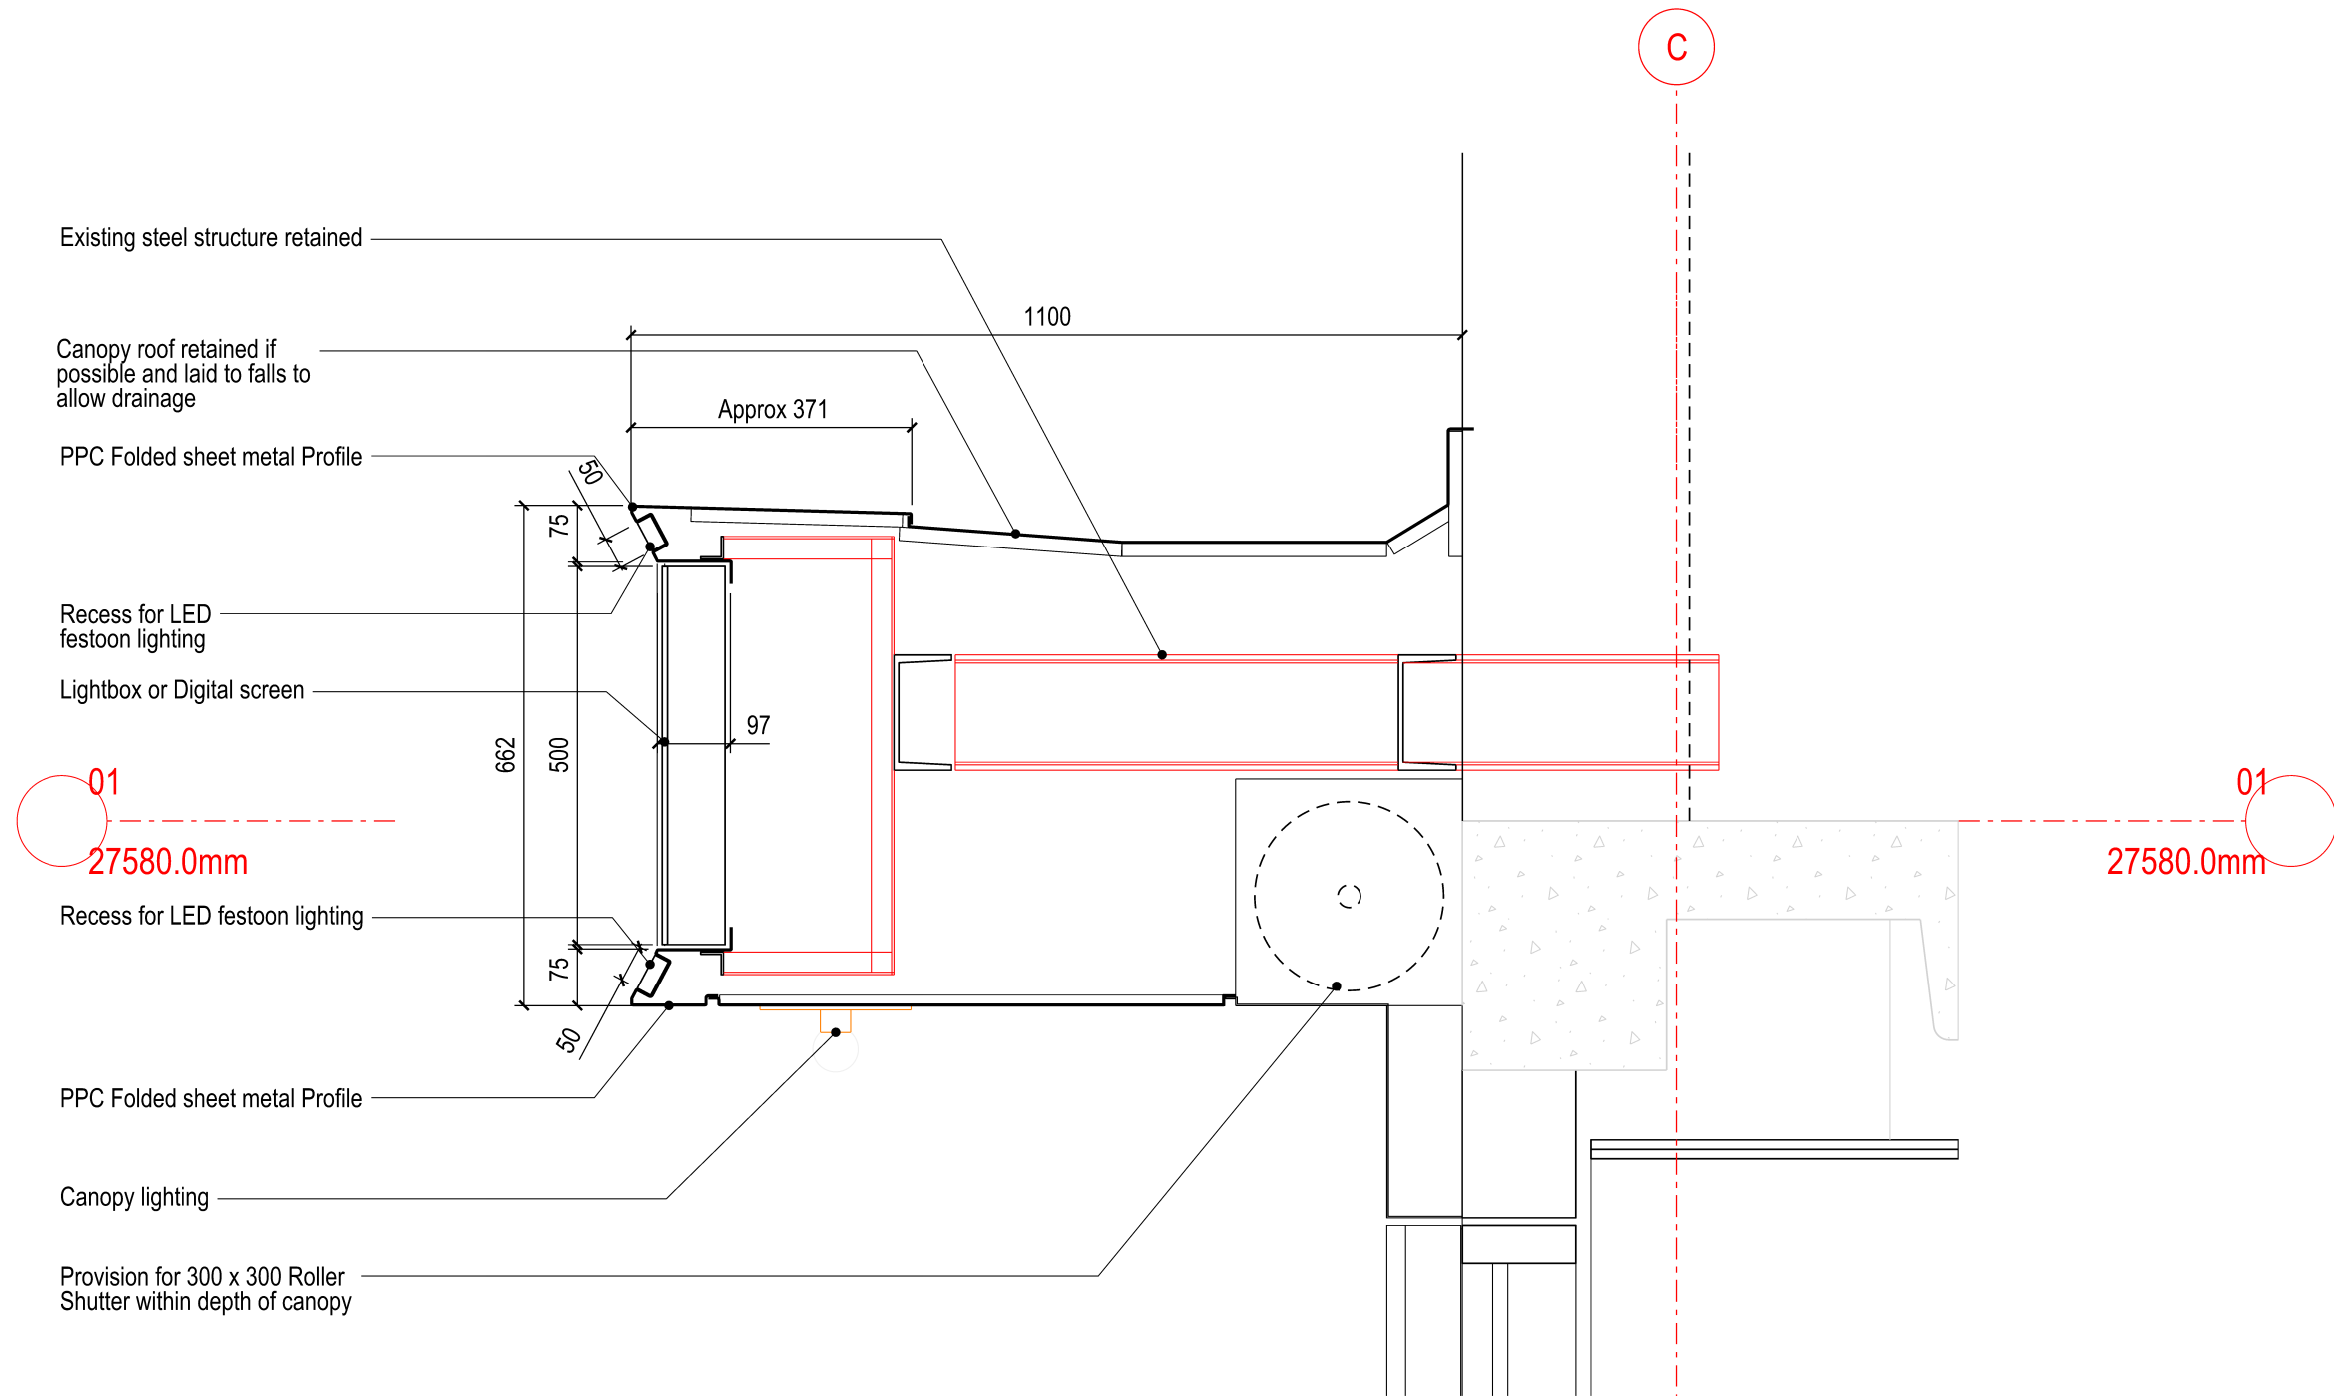


1 DETAIL  
Typical Section Thru Canopy 1:10

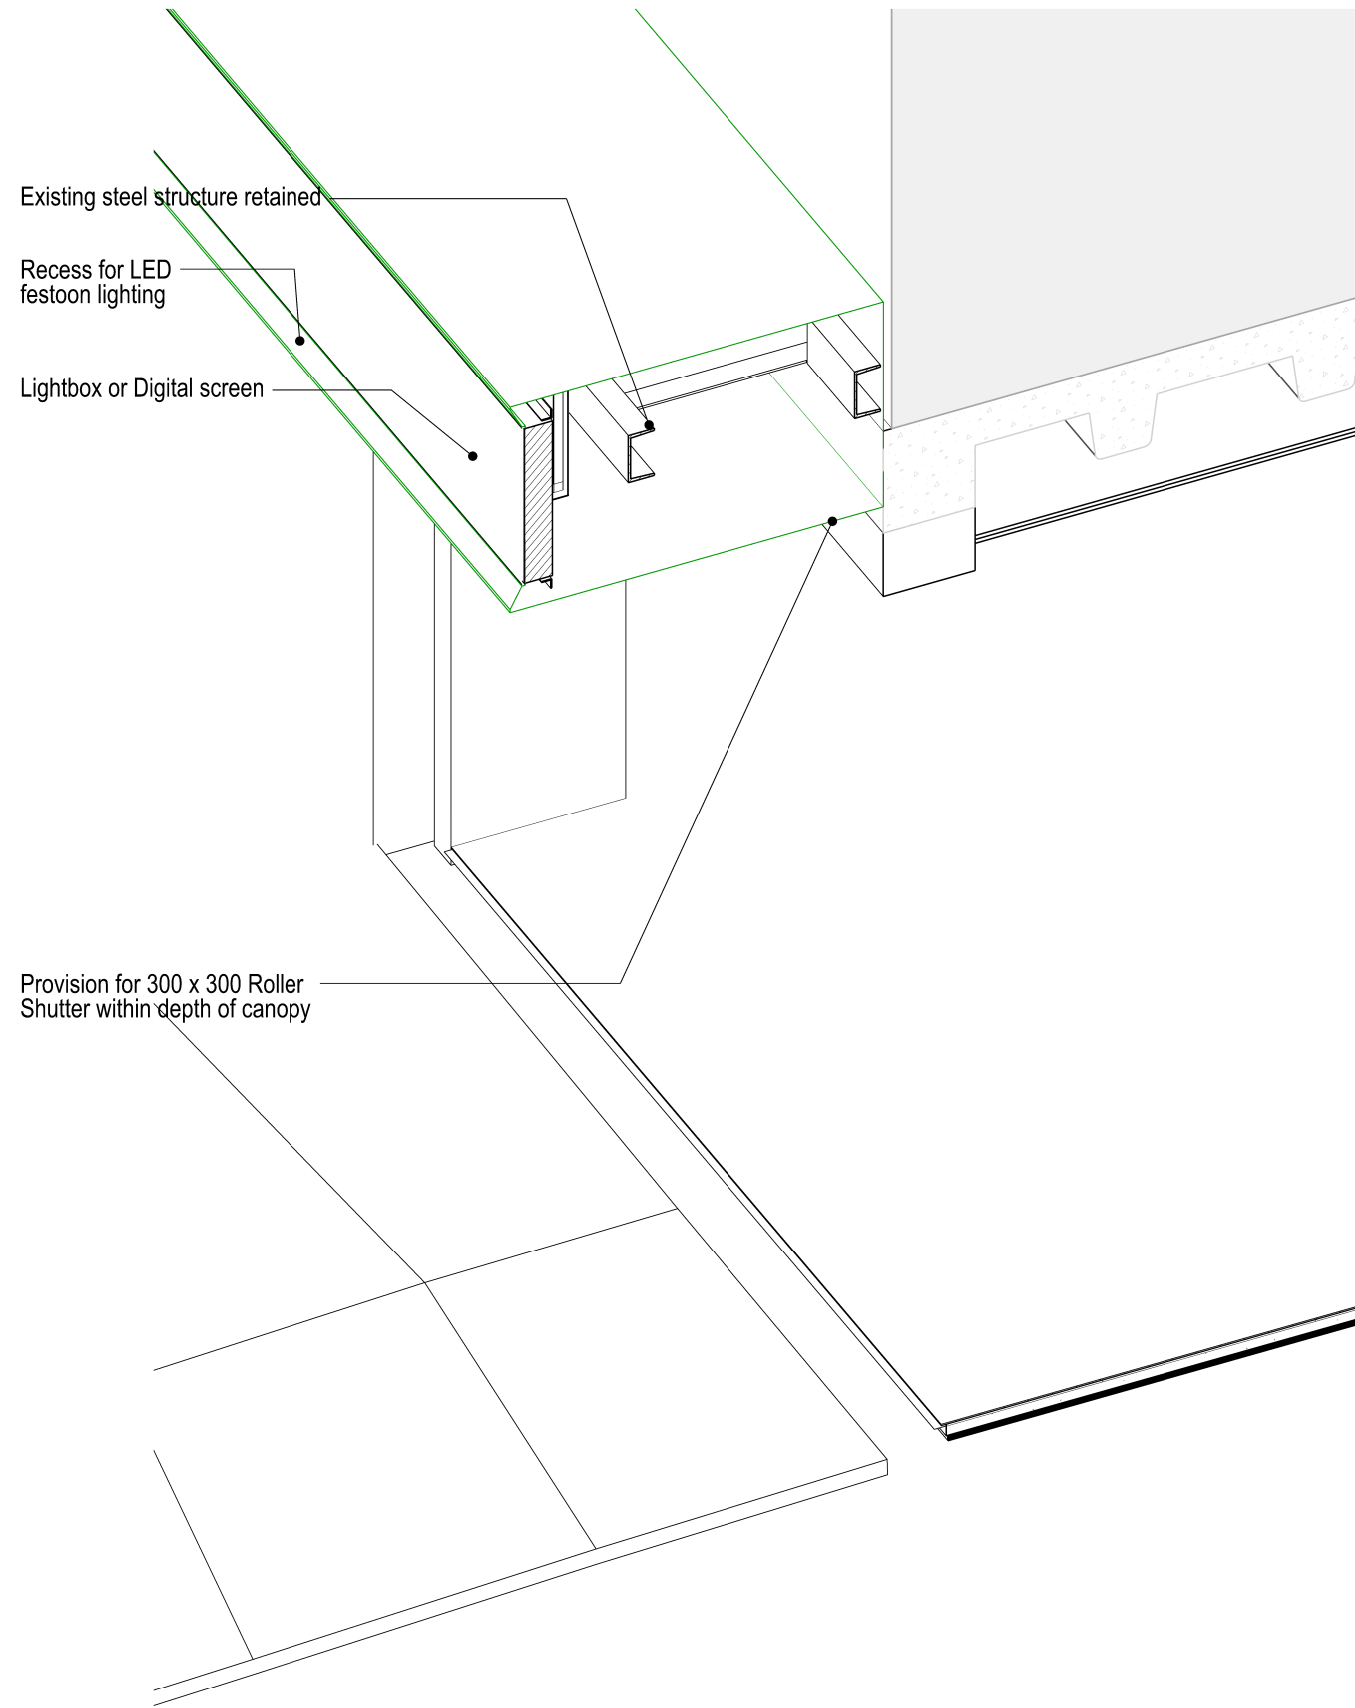


3 ISO View  
New Canopy 1:20

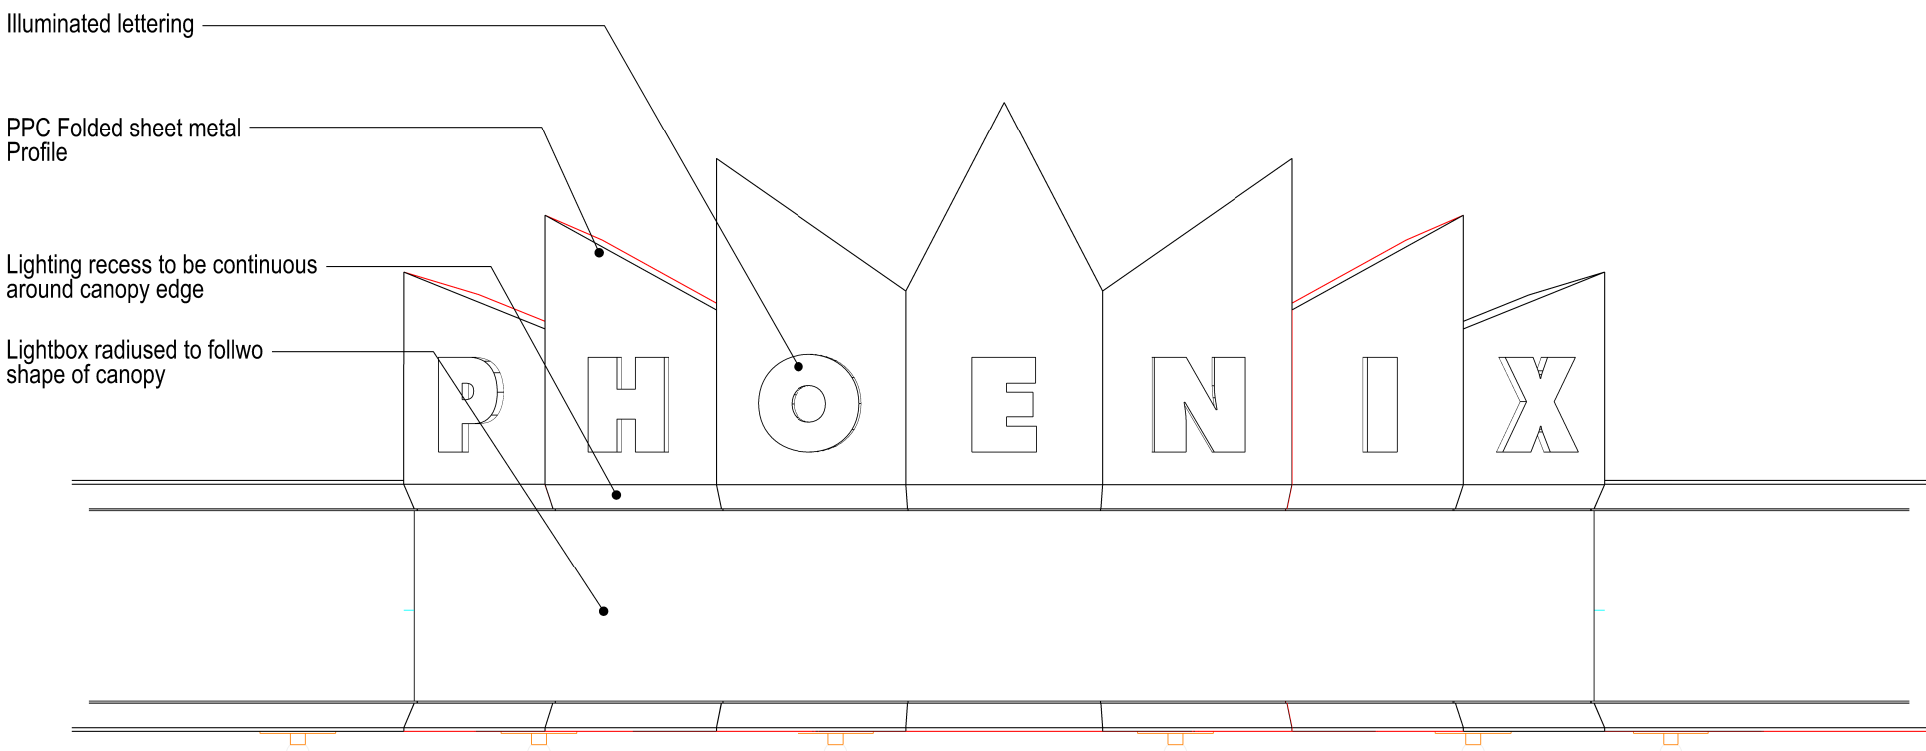

2 DETAIL  
Front Elevation of Corner 1:20

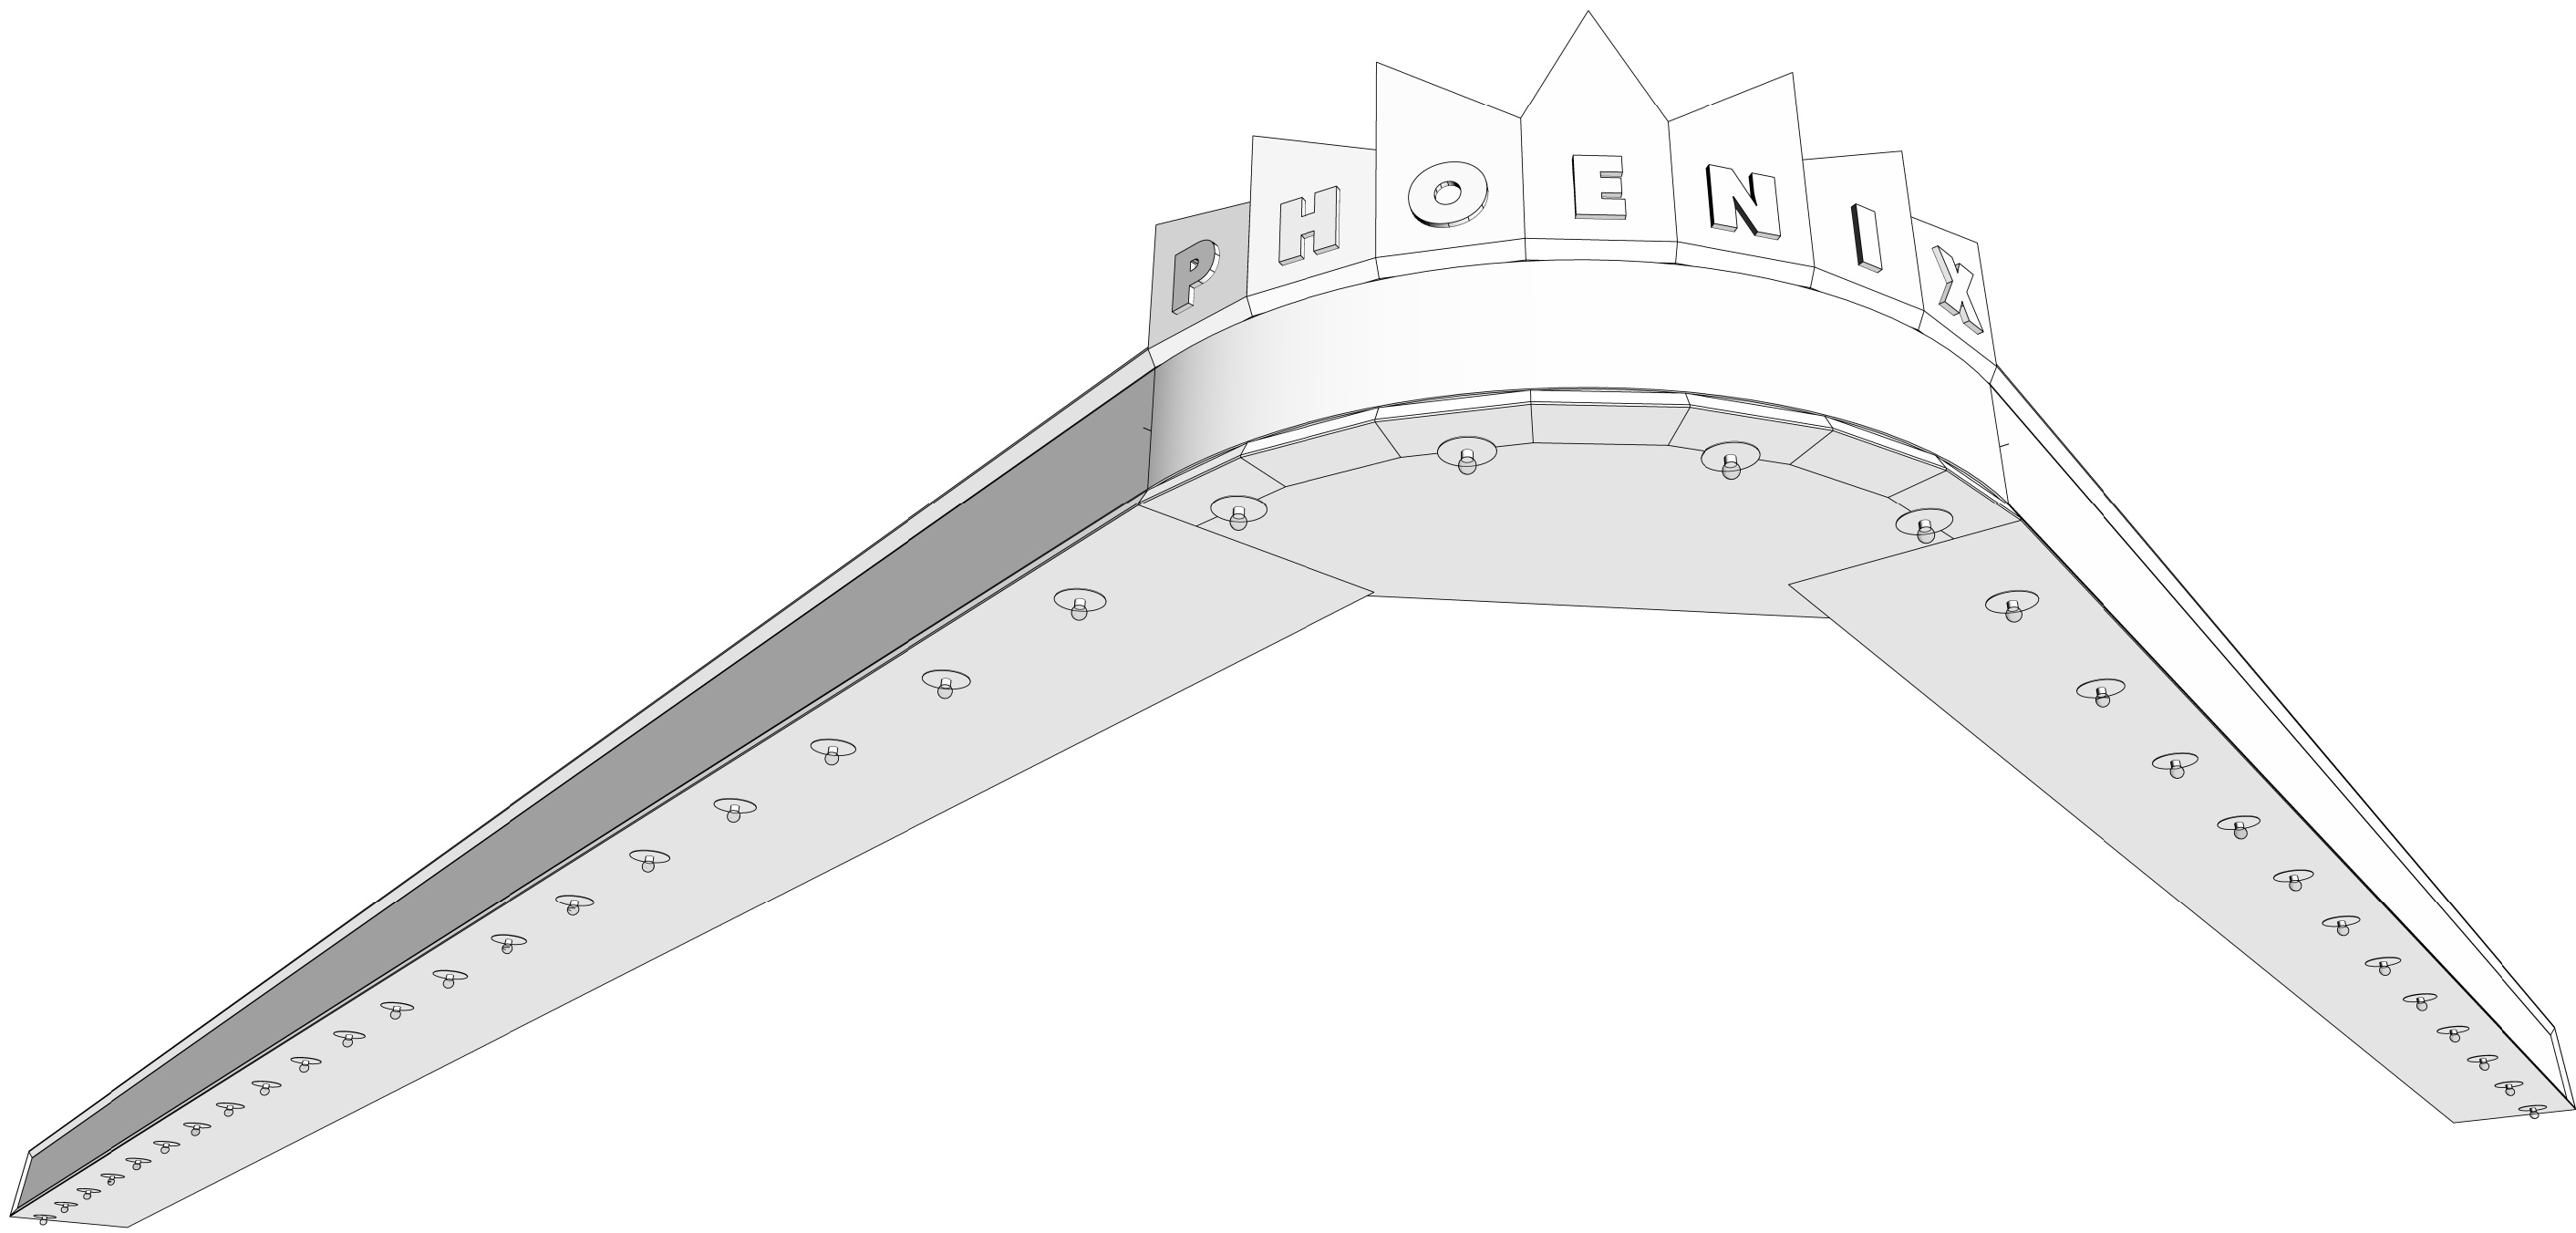


4 ILLUSTRATION  
Canopy viewed from Below NTS

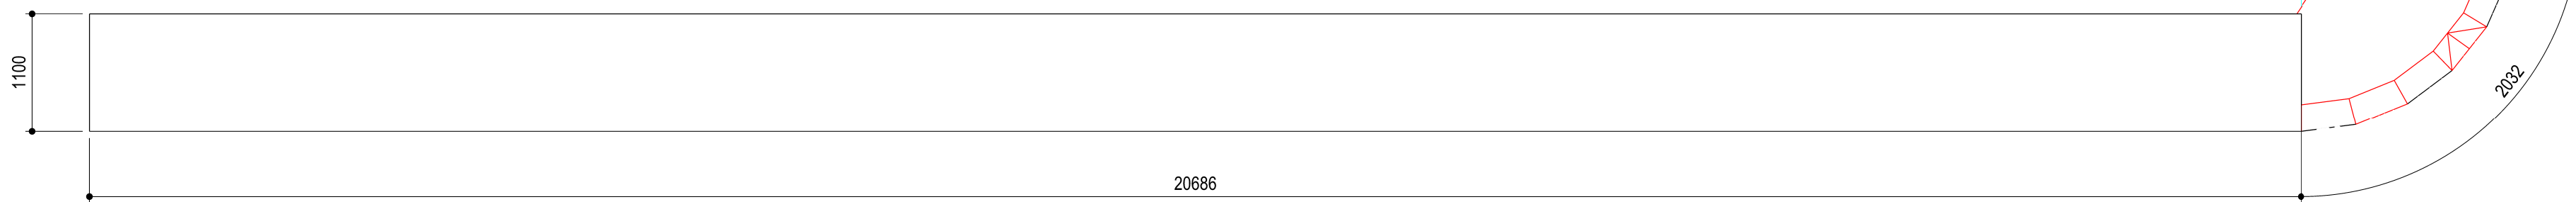

5 PLAN  
Top view of canopy 1:20

--	-	-	-
P1	13.06.2023	Phoenix motif omitted	NP
Rev	Date	Reason For Issue	Chk

Key Plan

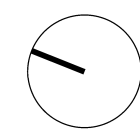

pawlik + wiedmer

8-12 Creekside  
London  
SE8 3DX  
london@pawlikwiedmer.com  
Registered in England & Wales No: 8155464  
Registered Office: 27 Mortimer Street, W1T 3BL, UK

Client  
Phoenix Theatre  
Charing Cross Road  
Ambassador Theatre Group

Project  
Project Ash  
Phoenix Theatre  
Charing Cross Road  
-

Title  
New Canopy  
Charing Cross Road  
Proposed

Status  
PRELIMINARY

Project Number 559	Date SEPT 2022	Checked By -
Revision P1	Scale @ ISO A1 1:50@A1	Approved By -

Drawing Number  
559-PWL-ZZ-ZZ-DR-A-01\_400