

S				SIGNAGE FIXTURE SCHEDULE			
DESIGN ID	COUNT	DESCRIPTION		RESP COMMENTS			
XS018	1	LOGO DISK PERPENDICULAR DOUBLE SIDED INTERNALLY ILLUMINATED LARGE - 750MM		CM	-		
XS106	1	WORDMARK SURFACE MOUNTED HALO-LIT LARGE - 300MM		CM	-		
XS308	1	MOP SIGN - CEILING ILLUMINATED		CM	SINGLE SIDED SIGN		

Y				SITE SCHEDULE			
DESIGN ID	COUNT	DESCRIPTION		RESP COMMENTS			
16209	2	SCREEN - MOVABLE STRUNG CANVAS - BLACK CANVAS F0061		VD	-		
XY001	1	CUSTOM AWNING - OUTDOOR FABRIC F0165		GC	-		

ARCHITECTURAL SITE PLAN NOTES
1. REFER TO EXTERIOR ELEVATIONS ON SHEET A-2001
FOR BUILDING SIGNAGE LOCATION AND DESIGN ID. SEE
ELECTRICAL DETAILS FOR ALL ASSOCIATED POWER
REQUIREMENTS.

CM/PM TO ADVISE CONFIRM ALL
DIMENSIONS TO STARBUCKS

SITE DEMISE LEGEND

- BUILD-ABLE DEMISE
--- EXTERNAL DEMISE



STARBUCKS COFFEE
COMPANY

2401 UTAH AVENUE SOUTH
SEATTLE, WASHINGTON 98134
(206) 318-1575

DRAWINGS AND SPECIFICATIONS ARE
CONFIDENTIAL AND SHALL REMAIN THE SOLE
PROPERTY OF STARBUCKS CORPORATION,
WHICH IS THE OWNER OF THE COPYRIGHT IN
THIS WORK. THEY SHALL NOT BE
REPRODUCED (IN WHOLE OR IN PART),
SHARED WITH THIRD PARTIES OR USED IN
ANY MANNER ON OTHER PROJECTS OR
EXTENSIONS TO THIS PROJECT WITHOUT THE
PRIOR WRITTEN CONSENT OF STARBUCKS
CORPORATION. THESE DRAWINGS AND
SPECIFICATIONS ARE INTENDED TO EXPRESS
DESIGN INTENT FOR A PROTOTYPICAL
STARBUCKS STORE (WHICH IS SUBJECT TO
CHANGE AT ANYTIME) AND DO NOT
REFLECT ACTUAL SITE CONDITIONS. NEITHER
PARTY SHALL HAVE ANY OBLIGATION NOR
LIABILITY TO
THE OTHER (EXCEPT STATED ABOVE) UNTIL
A WRITTEN AGREEMENT IS FULLY EXECUTED.
STARBUCKS CORPORATION VERSION EMEA
2019_01

ARCHITECT OF RECORD
THIS DRAWING IS A DESIGN DEVELOPMENT
DOCUMENT. SITE SPECIFIC MODIFICATIONS
MADE UNDER THE RESPONSIBLE CHARGE OF
THE ARCHITECT AND/OR
ENGINEER OF RECORD WILL BE REQUIRED
PRIOR TO USING THIS DOCUMENT FOR
BIDDING, PERMITTING, OR CONSTRUCTION.

ISSUED FOR CONSTRUCTION

PROJECT NAME:
HIGH HOLBORN 262

PROJECT ADDRESS:
UK
LONDON
262 High Holborn

STORE # 79198
PROJECT # 99978-001
PLAYBOOK FORMATTALL

INITIAL ISSUE DATE 31/03/23
DESIGN MANAGER AARON WEST
PROJECT DESIGNER CAT SPARKES
CHECKED BY AN

REVISION SCHEDULE


REV	DATE	BY	DESCRIPTION
1	03/04/23		CONSTRUCTION ISSUE

SHEET TITLE:

Architectural Site Plan

SCALE: AS SHOWN (A3)

A-1001

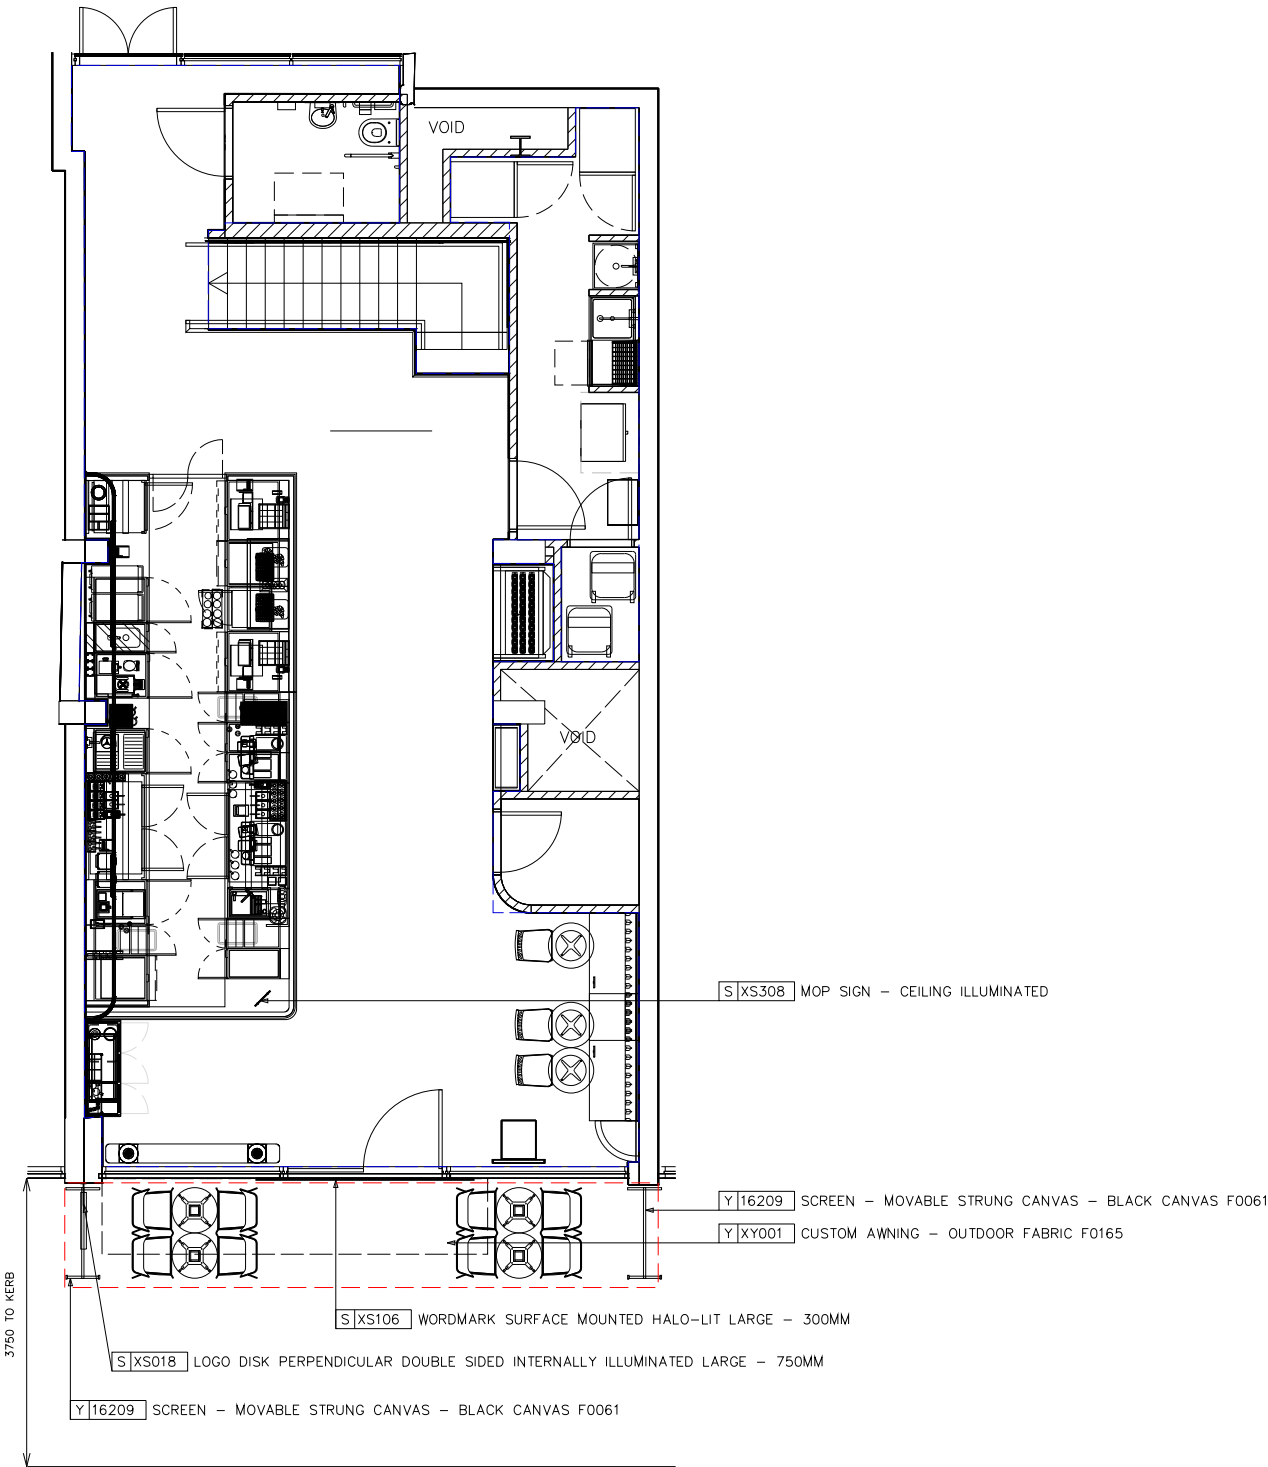

1 PROPOSED ARCHITECTURAL SITE PLAN
Scale: 1:100

ALL INTERNAL FINISHES TO ACHIEVE A
MINIMUM EN-13501-1 CLASSIFICATION OF
B-S3 D2

RESPONSIBILITY LEGEND
UNLESS OTHERWISE AGREED, ALL ITEMS SUPPLIED
ACCORDING TO PARTY LISTED IN "RESPONSIBILITY"
COLUMN

GC GENERAL CONTRACTOR
CS CASEWORK SUPPLIER
CM CONSTRUCTION MANAGER
LL LANDLORD
SB STARBUCKS
WH STARBUCKS WAREHOUSE (3PL)
VD STARBUCKS VENDOR DIRECT
LC LICENSEE

