



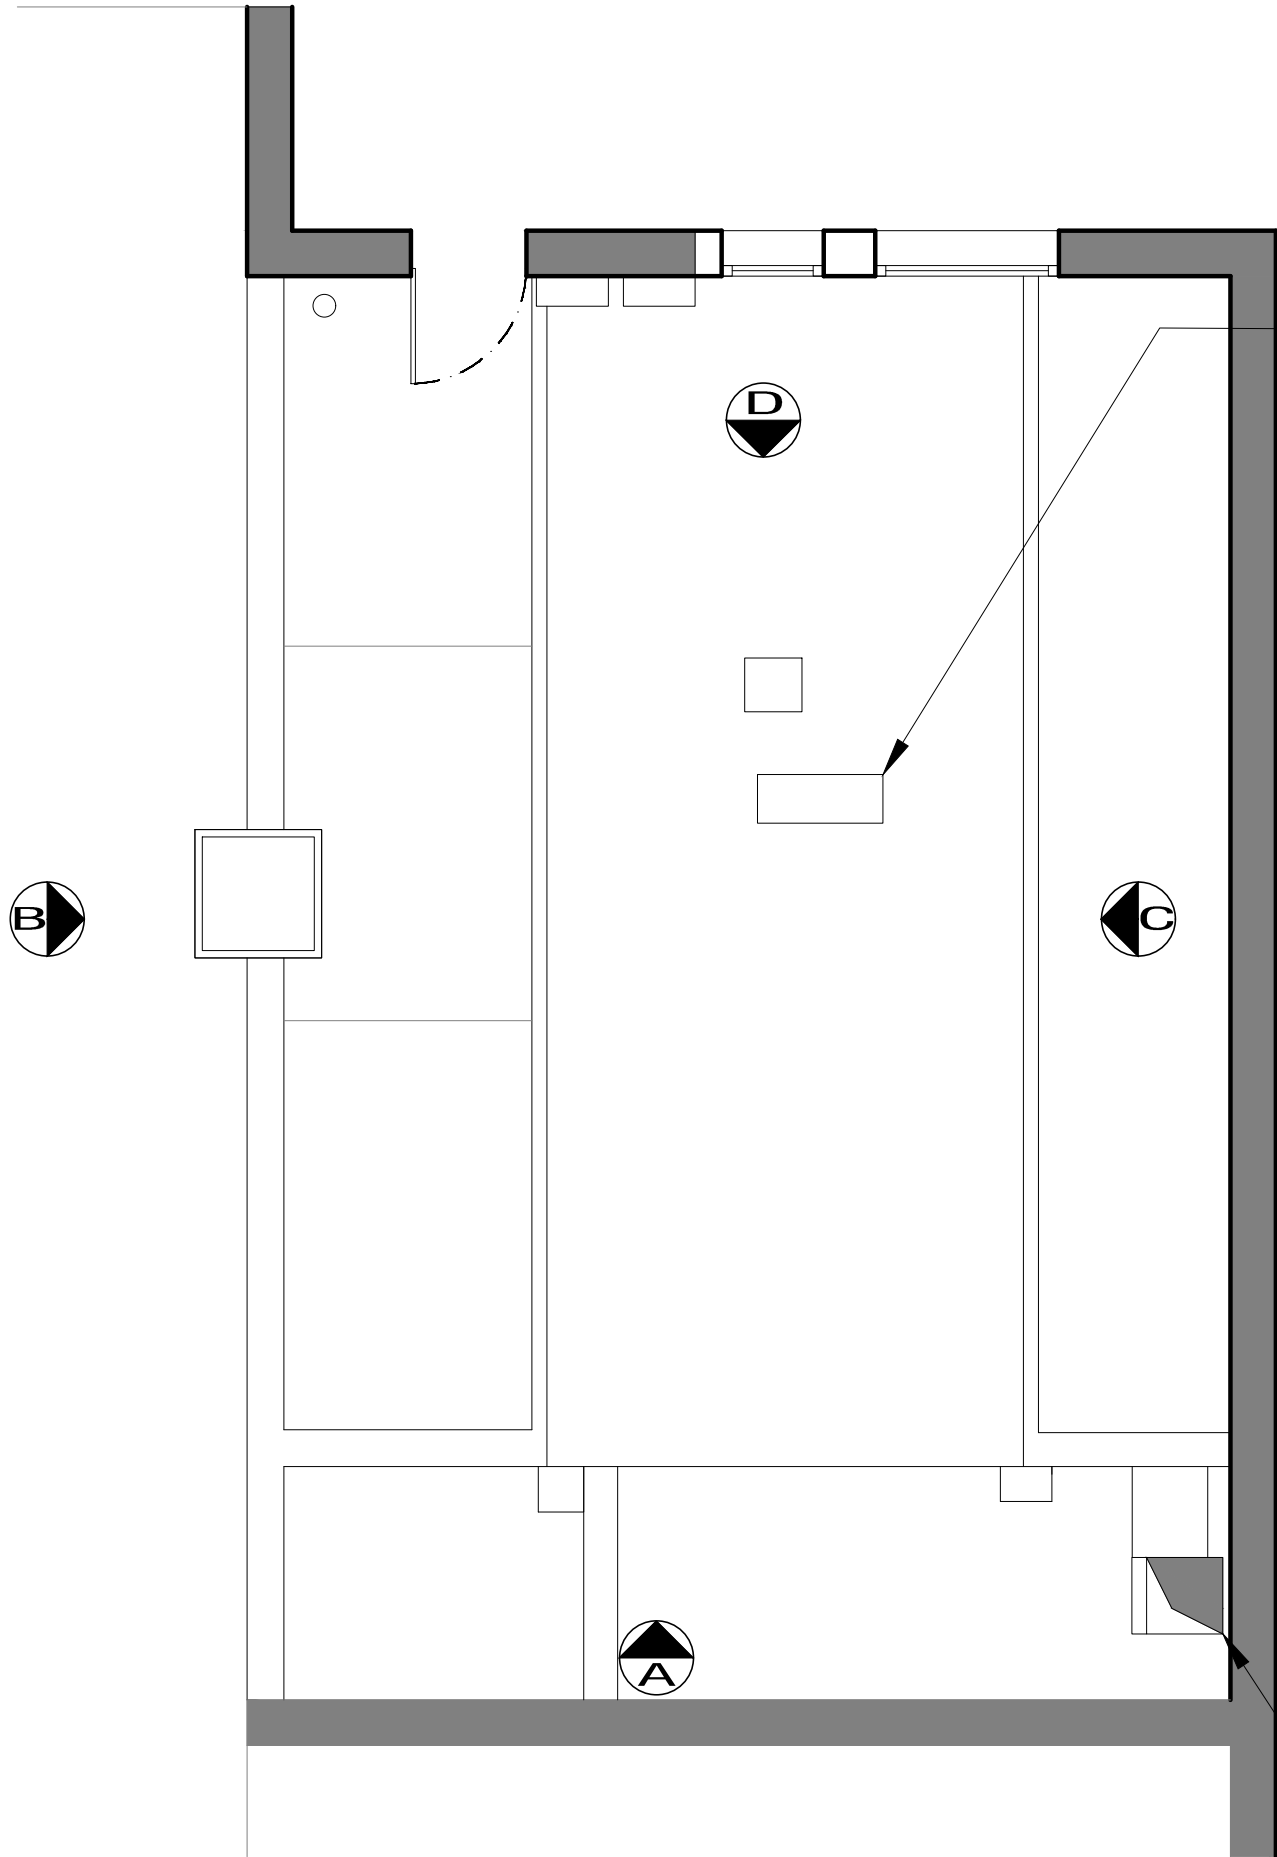

PRE EXISTING AC OUTDOOR UNIT

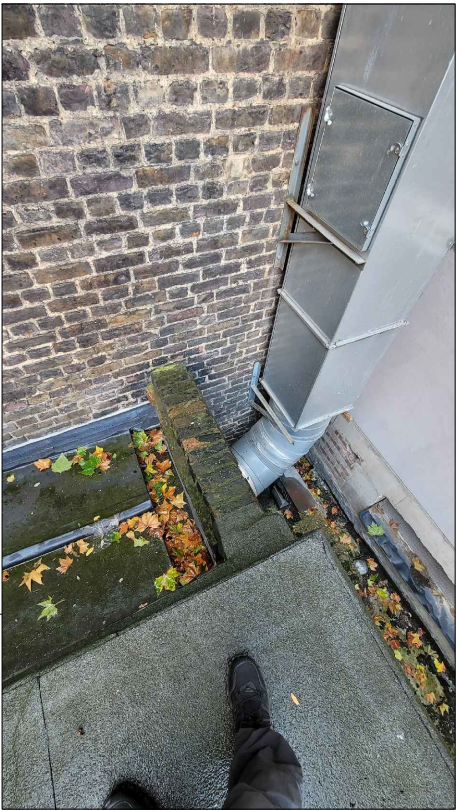

PRE EXISTING DUCTWORK

PROJECT NUMBER:

W096

WYDESIGN
40 GALLEYWALL ROAD
LONDON SE16 3PB
TEL:07818405078
WYDESIGNLTD@GMAIL.COM
©WYDESIGN LTD

KEYS:

REVISIONS:

PROJECT TITLE:
No.35 GRAYS INN RD.,
LONDON - WC1X 8PG

DRAWING TITLE:
PRE EXISTING AC
ROOF PLAN

SCALE:
1:50
@A3

CREATION DATE:
8TH JUNE 2023

209