



 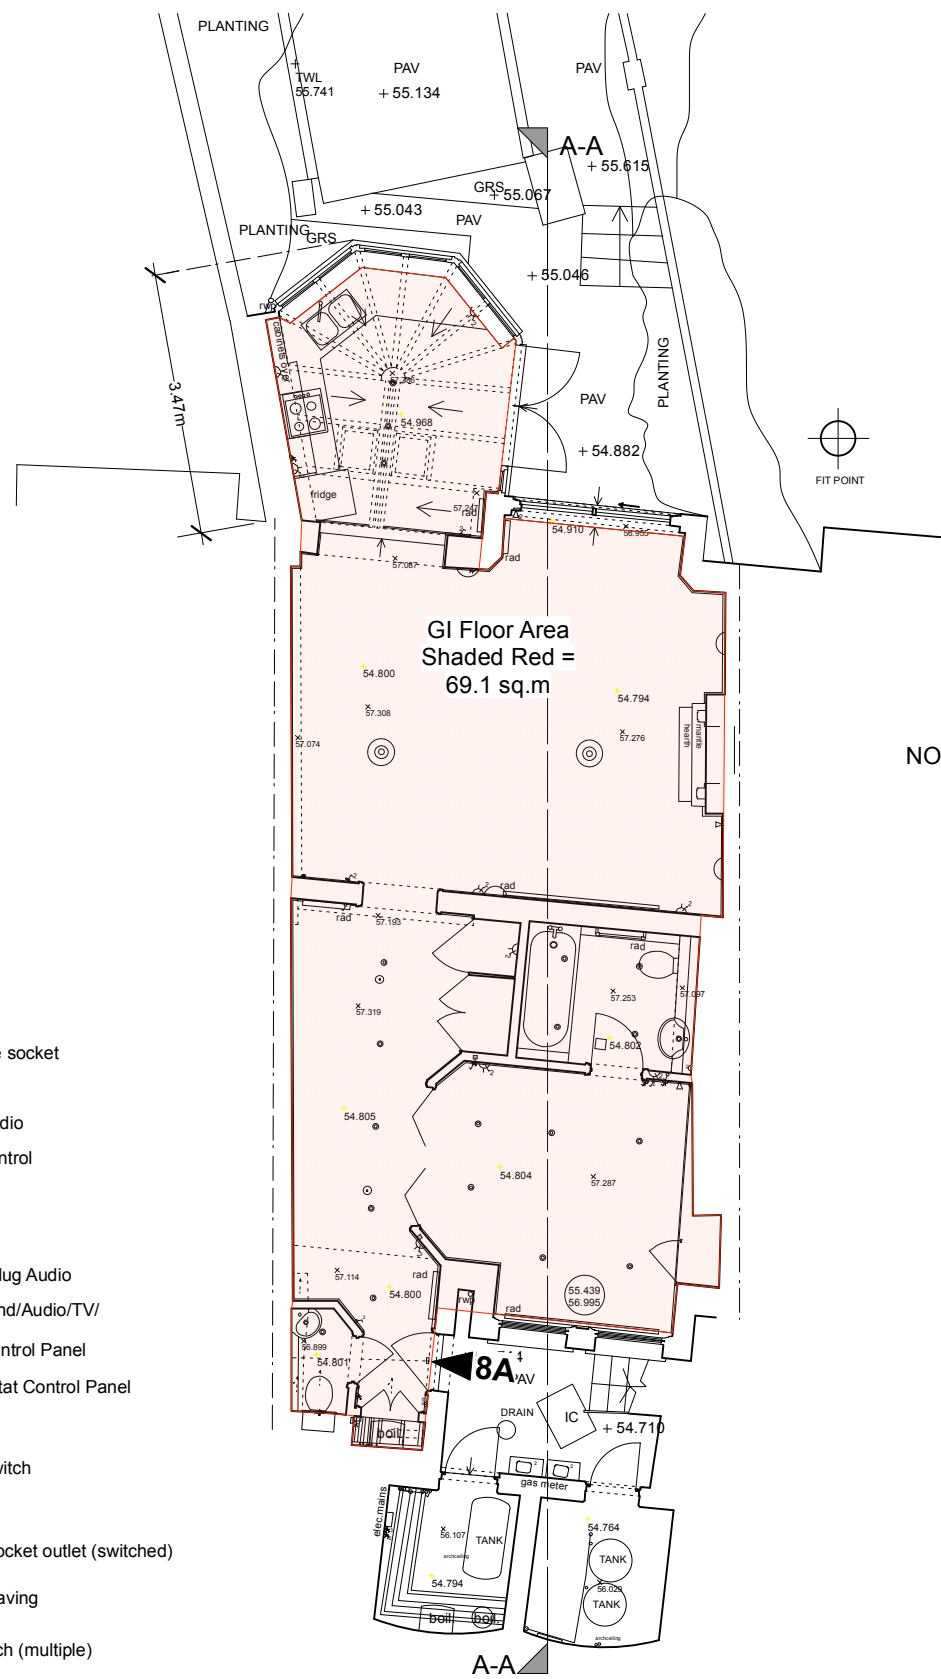


EXISTING LOWER GROUND FLOOR PLAN - No. 8A

 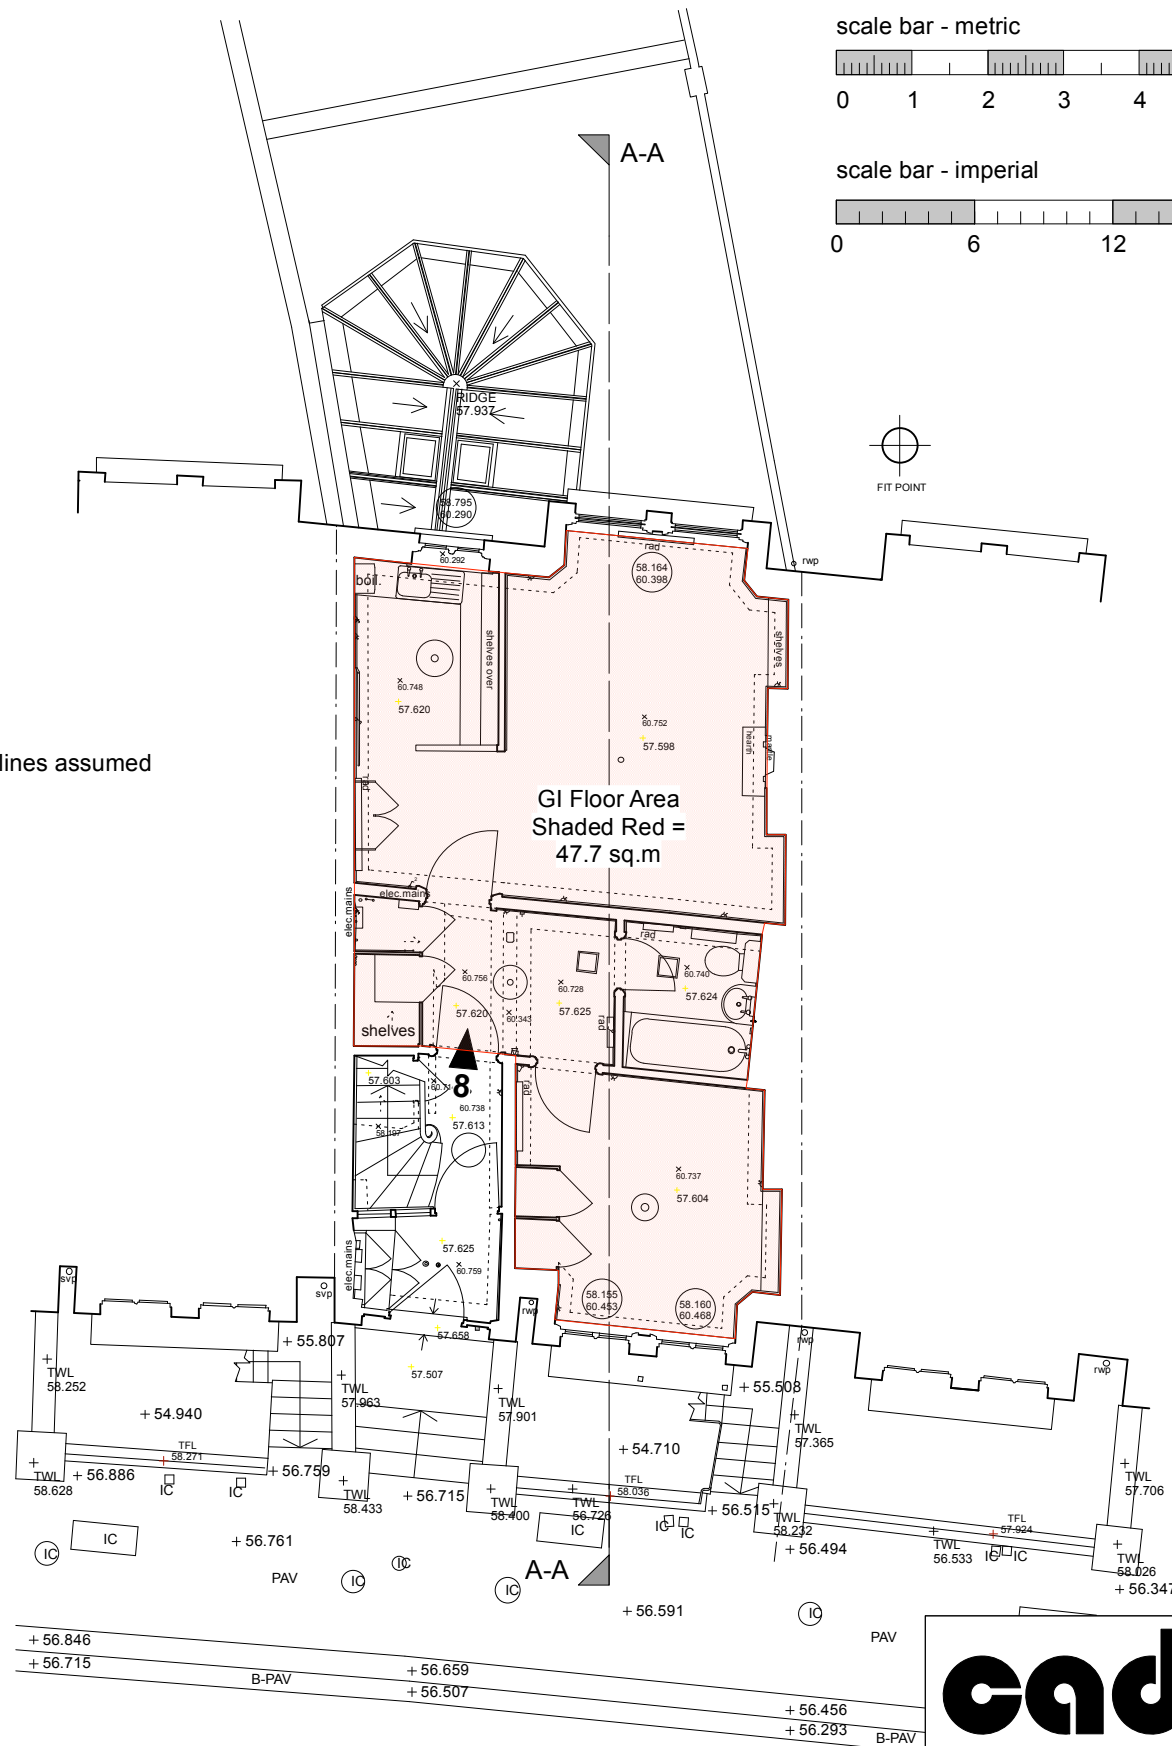


EXISTING UPPER GROUND FLOOR PLAN - No. 8

scale bar - metric



scale bar - imperial



KEY:

- telephone socket
- Door Bell
- Alarm Audio
- Alarm control
- TV
- comms
- Socket plug Audio
- Broadband/Audio/TV/
- Audio Control Panel
- Thermostat Control Panel
- fuse
- fuse + switch
- unk unknown
- 2 double socket outlet (switched)
- plug - shaving
- light switch (multiple)
- dimmer switch (multiple)
- blank pattress box
- lighting points
- 0.985 floor to cill, cill to head window
- 4.844 Ceiling Level
- vent
- speaker
- smoke alarm
- motion sensor/cam

NOTE - boundary lines assumed



CAD Surveys Ltd.
Suite 2 KPC House
Canterbury Road
Willesborough
Ashford
TN24 0BP

www.cadsurveys.co.uk

01233 635089

Project :
8 + 8A Primrose Gardens
London NW3 4TN

Drawn by :
SC

Drawing title :
Existing Lower Ground and
Ground Floor Plans

Scale:
1:100@A3/1:50@A1

Date :
05/07/2022

Ref :
1129-S2-02