



Notes:

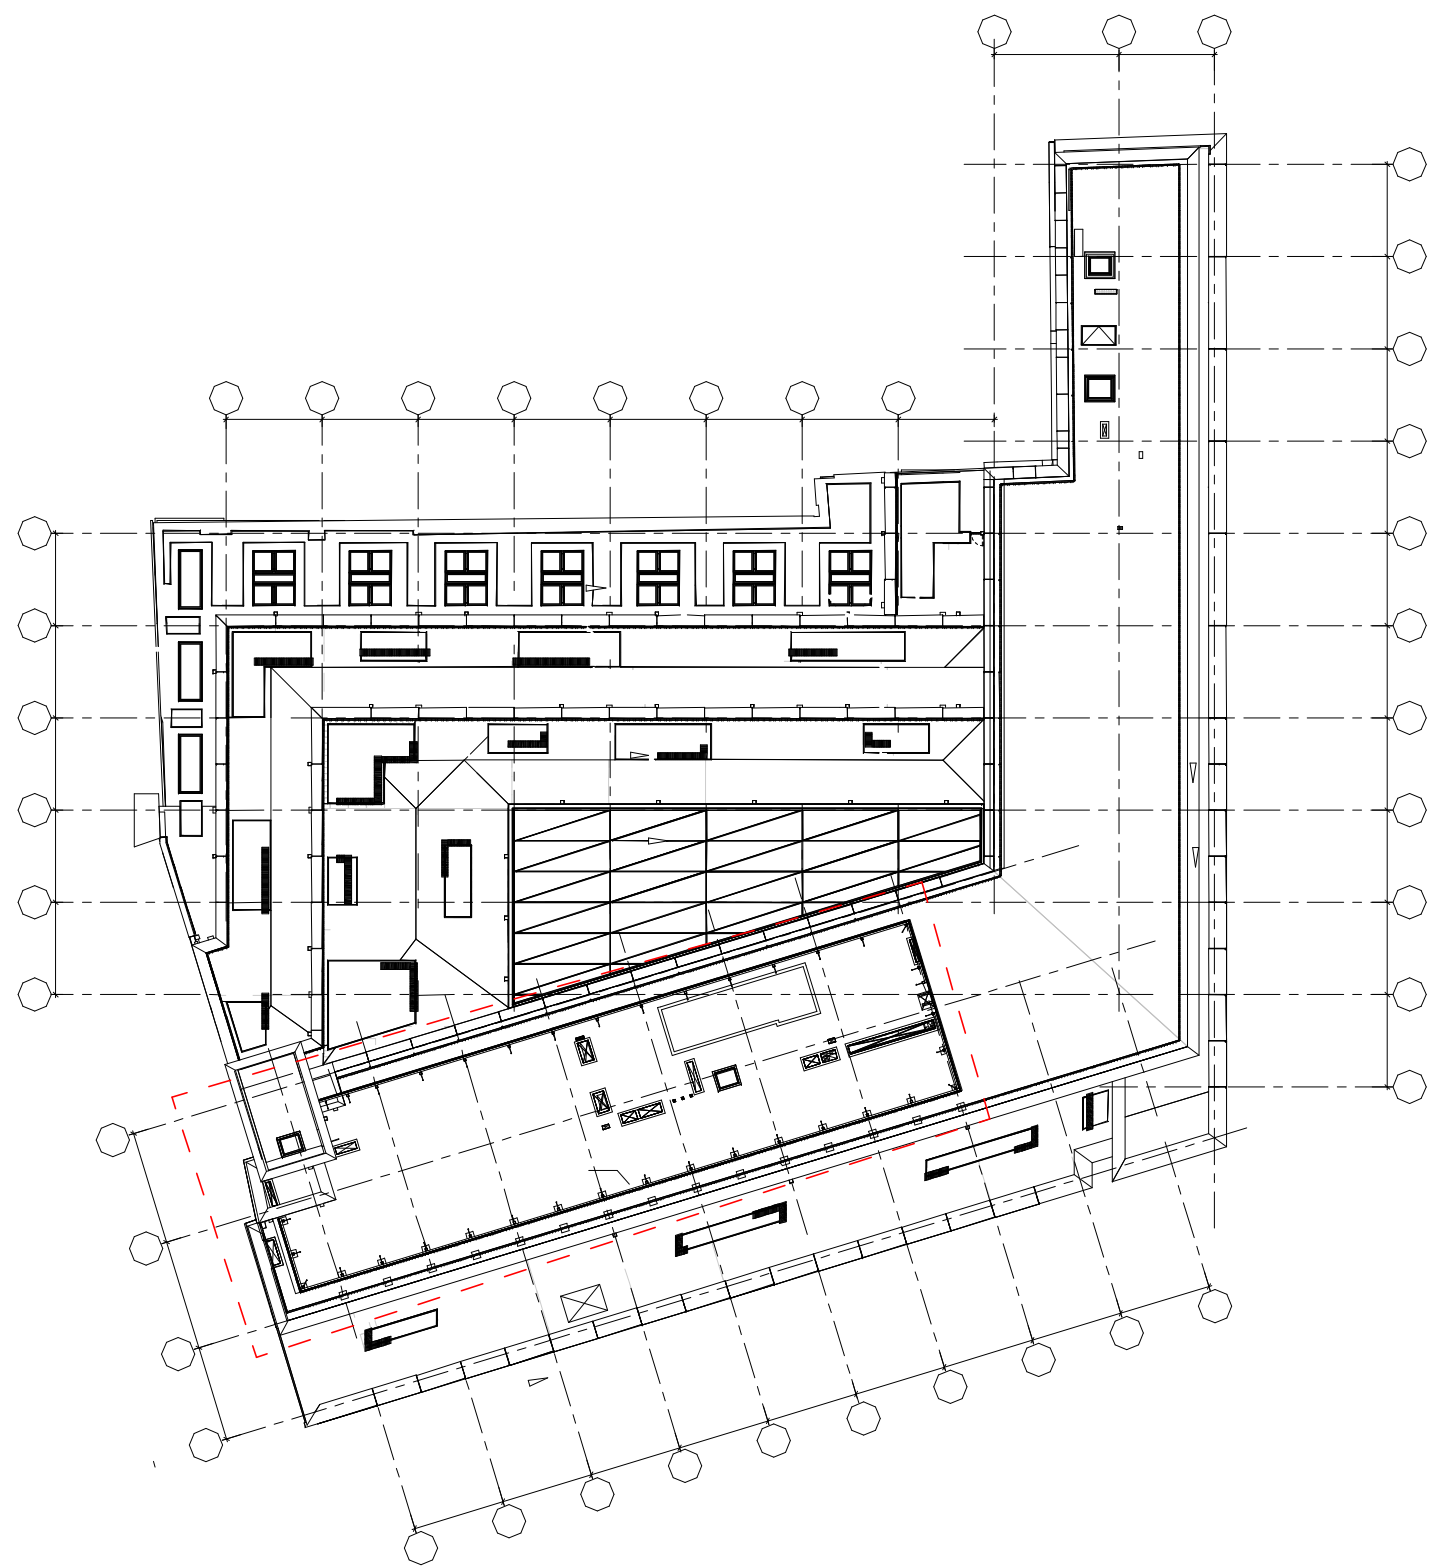


1 Roof Plan - Existing

Scale 1 : 500

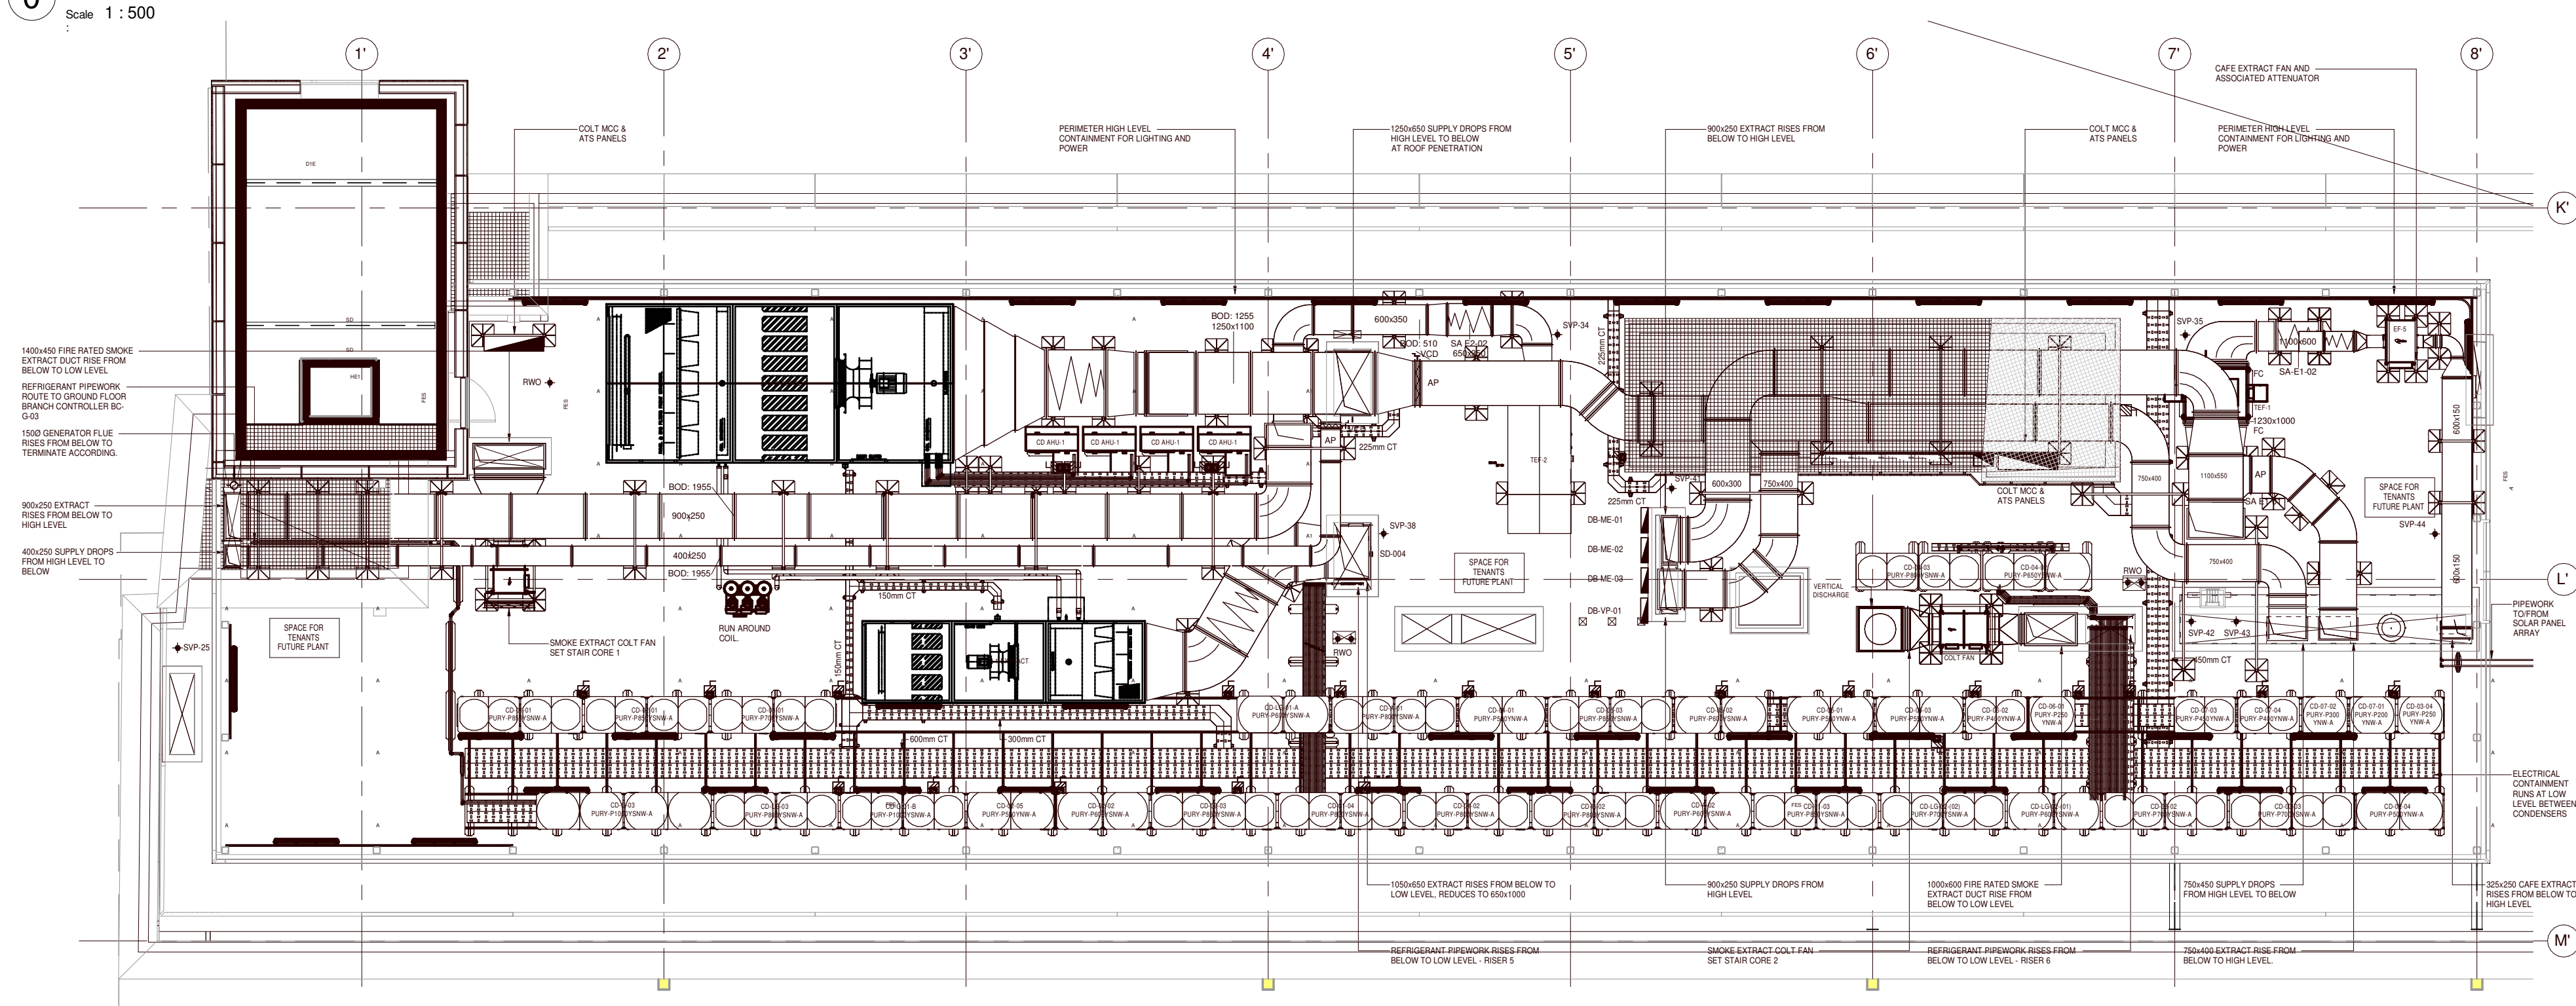

2 Existing Roof Mechanical Plan

Scale 1 : 100

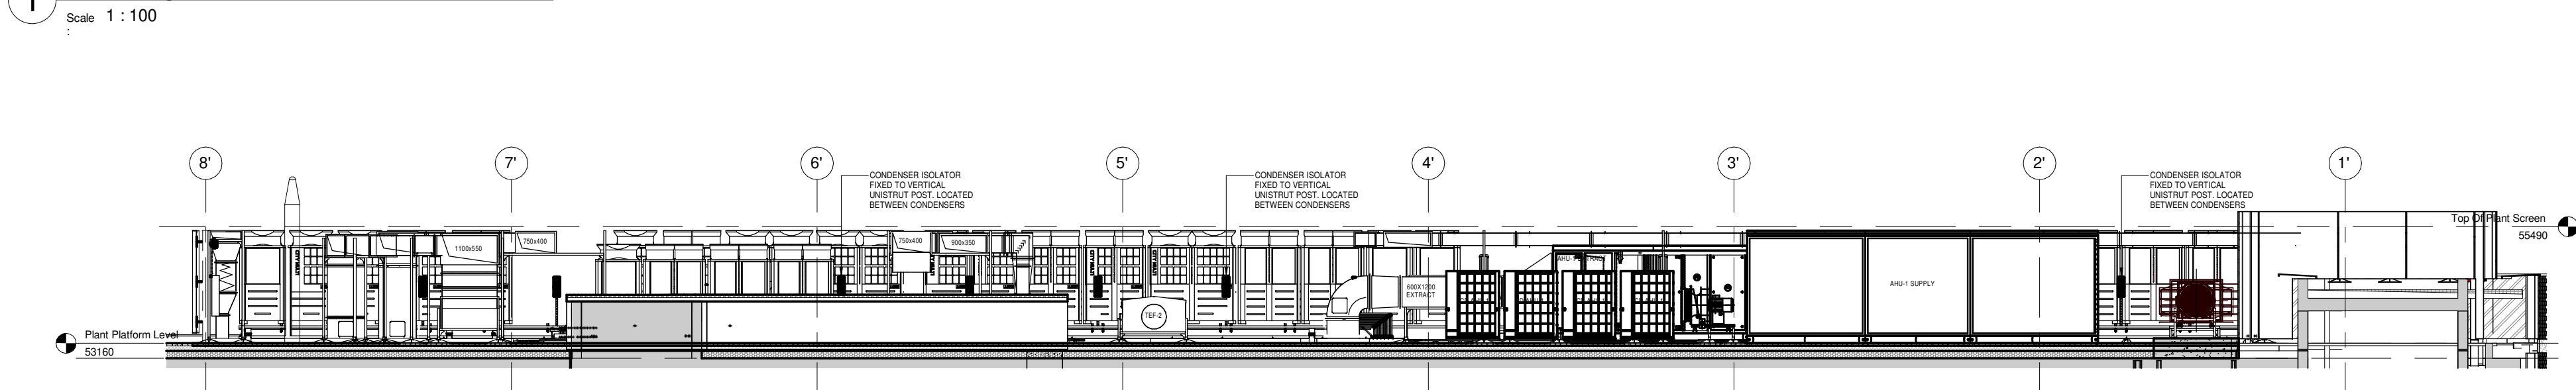

3 Existing Roof Section

Scale 1 : 100

As built plans provided by Lazari (Landlords)

Rev.	Date	Details	By
------	------	---------	----

Client
Bauer Media

Project Name
The Lantern (Main)

Drawing Title
Existing Roof Plan and Section

Status
Planning

Scale	Drawn by
As indicated@ A1	EW
Date	Checked by
21/07/2023	JN
Drawing Number	Revision
20122-PL-008	

This drawing is copyright. Do not scale off dimensions. All dimensions are to be checked on site by contractor. Contractor to report any dimensional discrepancies, errors or omissions prior to commencing in site.

18 Wenlock Road, London N1 7TA | spacelab.co.uk