



Notes:

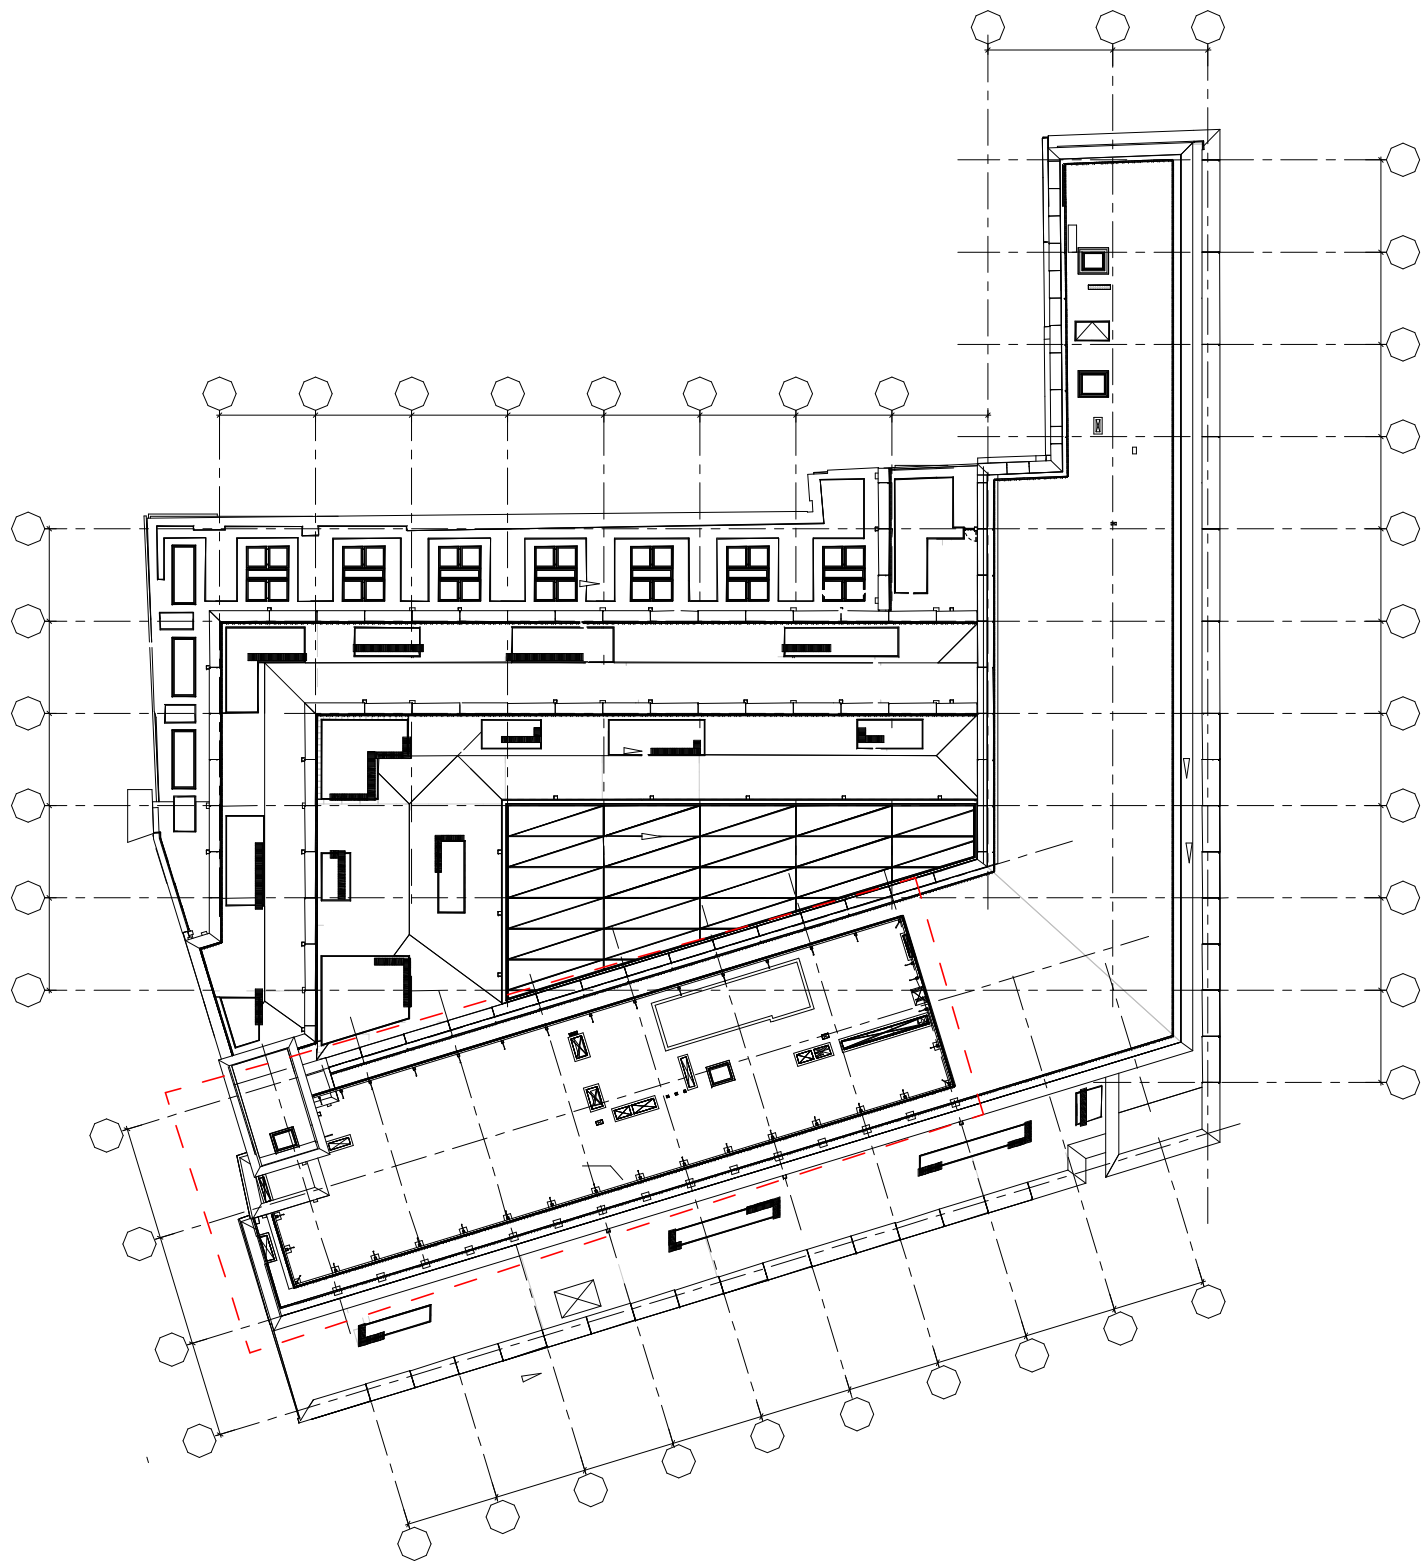

0 Roof Plan - Proposed


Scale 1 : 500

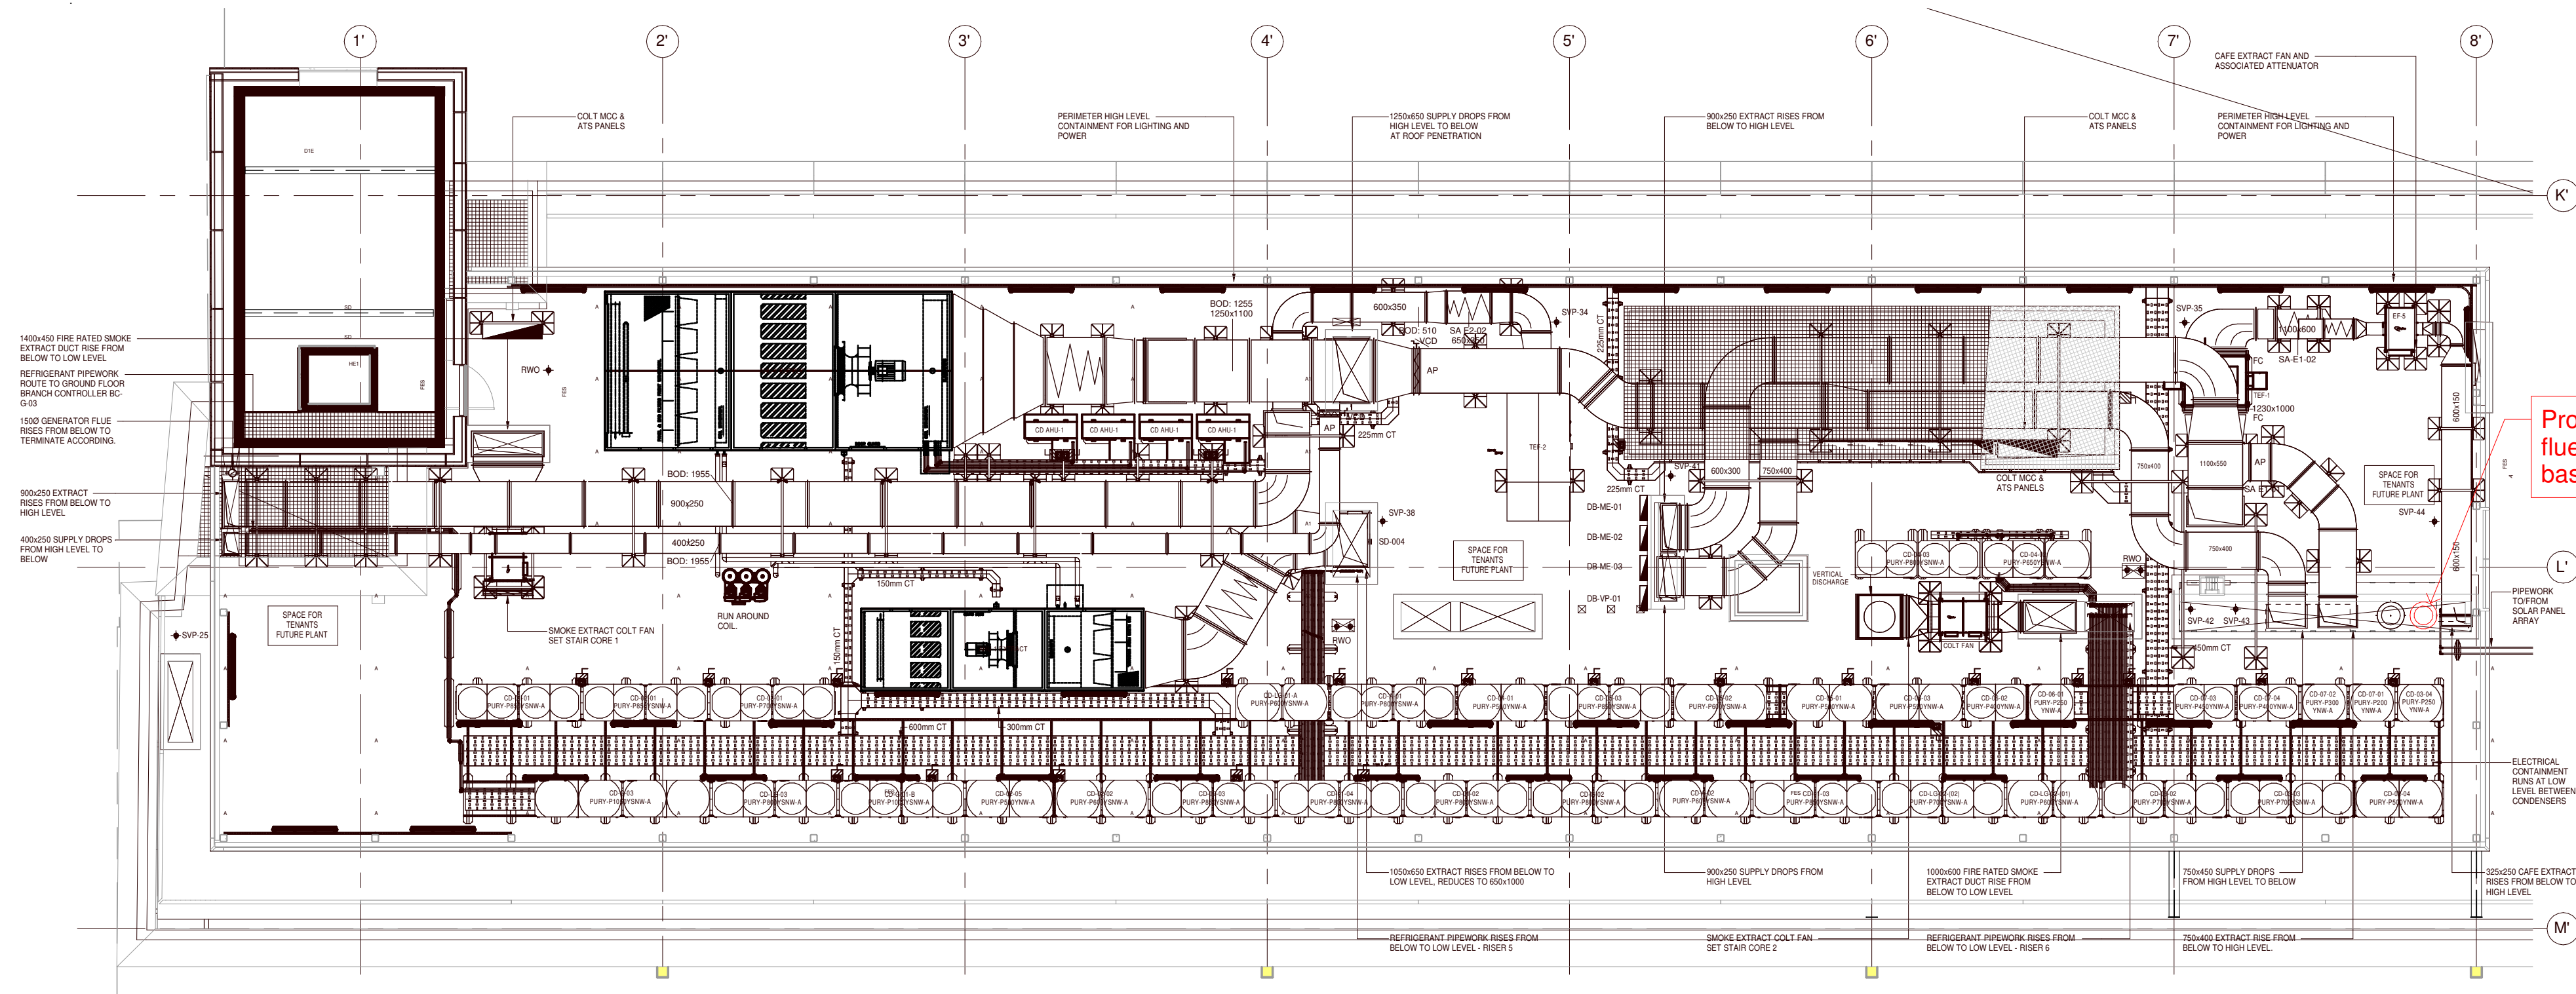

Proposed generator
flue 185mm dia from
basement to roof level

1 Proposed Roof Mechanical Plan

Scale 1 : 100

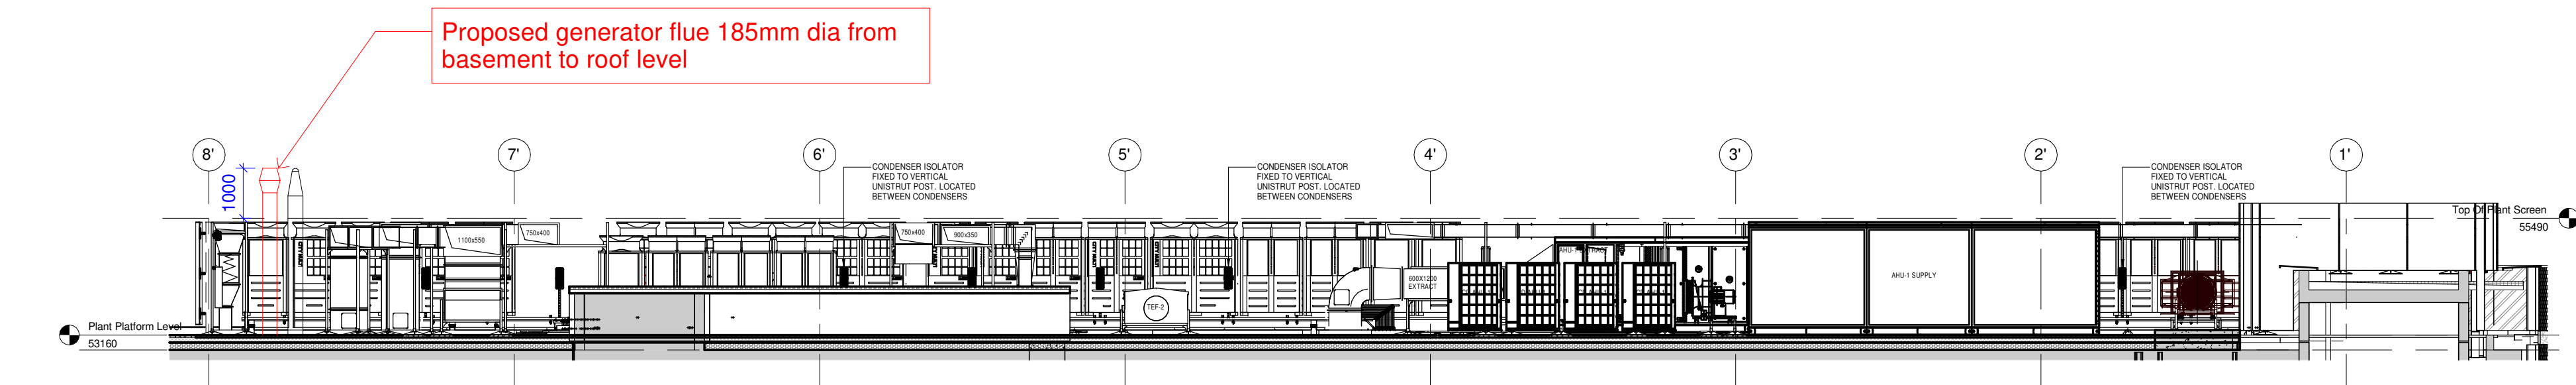

Proposed generator flue 185mm dia from
basement to roof level

2 Proposed Roof Section

Scale 1 : 100

As built plans provided by Lazari (Landlords)

A	11/08/2023	North Arrow Added	EW
Rev.	Date	Details	By

Client
Bauer Media

Project Name
The Lantern (Main)

Drawing Title
Proposed Roof Plan and Section

Status
Planning

Scale	As indicated@ A1	Drawn by	EW
Date	21/07/2023	Checked by	JN
Drawing Number	20122-PL-009	Revision	A

This drawing is copyright. Do not scale off dimensions.
All dimensions are to be checked on site by contractor.
Contractor to report any dimensional discrepancies, errors
or omissions prior to commencing in site.

18 Wenlock Road, London N1 7TA | spacelab.co.uk

