


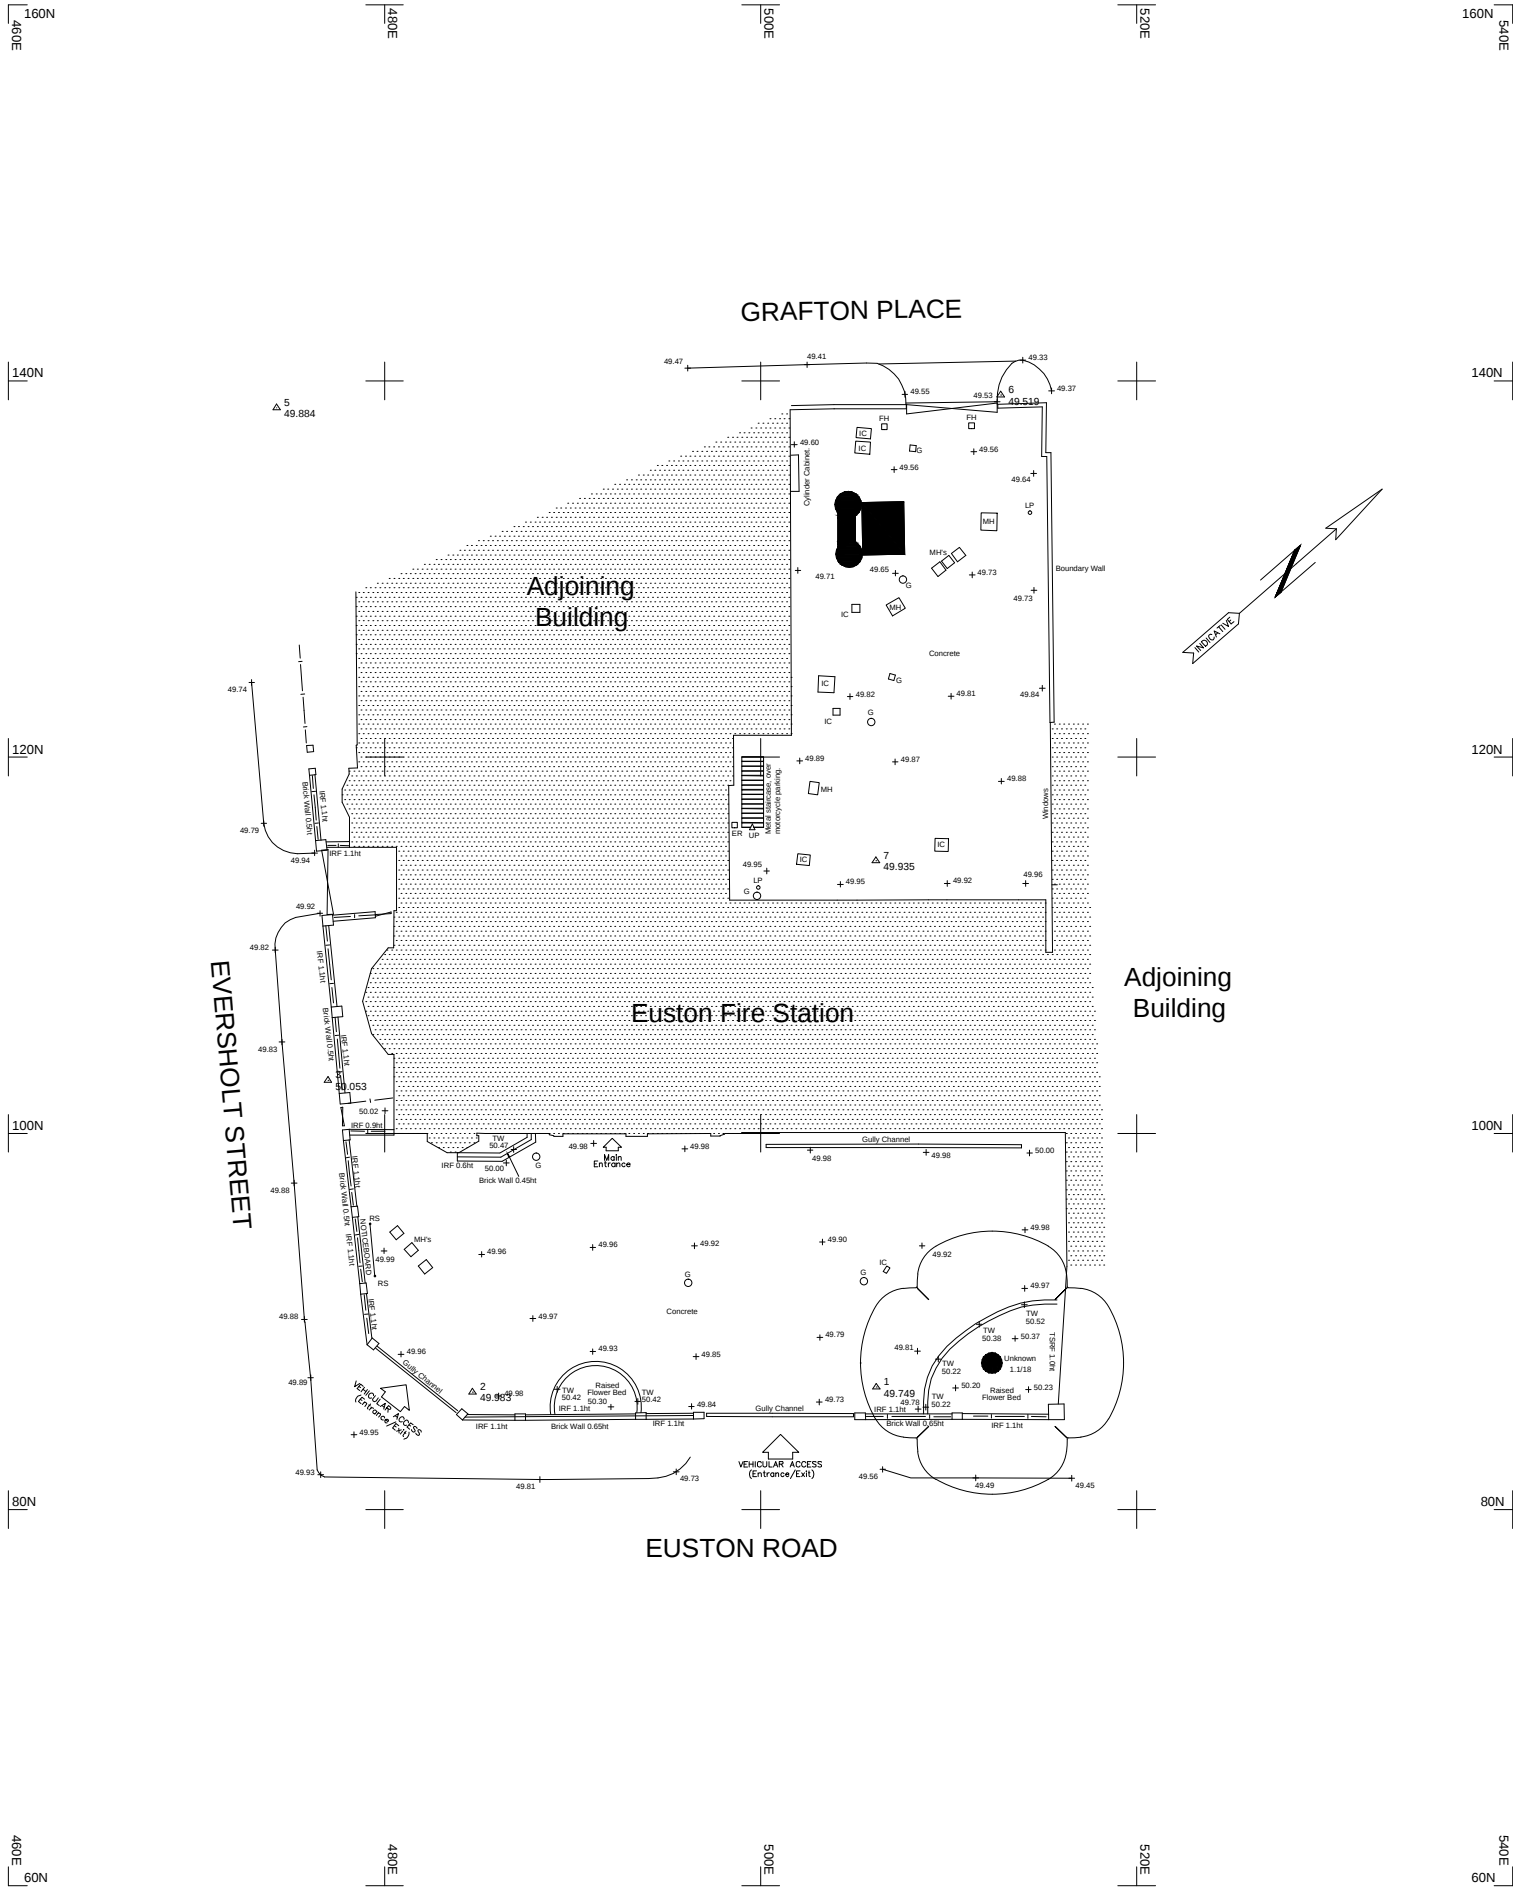

NOTES:
ALL DIMENSIONS SHOWN ARE TO BE VERIFIED
ON SITE. DO NOT SCALE FROM THIS DRAWING

LEGEND	
	PIPE RUN
	RADIATOR
	SWITCH
	TELEPHONE SOCKET OR BOX
	TELEPHONE
	ALARM DETECTOR
	LARGE FIRE STOP
	LARGE EXTINGUISHER
	WALL OR CEILING LIGHT
	FLUORESCENT STRIP LIGHT
	EMERGENCY LIGHT
	CONTROL BOX AS NOTED
	SPOT LIGHT
	BREAK GLASS
	HOSE REEL
	FALSE CEILING
	STRUCTURAL CEILING

ABBREVIATIONS (Where Applicable)	
BOLLARD	B
BRITISH TELECOM MANHOLE	BTM
ELECTRICITY POLE	EP
GAZEBO	GB
FIRE HYDRANT	FH
FLOWER BED	FB
FLOOR LEVEL	FL
GAS VALVE	GV
GULLY	G
INSPECTION COVER	IC
LAMP POST	LP
MANHOLE	MH
NOTICE BOARD	NB
NAME PLATE	NP
ROAD SIGN	RS
ROOFSIDE EYE	RE
RETAINING WALL	RW
STOP CODE	SC
TELEGRAPH POLE	TP
TRAFFIC LIGHT	TL
TOP OF WALL	TW
WATER METER	WM
VENT PIPE	VP
FENCES	
BARRIED WIRE FENCE	BWF
CORRUGATED IRON FENCE	CF
CLOSE BOARD FENCE	CBF
CHAIN LINK FENCE	CLF
CHESTNUT PALING FENCE	CPF
FENCE POST	FPD
INTERWOVEN FENCE	IF
IRON RAILING FENCE	IRF
LINCOLN LAMP FENCE	LLF
MISCELLANEOUS FENCING	MWF
POST AND CHAIN FENCE	PCF
POST AND RAIL FENCE	PRF
POST AND WIRE	PWF
TUBULAR STEEL RAIL	TSPF

REV	NOTE	DATE
-----	------	------

PROPERTY SERVICES
DEPARTMENT
ROOM 123
REAR BLOCK
8 ALBERT EMBANKMENT
LONDON SE1 7SD

TEL 020 7587 4930
FAX 020 7587 4916

JOB
EUSTON FIRE STATION

TITLE

EX SITE PLAN
© APRIL 2004
LFEPa UPDATED JULY 2007

SCALE 1:200@A1

DATE 16.06.04

JOB No DRAWING No
LR018/EUS LR018/EUS/001

DRAWN BY -

REVISIONS /

