







LEGEND	
SYMBOL	DESCRIPTION
	RECESSED DOWN LIGHT
	RECESSED DOWN LIGHT FOR BATHROOM
	RECESSED ADJUSTABLE DOWN LIGHT
	WALL LIGHT
	SUSPENDED PENDANT LIGHT
	SURFACE MOUNT LINEAR LIGHT

This drawing is protected under Copyright and at no time should any portion of this drawing be reproduced or copied without the permission of the Architect. (Design Copyright Act 1968)

This drawing must not be used for purposes other than that for which it is provided. It is supplied without liability for any errors or omissions.

Drawings only to be scaled for planning application purposes, all dimensions to be checked on site. All drawings subject to Statutory Authority Approval.

Notes	
No	Date
1	18.08.2023
Rev	

Status **PLANNING**



ARCHITECTS + INTERIOR DESIGNERS

91A - 91B HEATH STREET  
LONDON NW3 6SS  
Tel 020 7636 3838  
INFO WWW.TG-STUDIO.CO.UK


Project: 9 GAINSBOROUGH GARDENS  
NW3 1BJ

Date: 18.08.23  
Scale @ A1: 1:50


Drawing: EXISTING LOWER GROUND & GROUND FLOOR RCP LIGHTING PLAN

Drawn by: AL  
Checked by: TG

Job No.: 270  
Dwg No.: P-400  
Rev: -

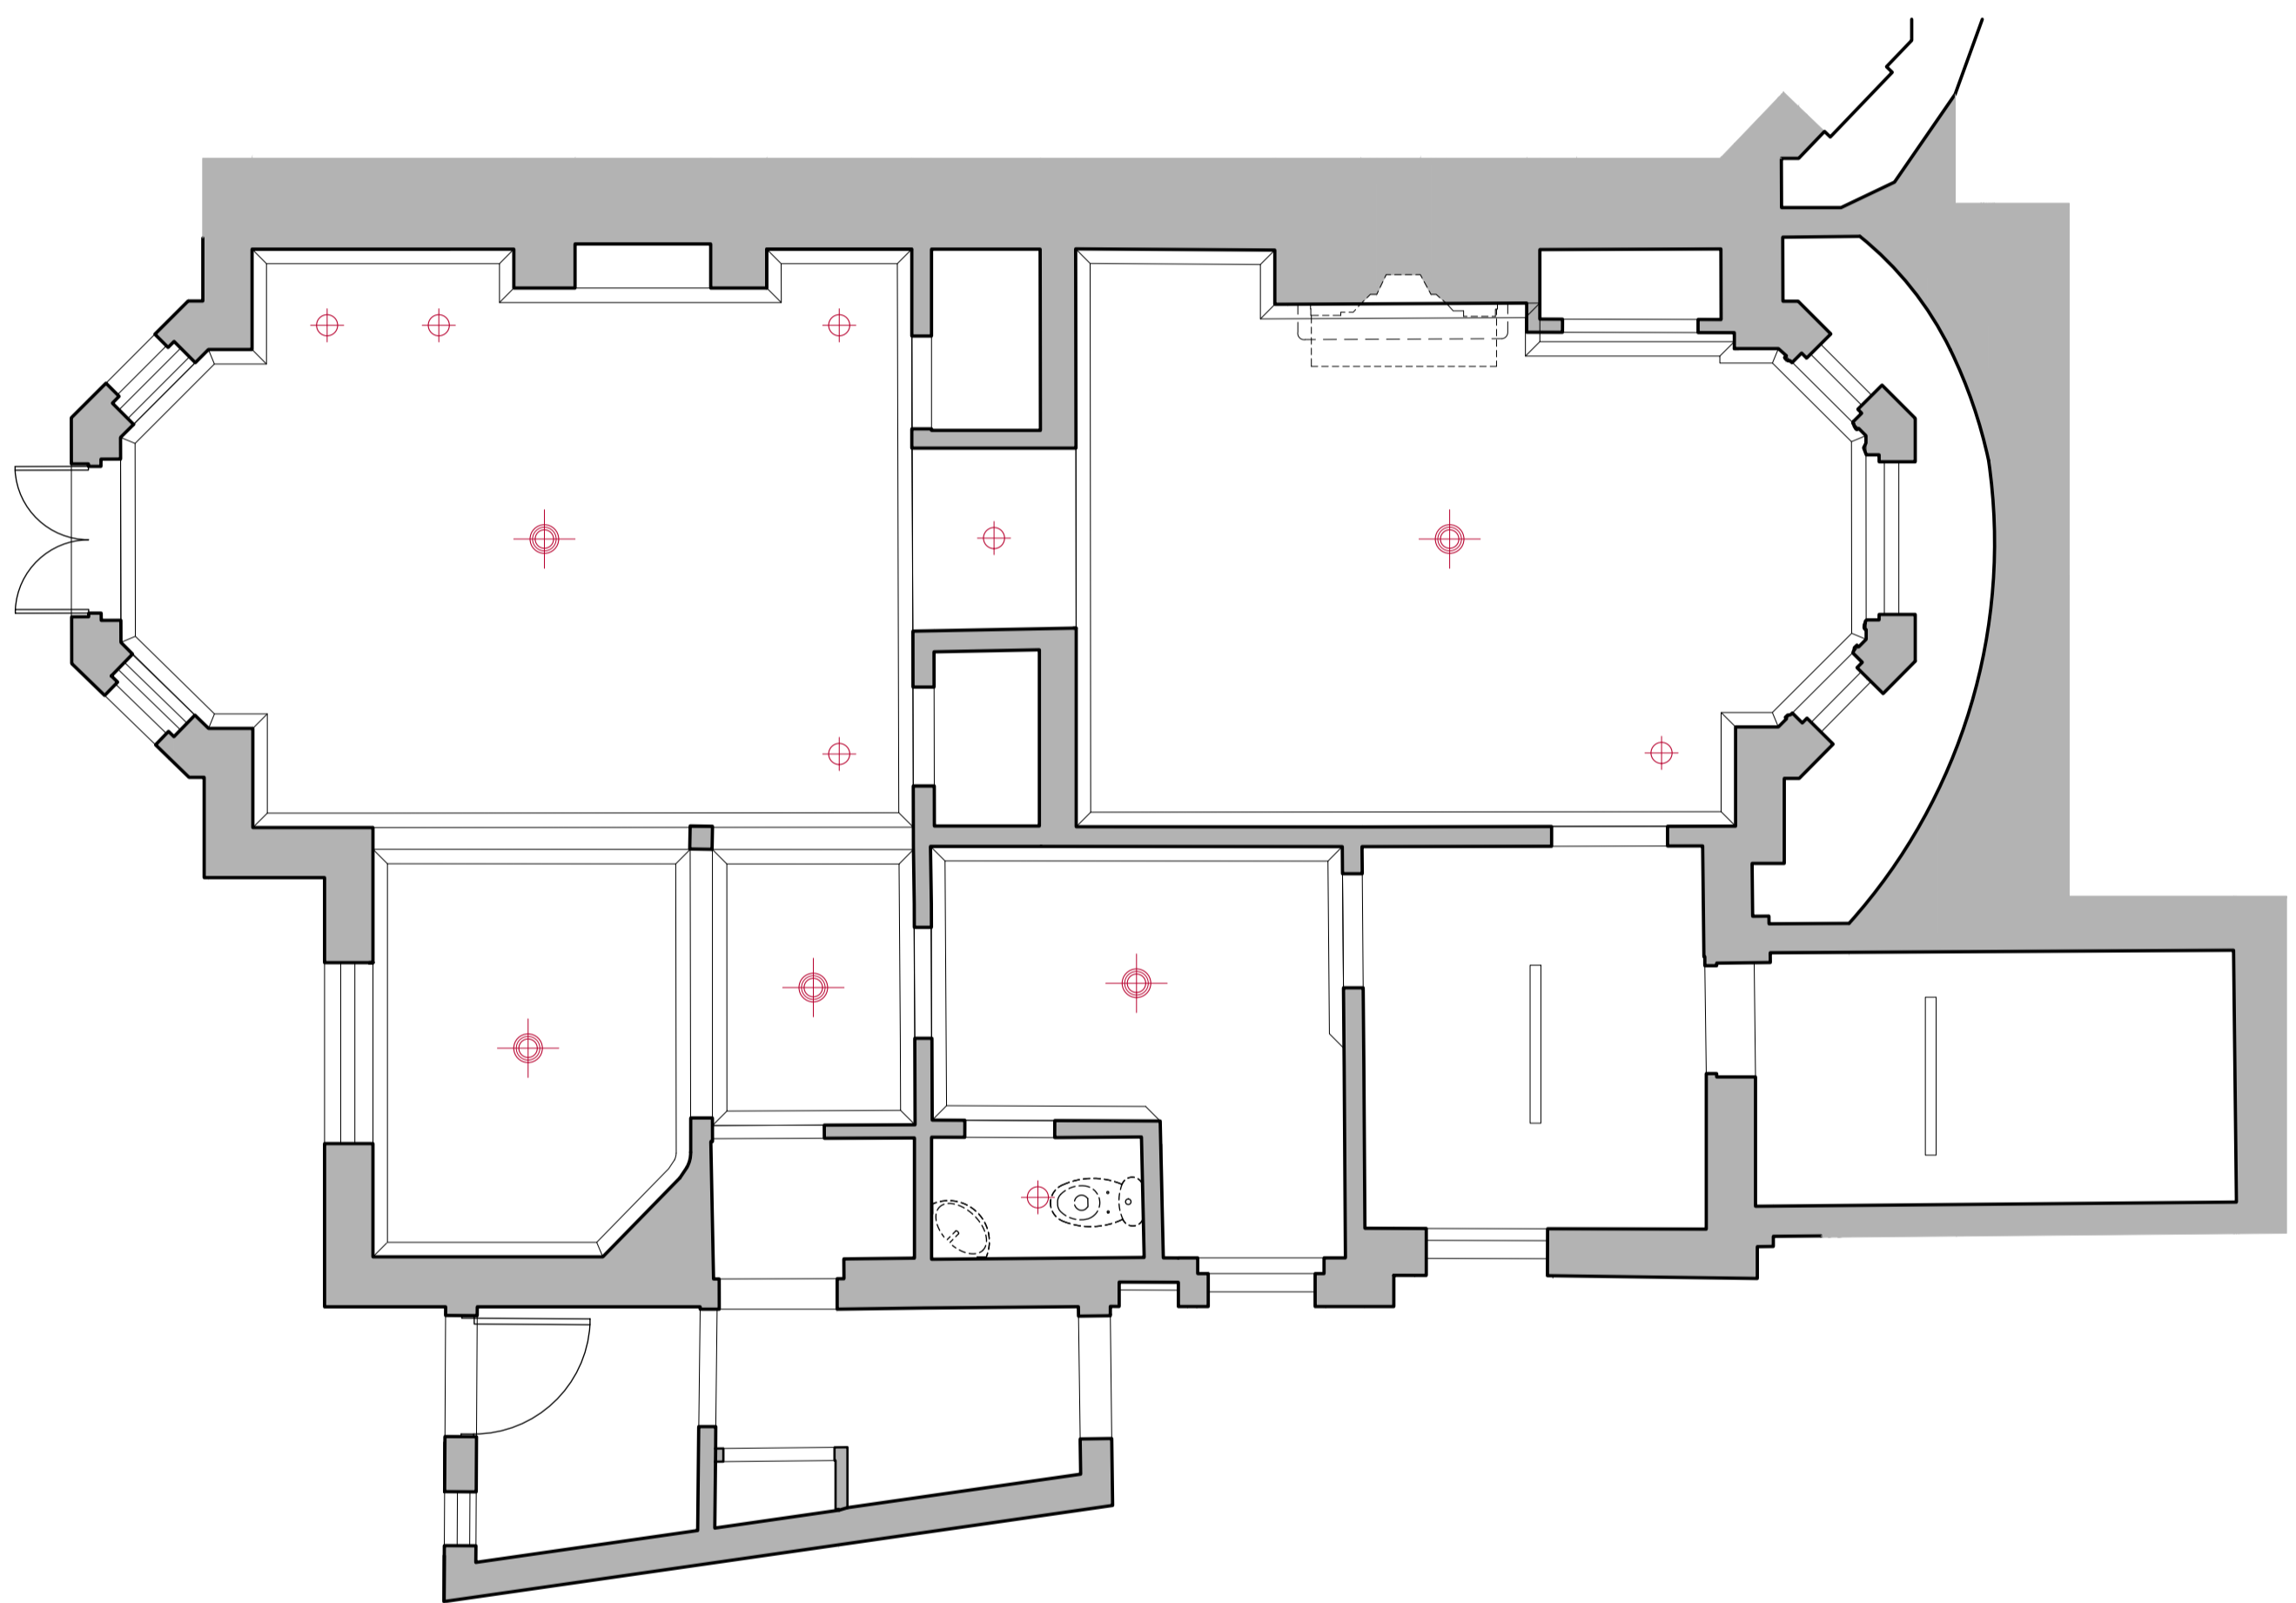

1 EXISTING LOWER GROUND FLOOR RCP LIGHTING PLAN  
scale 1:50

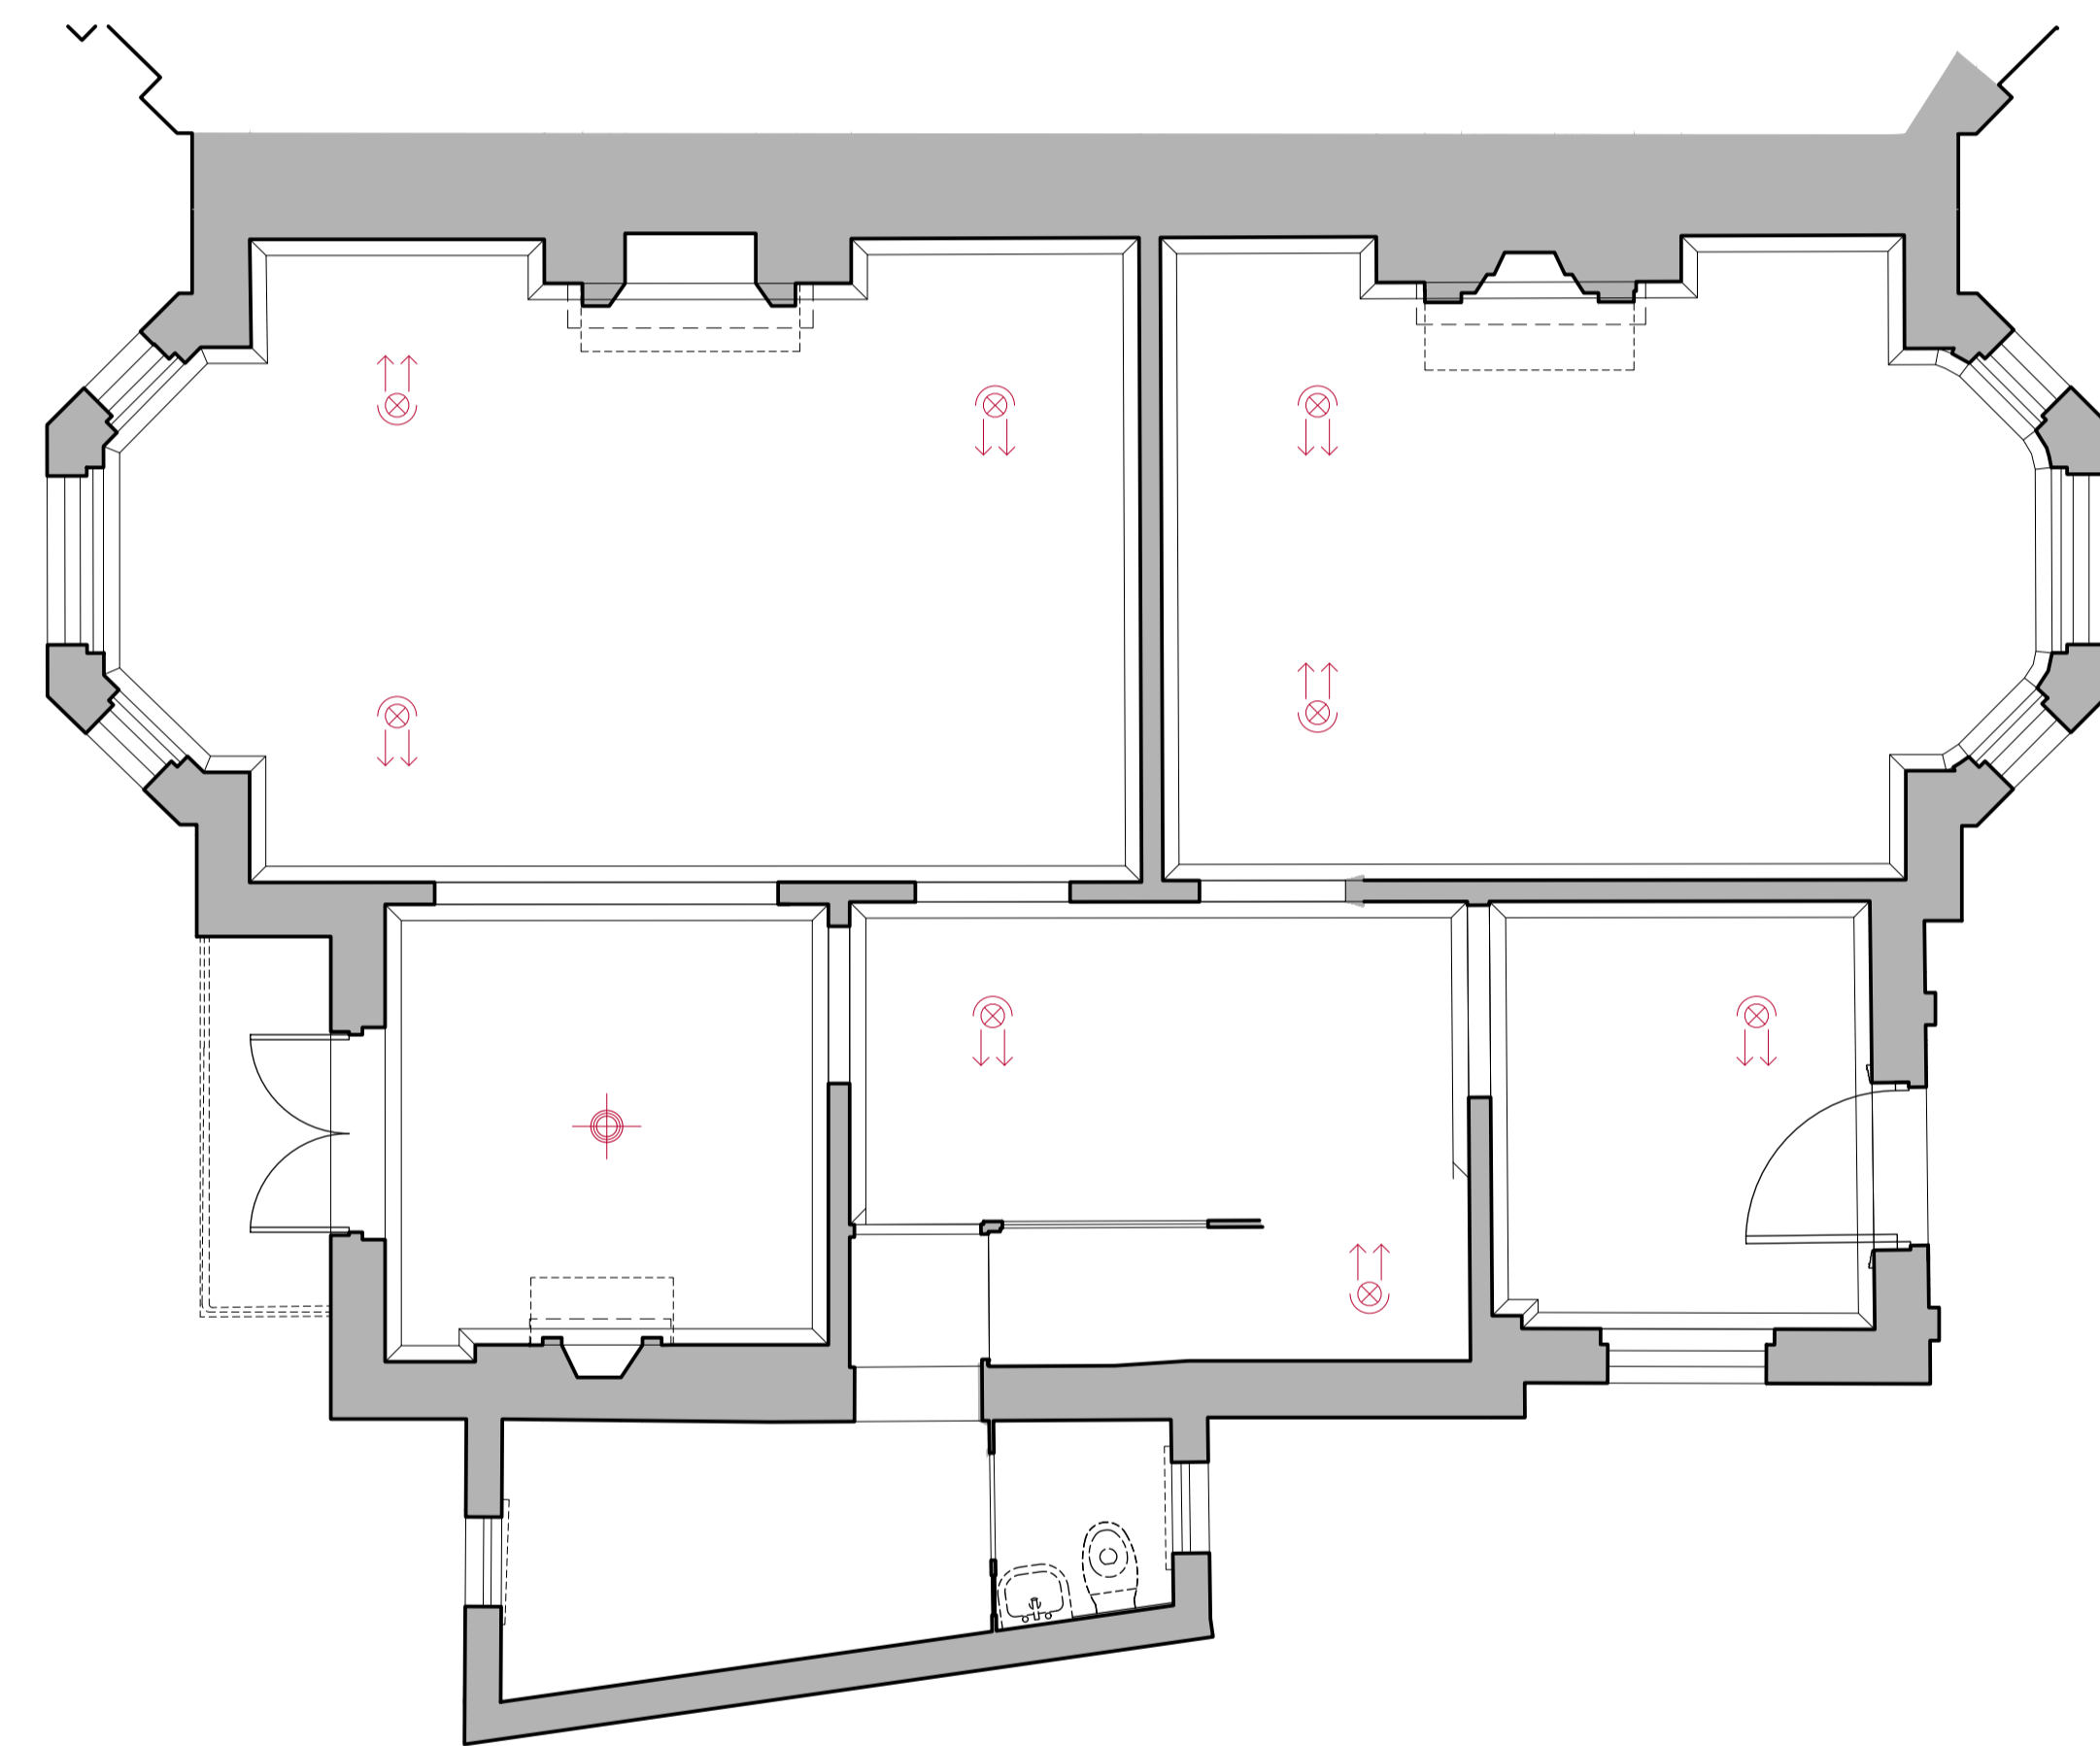

2 EXISTING GROUND FLOOR LIGHTING PLAN  
scale 1:50




LEGEND	
SYMBOL	DESCRIPTION
	RECESSED DOWN LIGHT
	RECESSED DOWN LIGHT FOR BATHROOM
	RECESSED ADJUSTABLE DOWN LIGHT
	WALL LIGHT
	SUSPENDED PENDANT LIGHT
	SURFACE MOUNT LINEAR LIGHT
	SURFACE MOUNT DOWN LIGHT


This drawing is protected under Copyright and at no time should any portion of this drawing be reproduced or copied without the permission of the Architect. (Design Copyright Act 1968)

This drawing must not be used for purposes other than that for which it is provided. It is supplied without liability for any errors or omissions.

Drawings only to be scaled for planning application purposes, all dimensions to be checked on site. All drawings subject to Statutory Authority Approval.

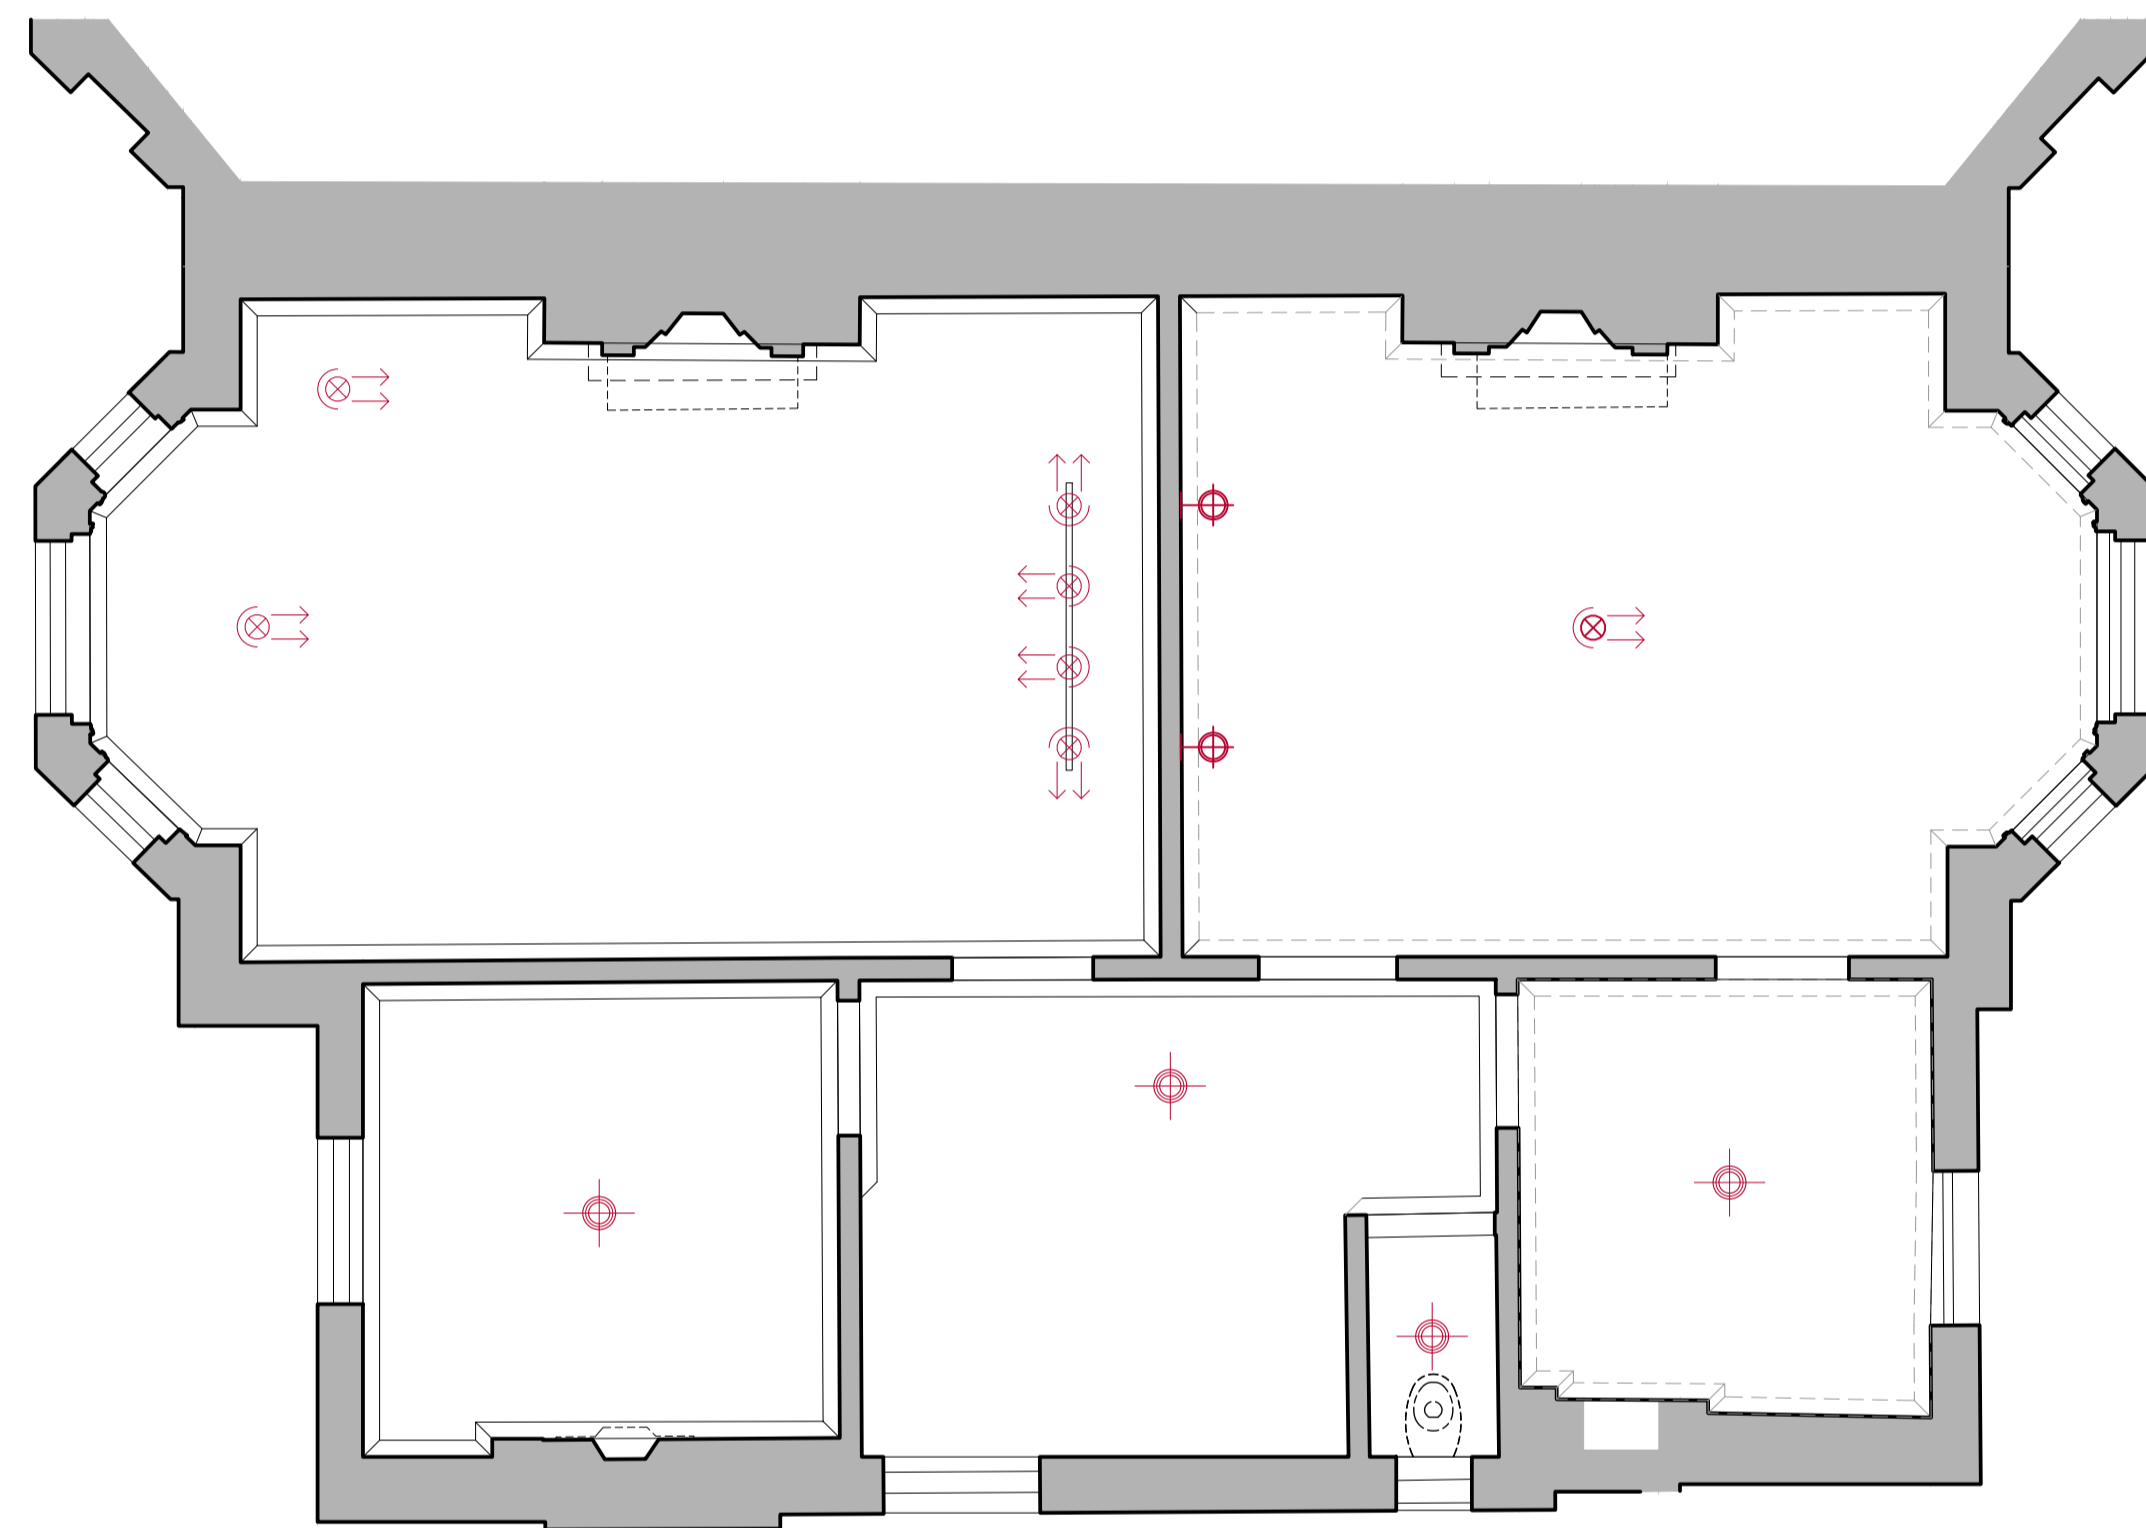

1 EXISTING FIRST FLOOR RCP LIGHTING PLAN  
scale 1:50

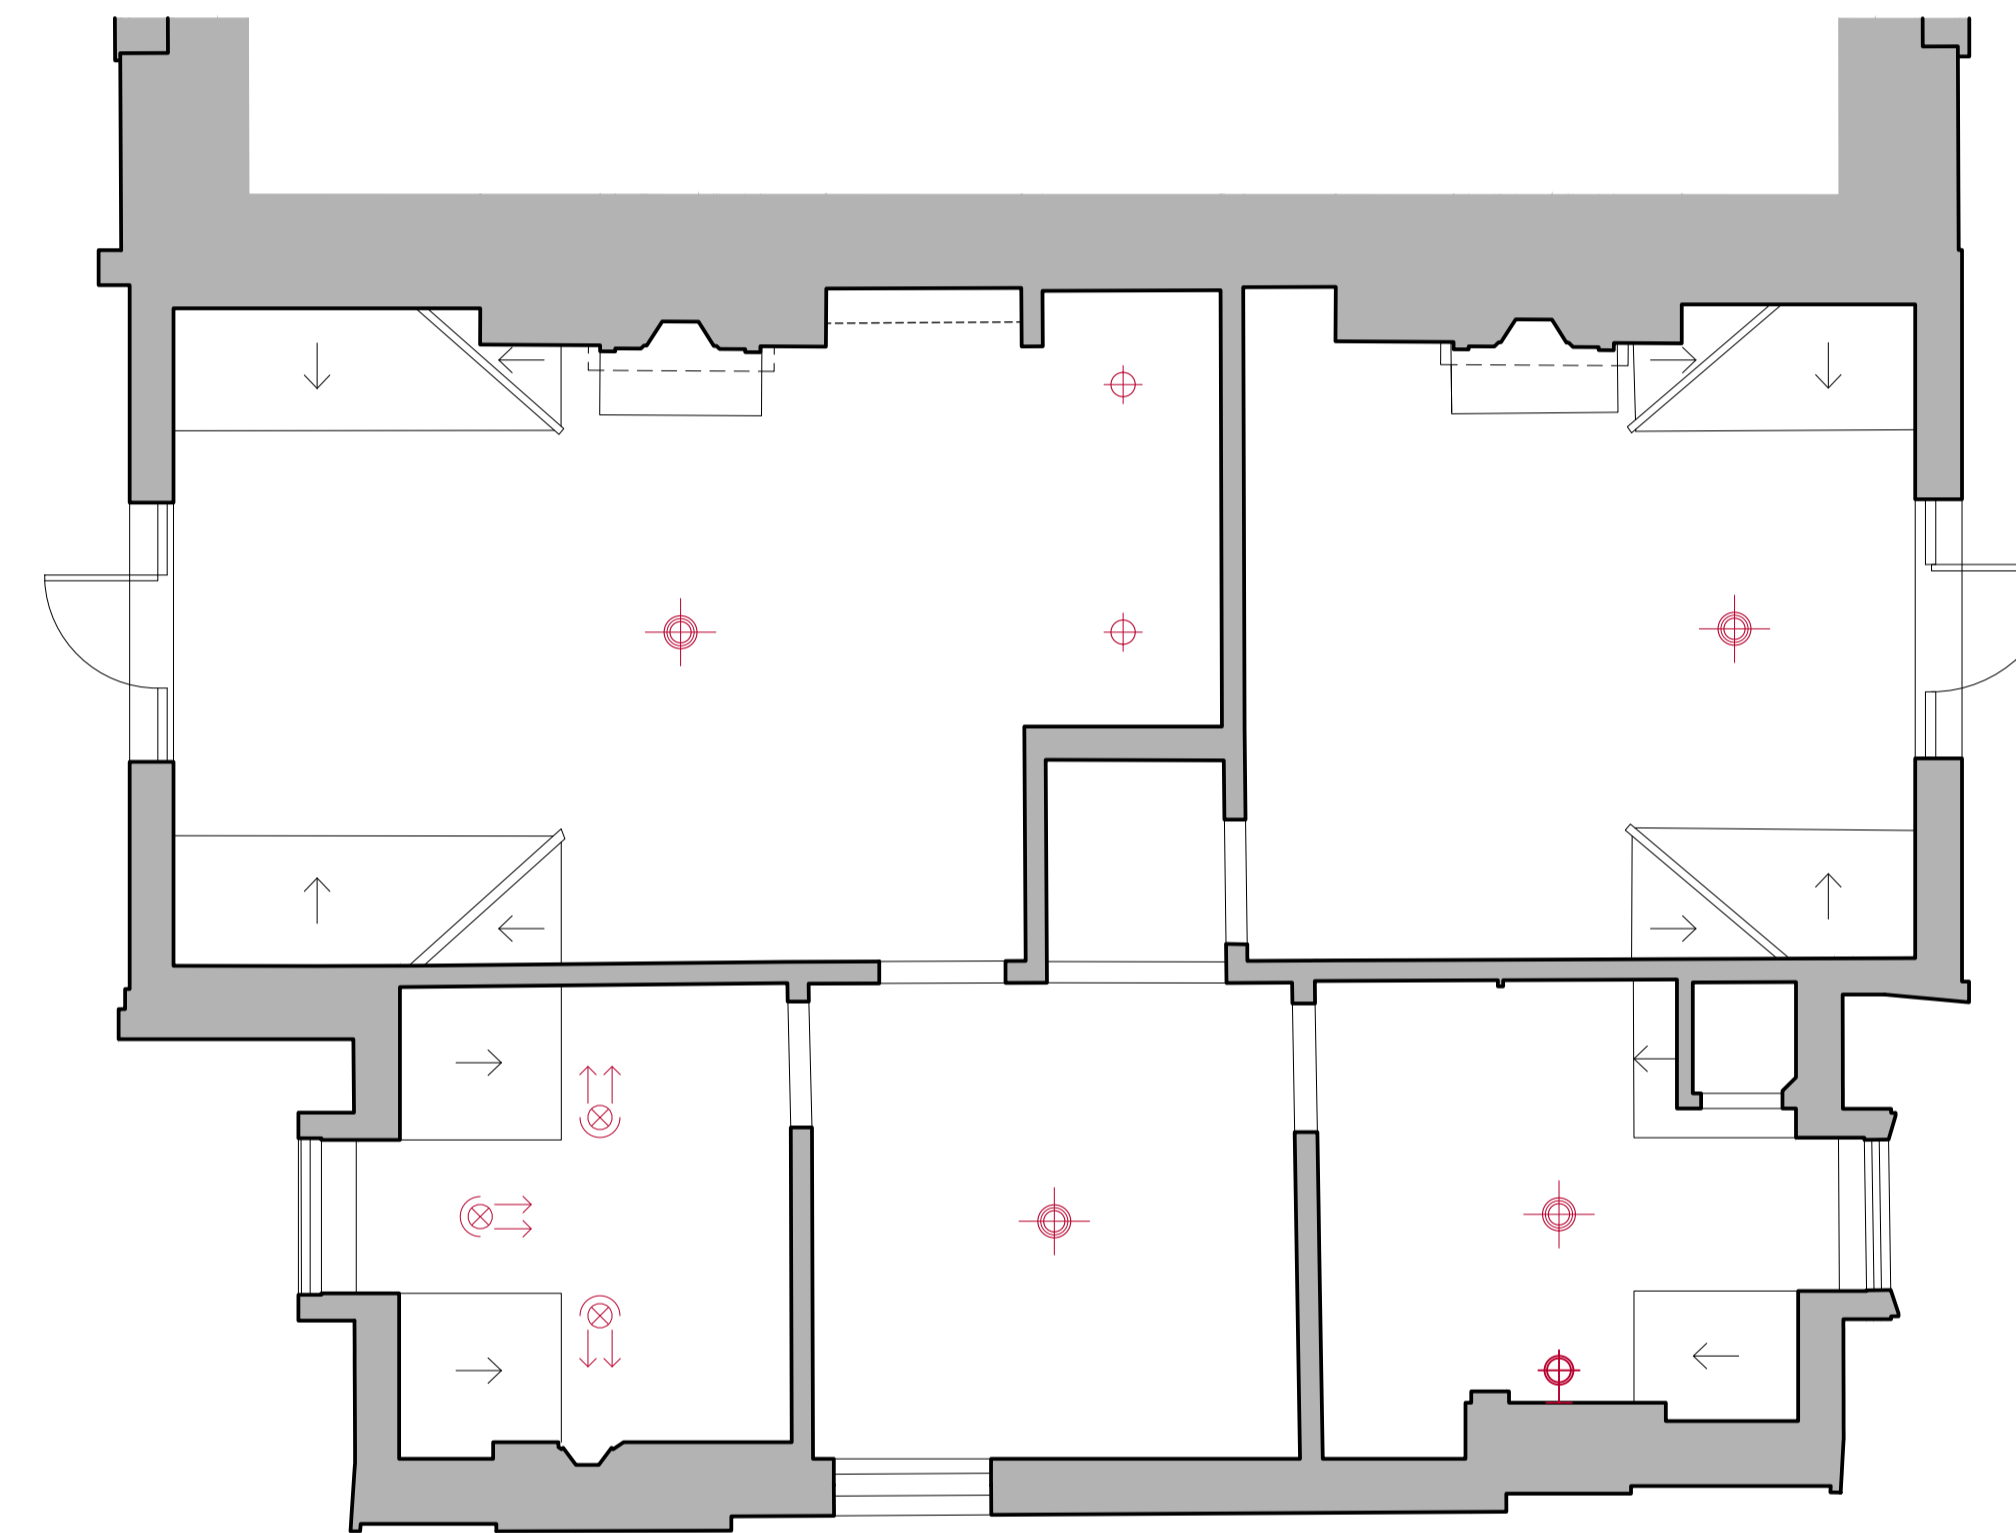

2 EXISTING SECOND FLOOR RCP LIGHTING PLAN  
scale 1:50



Notes	
No.	Date
1	18.08.2023
Rev	

Status PLANNING



ARCHITECTS + INTERIOR DESIGNERS

91A - 91B HEATH STREET  
LONDON NW3 6SS  
Tel 020 7636 3838

INFO WWW.TG-STUDIO.CO.UK

Project: 9 GAINSBOROUGH GARDENS  
NW3 1BJ

Date	18.08.23	Scale @ A1	1:50
------	----------	------------	------

Drawing: EXISTING  
FIRST & SECOND FLOOR  
RCP LIGHTING PLAN

Drawn by	AL	Checked by	TG
----------	----	------------	----

Job No.	270	Dwg No.	P-401	Rev	-
---------	-----	---------	-------	-----	---

LEGEND	
SYMBOL	DESCRIPTION
	RECESSED DOWN LIGHT
	RECESSED DOWN LIGHT FOR BATHROOM
	RECESSED ADJUSTABLE DOWN LIGHT
	WALL LIGHT
	SUSPENDED PENDANT LIGHT
	SURFACE MOUNT LINEAR LIGHT
	SURFACE MOUNT DOWN LIGHT

This drawing is protected under Copyright and at no time should any portion of this drawing be reproduced or copied without the permission of the Architect. (Design Copyright Act 1968)

This drawing must not be used for purposes other than that for which it is provided. It is supplied without liability for any errors or omissions.

Drawings only to be scaled for planning application purposes, all dimensions to be checked on site. All drawings subject to Statutory Authority Approval.

Notes	
No	Date
1	18.08.2023
Rev	

Status **PLANNING**



ARCHITECTS + INTERIOR DESIGNERS

91A - 91B HEATH STREET  
LONDON NW3 6SS  
Tel 020 7636 3838  
INFO WWW.TG-STUDIO.CO.UK


Project: 9 GAINSBOROUGH GARDENS  
NW3 1BJ

Date: 18.08.23  
Scale @ A1: 1:50


Drawing: PROPOSED LOWER GROUND & GROUND FLOOR RCP LIGHTING PLAN

Drawn by: AL  
Checked by: TG

Job No.: 270  
Dwg No.: P-402  
Rev: -

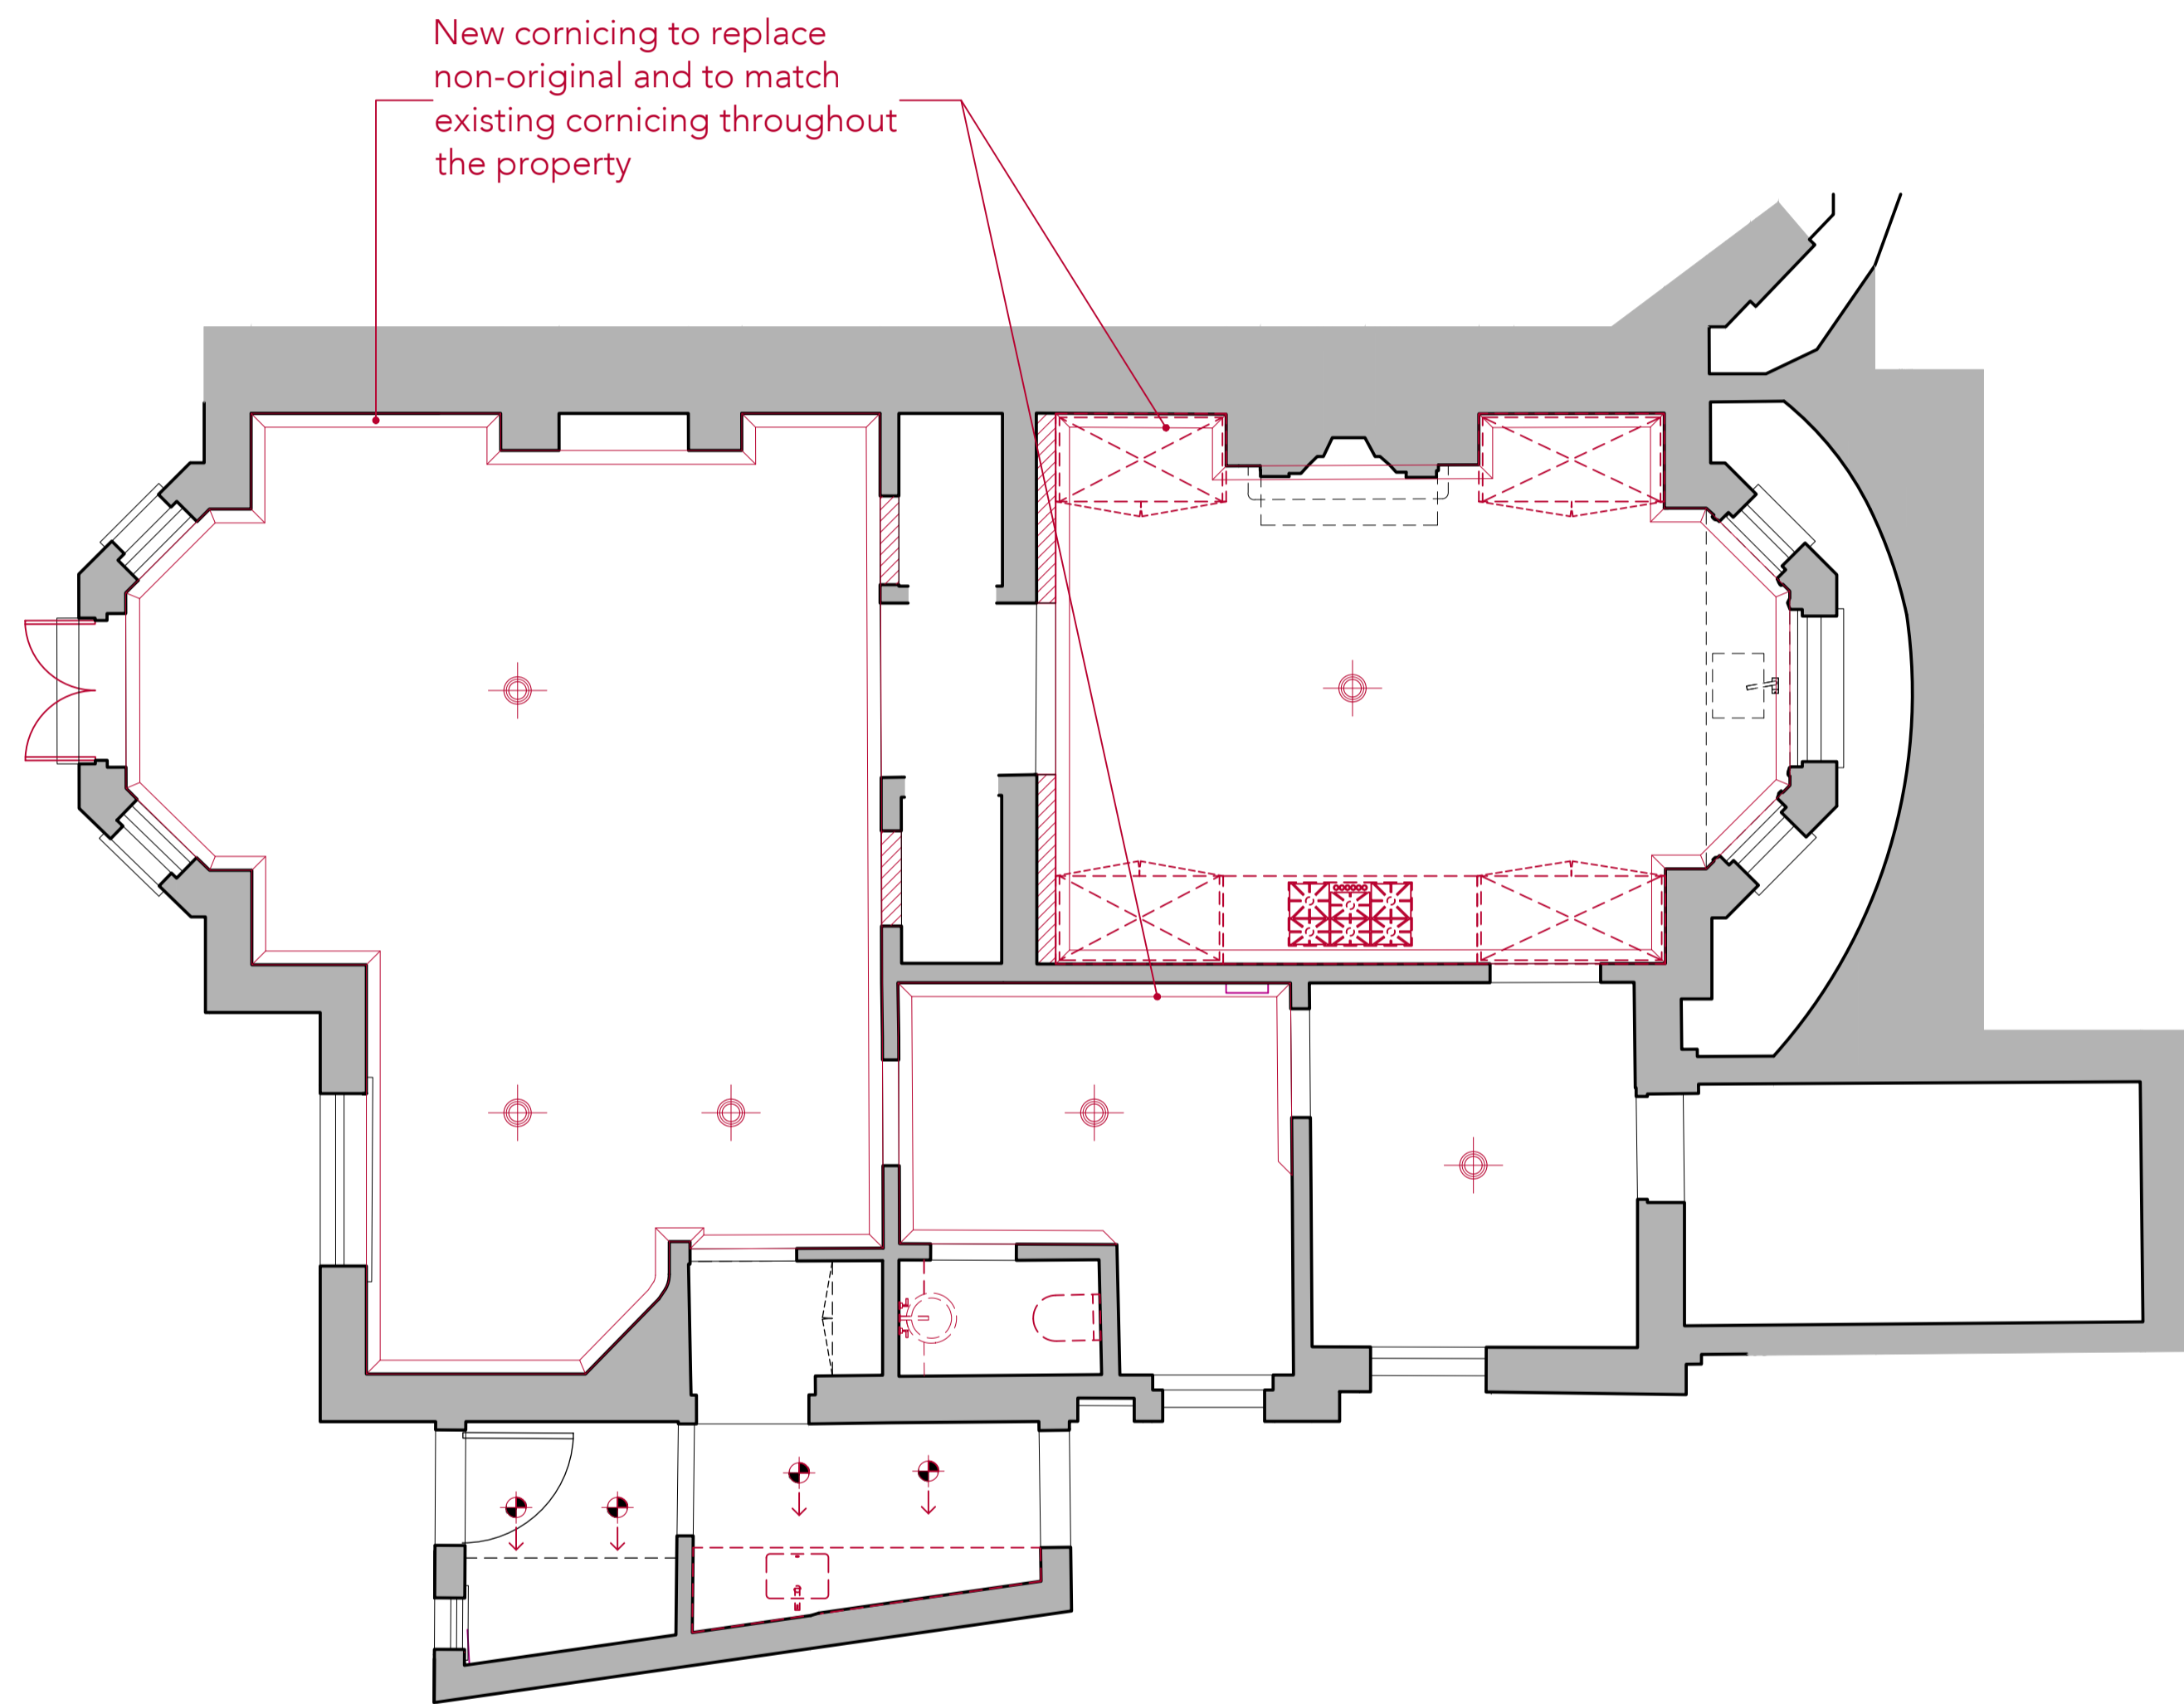

1 PROPOSED LOWER GROUND FLOOR RCP LIGHTING PLAN  
scale 1:50

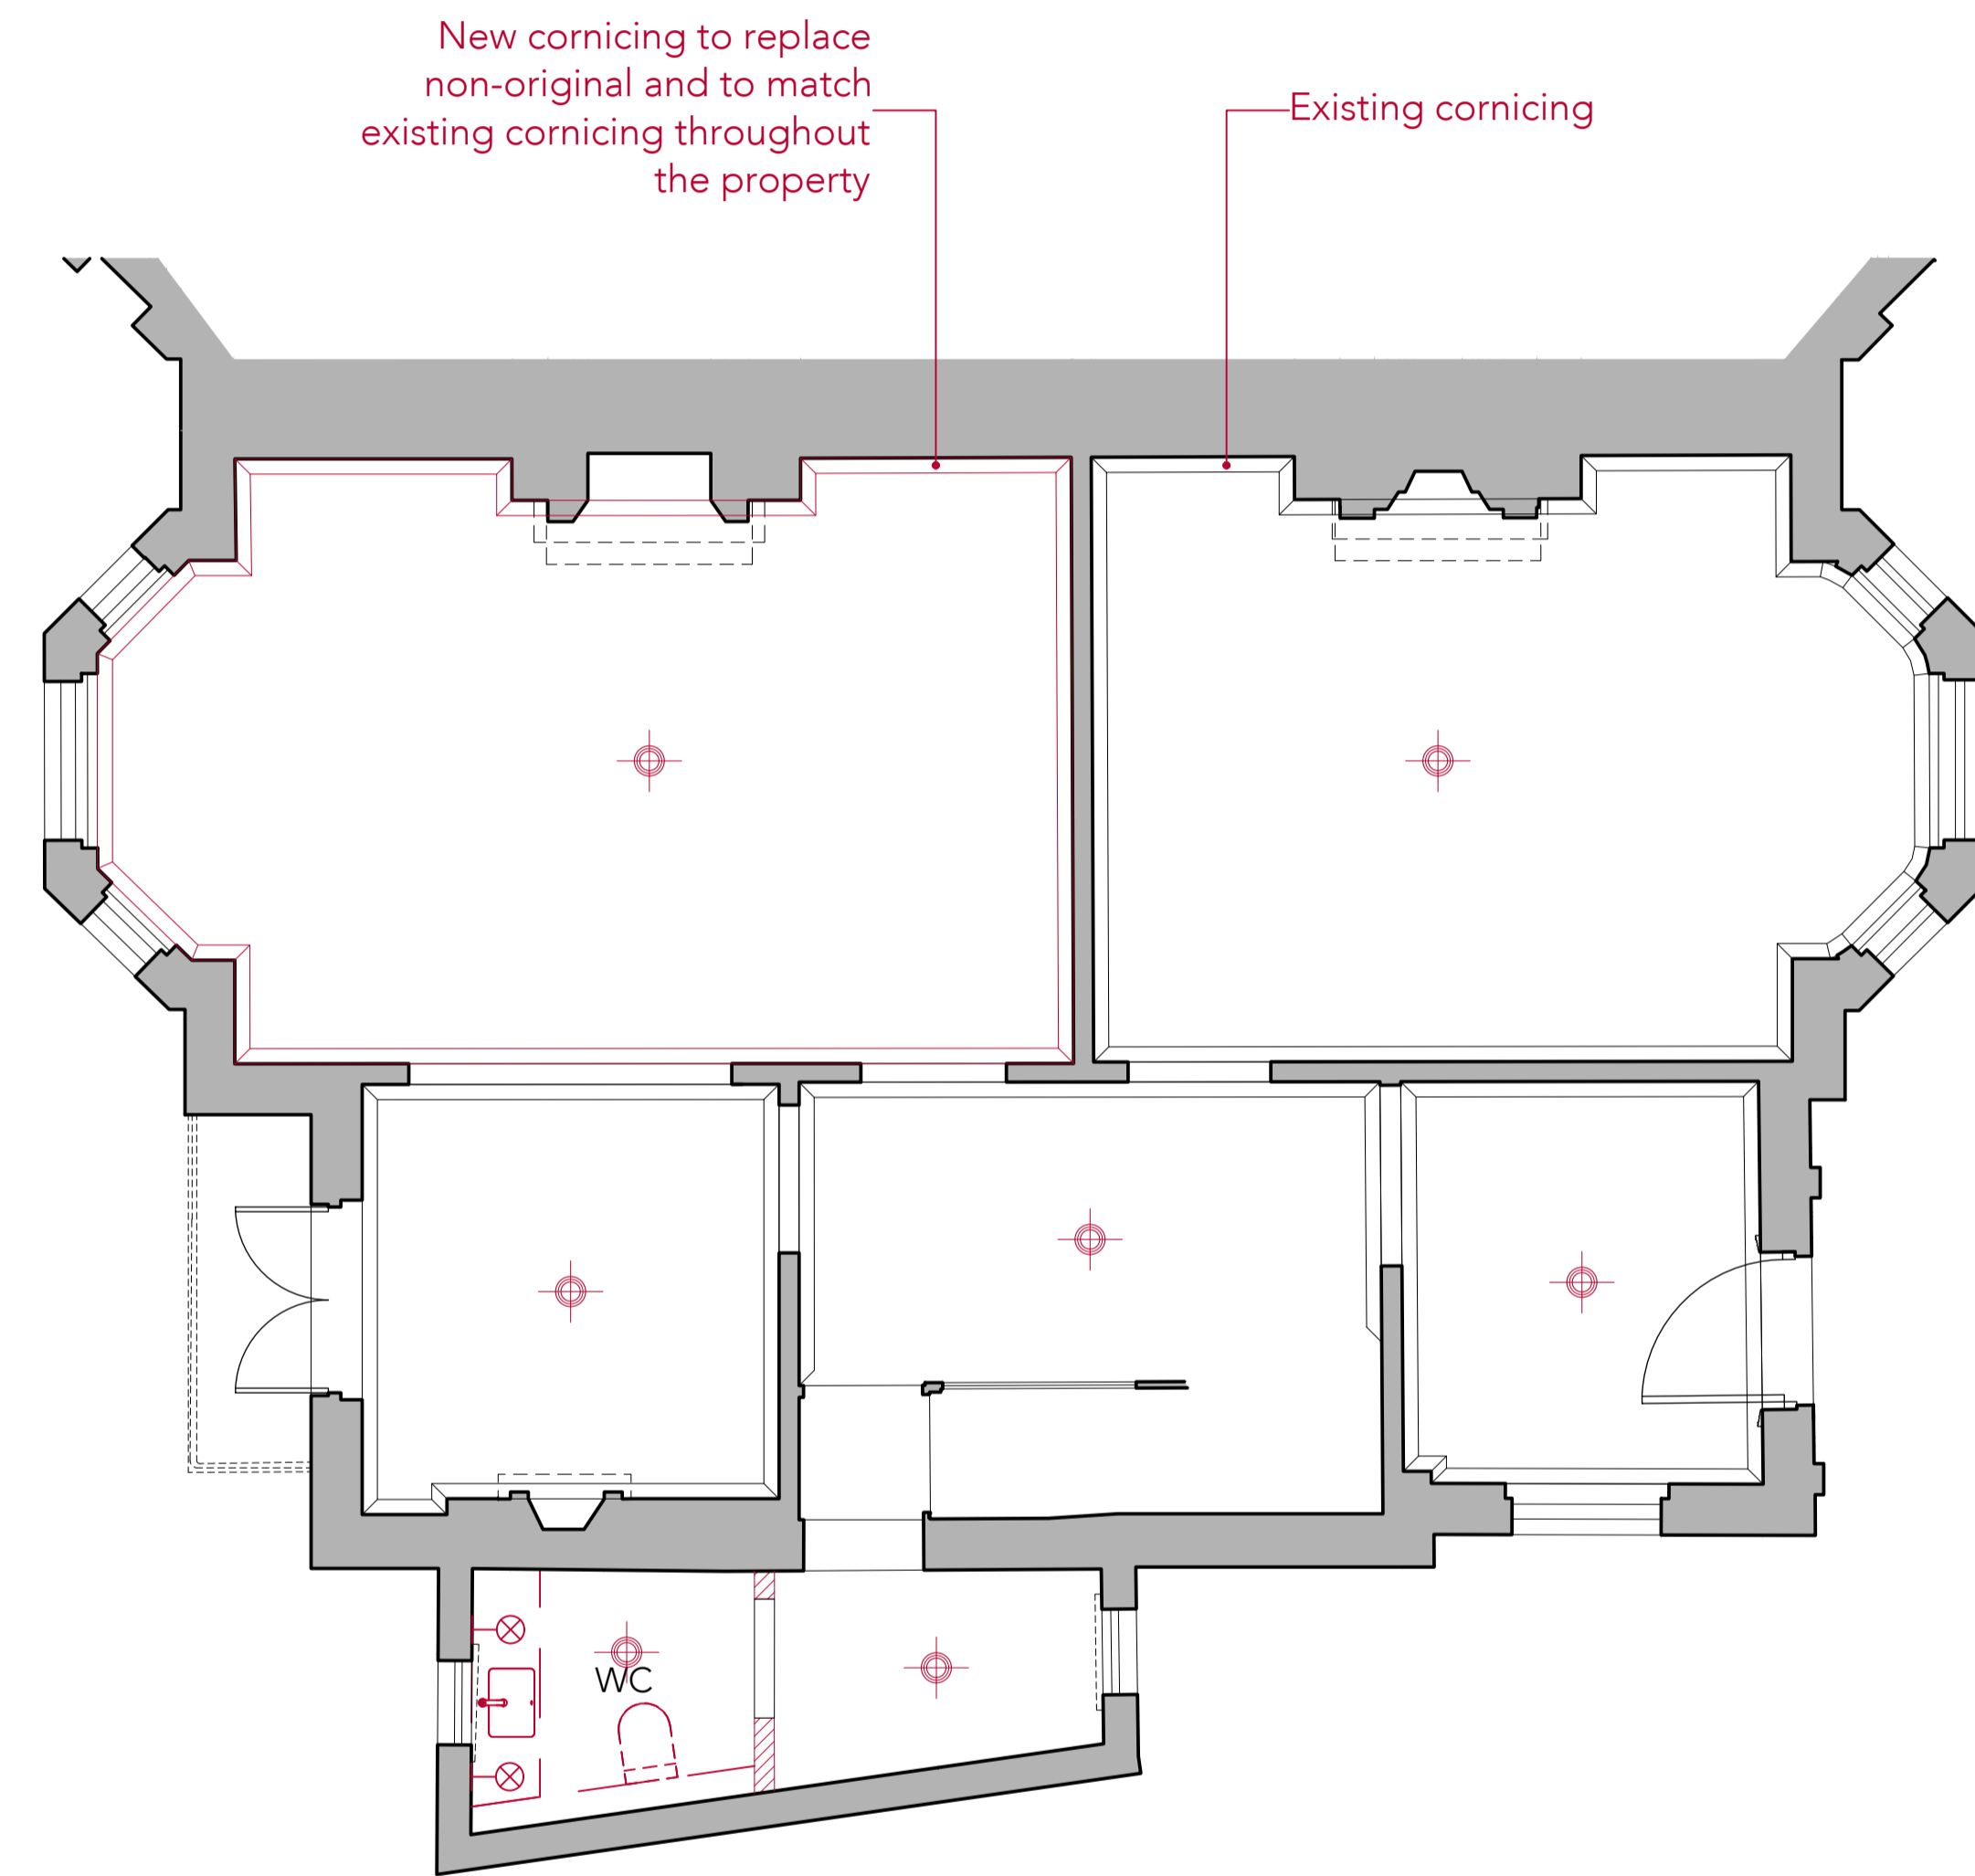

2 PROPOSED GROUND FLOOR LIGHTING PLAN  
scale 1:50




LEGEND	
SYMBOL	DESCRIPTION
	RECESSED DOWN LIGHT
	RECESSED DOWN LIGHT FOR BATHROOM
	RECESSED ADJUSTABLE DOWN LIGHT
	WALL LIGHT
	SUSPENDED PENDANT LIGHT
	SURFACE MOUNT LINEAR LIGHT
	SURFACE MOUNT DOWN LIGHT


This drawing is protected under Copyright and at no time should any portion of this drawing be reproduced or copied without the permission of the Architect. (Design Copyright Act 1968)

This drawing must not be used for purposes other than that for which it is provided. It is supplied without liability for any errors or omissions.

Drawings only to be scaled for planning application purposes, all dimensions to be checked on site. All drawings subject to Statutory Authority Approval.

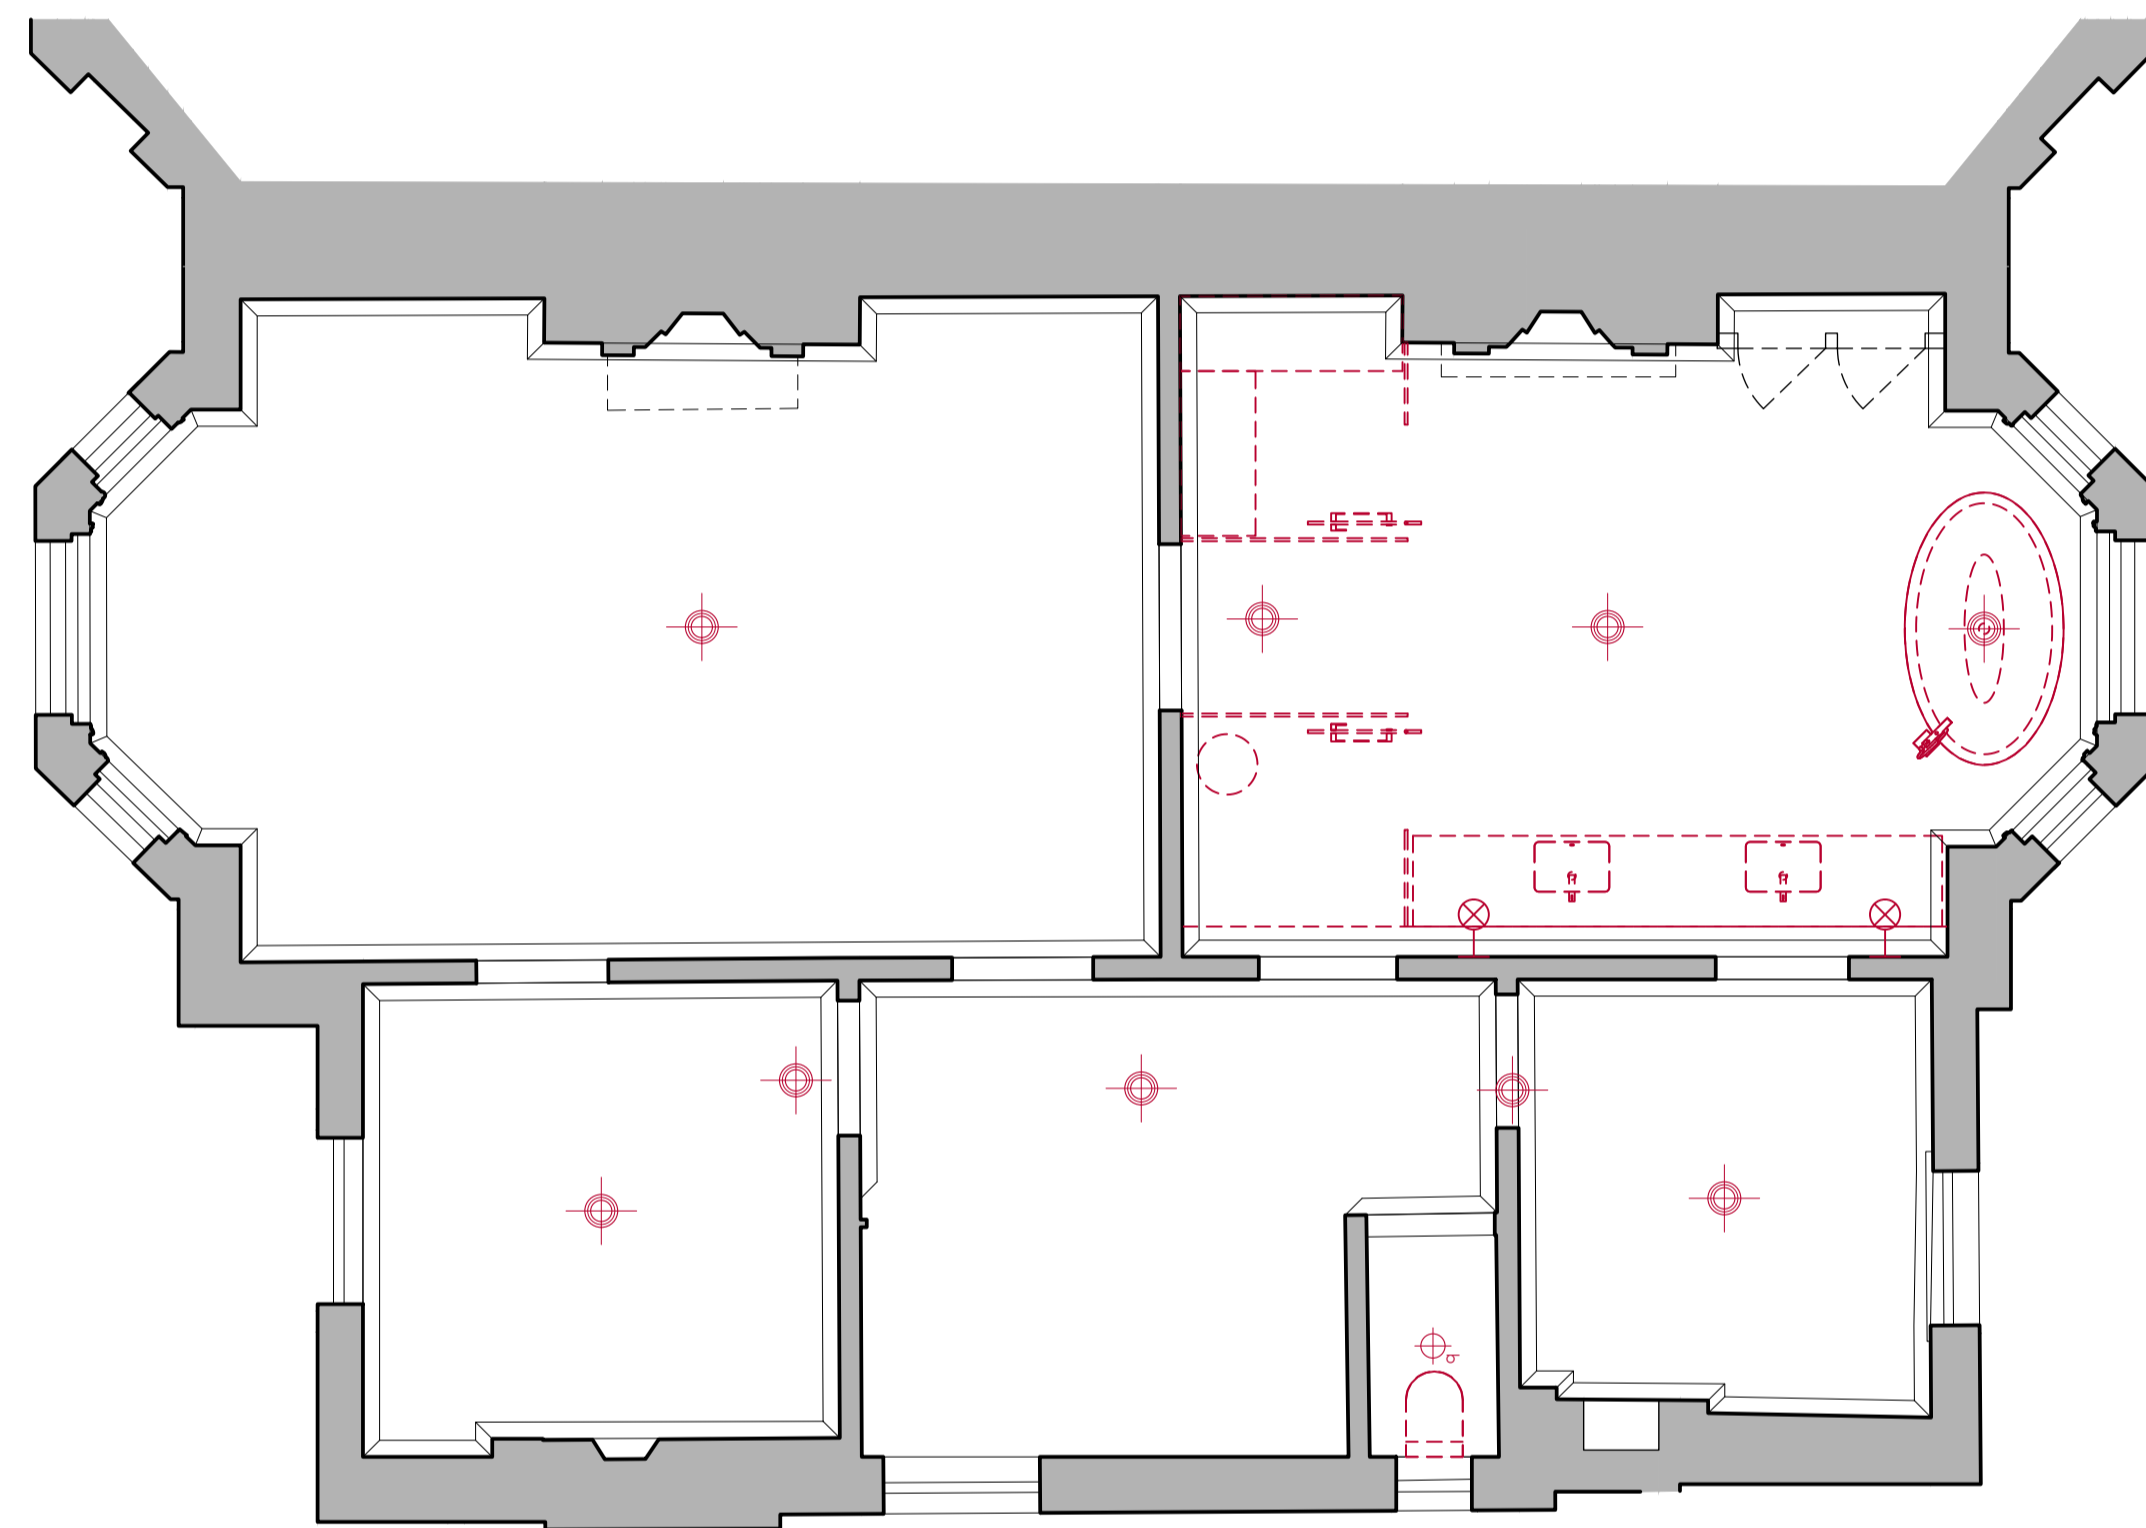

1 PROPOSED FIRST FLOOR RCP LIGHTING PLAN  
scale 1:50

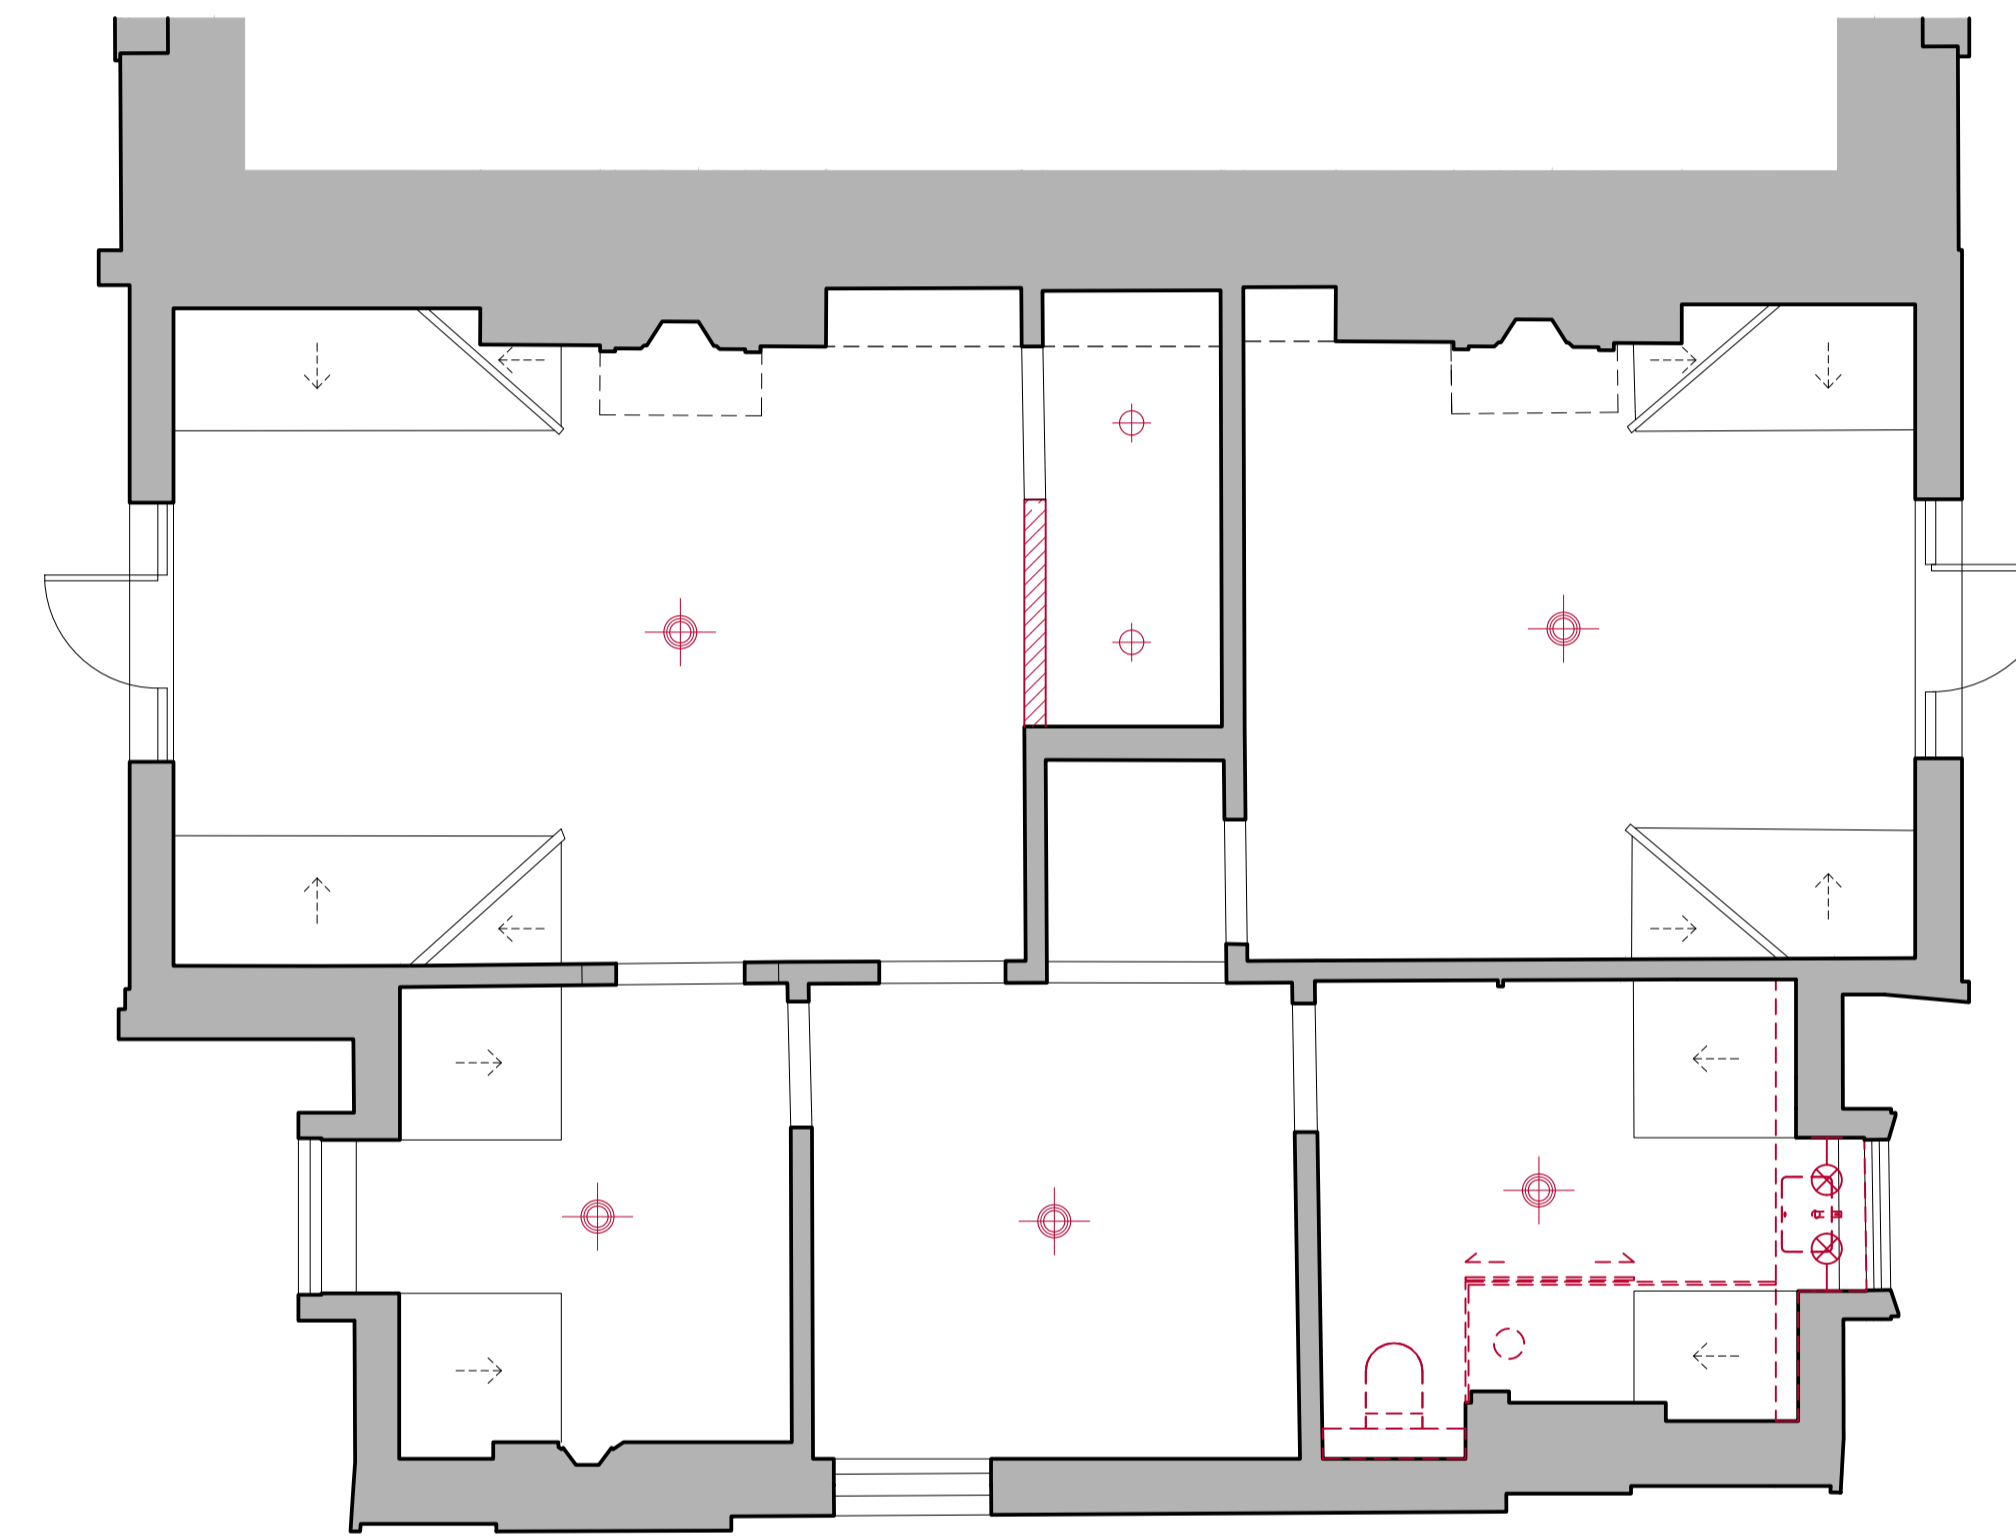

2 PROPOSED SECOND FLOOR RCP LIGHTING PLAN  
scale 1:50



Notes

No	PLANNING	Date	18.08.2023
Rev			

Status  
PLANNING



ARCHITECTS + INTERIOR DESIGNERS

91A - 91B HEATH STREET  
LONDON NW3 6SS  
Tel 020 7636 3838

INFO WWW.TG-STUDIO.CO.UK

Project: 9 GAINSBOROUGH GARDENS  
NW3 1BJ

Date	18.08.23	Scale @ A1	1:50
------	----------	------------	------

Drawing: PROPOSED  
FIRST & SECOND FLOOR  
RCP LIGHTING PLAN

Drawn by	AL	Checked by	TG
----------	----	------------	----

Job No.	270	Dwg No.	P-403	Rev	-
---------	-----	---------	-------	-----	---