


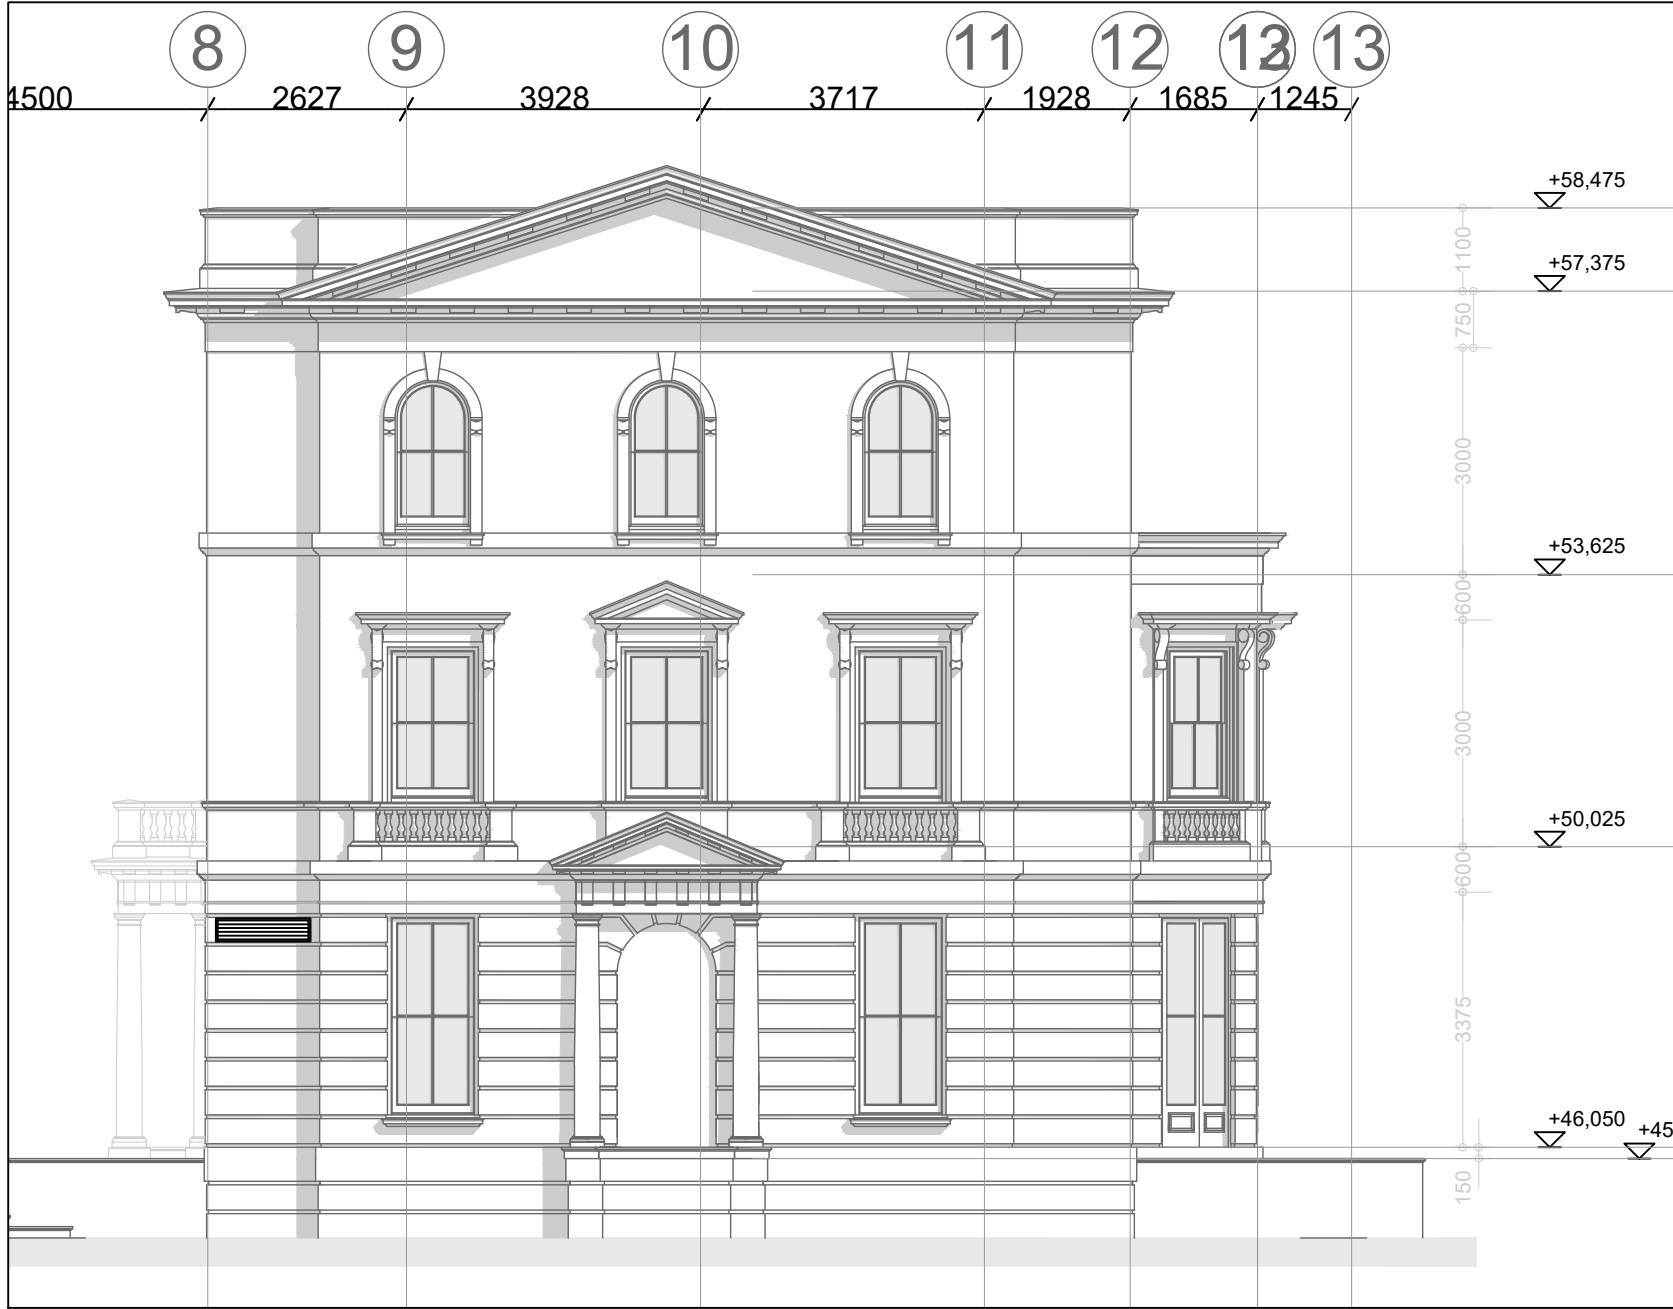

ELEVATION A
Scale 1:100




ELEVATION B
Scale 1:100




ELEVATION C
Scale 1:100




ELEVATION E
Scale 1:100

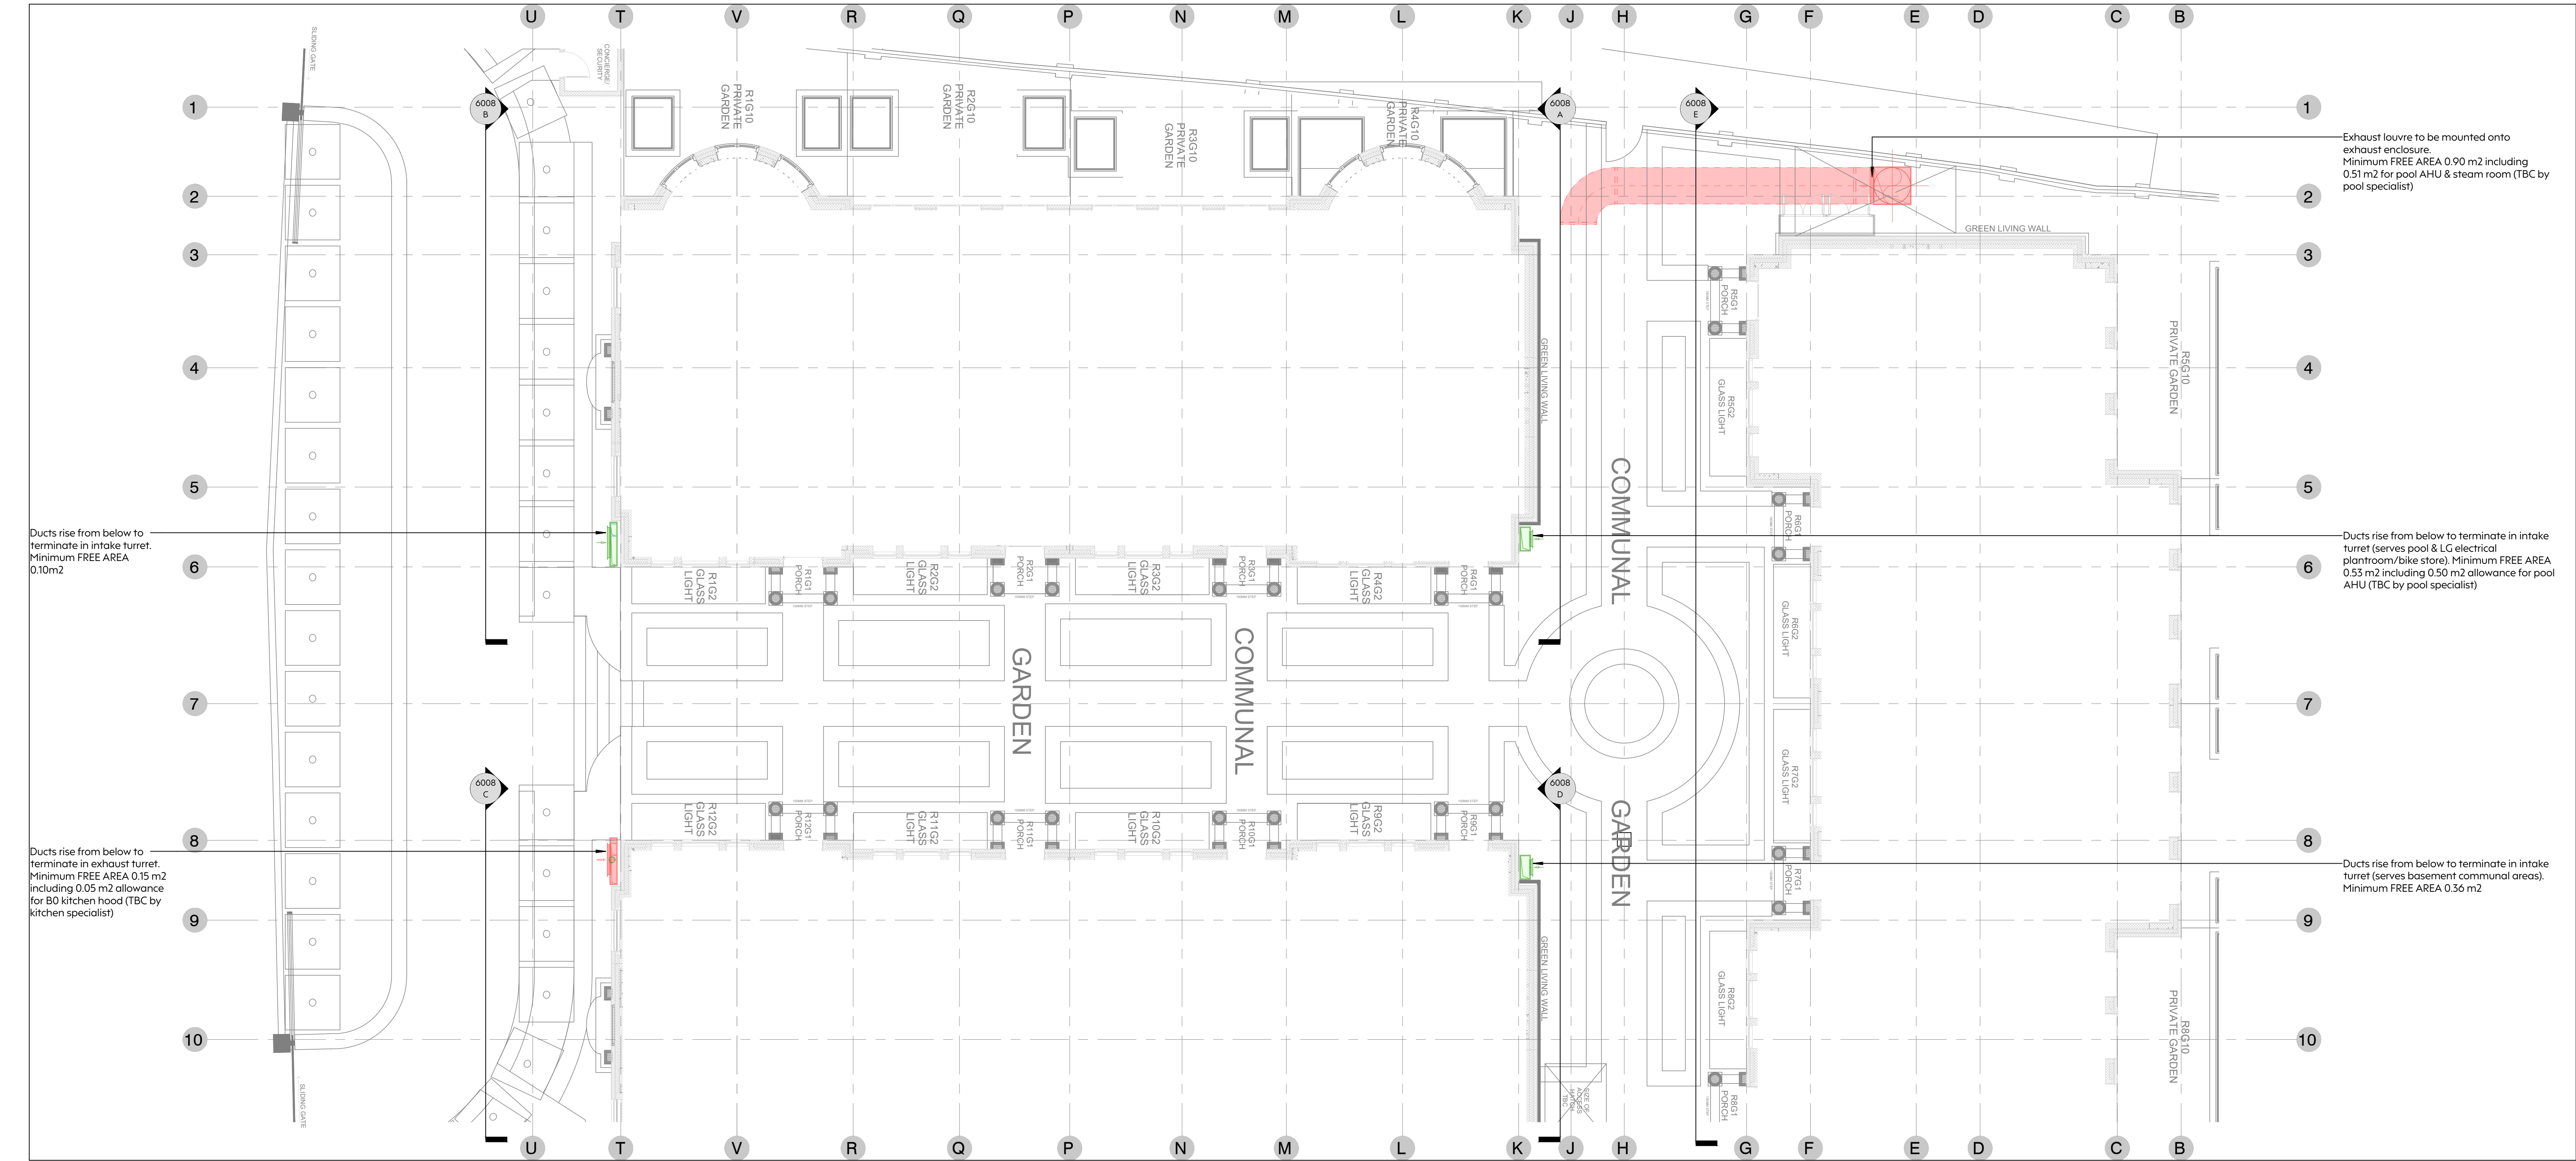

Ventilation Layout, Ground Floor
SCALE - 1:100

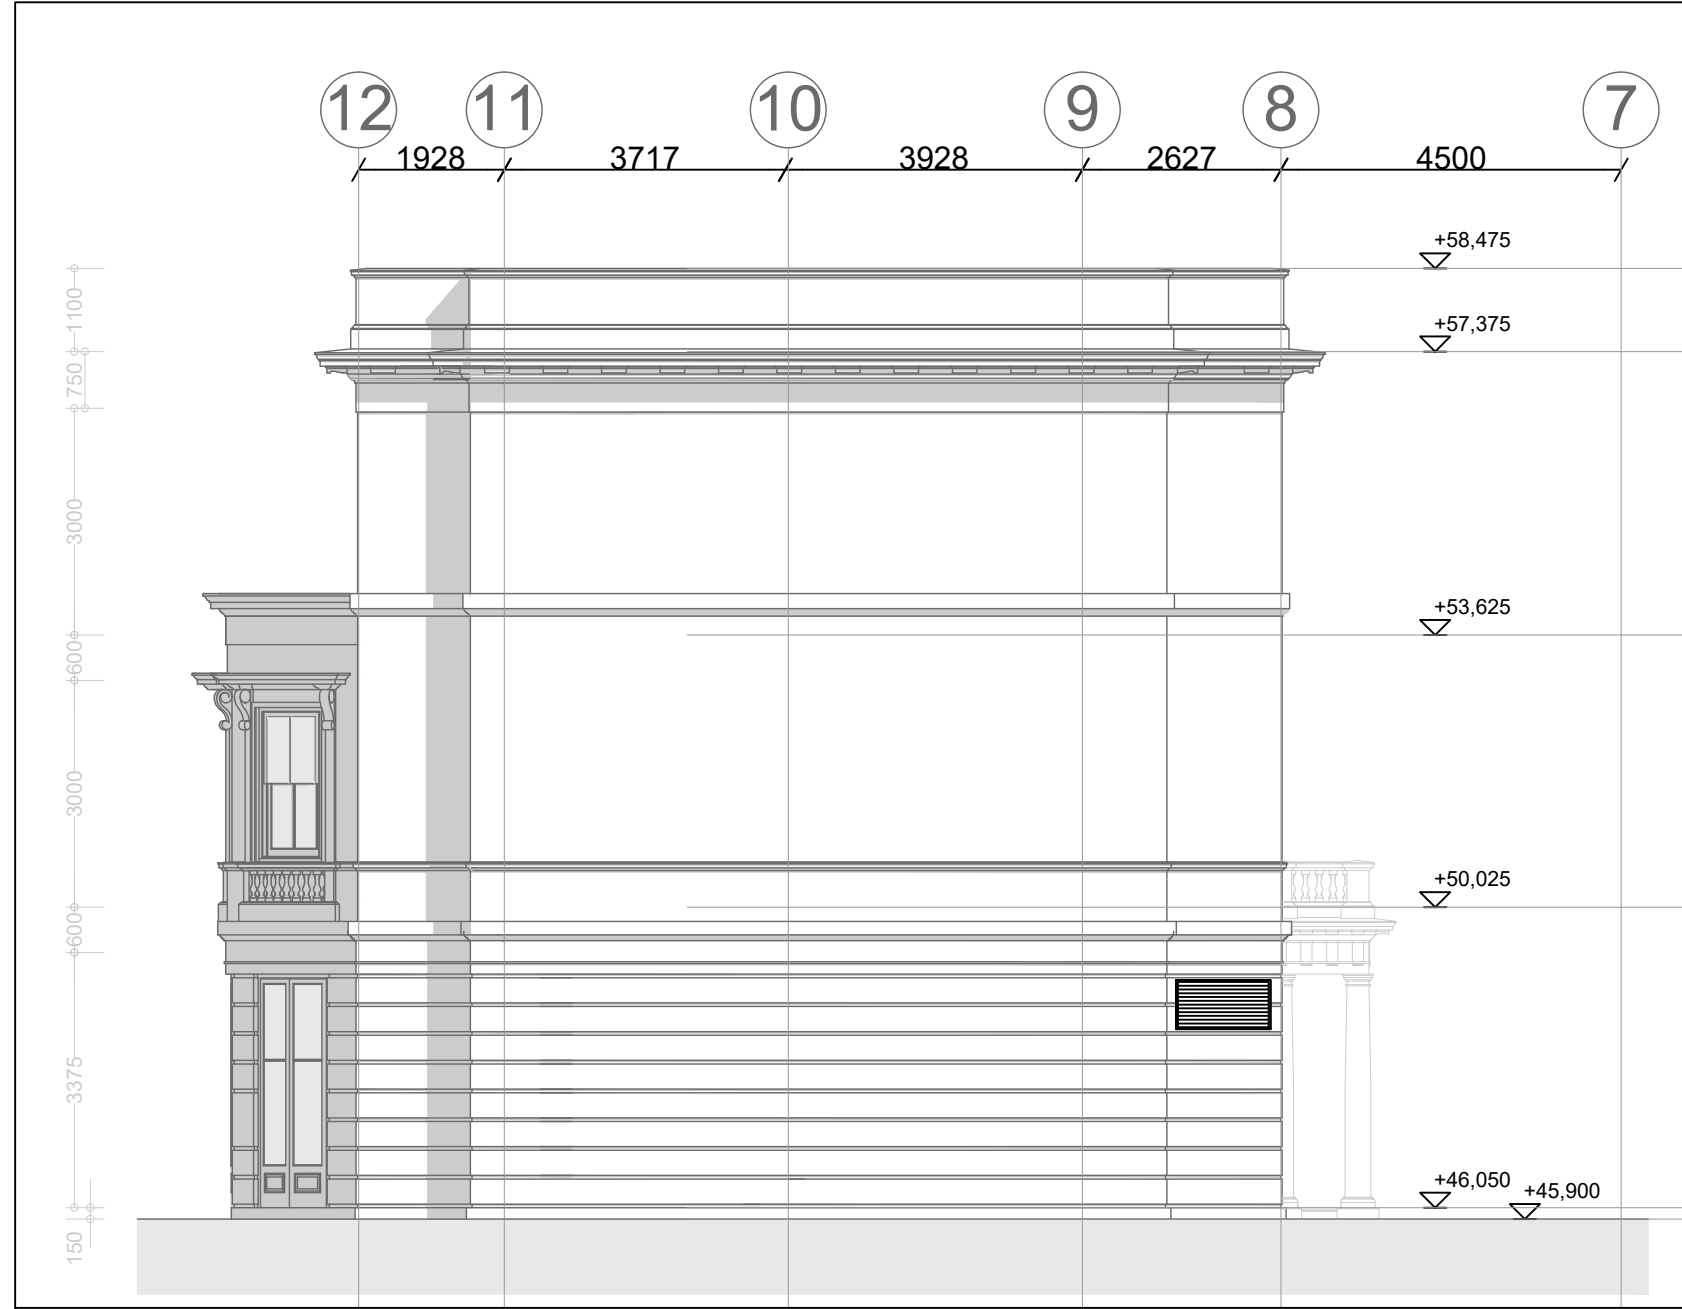

ELEVATION D
Scale 1:100

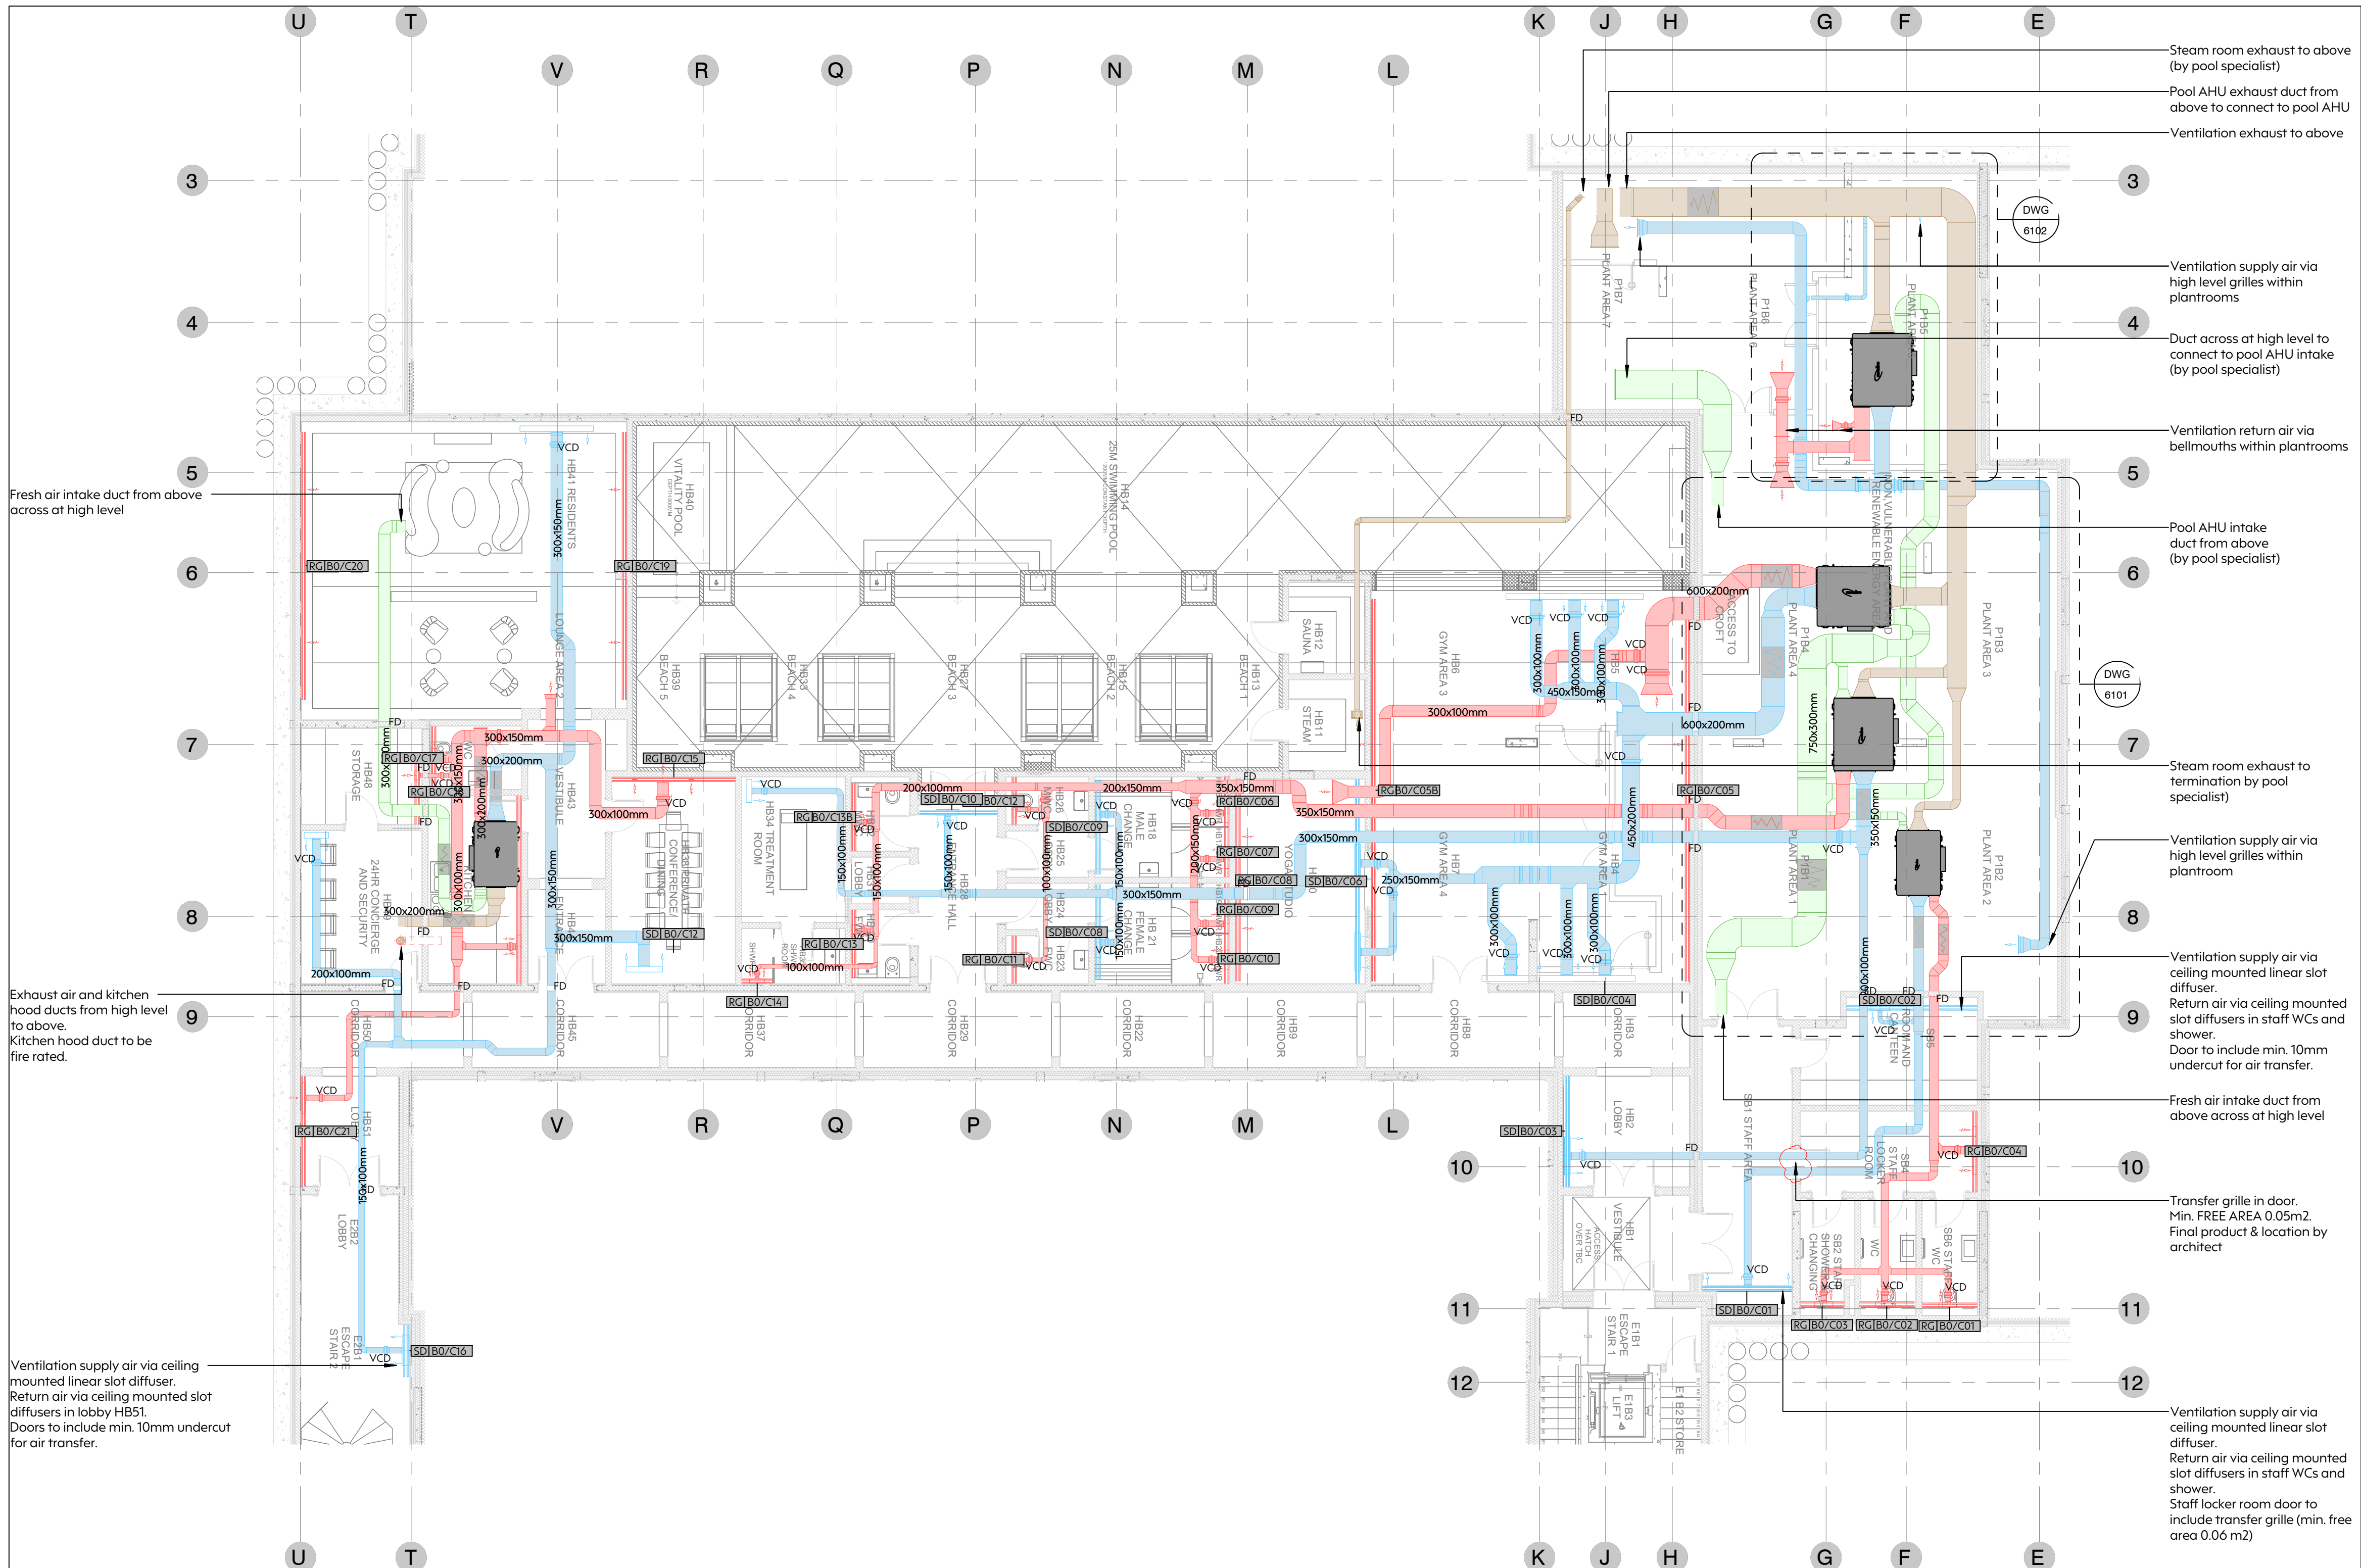

Ventilation Layout, Basement
SCALE - 1:100


NORTH



NOTES

- Do not scale this drawing
- This drawing shall be read in conjunction with all MEP drawings, schedules & specifications and relevant architectural and structural drawings & specifications
- This drawing has been produced for design purposes only and is not an installation or working drawing. Any installation based on this drawing is at the Contractor's risk.
- Refer to architectural drawings for setting out of all plant & equipment
- External louvers are indicative. Refer to architectural drawings for final sizes and setting out

LEGEND

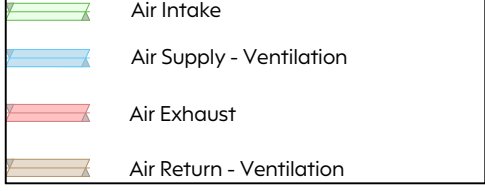

PROJECT

52-54 Avenue Road
London
NW6 6HP

Client

52 AVENUE ROAD LIMITED
Bridge House
Harker Street, Glassop
S61 5AP

Architect

DDHYS LONDON
Studio 80, Swinford House East
Bottersmoor Power Station
London SW17BB

DRAWING TITLE

Ventilation Services
Communal Spaces

DRAWING STATUS

Planning condition & discharge

Scale

1:100

Size

A0

Engineer

HSR

Date

15/08/2023

Stage

Checked

BC

DRAWING NO.

723-INT-150823-SK01

REV.

Integration

Integrationuk.com
+44 (0)20 735 8610
52-54 Rosebery Avenue
London EC1R 4BP
© Integration Consultancy Limited