


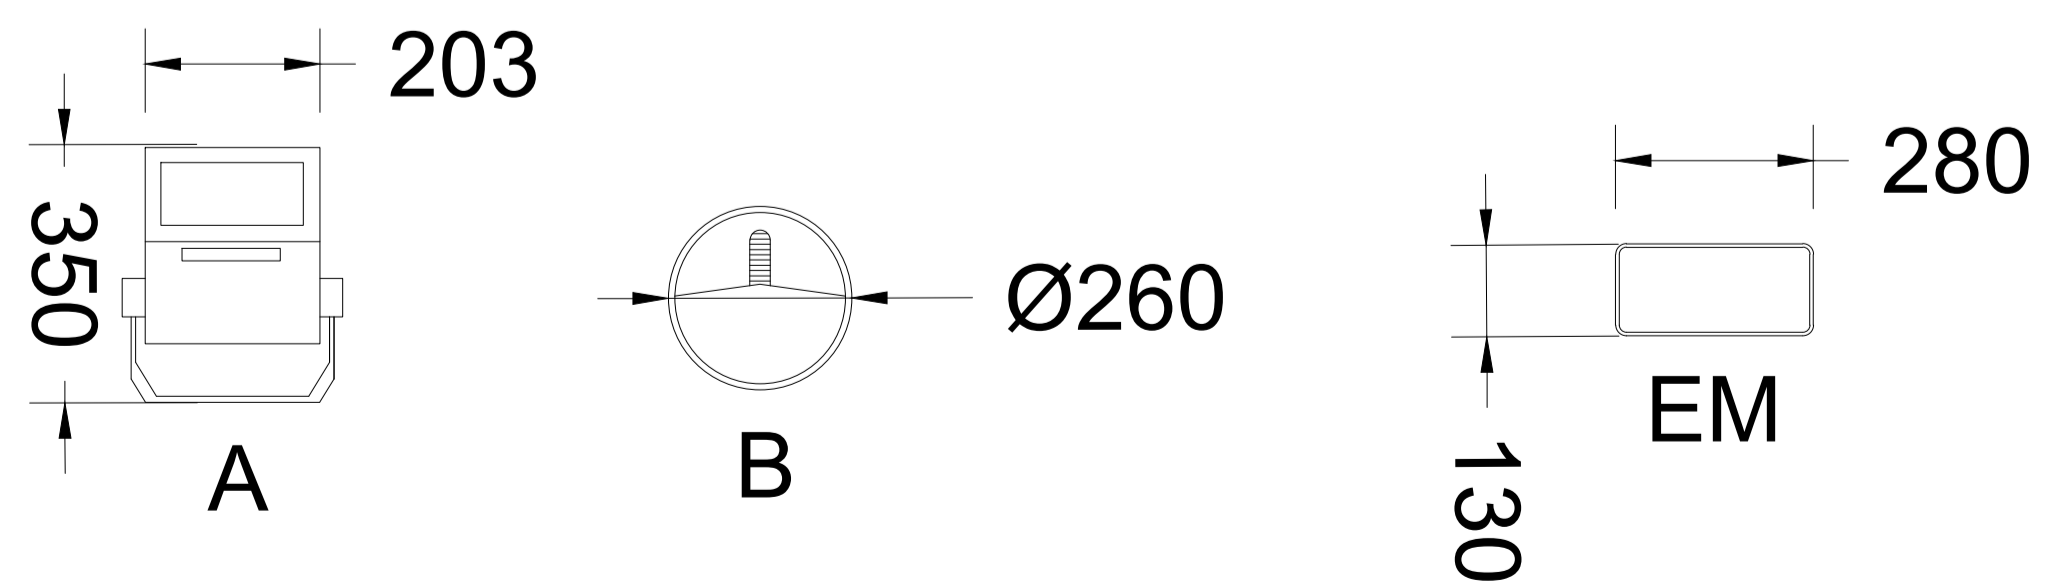
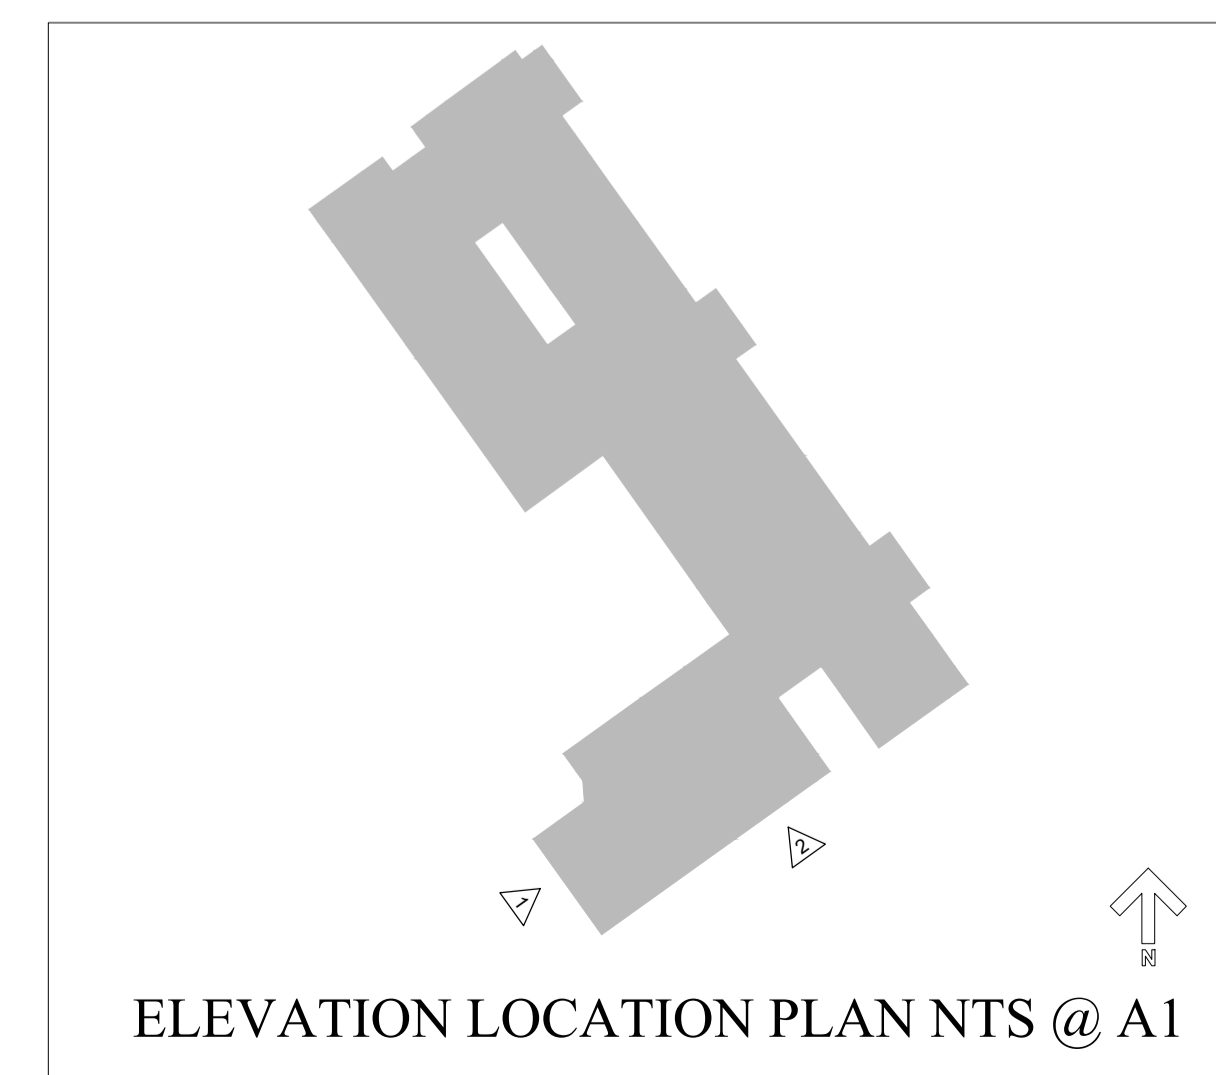


REAR ELEVATION (1) 1:100 @ A1


	TYPE 'A' LUMINAIRE
	TYPE 'B' LUMINAIRE
	TYPE 'EM' LUMINAIRE



LUMINAIRE DIMENSIONS NTS @ A1



ELEVATION LOCATION PLAN NTS @ A1

DRAWING STATUS: PLANNING APPLICATION		
 ALPINE WORKS LIMITED ELECTRICAL AND MECHANICAL CONTRACTORS 23-25 High Street Ewell Village, Epsom, Surrey KT17 1SB Tel: - 020 8644 2014 mail@alpineworks.co.uk www.alpineworks.co.uk		
CLIENT: UNIVERSITY COLLEGE LONDON ESTATES GOWER STREET LONDON WC1E 6BT		
PROJECT: 10E 20 BEDFORD WAY UPGRADING OF EXTERNAL LIGHTING		
TITLE: REAR BAR TERRACE PROPOSED LIGHTING ELEVATIONS		
SCALE & SIZE: 1:100 @ A1	CHECKED: AS	APPROVED: AS
CAD FILE:	DRAWN: HB	DATE: May 23
PROJECT No:	DRAWING No: ALP-20BED-EXT-LTG-002	REV: A