


Copyright Portakabin Limited 2013. Member of the Portakabin Group.
 This drawing is the property of Portakabin Limited. It must not be copied or reproduced or divulged to anyone without written permission.

Do not scale off this drawing. All discrepancies to be reported to Portakabin Limited.

Rev:	Date:	Description:	By:
-	30/09/20	Proposed Electrical Layout - First Issue	MDH

ELECTRICAL KEY

PIR	EXTERNAL LED LIGHT w. PIR
2g	TWIN SWITCHED SOCKET OUTLET
D	TWIN DATA OUTLET

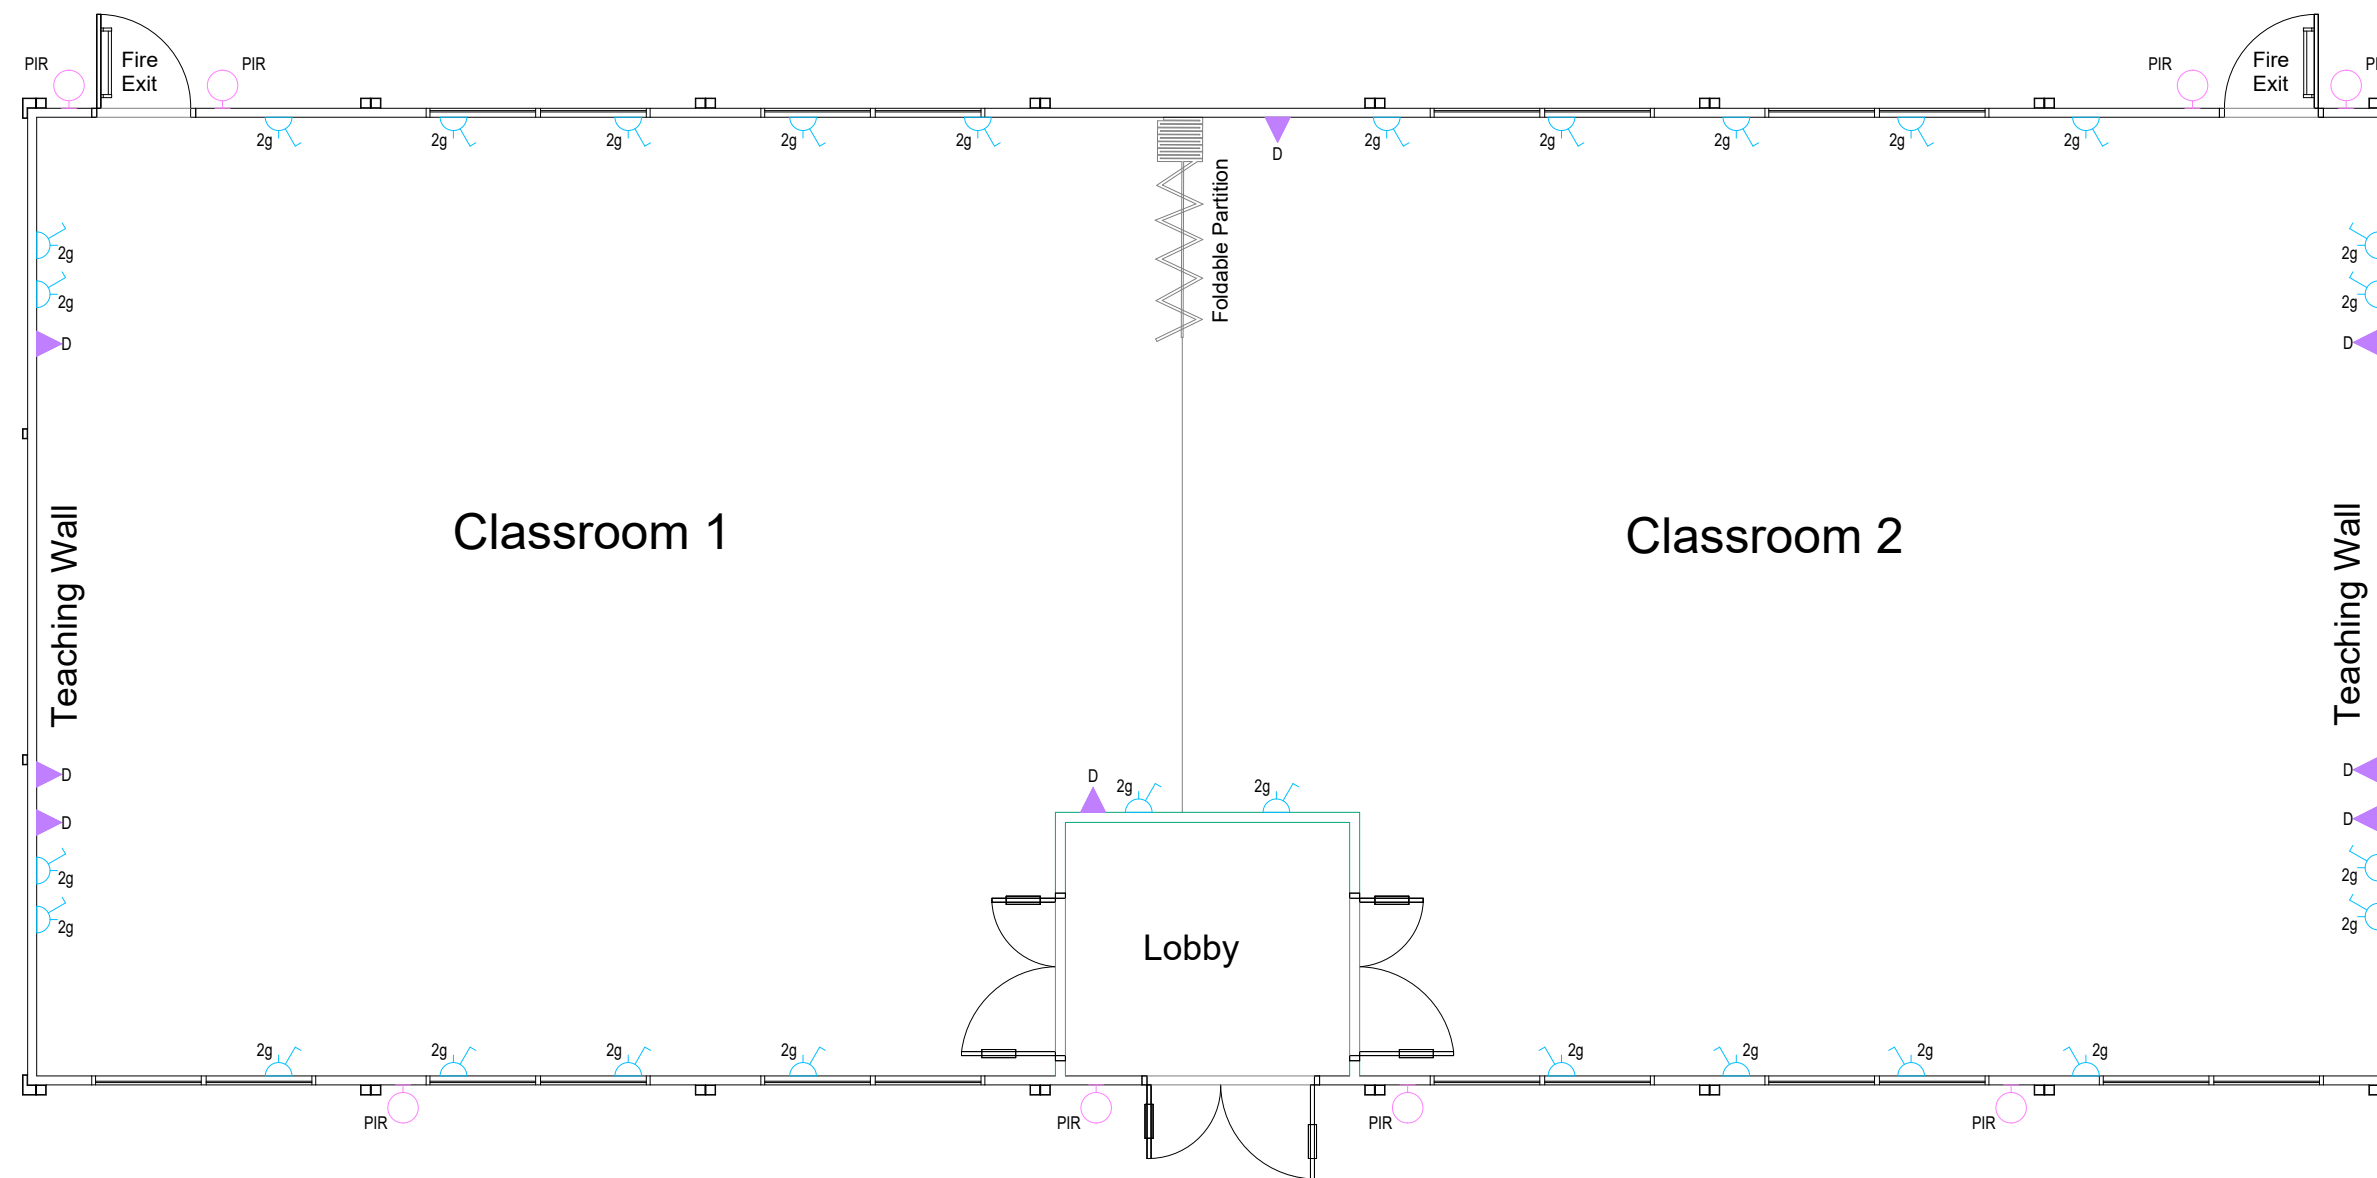

Portakabin Portakabin Hire
 Huntington
 York YO32 9PT
 Quality - this time - next time - every time
 T:01904 611655
 www.portakabin.co.uk

Client: ESCP Business School		
Project: Library & Study Centre		
Title: Proposed Electrical Layout		
Scale: NTS	Date: 22/09/23	Drawn By: MDH
Drawing Number: HD/13313/01 - E01	Rev: -	