 


1 L - 00. BL - Floor Plan  
1 : 50

FIRE PREVENTING LEGEND KEY

- ALARM SOUNDER  
Fire alarm bell min 65 db
- FIRE INDICATOR PANEL
- EMERGENCY LIGHTING  
3 hour non maintained
- S22 SIGN- EMERGENCY EXIT  
Non illuminated
- SS SIGN-EMERGENCY EXIT NOTICE  
Indicates that the notice is internally illuminated. Wall and ceiling mounted
- S SMOKE DETECTOR  
Linked into fire alarm system
- K HEAT DETECTOR
- CALL POINT
- 1/2 HR FR 1/2 HOUR FIRE RESISTANT SELF CLOSING DOOR  
with smoke seals and intumescent strips.
- 1 HR FR 1 HOUR FIRE RESISTANT SELF CLOSING DOOR  
with smoke seals and intumescent strips.
- AOV AUTOMATIC OPENING VENT  
For AOV Control panel in the Fire Panel
- FLASHING ALARM
- CCTV
- PB FIRE EXIT DOORS FITTED WITH EMERGENCY PUSH BAR FACILITY DETECTOR
- SF SIMPLE FASTENING
- VP VISION PANEL
- S13 SIGN - FIRE DOOR KEEP SHUT
- S14 SIGN - FIRE DOOR KEEP LOCKED
- GIPB GAS INTERLOCK PUSH BUTTON

No.	Description	Date



- Fire Extinguisher - Water
- Fire Extinguisher - Foam
- Fire Extinguisher - CO2
- Fire Blanket
- Warning Device Sounder
- Escape Route - Direction to Follow
- Escape Route - Final Exit


KEY TO AREAS

- Drinking Area
- Toilet / Passageways
- Liquor Storage
- Kitchen

KEY TO LINES

- Demise of A3 Area
- Extend Area
- 60 min. WALL CONSTRUCTION
- 30 min. WALL CONSTRUCTION

Project Status	
Preliminary	
CONTRACTORS MUST VERIFY ALL DIMENSIONS ON SITE BEFORE STARTING WORK. THIS DRAWING IS COPYRIGHT.	
Project	42 Kingsway WC2B 6EX
Client	Zeren Food Limited
Drawing Title	Licencing_Basement Floor
Project Number	221108
Date	November 22
Drawn by	Author
Checked by	Checker
Scale	1 : 100 @ A3 1 : 50 @ A1
Drawing No.	L 101

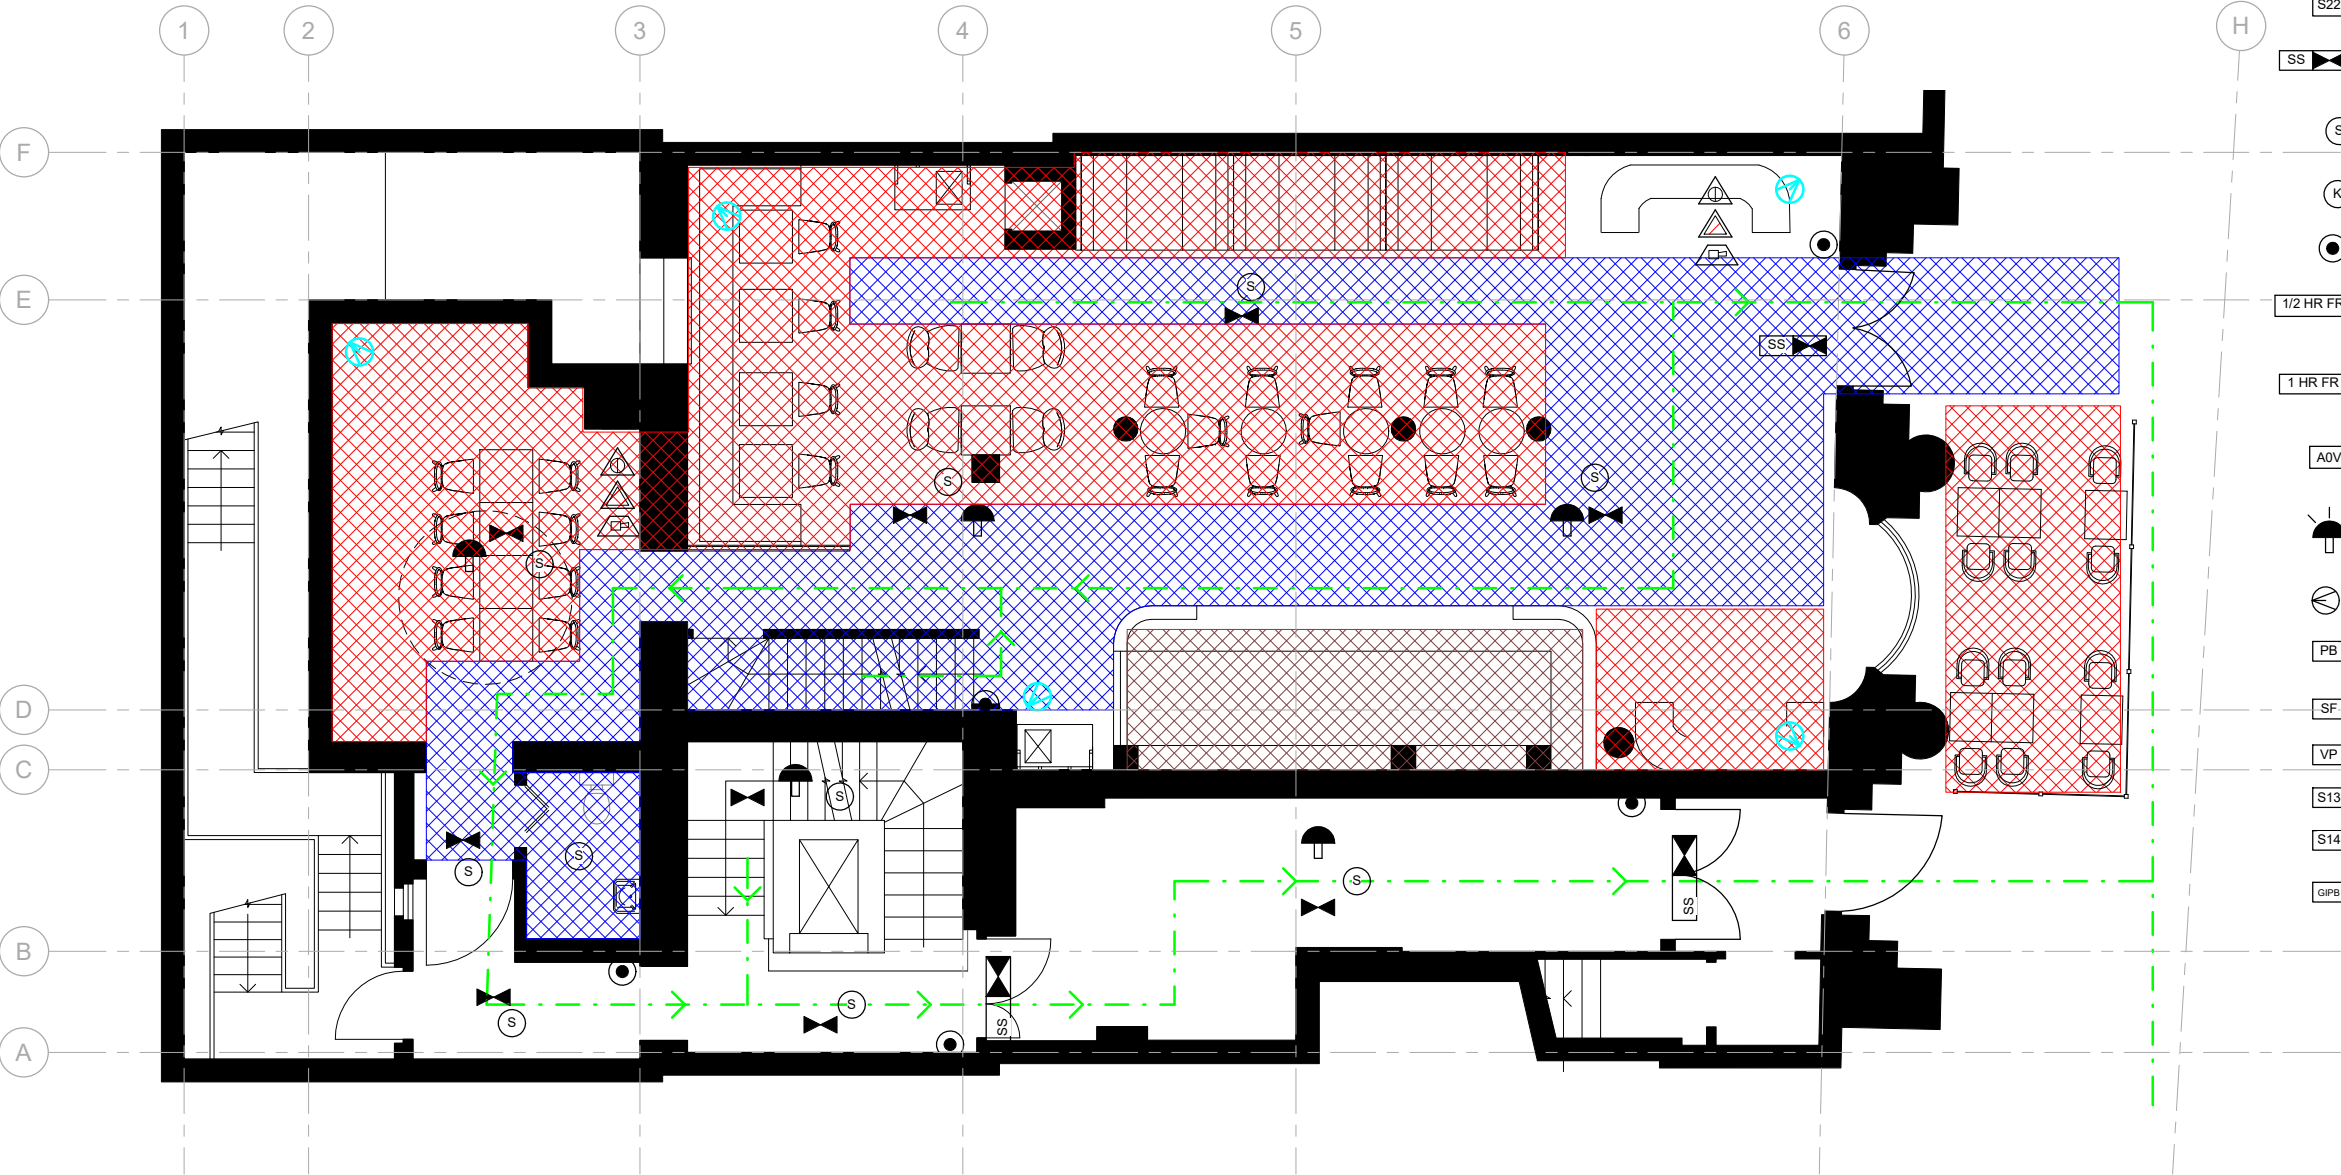


1 L - 01. GF - Floor Plan  
1 : 50

FIRE PREVENTING LEGEND KEY

- ALARM SOUNDER  
Fire alarm bell min 65 db
- FIRE INDICATOR PANEL
- EMERGENCY LIGHTING  
3 hour non maintained
- SIGN- EMERGENCY EXIT  
Non illuminated
- SIGN-EMERGENCY EXIT NOTICE  
Indicates that the notice is internally illuminated. Wall and ceiling mounted
- SMOKE DETECTOR  
Linked into fire alarm system
- HEAT DETECTOR
- CALL POINT
- 1/2 HR FR  
1/2 HOUR FIRE RESISTANT SELF CLOSING DOOR with smoke seals and intumescent strips.
- 1 HR FR  
1 HOUR FIRE RESISTANT SELF CLOSING DOOR with smoke seals and intumescent strips.
- AOV  
AUTOMATIC OPENING VENT  
For AOV Control panel in the Fire Panel
- FLASHING ALARM
- CCTV
- PB  
FIRE EXIT DOORS FITTED WITH EMERGENCY PUSH BAR FACILITY DETECTOR
- SF  
SIMPLE FASTENING
- VP  
VISION PANEL
- S13  
SIGN - FIRE DOOR KEEP SHUT
- S14  
SIGN - FIRE DOOR KEEP LOCKED
- GIPB  
GAS INTERLOCK PUSH BUTTON

No.	Description	Date

 


- Fire Extinguisher - Water
- Fire Extinguisher - Foam
- Fire Extinguisher - CO2
- Fire Blanket
- Warning Device Sounder
- Escape Route - Direction to Follow
- Escape Route - Final Exit

- KEY TO AREAS
- Drinking Area
  - Toilet / Passageways
  - Liquor Storage
  - Kitchen

- KEY TO LINES
- Demise of A3 Area
  - Extend Area
  - 60 min. WALL CONSTRUCTION
  - 30 min. WALL CONSTRUCTION

Project Status	
Preliminary	
CONTRACTORS MUST VERIFY ALL DIMENSIONS ON SITE BEFORE STARTING WORK. THIS DRAWING IS COPYRIGHT.	
Project	
42 Kingsway WC2B 6EX	
Client	
Zeren Food Limited	
Drawing Title	
Licencing_Ground Floor	
Project Number	Date
221108	November 22
Drawn by	Checked by
Author	Checker
Scale	Revision
1 : 100 @ A3 1 : 50 @ A1	
Drawing No.	
L 102	

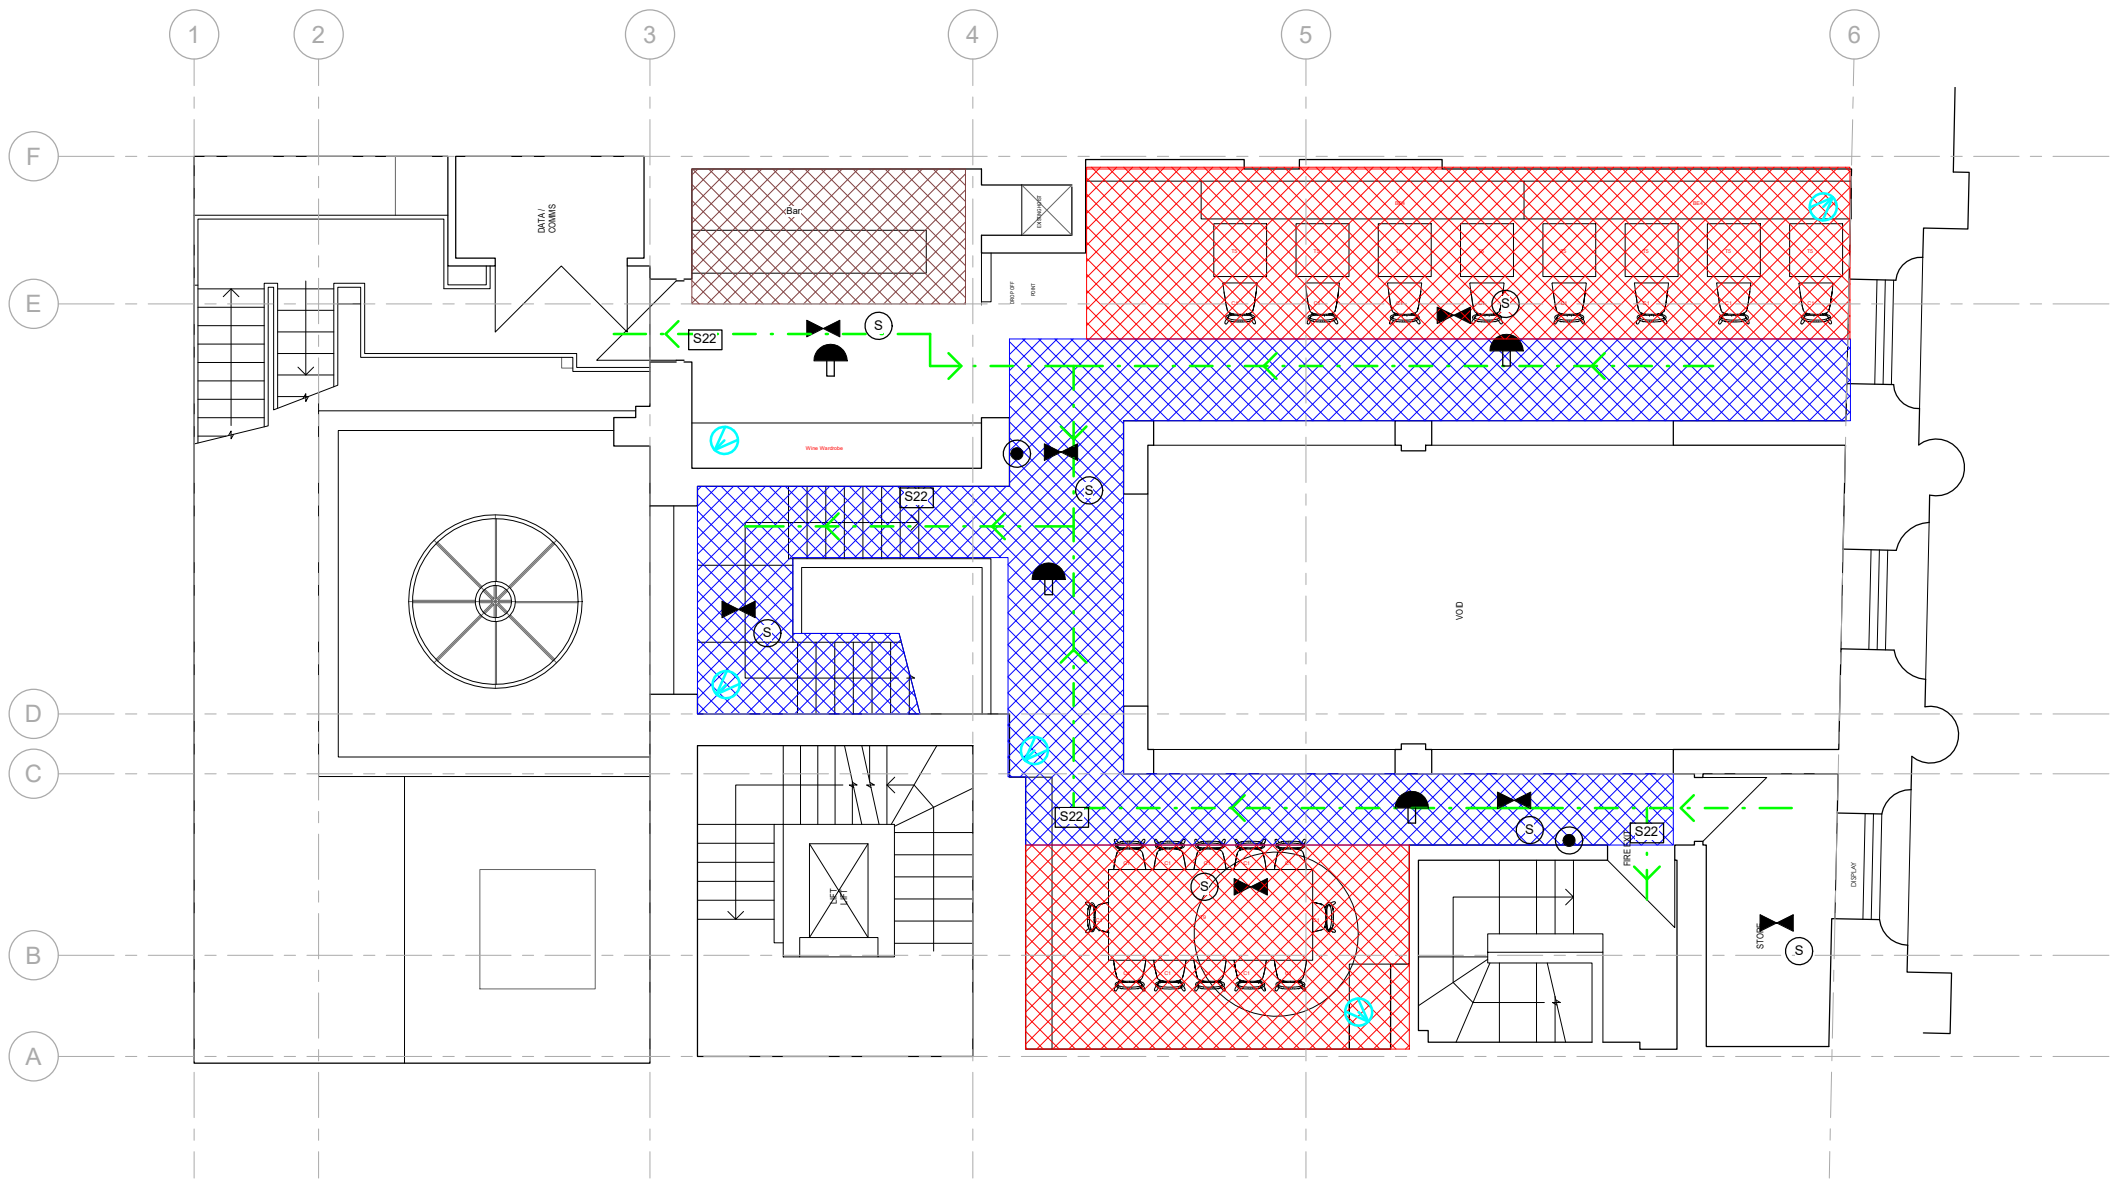

**1 L - 02. MF - Floor Plan**  
1 : 50

**FIRE PREVENTING LEGEND KEY**

- ALARM SOUNDER  
Fire alarm bell min 65 db
- FIRE INDICATOR PANEL
- EMERGENCY LIGHTING  
3 hour non maintained
- SIGN- EMERGENCY EXIT  
Non illuminated
- SIGN-EMERGENCY EXIT NOTICE  
Indicates that the notice is internally illuminated. Wall and ceiling mounted
- SMOKE DETECTOR  
Linked into fire alarm system
- HEAT DETECTOR
- CALL POINT
- 1/2 HOUR FIRE RESISTANT SELF CLOSING DOOR  
with smoke seals and intumescent strips.
- 1 HOUR FIRE RESISTANT SELF CLOSING DOOR  
with smoke seals and intumescent strips.
- AUTOMATIC OPENING VENT  
For AOV Control panel in the Fire Panel
- FLASHING ALARM
- CCTV
- FIRE EXIT DOORS FITTED WITH EMERGENCY PUSH BAR FACILITY DETECTOR
- SIMPLE FASTENING
- VISION PANEL
- SIGN - FIRE DOOR KEEP SHUT
- SIGN - FIRE DOOR KEEP LOCKED
- GAS INTERLOCK PUSH BUTTON

- Fire Extinguisher - Water
- Fire Extinguisher - Foam
- Fire Extinguisher - CO2
- Fire Blanket
- Warning Device Sounder
- Escape Route - Direction to Follow
- Escape Route - Final Exit

**KEY TO AREAS**

- Drinking Area
- Toilet / Passageways
- Liquor Storage
- Kitchen

**KEY TO LINES**

- Demise of A3 Area
- Extend Area
- 60 min. WALL CONSTRUCTION
- 30 min. WALL CONSTRUCTION

Project Status	
Preliminary	
CONTRACTORS MUST VERIFY ALL DIMENSIONS ON SITE BEFORE STARTING WORK. THIS DRAWING IS COPYRIGHT.	
Project	
42 Kingsway WC2B 6EX	
Client	
Zeren Food Limited	
Drawing Title	
Licencing_Mezanine Floor	
Project Number	Date
221108	November 22
Drawn by	Checked by
Author	Checker
Scale	Revision
1 : 100 @ A3 1 : 50 @ A1	
Drawing No.	
L 103	