

GROUND FLOOR SECURITY KEY

RED ICONS - NEW DEVICES
(Full installations)


MAGENTA ICONS - REPLACE EXISTING
(Re-use existing cable)

- NEW CAMERA 6.0C-H5A-DP1-IR
- REPLACE EXISTING CAMERA WITH - 6.0C-H5A-DP1-IR
- NEW CAMERA 6.0C-H5A-DC1-IR
- REPLACE EXISTING CAMERA WITH - 6.0C-H5A-DC1-IR
- NEW CAMERA - 2.0C-H5A-DC1-IR
- REPLACE EXISTING CAMERA WITH - 2.0C-H5A-DC1-IR
- NEW CAMERA - 20C-H4A-4MH-360
- REPLACE EXISTING CAMERA WITH - 8.0C-H5A-FE-D01-IR
- NEW CAMERA - 15C-H5A-3MH
- NEW CAMERA - 2.0C-H5A-IRPTZ-DP40-WP
- REPLACE EXISTING CAMERA WITH - 2.0C-H5A-IRPTZ-DP40-WP

3,4,5,8 & 10th FLOOR SECURITY KEY

RED ICONS - NEW DEVICES
(Full installations)

- NEW CAMERA IME 539-1ERS
- NEW CAMERA IME 539-1IRS
- NEW CAMERA IME 238-1IRS
- NEW CAMERA IMF 82-1ERS
- NEW CAMERA IMD 15118

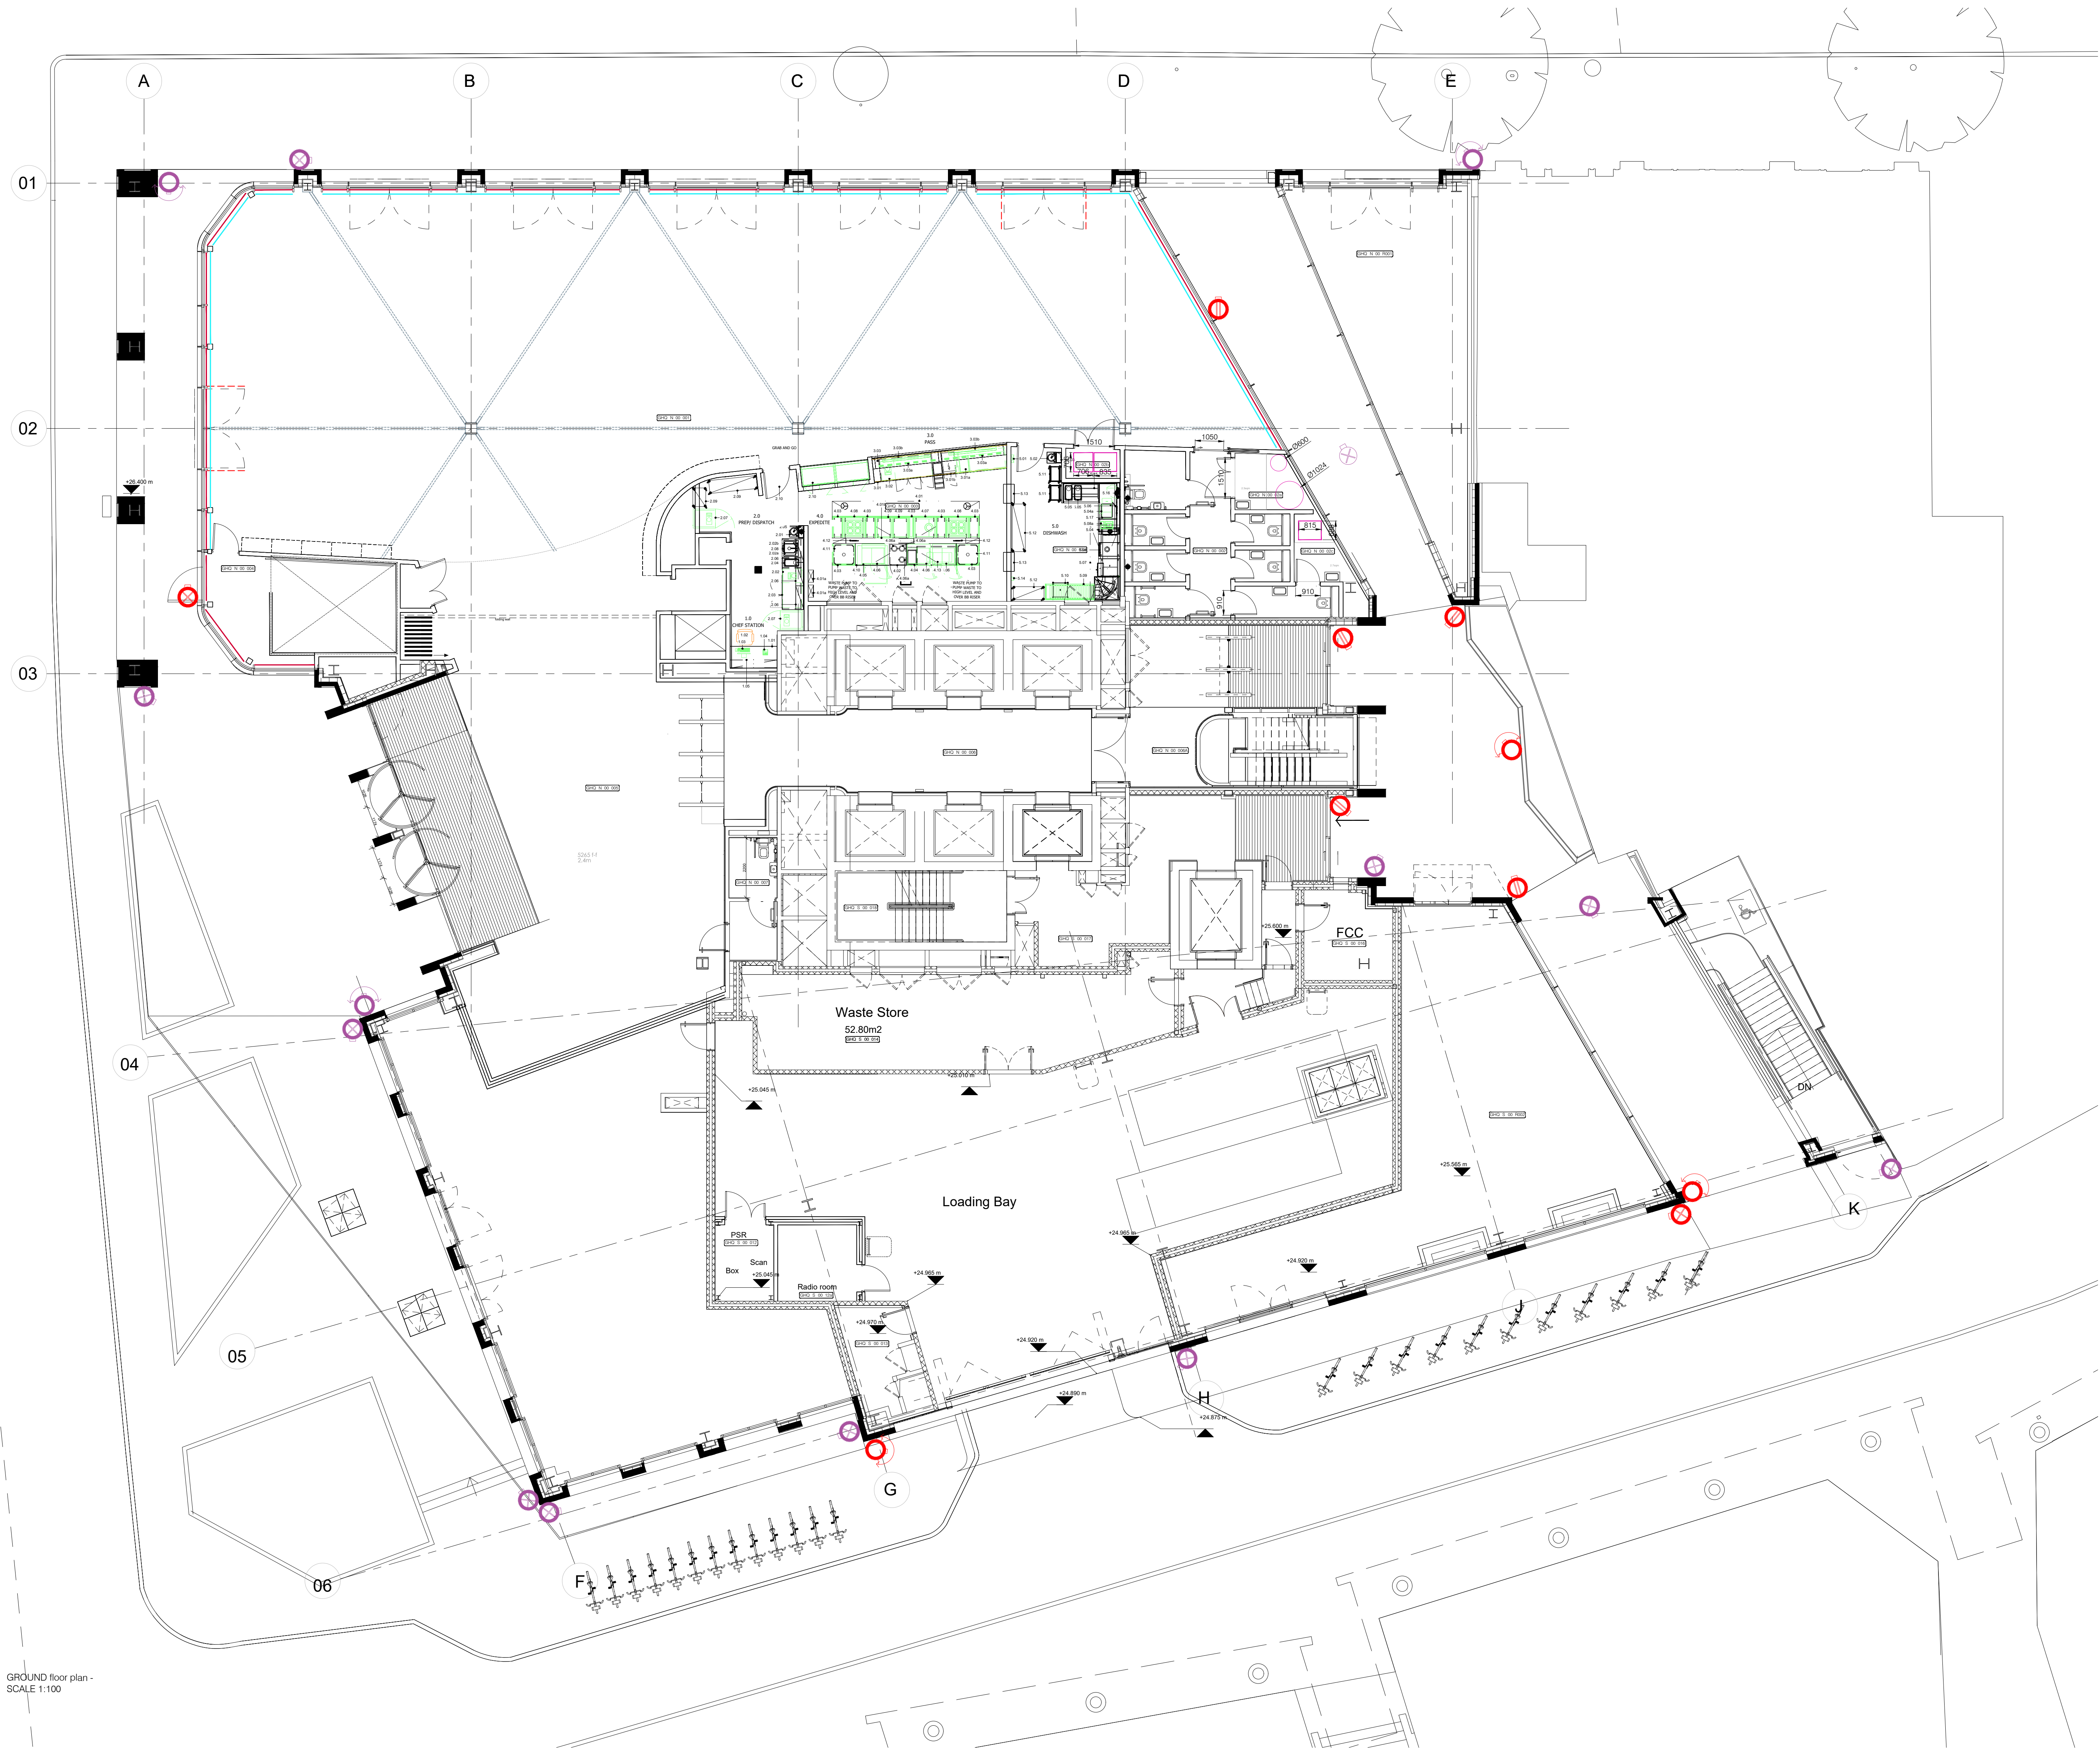

GROUND floor plan -
SCALE 1:100

T3	22.09.23	Tender - Updated ICONS	PW
T2	08.09.23	Tender - Updated CCTV information	PW
T1	25.08.23	Tender	PW
P1	21.04.23	Preliminary Issue	JB
REV	DATE	DESCRIPTION	BY

CLIENT

GSK

PROJECT TITLE

London Office - GSK

DRAWING TITLE

Planning - Proposed Ground

Floor Plan

DATE

21.04.23

SCALE

1:100 @ A0

DRAWN

JB

CHECKED

LP

PENSON

TELEPHONE

+44 - 207 403

WEBSITE

www.penson.co

PROJECT NO

3314

DRAWING NO

I-X12

REVISION

T3