






 
 




**GROUND FLOOR SECURITY KEY**


 



RED ICONS - NEW DEVICES  
(Full installations)



MAGENTA ICONS - REPLACE EXISTING  
(Re-use existing cable)

-  NEW CAMERA 6.0C-H5A-DP1-IR
-  REPLACE EXISTING CAMERA WITH - 6.0C-H5A-DP1-IR
-  NEW CAMERA 6.0C-H5A-DC1-IR
-  REPLACE EXISTING CAMERA WITH - 6.0C-H5A-DC1-IR
-  NEW CAMERA - 2.0C-H5A-DC1-IR
-  REPLACE EXISTING CAMERA WITH - 2.0C-H5A-DC1-IR
-  NEW CAMERA - 20C-H4A-4MH-360
-  REPLACE EXISTING CAMERA WITH - 8.0C-H5A-FE-D01-IR
-  NEW CAMERA - 15C-H5A-3MH
-  NEW CAMERA - 2.0C-H5A-IRPTZ-DP40-WP
-  REPLACE EXISTING CAMERA WITH - 2.0C-H5A-IRPTZ-DP40-WP

**3,4,5,8 & 10th FLOOR SECURITY KEY**

RED ICONS - NEW DEVICES  
(Full installations)

-  NEW CAMERA IME 539-1ERS
-  NEW CAMERA IME 539-1IRS
-  NEW CAMERA IME 238-1IRS
-  NEW CAMERA IMF 82-1ERS
-  NEW CAMERA IMD 15118

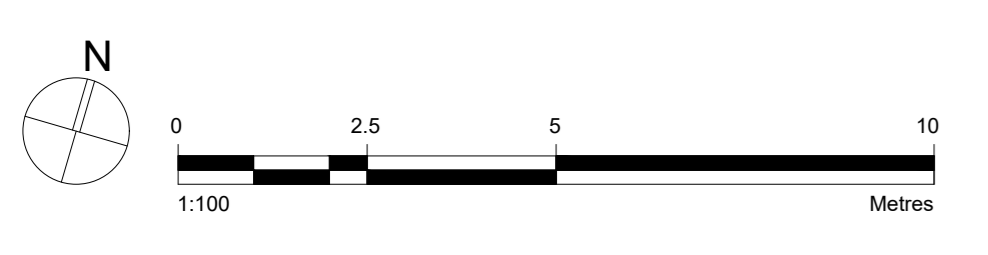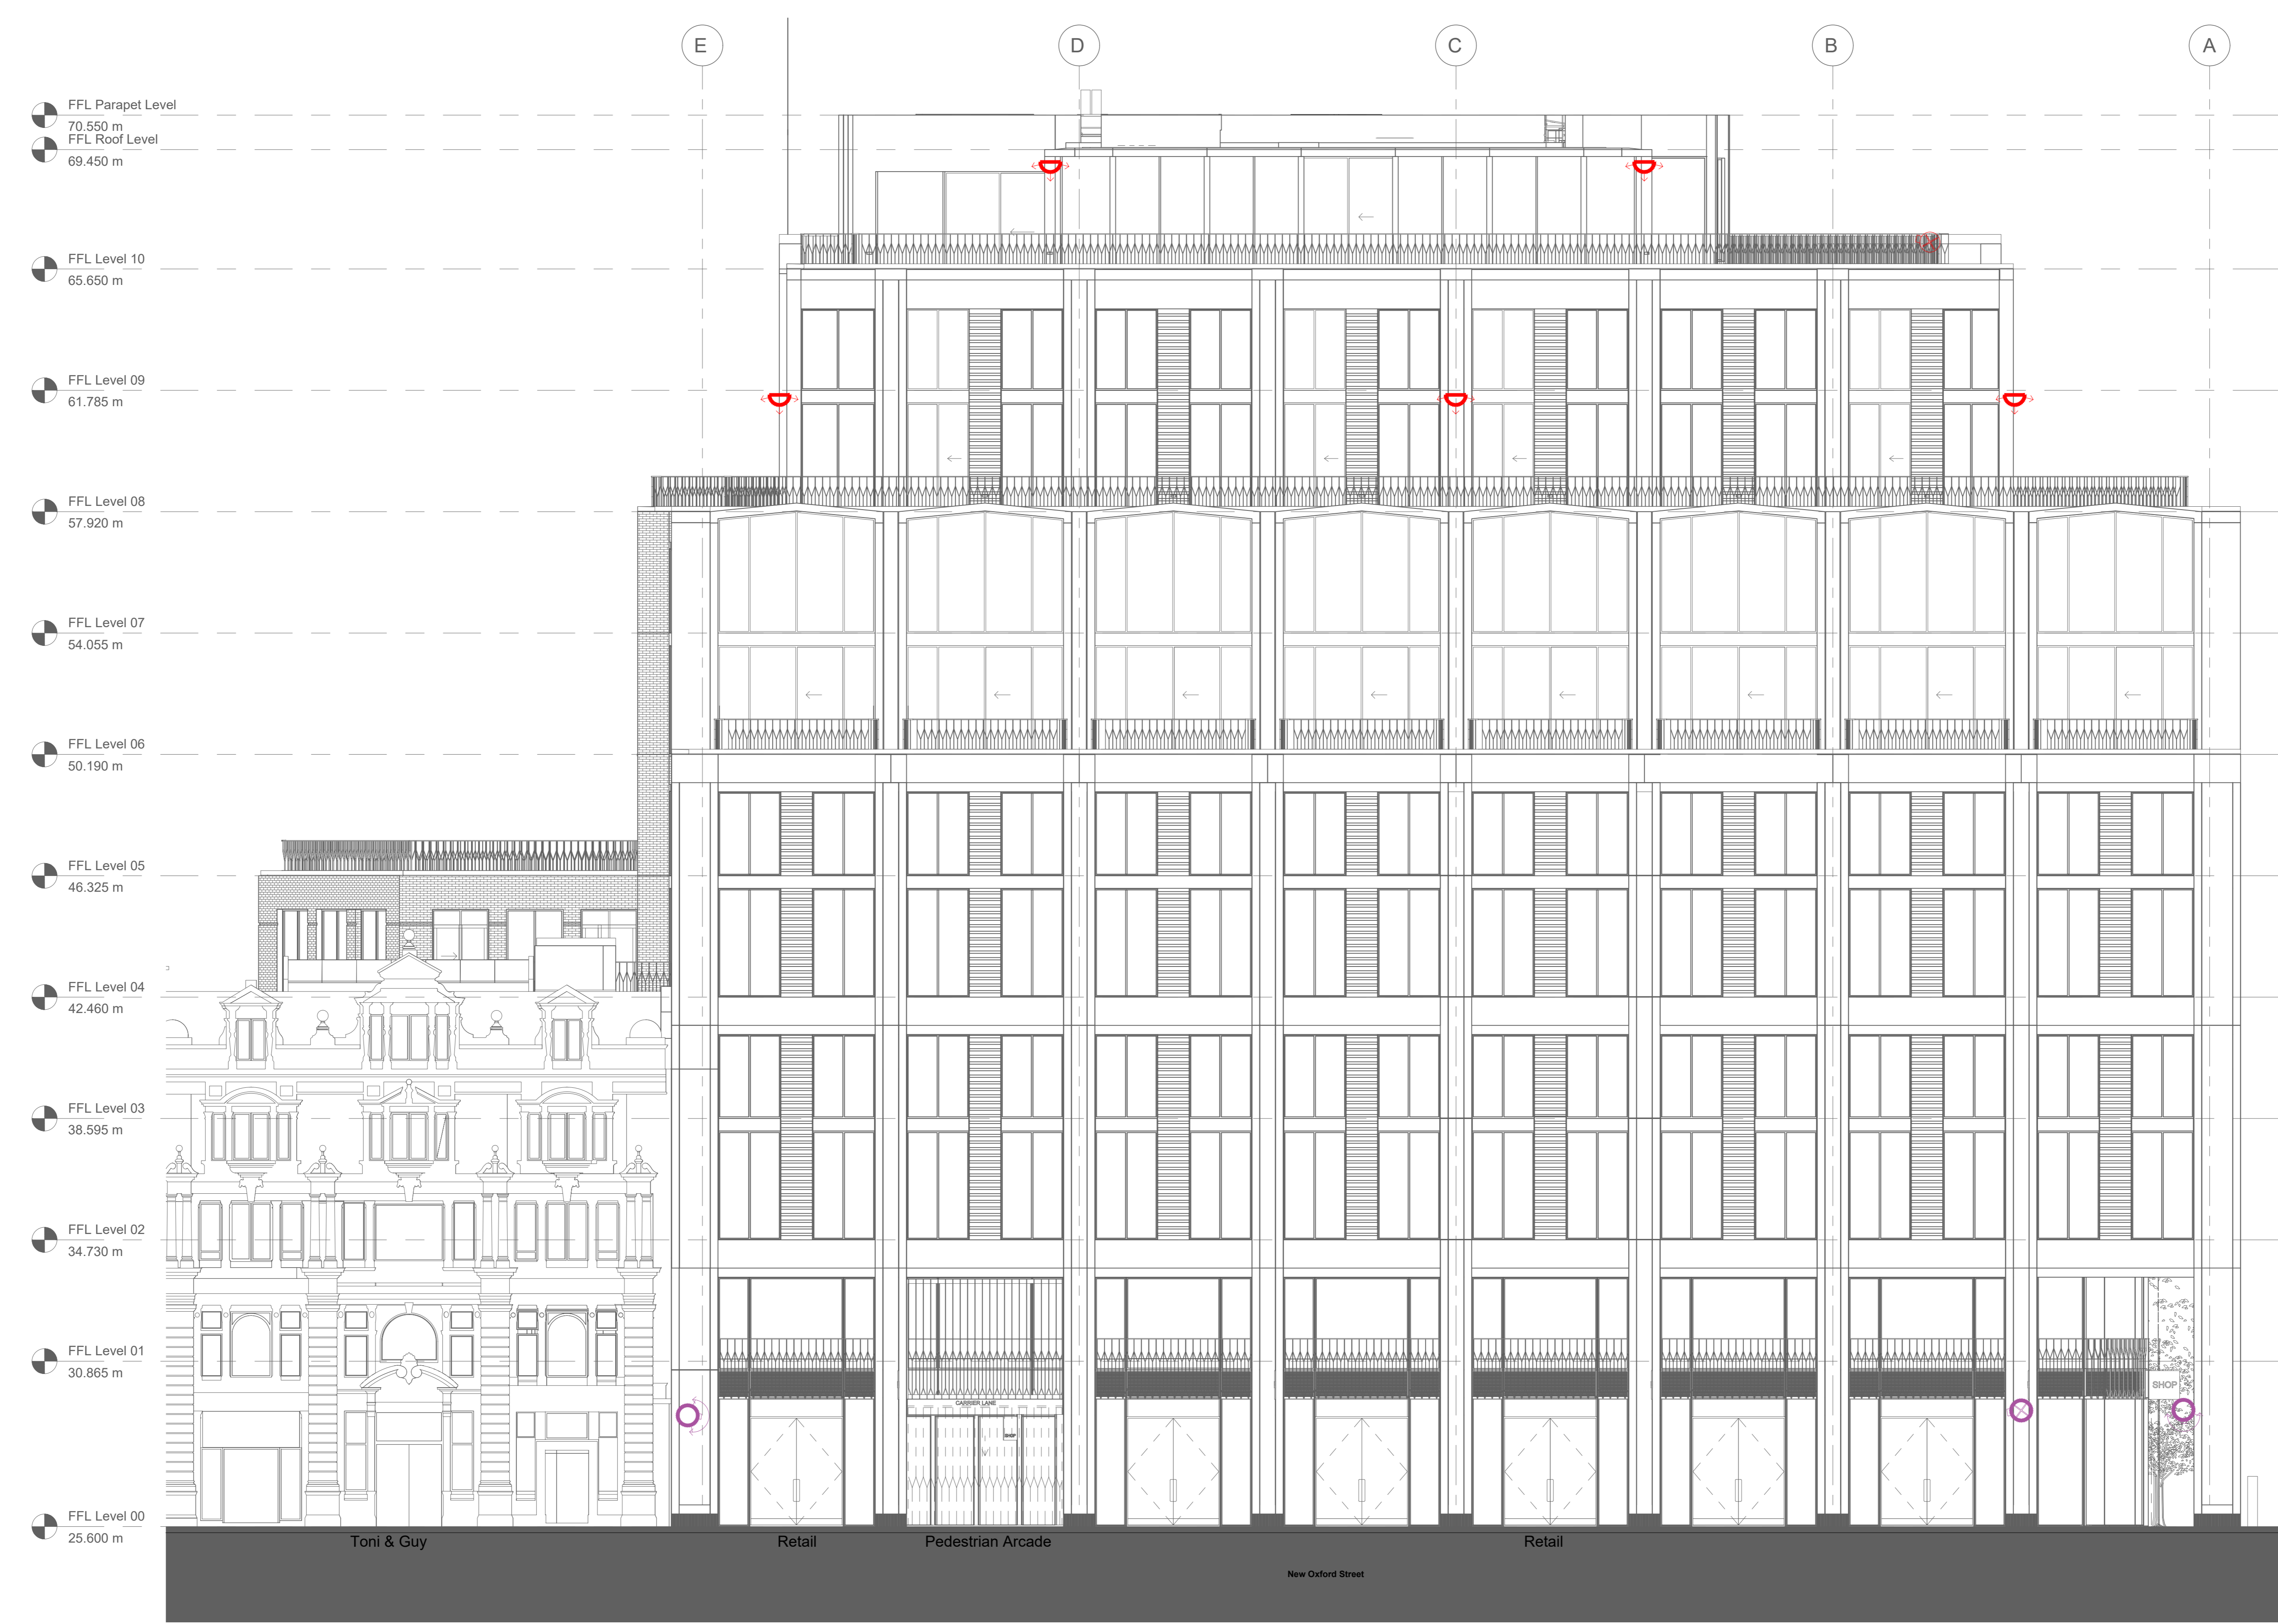

REV	DATE	DESCRIPTION	BY
T5	13.10.23	Tender - Antenna removed	PW
T4	22.06.23	Tender - Updated CCING	PW
T3	08.09.23	Tender - Updated CCTV information	PW
T2	03.08.23	TENDER ISSUE	JS
T1	21.07.23	TENDER ISSUE	JB
P1	21.04.23	Preliminary Issue	JB

CLIENT  
GSK

PROJECT TITLE  
London Office - GSK

DRAWING TITLE  
Planning - Proposed North Elevation

DATE  
21.04.23

SCALE  
1:100 @ A0

DRAWN  
JB

CHECKED  
LP