












GROUND FLOOR SECURITY KEY


 

 

RED ICONS - NEW DEVICES
(Full installations)



MAGENTA ICONS - REPLACE EXISTING
(Re-use existing cable)

-  NEW CAMERA 6.0C-H5A-DP1-IR
-  REPLACE EXISTING CAMERA WITH - 6.0C-H5A-DP1-IR
-  NEW CAMERA 6.0C-H5A-DC1-IR
-  REPLACE EXISTING CAMERA WITH - 6.0C-H5A-DC1-IR
-  NEW CAMERA - 2.0C-H5A-DC1-IR
-  REPLACE EXISTING CAMERA WITH - 2.0C-H5A-DC1-IR
-  NEW CAMERA - 20C-H4A-4MH-360
-  REPLACE EXISTING CAMERA WITH - 8.0C-H5A-FE-D01-IR
-  NEW CAMERA - 15C-H5A-3MH
-  NEW CAMERA - 2.0C-H5A-IRPTZ-DP40-WP
-  REPLACE EXISTING CAMERA WITH - 2.0C-H5A-IRPTZ-DP40-WP

3,4,5,8 & 10th FLOOR SECURITY KEY

RED ICONS - NEW DEVICES
(Full installations)

-  NEW CAMERA IME 539-1ERS
-  NEW CAMERA IME 539-1IRS
-  NEW CAMERA IME 238-1IRS
-  NEW CAMERA IMF 82-1ERS
-  NEW CAMERA IMD 15118

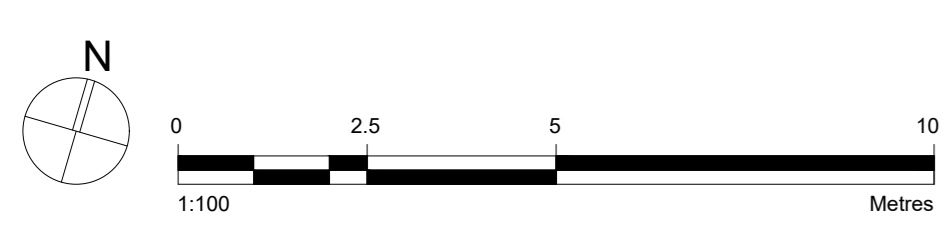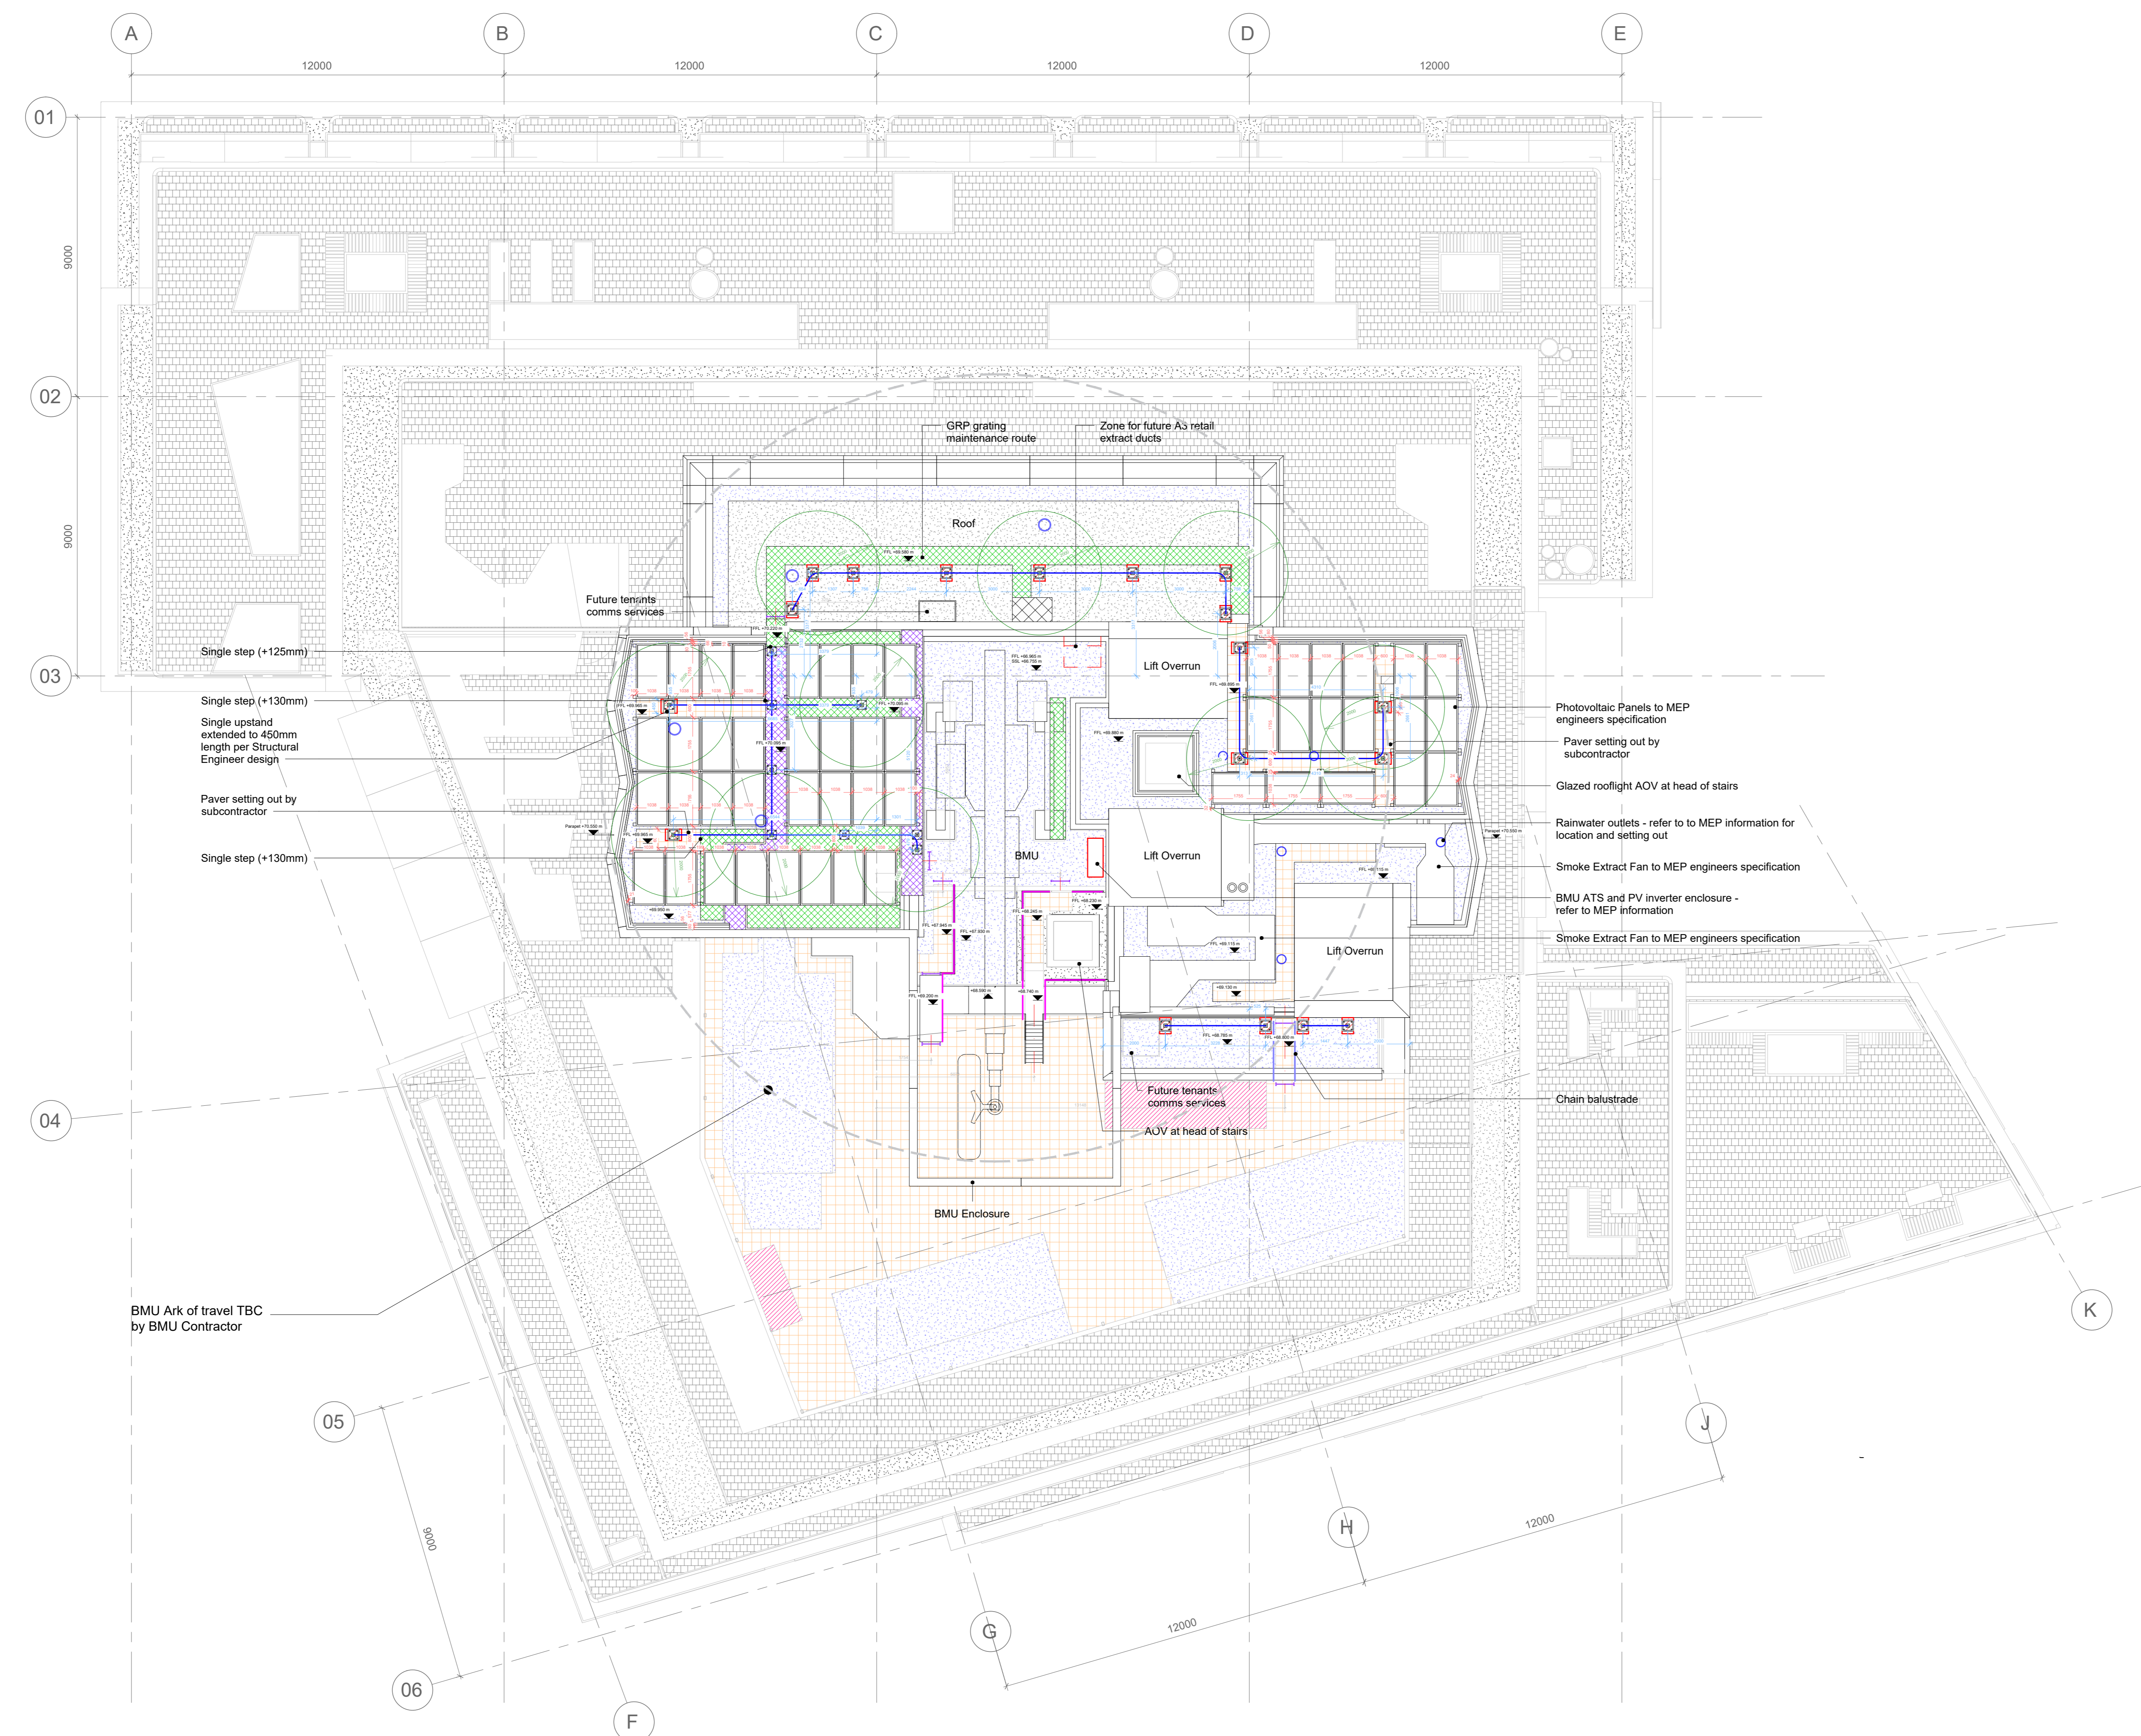

T2	13.10.23	Tender - Antenna removed	PW
T1	22.09.23	Tender - Updated ICONS	PW
REV	DATE	DESCRIPTION	BY

CLIENT
GSK

PROJECT TITLE
London Office - GSK

DRAWING TITLE
Planning - As Built Roof Plan
Antenna location

DATE
21.04.23

SCALE
1:100 @ A0

DRAWN
JB

CHECKED
LP

PENSON

TELEPHONE: +44 - 207 403 8047
WEBSITE: www.penson.co

PROJECT NO: 3314
DRAWING NO: I-X17
REVISION: T2

Copyright Penon Group 2022