 



SCALE:
1:50 @A1
1:100 @A3




LEGEND

■ ■ ■ = PROPOSED DUCTING WITHIN CEILING

⊗ = EXTRACTOR FAN

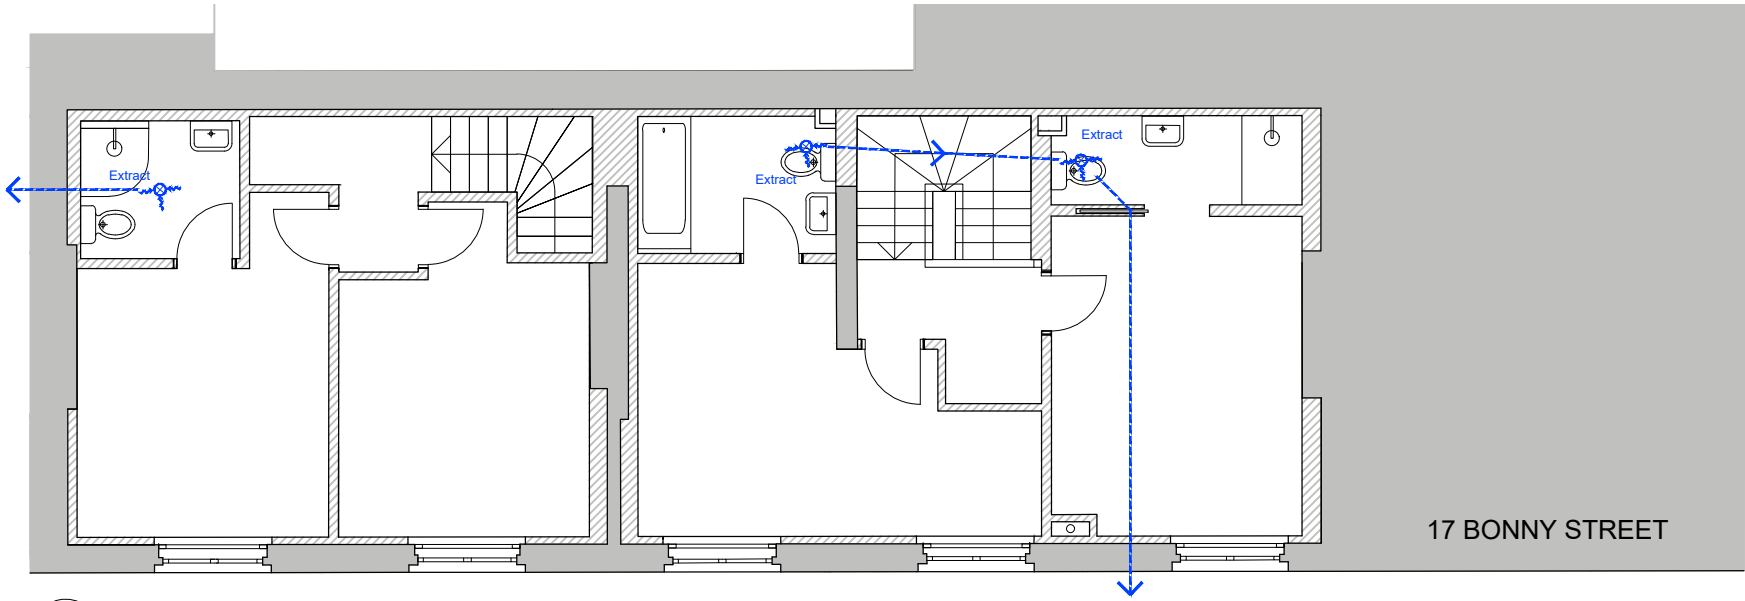

1 FIRST FLOOR MECHANICAL LAYOUT
SCALE 1:50 @A1, 1:100 @ A3

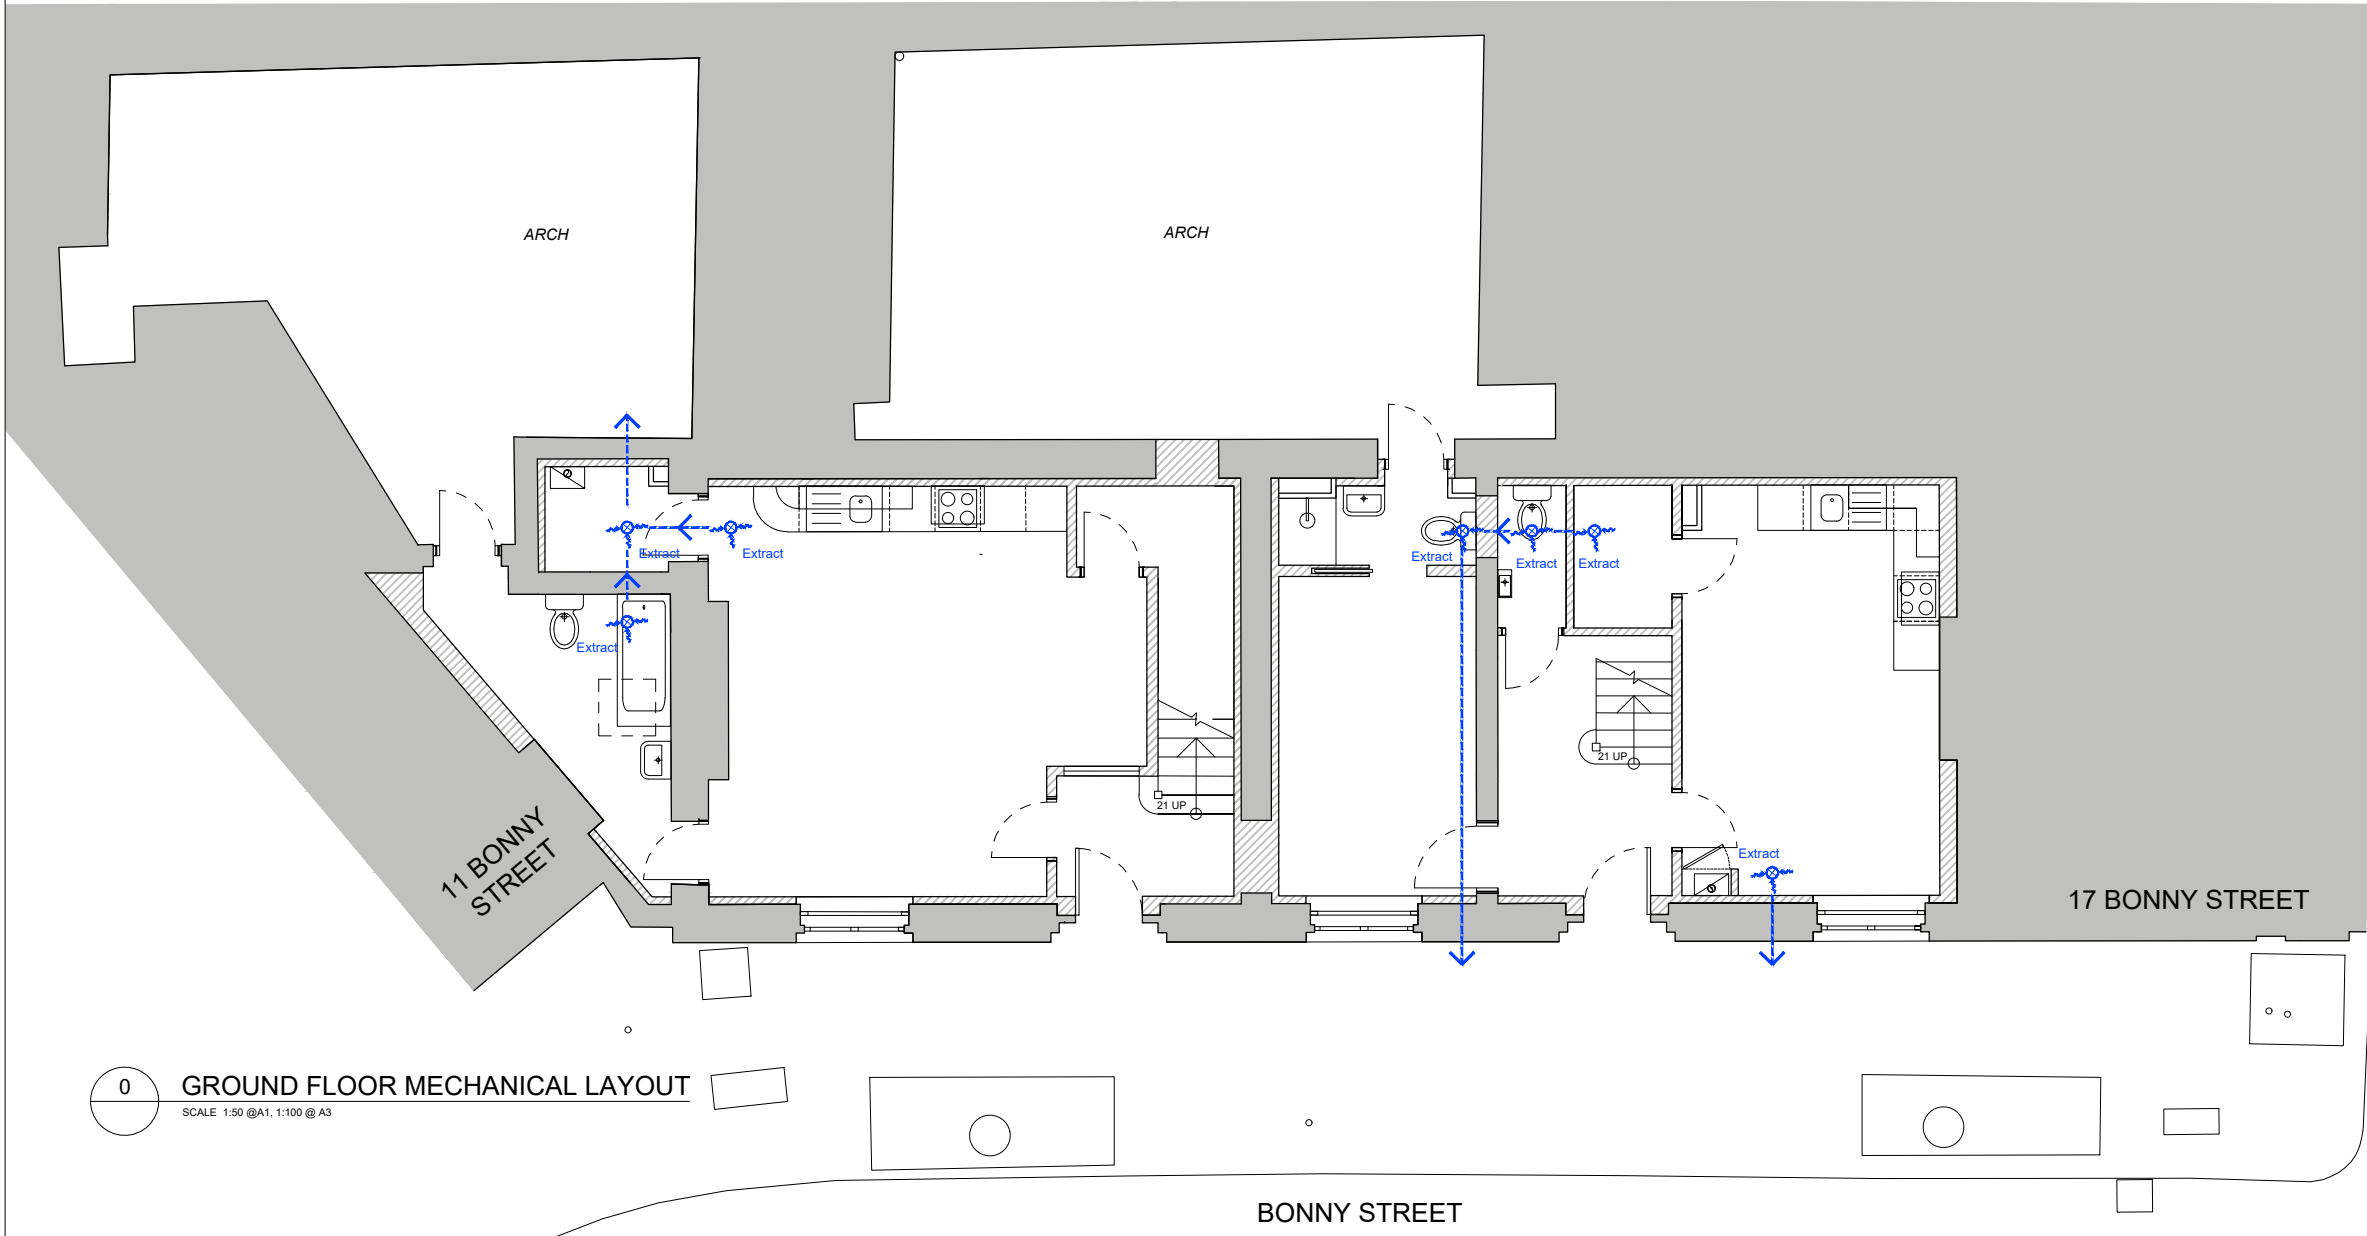

0 GROUND FLOOR MECHANICAL LAYOUT
SCALE 1:50 @A1, 1:100 @ A3

PLEASE NOTE:

FOR CONSTRUCTION PURPOSES USE FIGURED DIMENSIONS ONLY. THIS DRAWING IS TO BE READ IN CONJUNCTION WITH ALL RELEVANT PROJECT INFORMATION. ALL DIMENSIONS MUST BE CHECKED ON SITE PRIOR TO THE COMMENCEMENT OF WORKS. PLEASE REPORT ANY DISCREPANCY TO THE ARCHITECT OR CONTRACT ADMINISTRATOR.

P1	03/10/2023	First Issued	AM
Rev:	Date:	Revision note:	By:

prime BUILDING CONSULTANTS LTD

Maidstone Innovation Centre,
Suite 44,45 & 46,
Gidds Pond Way,
Maidstone, Kent, ME14 5FY

T 01622 692249
E pbc@primebc.co.uk
W www.primegrouppltd.co.uk

SURVEYORS ARCHITECTS PLANNERS

Project:			
13 & 15 BONNY STREET, NW1 9PE			
Client:			
THE ARCH COMPANY			
Title:			
PROPOSED MECHANICAL LAYOUT			
Purpose of issue:			
PLANNING / LBC			
Drawing number:		Revision:	
014.2429-012		P1	
Scale:	Paper Size:	Date:	Drawn By:
1:100	A3	09/2023	AM
Copyright © Prime Building Consultants Limited. Do not reproduce without written permission.			