



1 URBAN FARM ENTRANCE SIGNAGE - 3D View

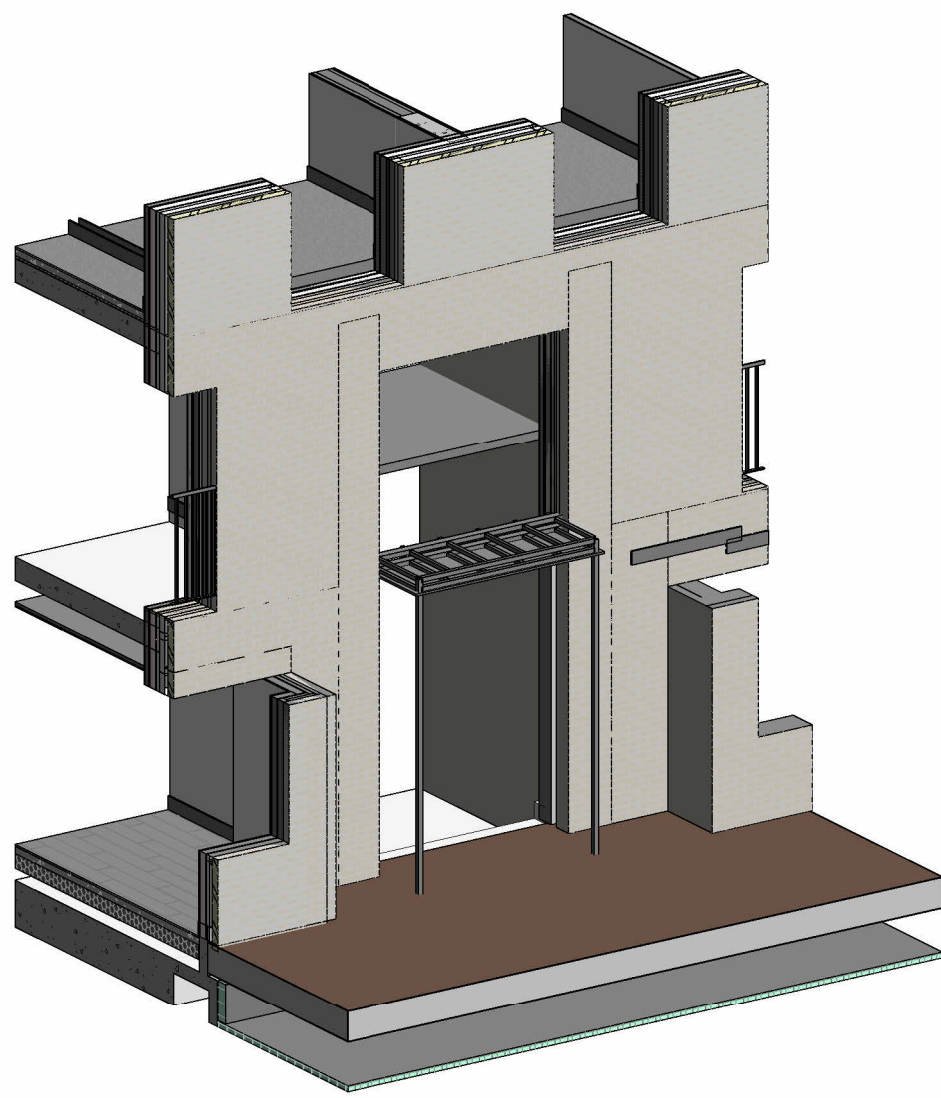

2 URBAN FARM ENTRANCE SIGNAGE - 3D View - Metalwork Arrangement

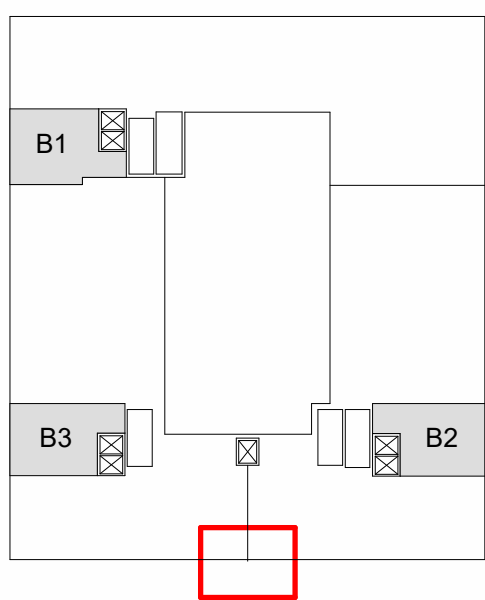



©Design Delivery Unit Limited
This drawing is to be read in conjunction with all relevant architect's and other designers' drawings and associated specifications. Figured dimensions only are to be taken from this drawing. All dimensions are to be checked on site before any work is put in hand.

mm 100 200 300 400 500
SCALE BAR: 1:5


DRAWING SERIES

Series 00 - Accommodation Schedules
Series 00 - NBS Specification
Series 02 - Conveyance Plans
Series 03 - GA Plans, GA Setting out Plans & Marketing Plans
Series 04 - GA Sections
Series 05 - GA Elevations
Series 06 - Stage 2 Drawings
Series 07 - Bay Studies
Series 09 - 3D Views
Series 16 - Substructure
Series 20 - Superstructure
Series 21 - External Wall Types & Details
Series 22 - Internal Wall Types & Details
Series 23 - Floor Types & Details
Series 24 - Staircases & Lifts
Series 27 - Roof Types & Details
Series 31 - Window & Doors Types, Details & Schedules
Series 35 - Reflected Ceiling Plans
Series 36 - Balconies & External Metalwork
Series 40 - Internal Finishes
Series 43 - Floor Finishes
Series 60 - Electrical Plans
Series 67 - Fire Strategy Plans
Series 70 - Flat Type Layouts
Series 71 - Signage Plans
Series 73 - Kitchen Layouts & Schedules
Series 74 - Bathroom Layouts & Schedules
Series 79 - Residents Facilities
Series 82 - Commercial Units
Series 83 - Offices

Refer to:
03 Series Cladding plans for scoping extent,
35 Series SW soffit plans (insulation & metalwork),
36 Series for metalwork details &
DDU / TFS NBS specification for metalwork elements

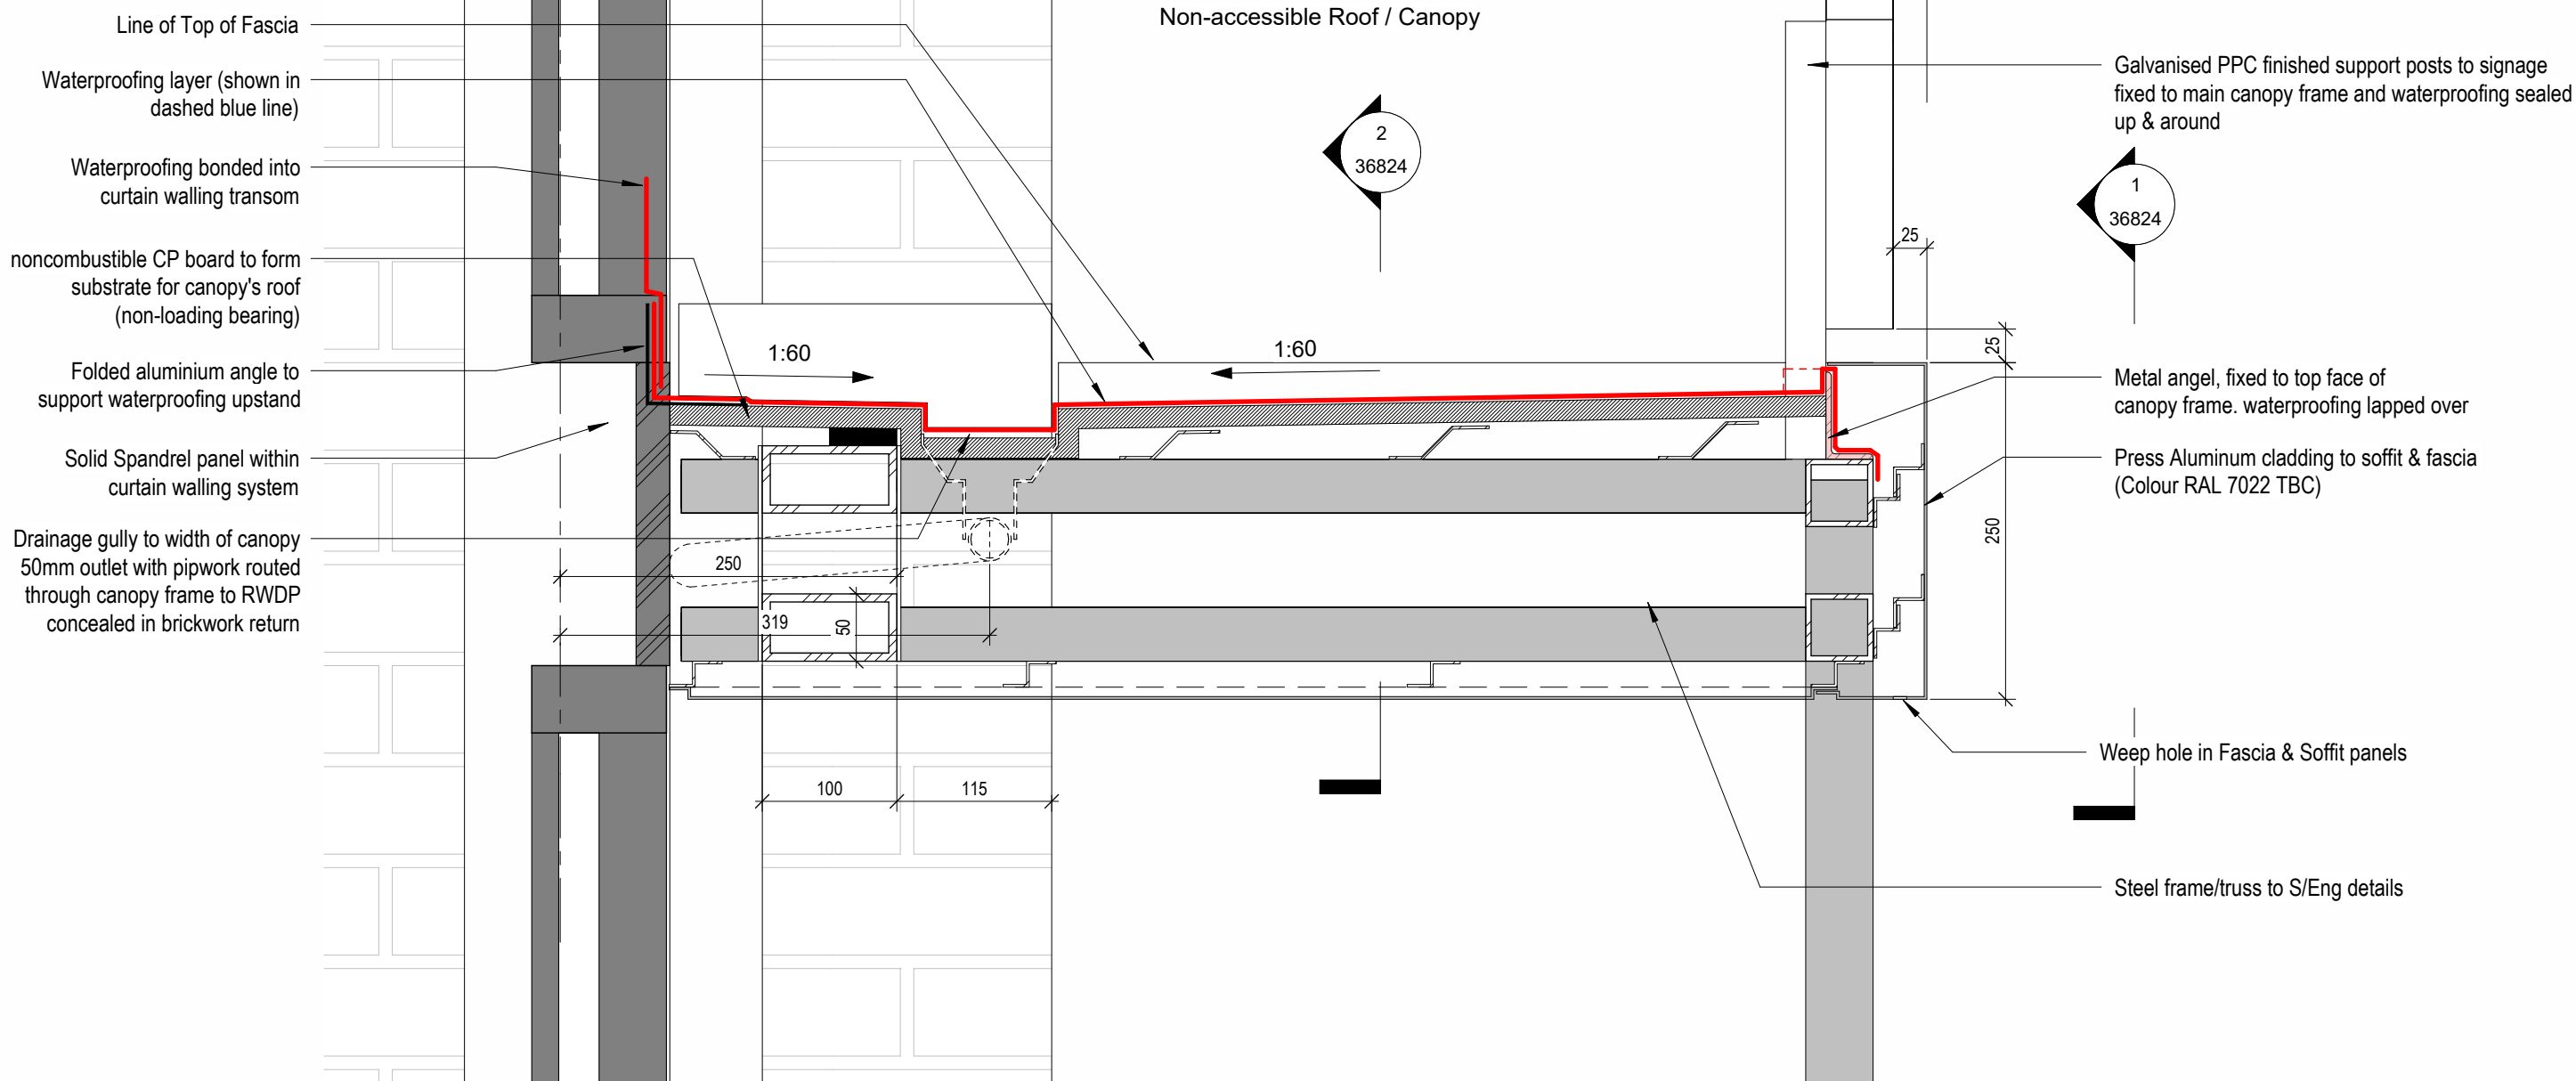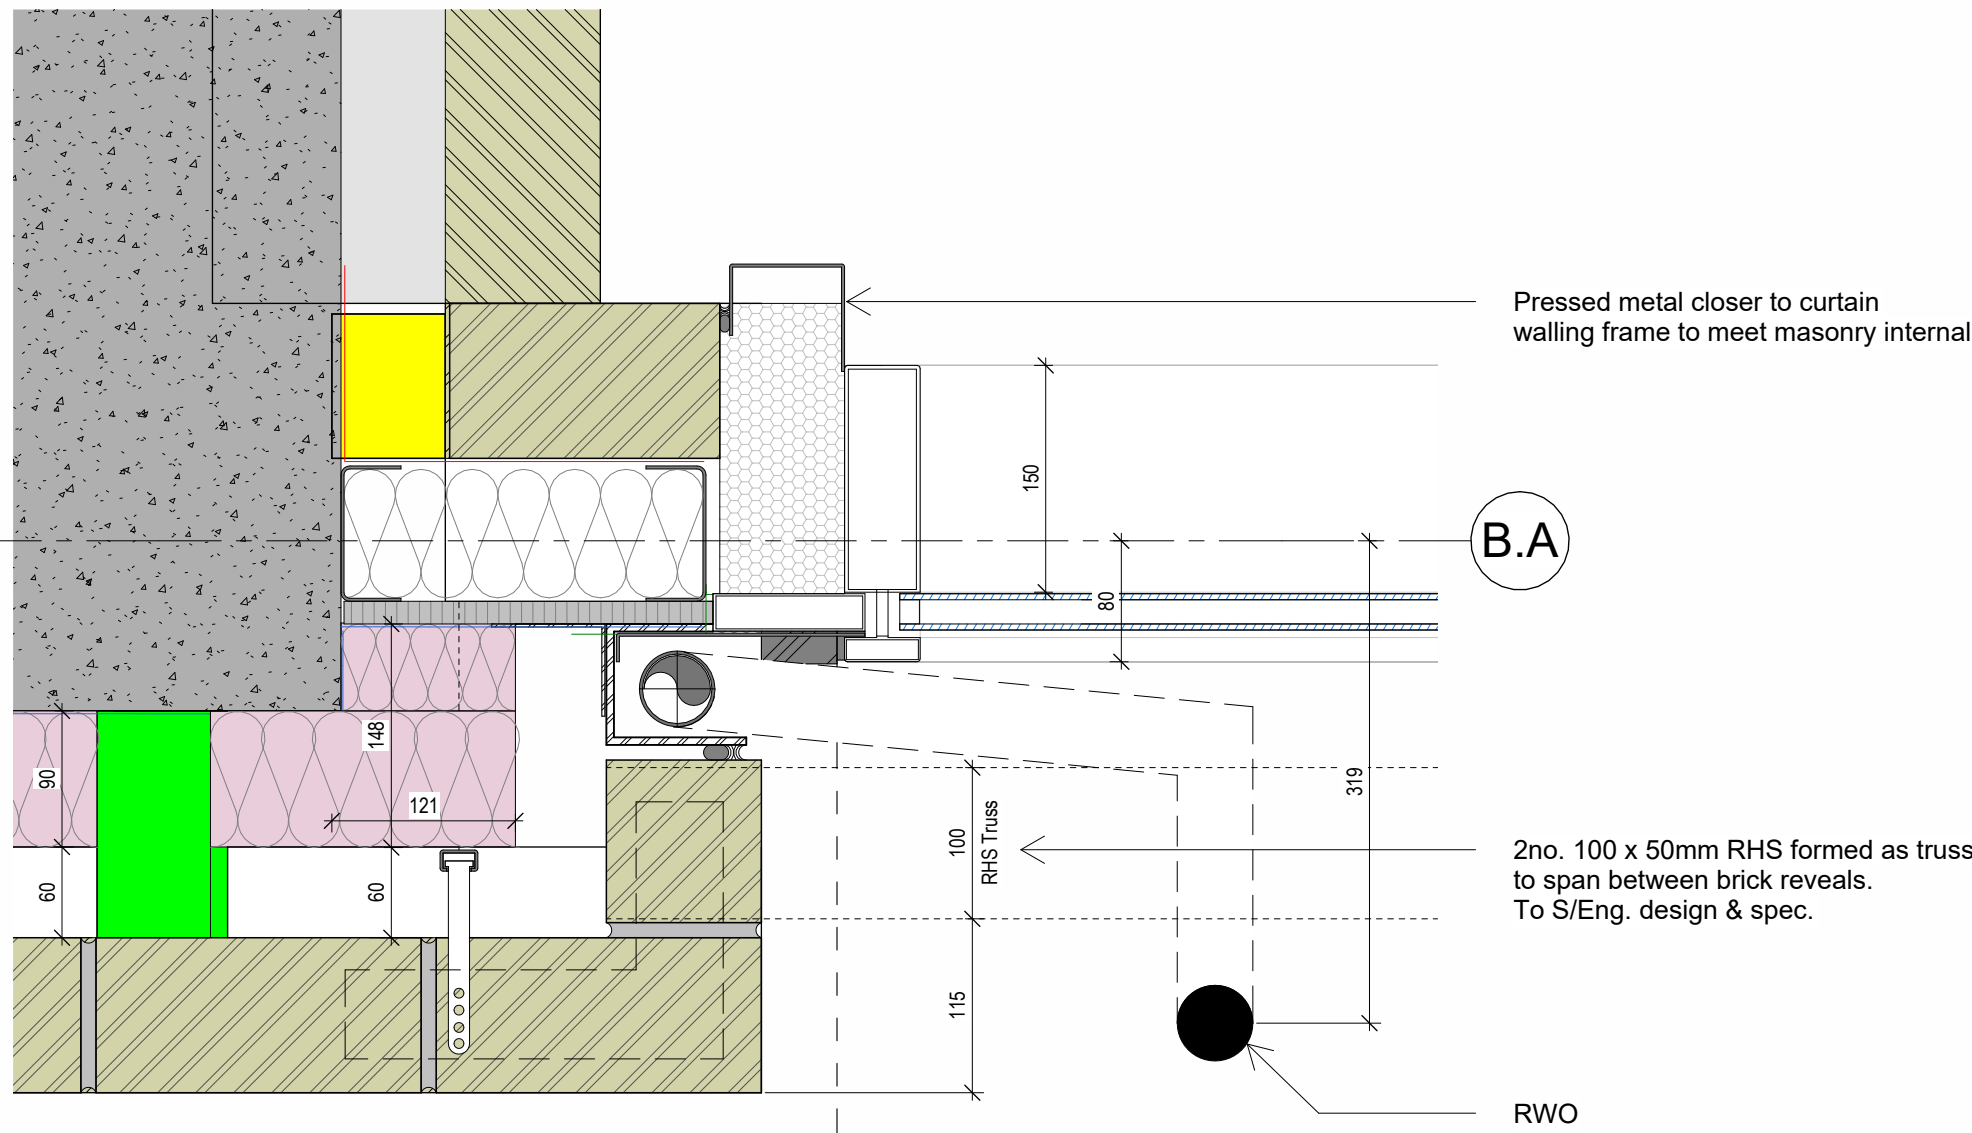

4 URBAN FARM ENTRANCE - Canopy Drainage- Cross Section
1:5

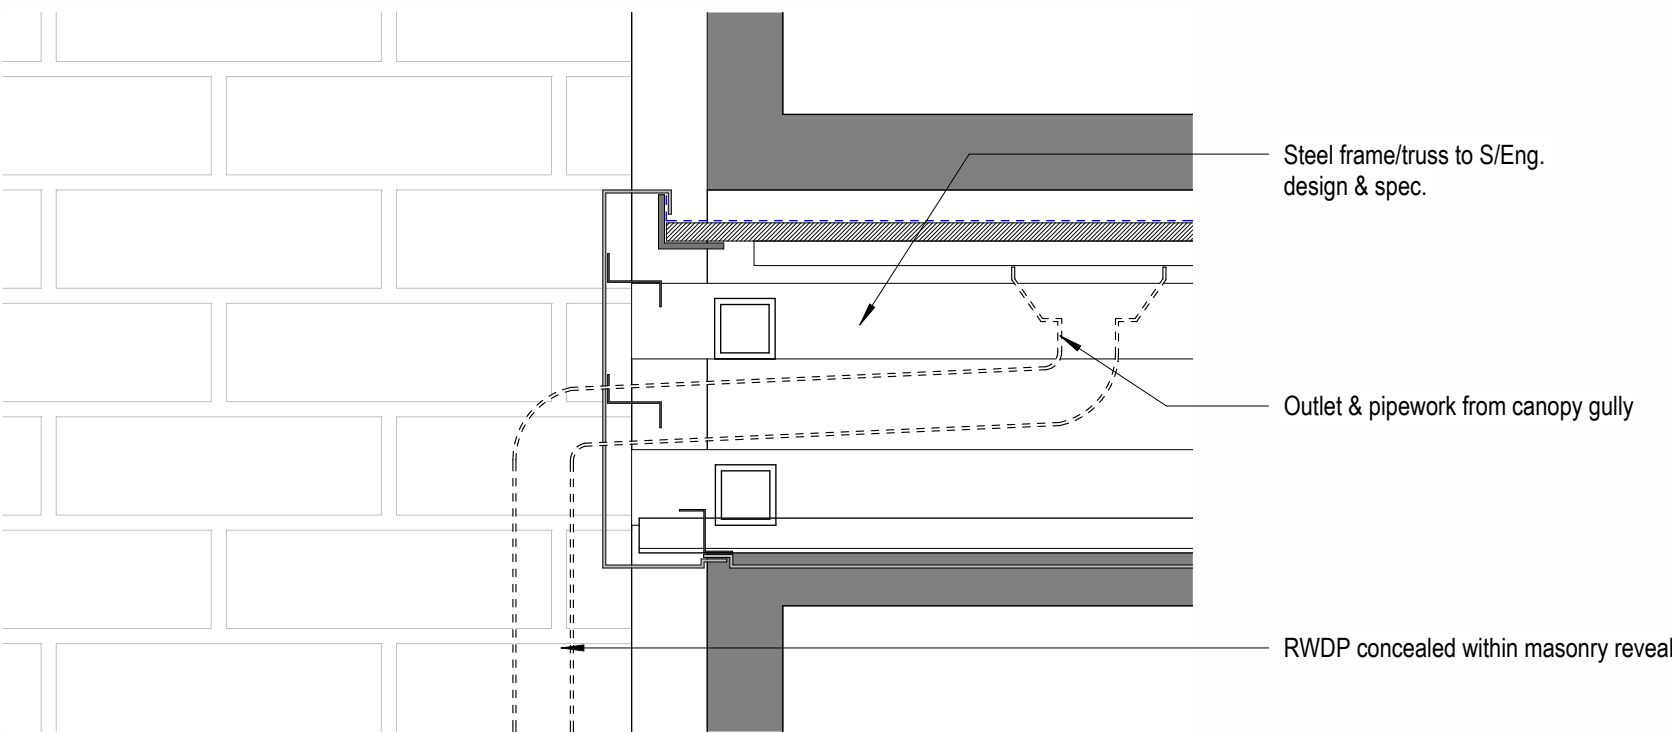

5 URBAN FARM ENTRANCE - Canopy Drainage - Edge section Copy
1:5

C02	Updated Metalwork Issue	05.09.23	CS	JR
C01	Construction Issue	30.06.23	CS	ACS
Revision	Description	Date	Drawn	Checked

design
delivery
unit

77 Endell Street
London WC2H 9DZ
T +44 (0)20 7240 7766
W designdeliveryunit.com

Client's Name
St George North London Limited



Job Title
Camden Goods Yard

Drawing Title
Building B Metalwork Urban Farm
Entrance Signage Details

Scale
As indicated @A1

Practice Project No.
20226

Client Project Code	Originator	Volume	Level	Type	Role	Number
CGYB0-DDU-B0-ZZ-DR-A-36840						
Description						
CONSTRUCTION						