

SCALE BAR: 1:20

DRAWING SERIES

Series 00 - Accommodation Schedules  
Series 00 - NBS Specification  
Series 02 - Conveyance Plans  
Series 03 - GA Plans, GA Setting out Plans & Marketing Plans  
Series 04 - GA Sections  
Series 05 - GA Elevations  
Series 06 - Stage 2 Drawings  
Series 07 - Bay Studies  
Series 09 - 3D Views  
Series 16 - Substructure  
Series 20 - Superstructure  
Series 21 - External Wall Types & Details  
Series 22 - Internal Wall Types & Details  
Series 23 - Floor Types & Details  
Series 24 - Staircases & Lifts  
Series 27 - Roof Types & Details  
Series 31 - Window & Doors Types, Details & Schedules  
Series 35 - Reflected Ceiling Plans  
Series 36 - Balconies & External Metalwork  
Series 40 - Internal Finishes  
Series 43 - Floor Finishes  
Series 60 - Electrical Plans  
Series 67 - Fire Strategy Plans  
Series 70 - Flat Type Layouts  
Series 71 - Signage Plans  
Series 73 - Kitchen Layouts & Schedules  
Series 74 - Bathroom Layouts & Schedules  
Series 79 - Residents Facilities  
Series 82 - Commercial Units  
Series 83 - Offices

Refer to;  
03 Series Cladding plans for scoping extent,  
35 Series SW soffit plans (insulation & metalwork),  
36 Series for metalwork details &  
DDU / TFS NBS specification for metalwork elements

C02	Updated Metalwork Issue	05.09.23	CS	JR
C01	Updated Metalwork Package	30.06.23	CS	ACS
Revision	Description	Date	Drawn	Checked

design  
delivery  
unit

77 Endell Street  
London WC2H 9DZ  
T + 44 (0)20 7240 7766  
W designdeliveryunit.com

Client's Name

St George North London Limited



Job Title

Camden Goods Yard


Drawing Title

Building B Metalwork Gates / Partition


Scale As indicated @A1 Practice Project No. 20226

Client Project Code Originator Volume Level Type Role Number  
CGYB0-DDU-B0-ZZ-DR-A-36832


Description	Rev
CONSTRUCTION	C02

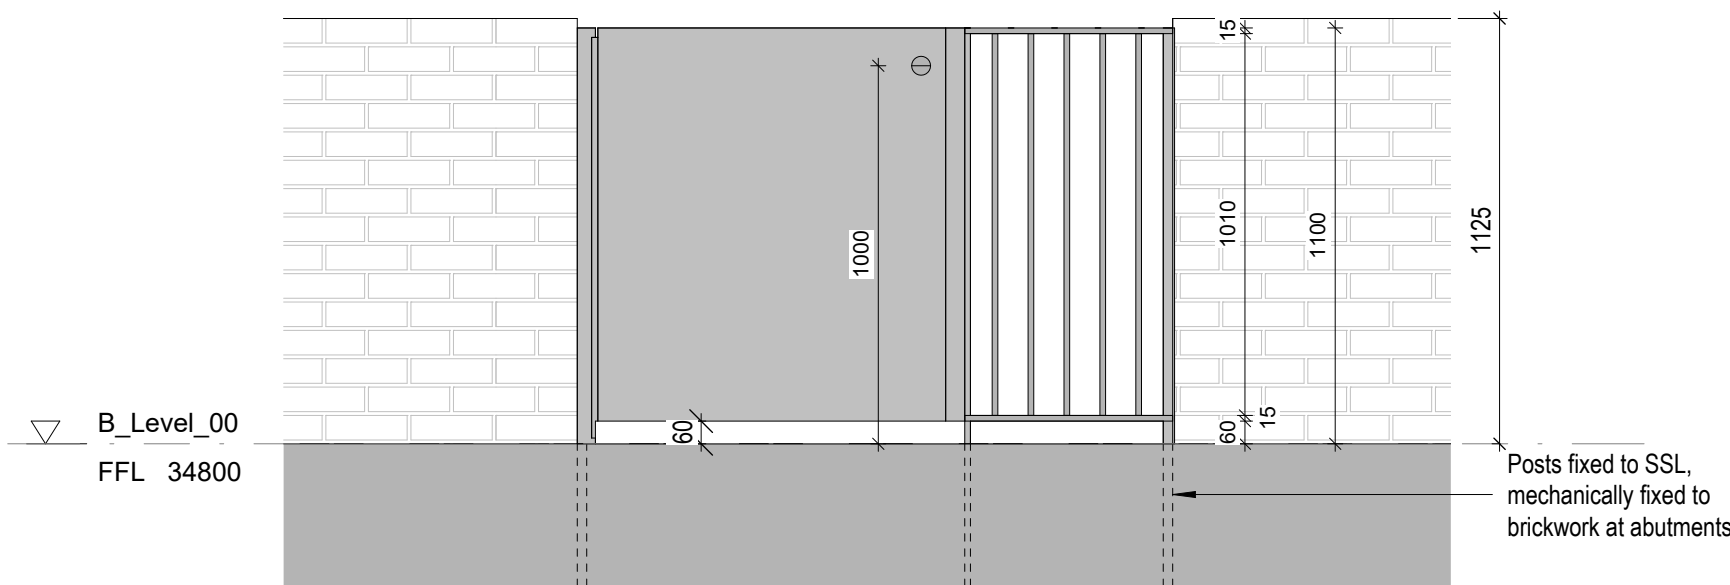


1 Metal Gate Elevation  
1: 20

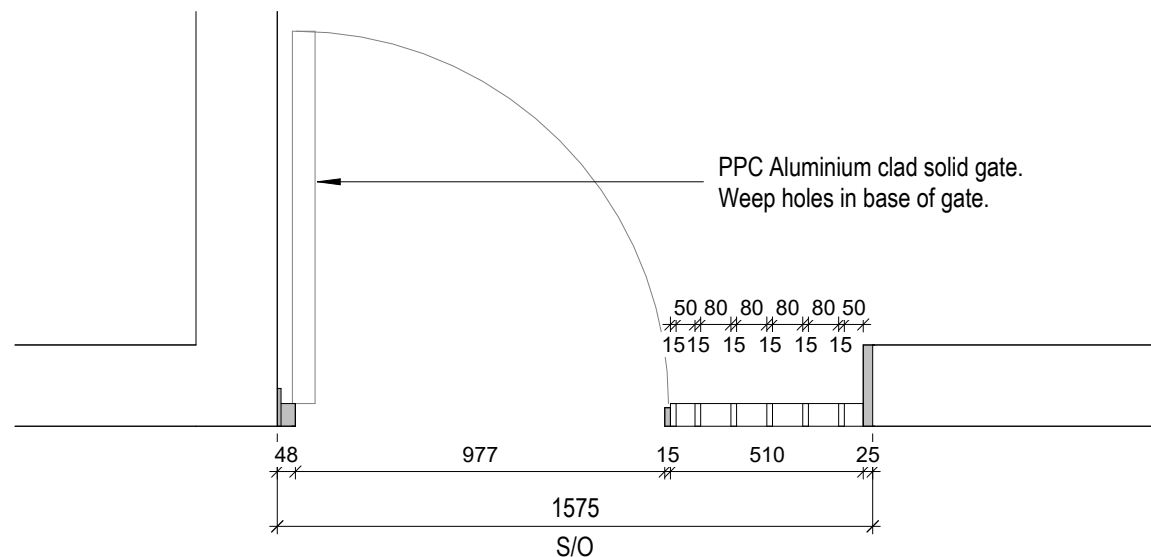


3 Metalwork Gates Plan  
1: 20

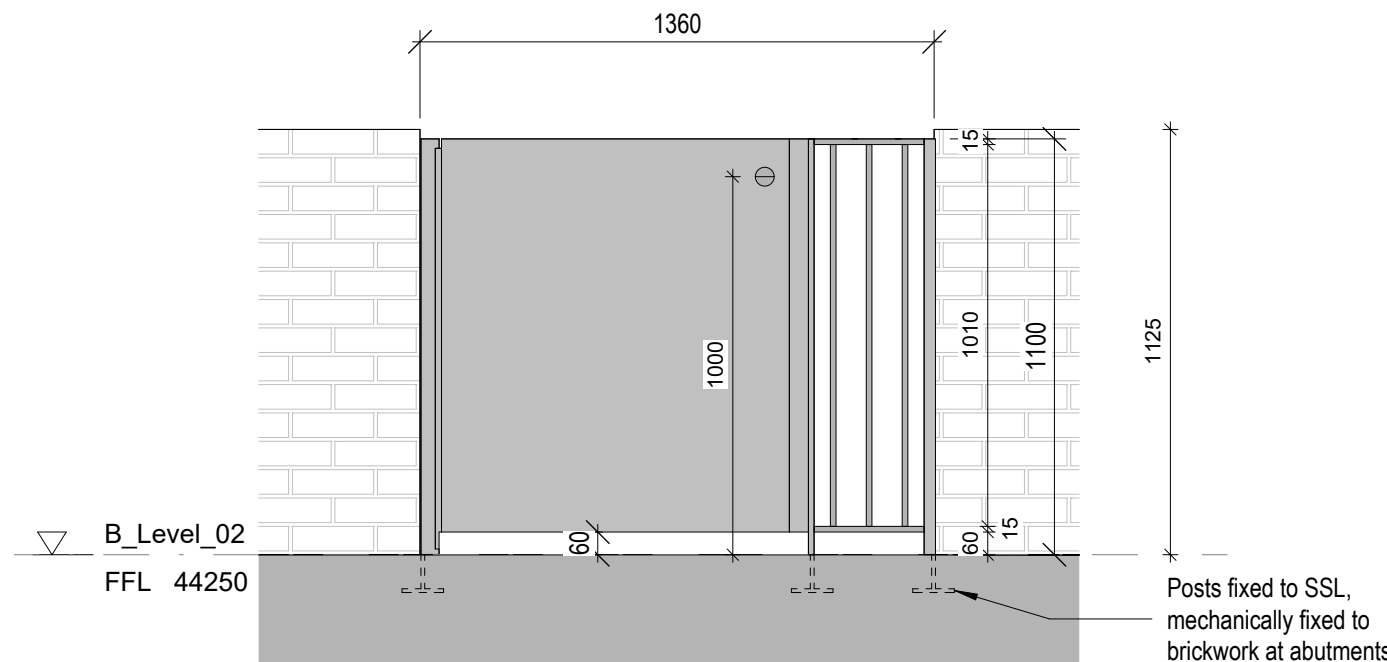


5 Metalwork Gate Lvl 02  
1: 20

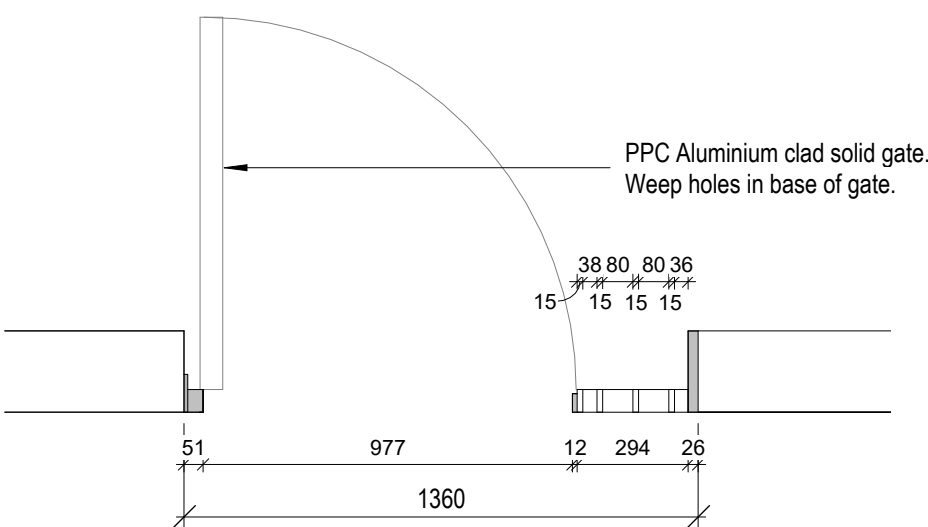

6 Metalwork Gate Plan Lvl 2  
1: 20

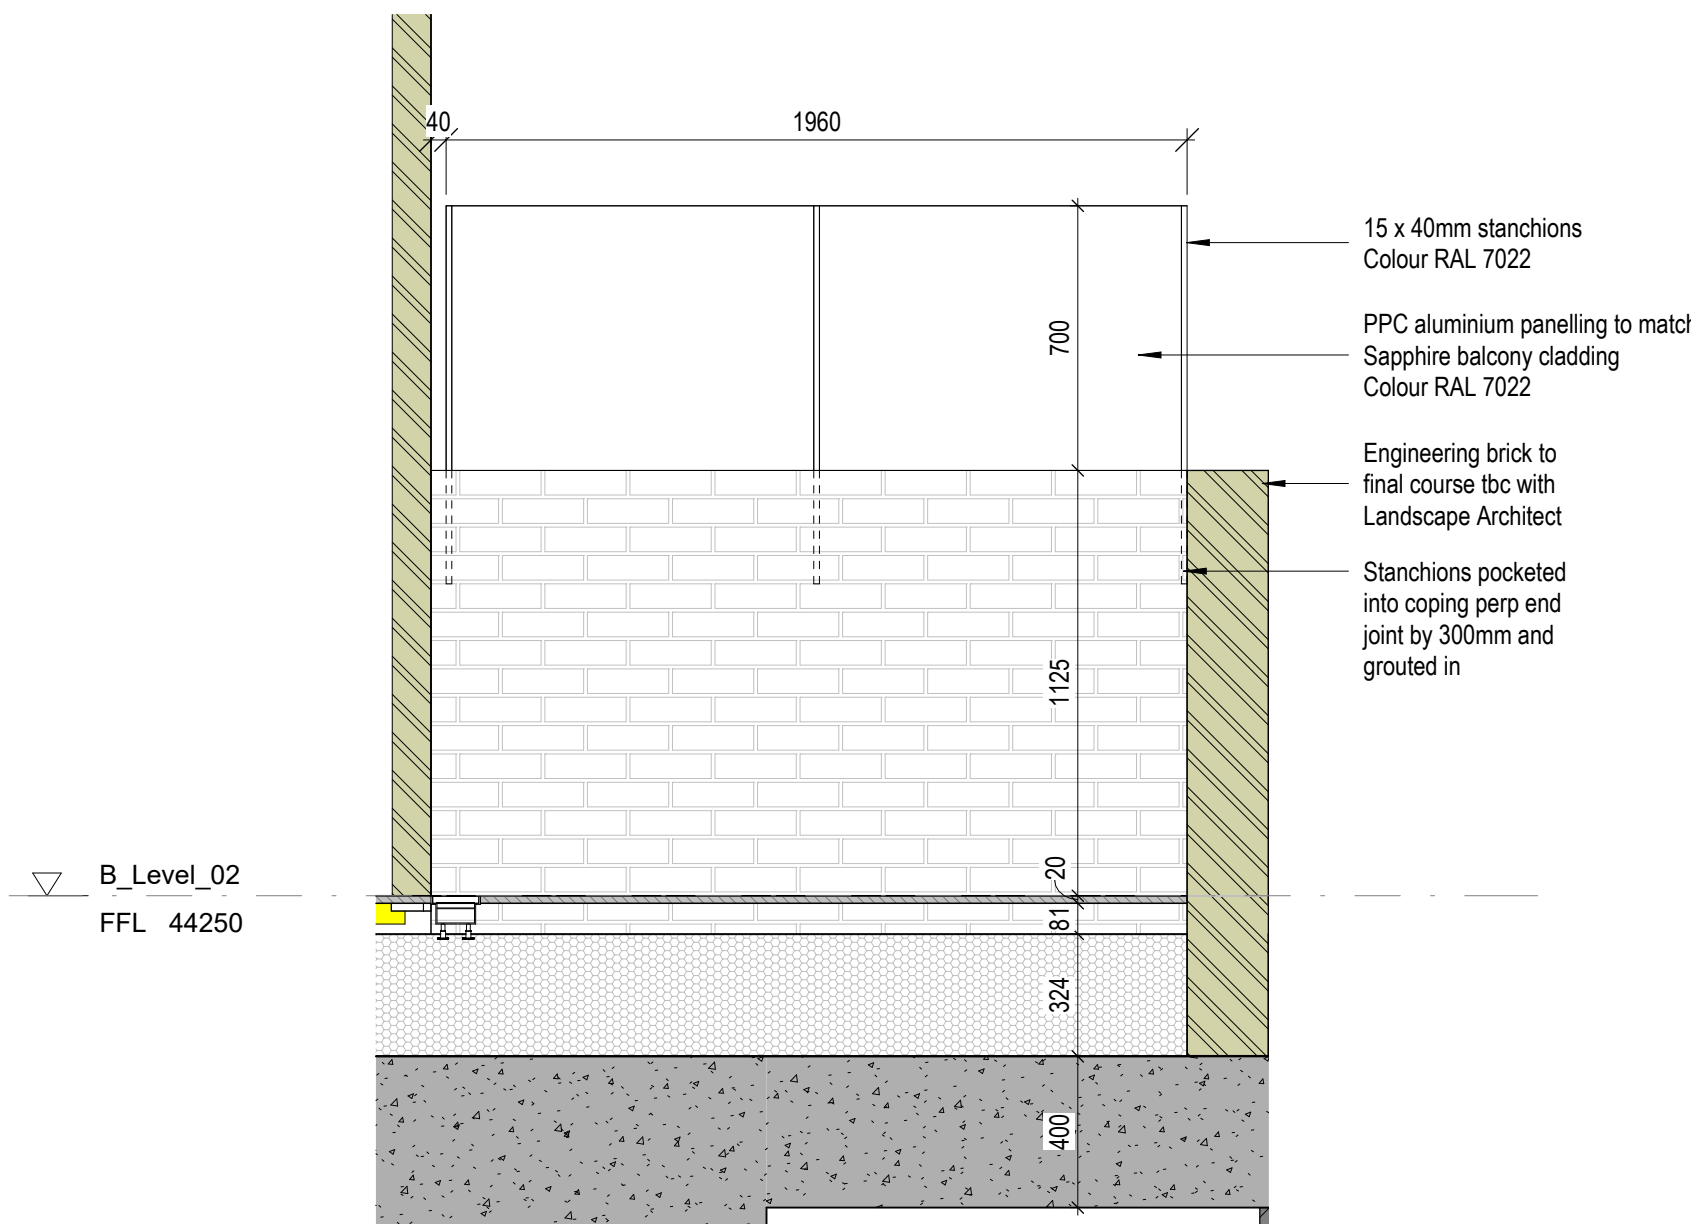

2 Metal Partition to Terraces  
1: 20

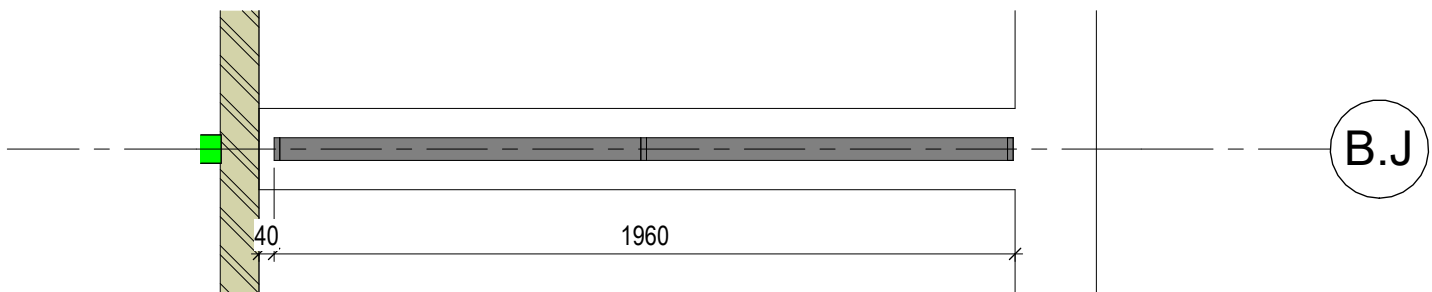

4 Metalwork Partition Plan  
1: 20