

- DRAWING SERIES**
- Series 00 - Accommodation Schedules
 - Series 00 - NBS Specification
 - Series 02 - Conveyance Plans
 - Series 03 - GA Plans, GA Setting out Plans & Marketing Plans
 - Series 04 - GA Sections
 - Series 05 - GA Elevations
 - Series 06 - Stage 2 Drawings
 - Series 07 - Bay Studies
 - Series 08 - 3D Views
 - Series 16 - Substructure
 - Series 20 - Superstructure
 - Series 21 - External Wall Types & Details
 - Series 22 - Internal Wall Types & Details
 - Series 24 - Staircases & Lifts
 - Series 27 - Roof Types & Details
 - Series 31 - Window & Doors Types, Details & Schedules
 - Series 35 - Reflected Ceiling Plans
 - Series 36 - Floor Types & Details
 - Series 36 - Balconies & External Metalwork
 - Series 40 - Internal Finishes
 - Series 43 - Floor Finishes
 - Series 60 - Electrical Plans
 - Series 67 - Fire Strategy Plans
 - Series 70 - Flat Type Layouts
 - Series 71 - Signage Plans
 - Series 73 - Kitchen Layouts & Schedules
 - Series 74 - Bathroom Layouts & Schedules
 - Series 79 - Residents Facilities
 - Series 82 - Commercial Units
 - Series 83 - Offices
 - Series 84 - Area Plans

GENERAL NOTES


STRUCTURAL - For design, detailing and setting out of structural elements refer to Structural Engineers drawings.

SERVICES - For design, detailing & setting out of services, including SVPS, Gas, Water, Electricals & Telecoms etc refer to M&E Engineers and Structural Engineers drawings.


All information on this drawing must be read in conjunction with relevant series and specifications.

Note: All steel sizes are indicative and subject to specialist design


Refer to:
03 Series Cladding plans for scoping extent,
35 Series SW soffit plans (insulation & metalwork),
36 Series for metalwork details &
DDU / ITS NBS specification for metalwork elements

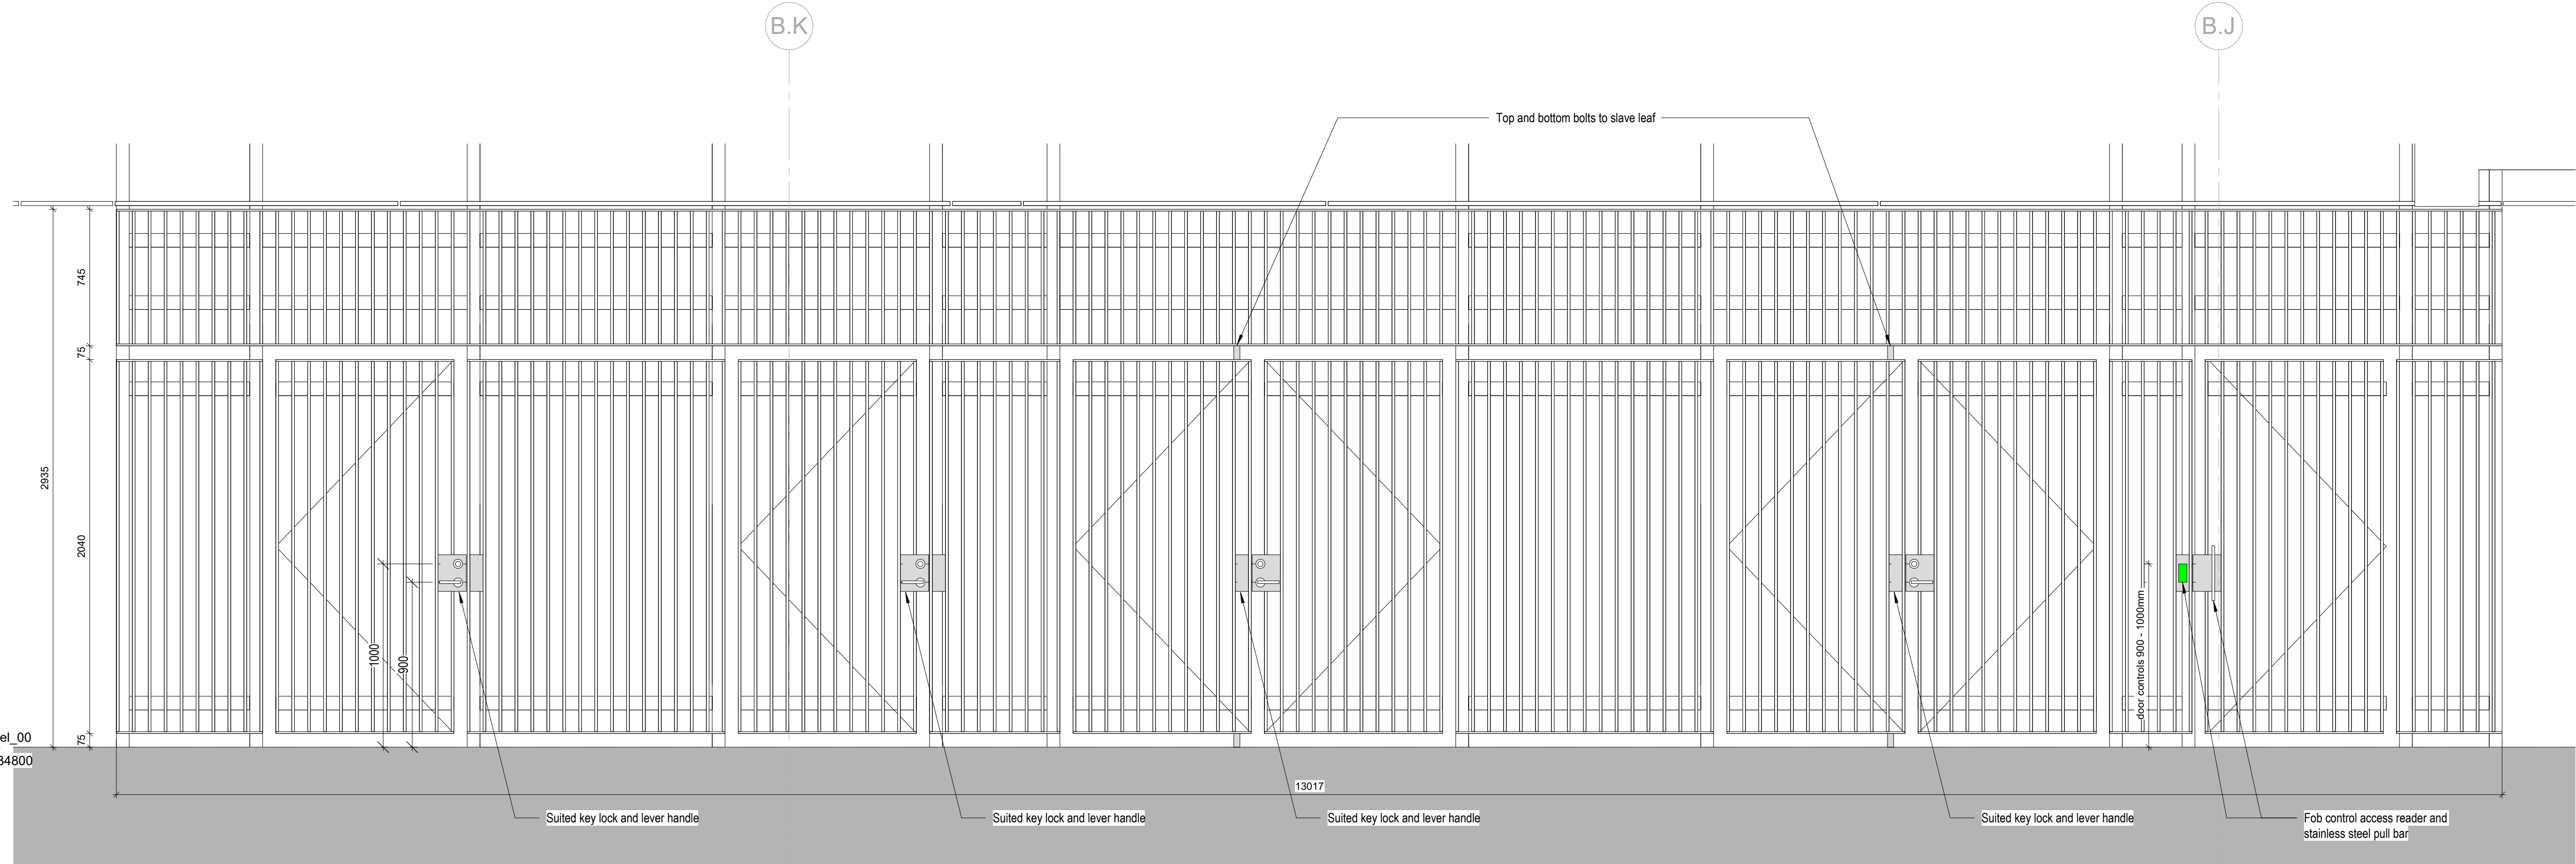

1 Cladding Bay Study 04
1:20

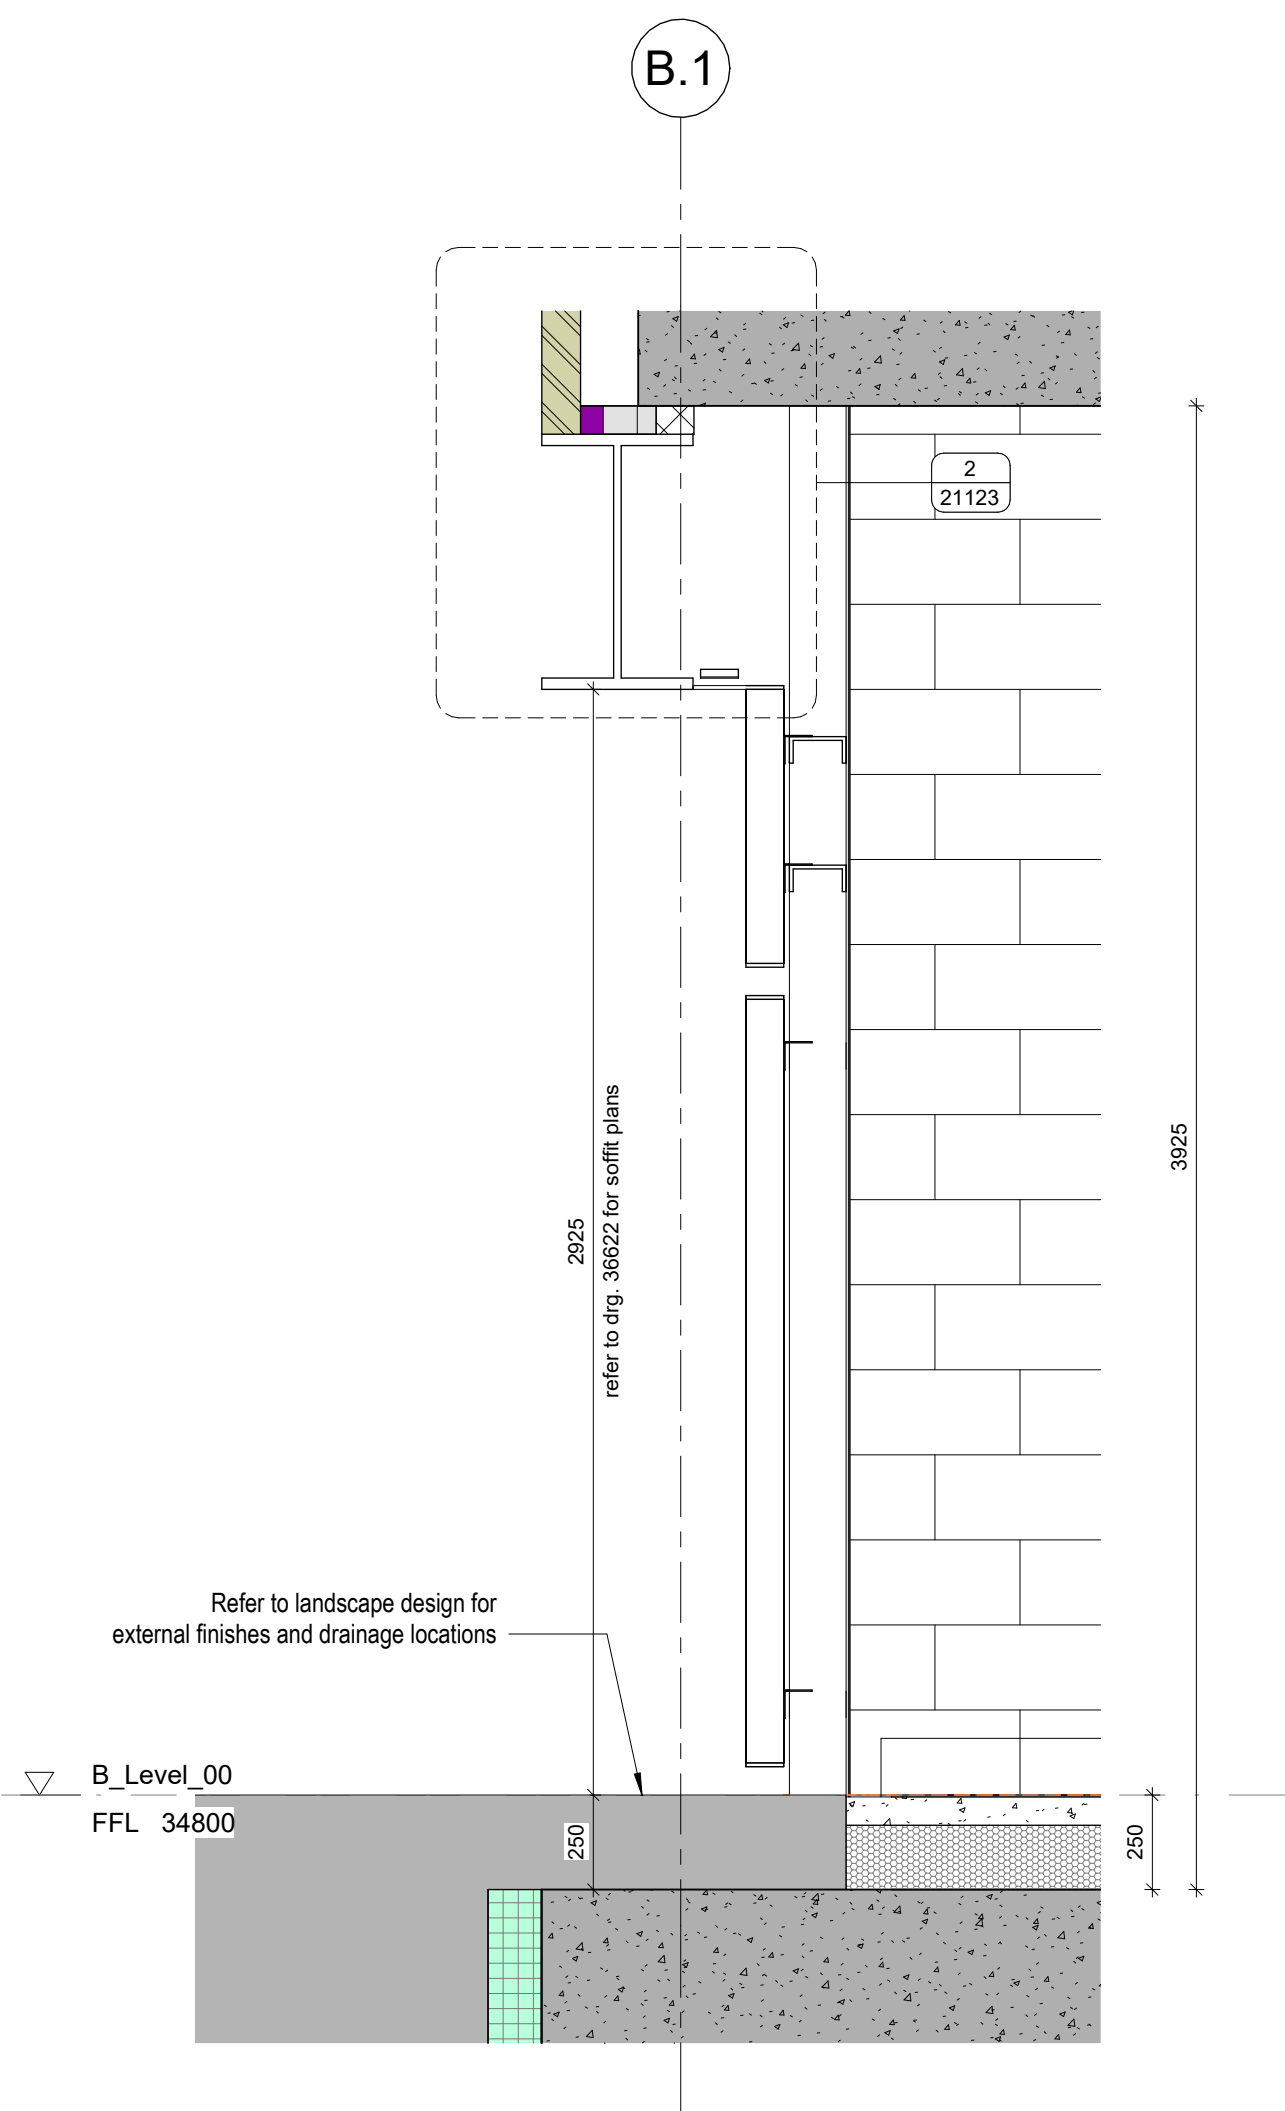

3 Cladding Bay Study 04 Section
1:20

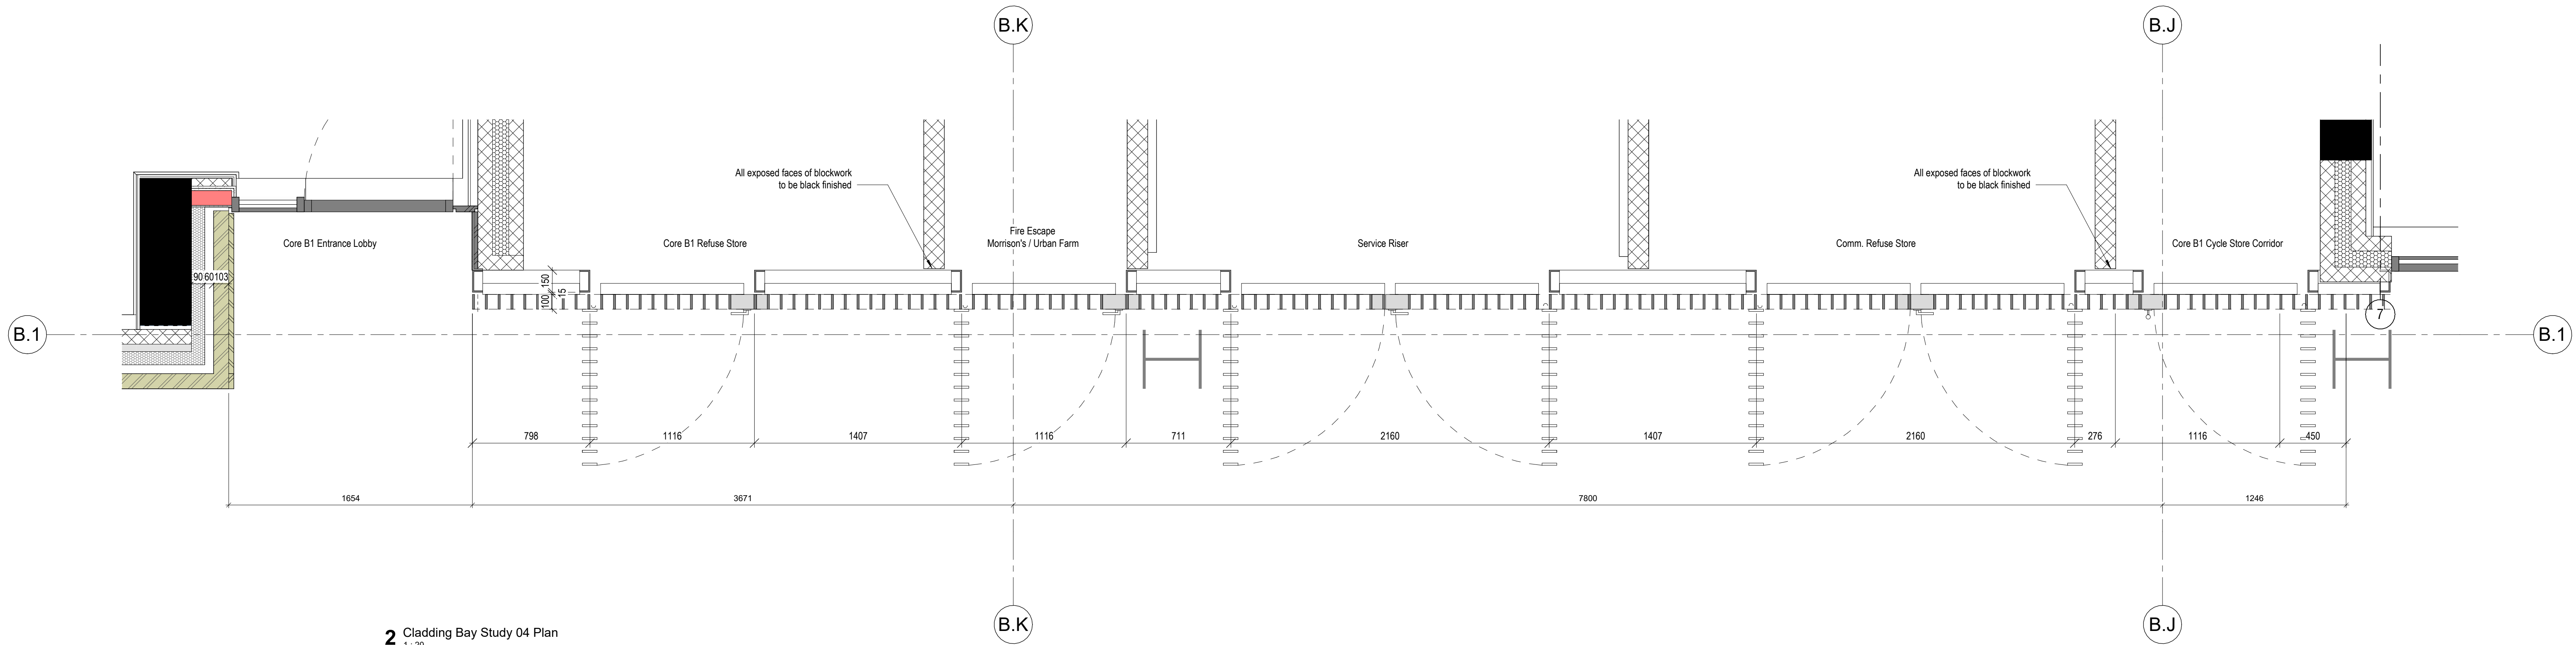

2 Cladding Bay Study 04 Plan
1:20

CO2	Updated Metalwork Issue	05.09.23	CS	JR
CO1	Construction Issue	30.06.23	CS	ACS
Revision	Description	Date	Drawn	Checked

**design
delivery
unit**

77 Endell Street
London WC2H 9DZ
T +44 (0)20 7240 7766
W designdeliveryunit.com

Client's Name
St George North London Limited



Job Title
Camden Goods Yard

Drawing Title
Building B Metalwork Core B1 Screen

Scale
As indicated @A0

Practice Project No.
20226

Practice Project No. Originator Volume Level Type Revision Number
CGYB0-DDU-B0-ZZ-DR-A-36830

Description
CONSTRUCTION

Rev
CO2