




1 Cladding Bay Elevation  
1:20

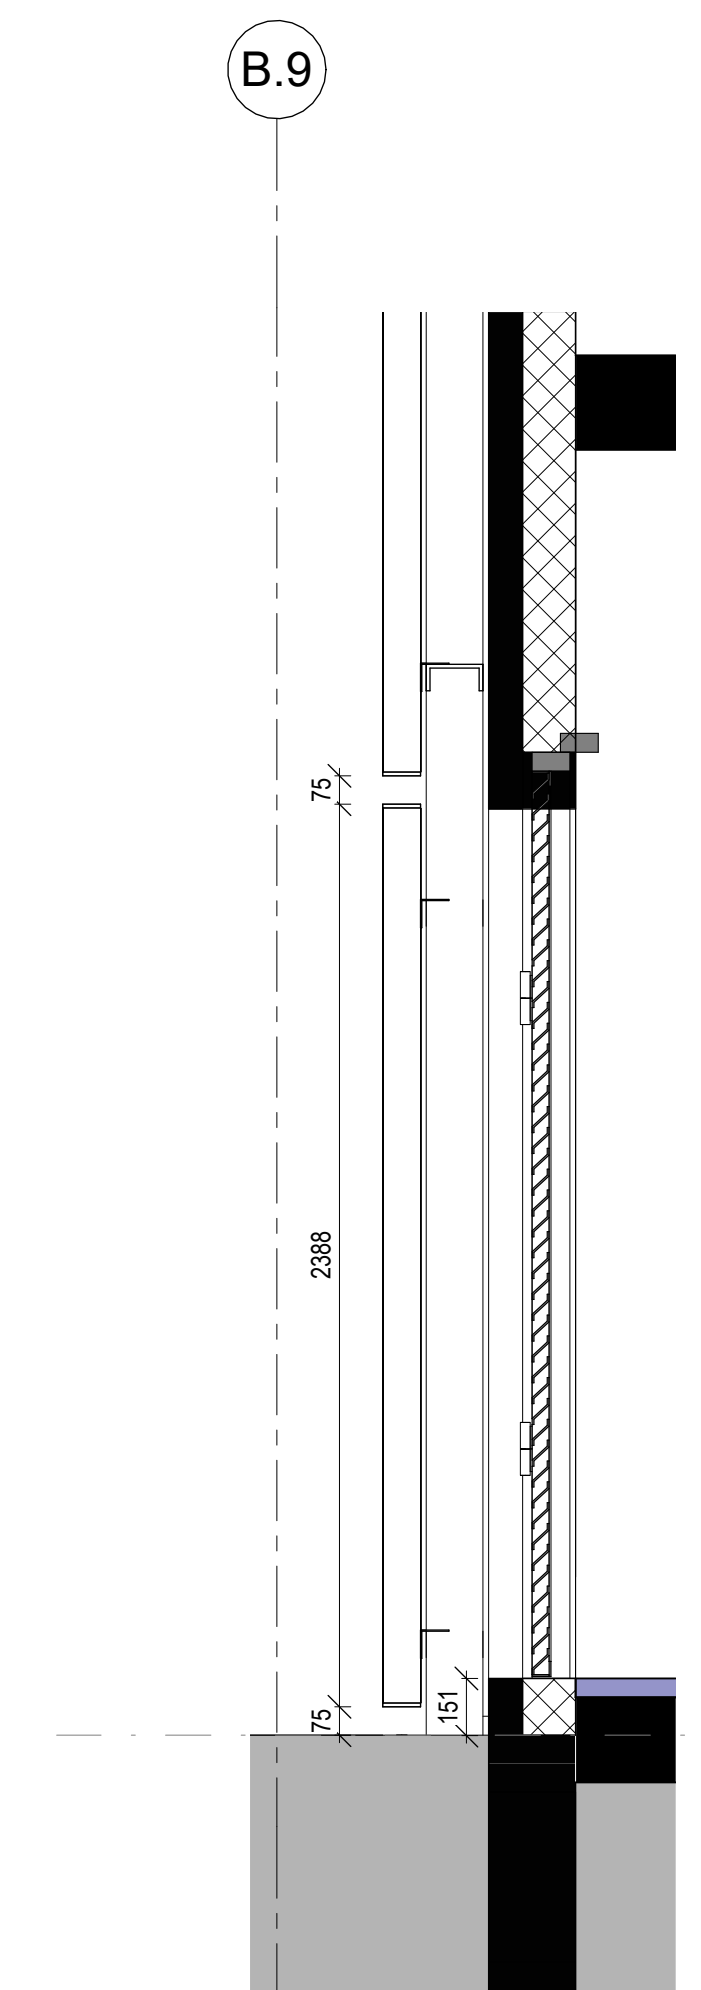


A Cladding Section A  
1:20

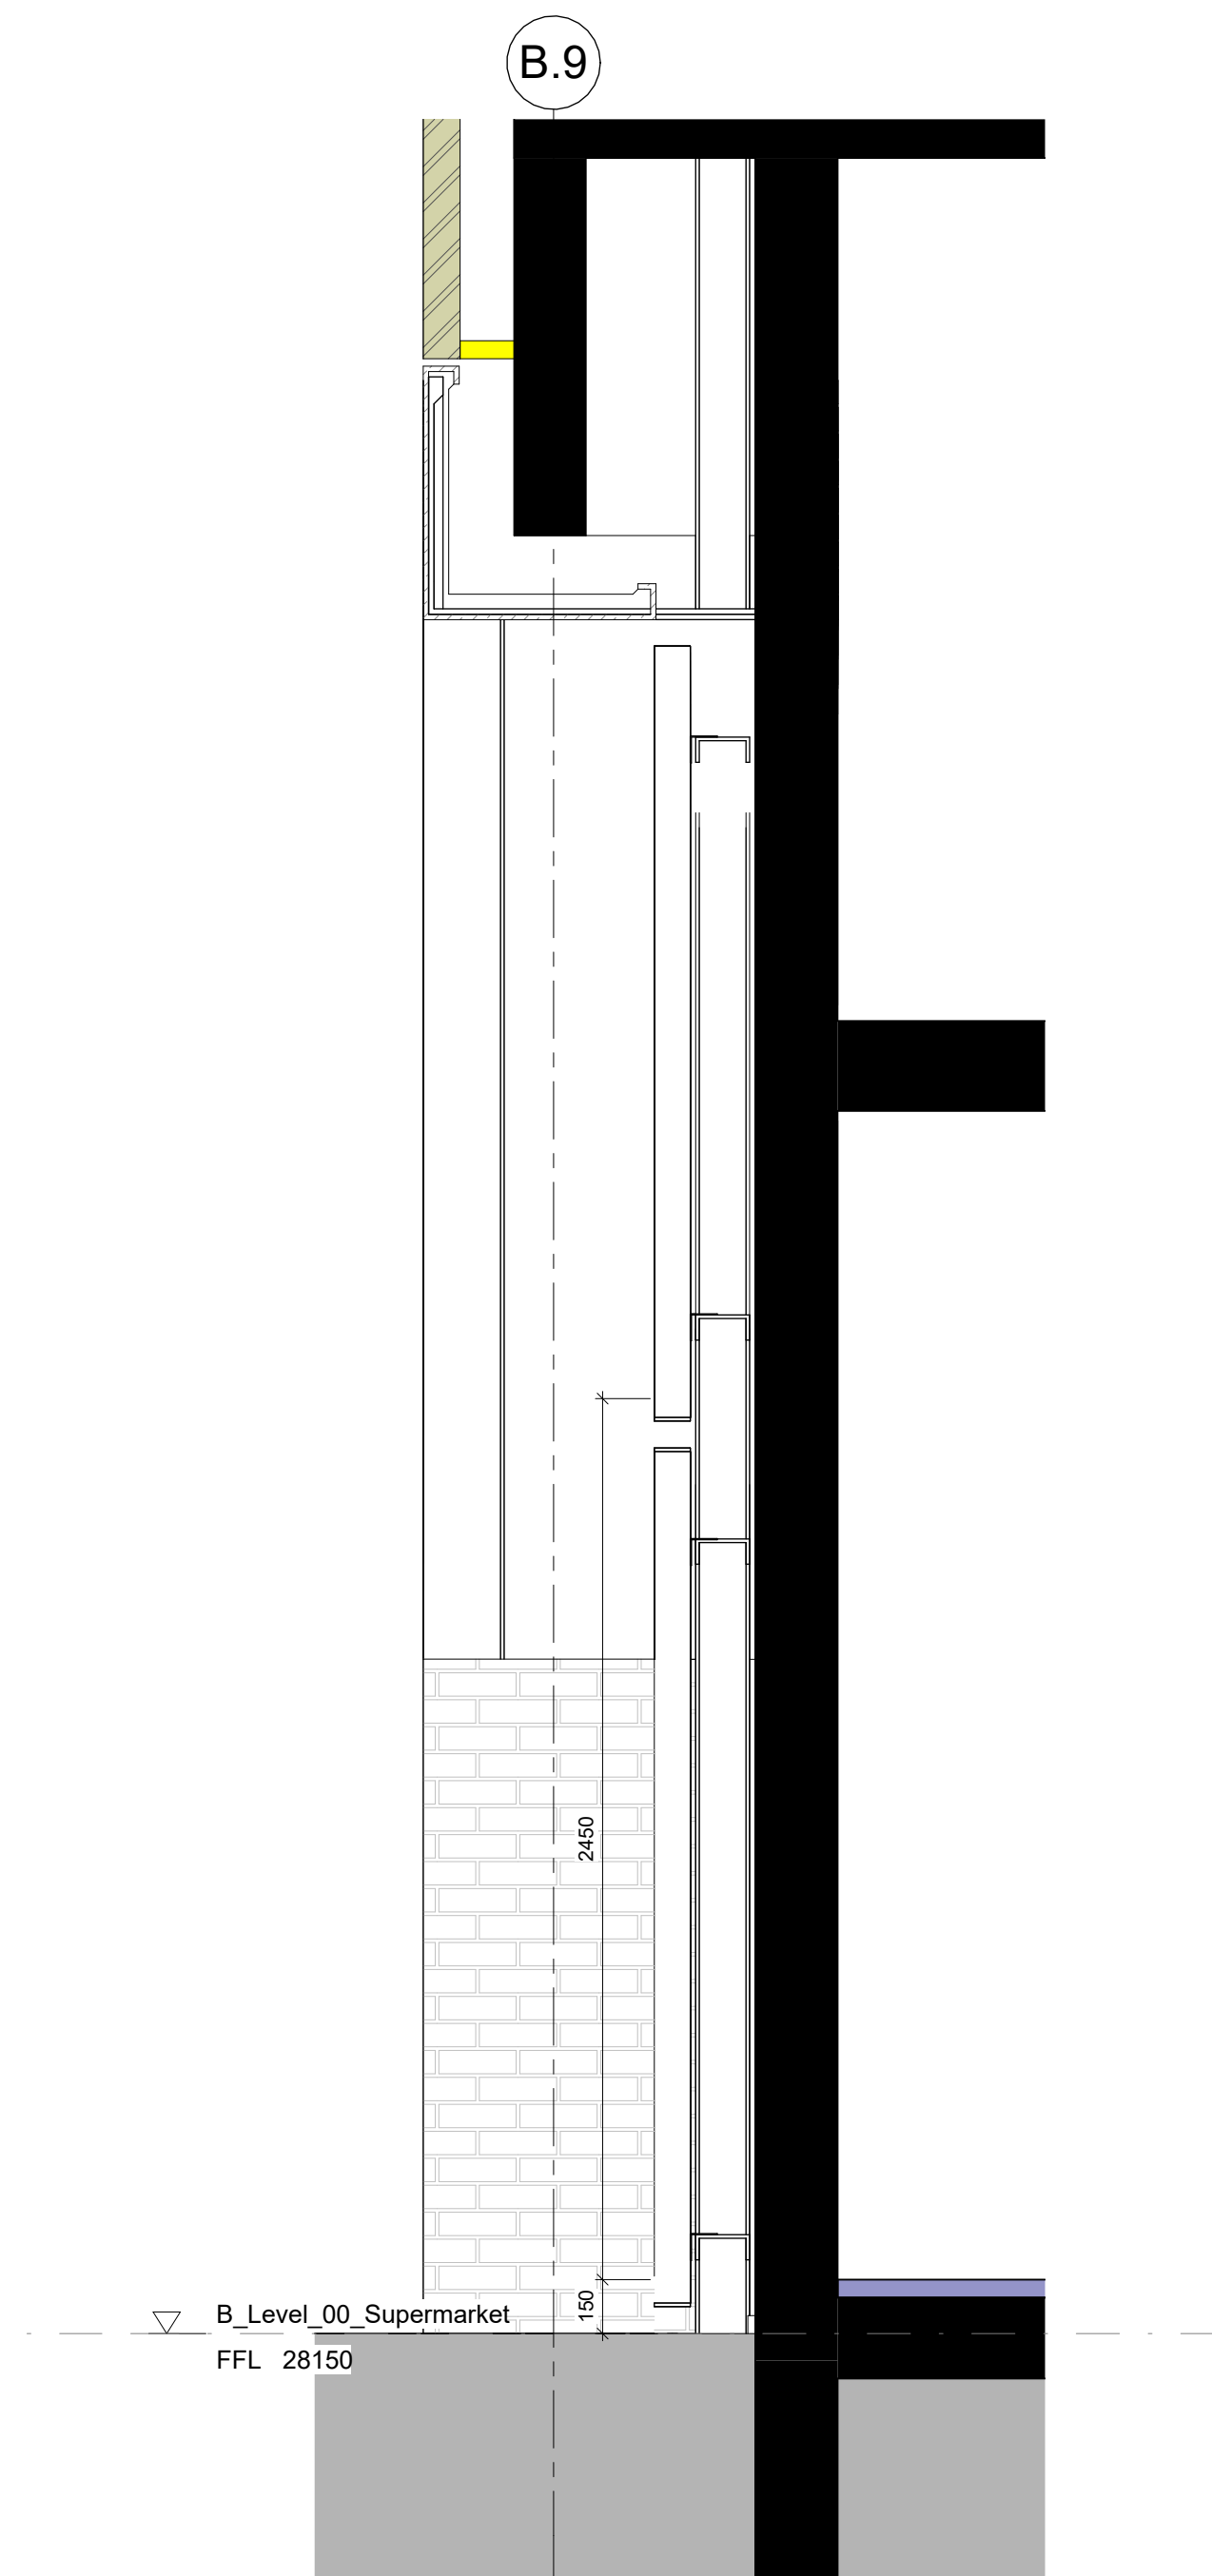

B Cladding Section B  
1:20

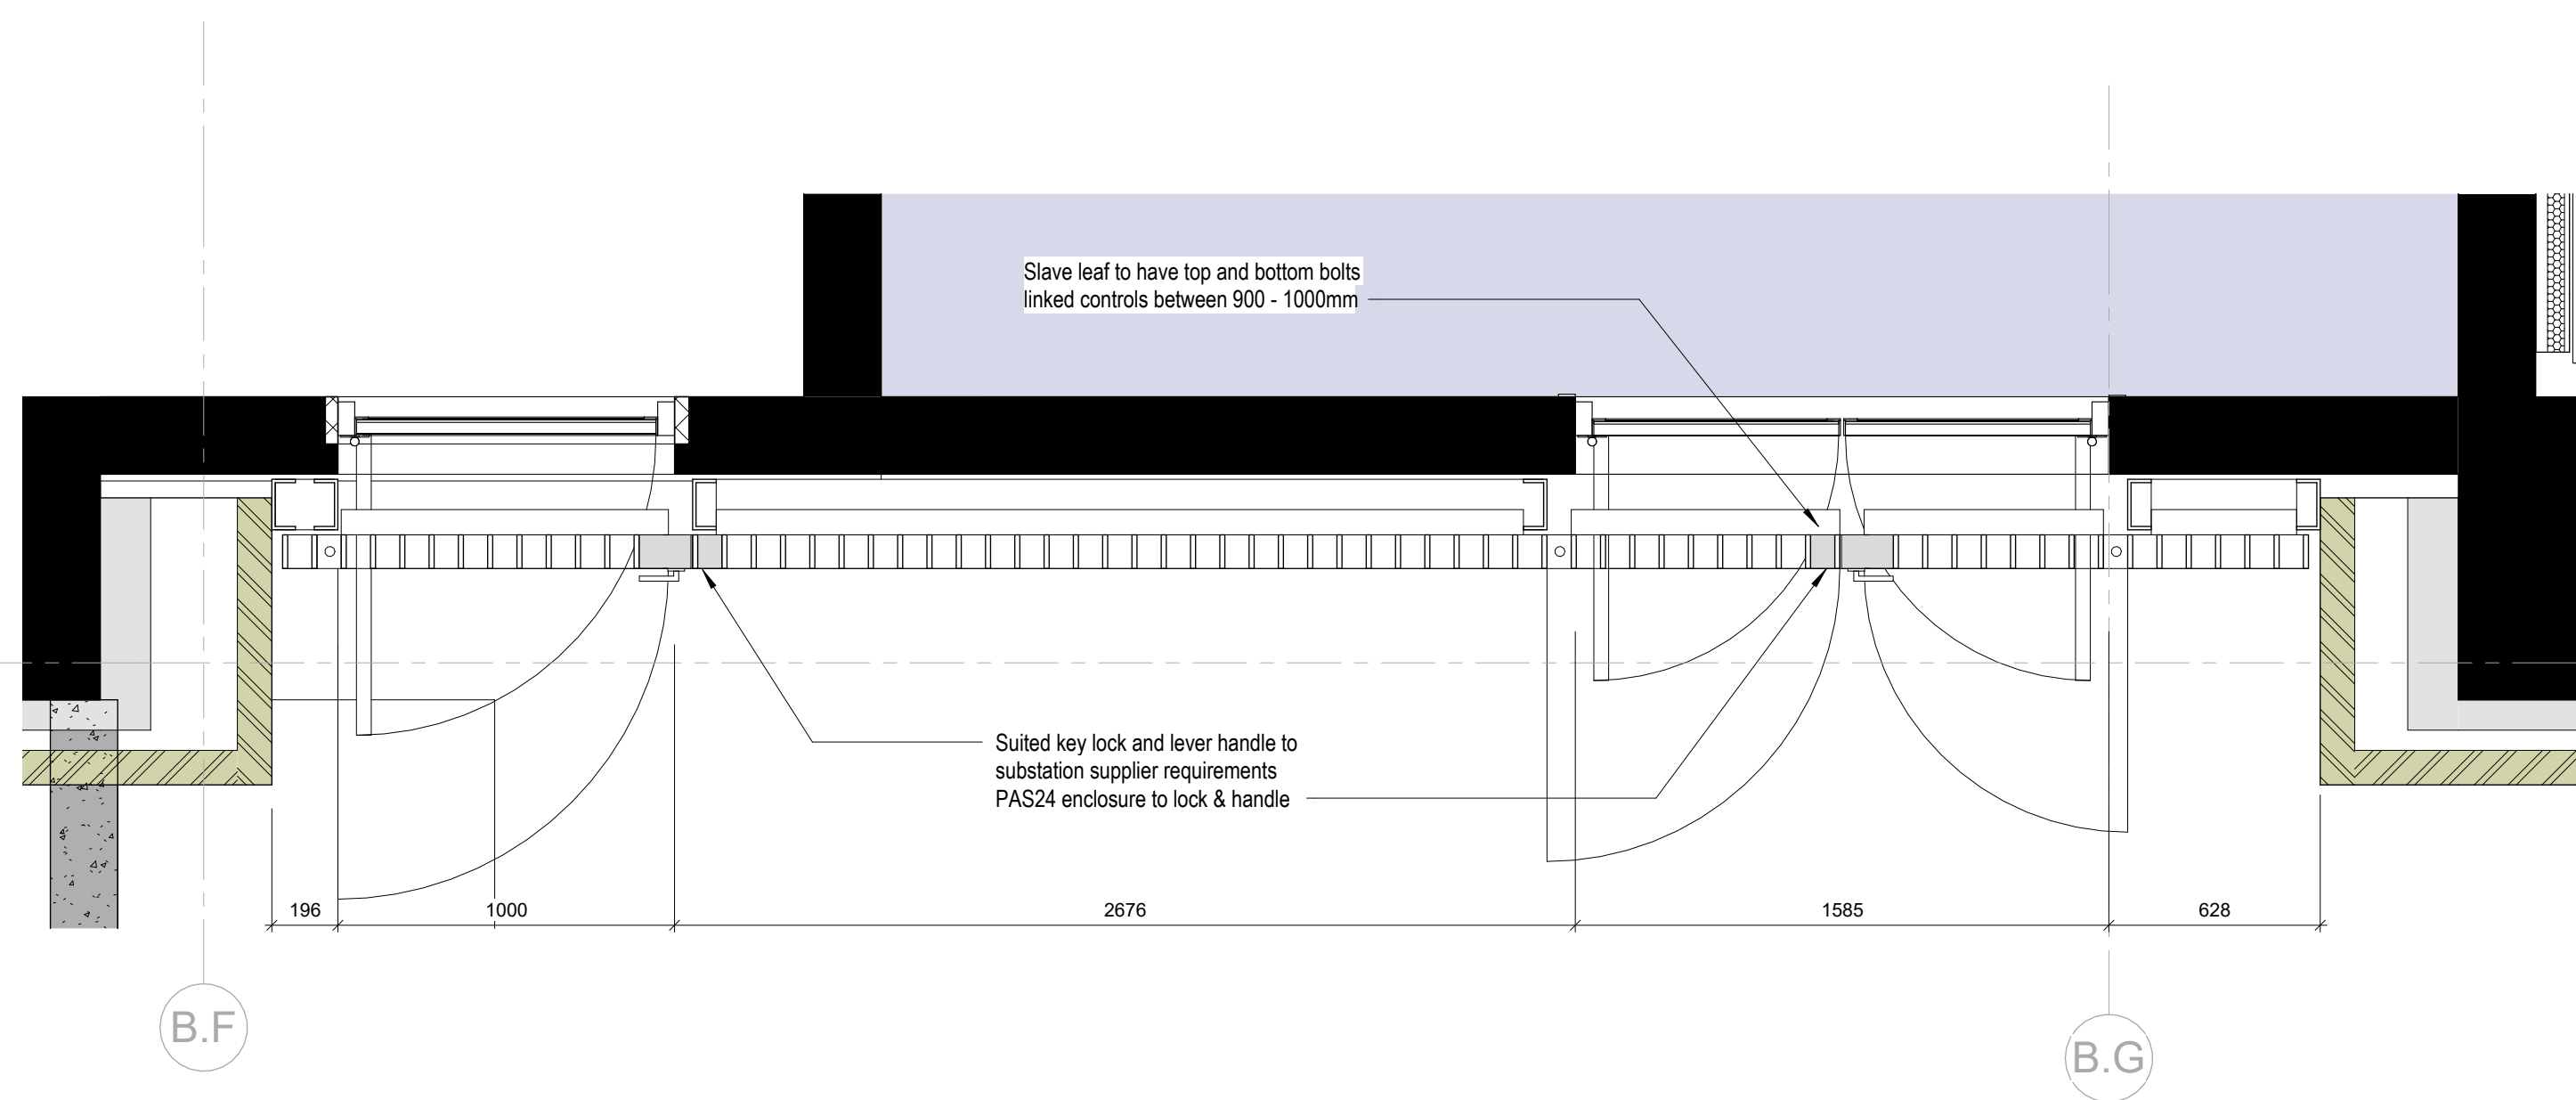

2 Cladding Bay Study 01 Plan  
1:20

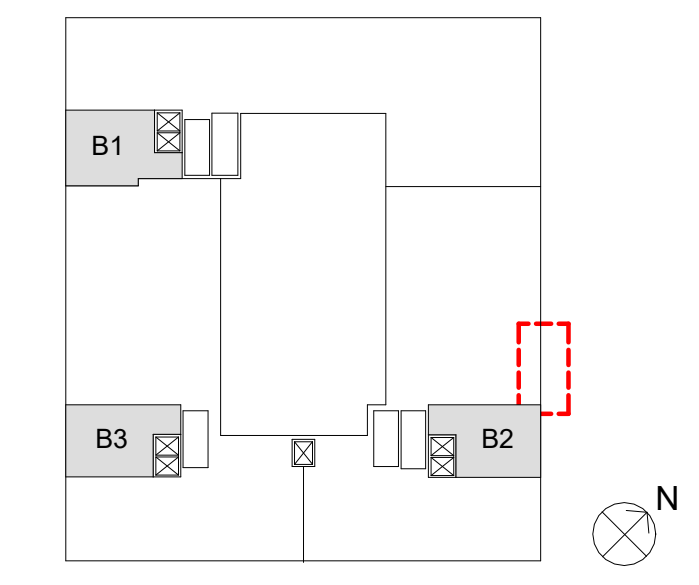

©Design Delivery Unit Limited  
This drawing is to be read in conjunction with all relevant architect's and other designers' drawings and associated specifications. Figured dimensions only are to be taken from this drawing. All dimensions are to be checked on site before any work is put in hand.

SCALE BAR: 1:20  
0 400 800 1200 1600 2000

DRAWING SERIES

- Series 00 - Accommodation Schedules
- Series 00 - NBS Specification
- Series 02 - Conveyance Plans
- Series 03 - GA Plans, GA Setting out Plans & Marketing Plans
- Series 04 - GA Sections
- Series 05 - GA Elevations
- Series 06 - Stage 2 Drawings
- Series 07 - Bay Studies
- Series 09 - 3D Views
- Series 16 - Substructure
- Series 20 - Superstructure
- Series 21 - External Wall Types & Details
- Series 22 - Internal Wall Types & Details
- Series 23 - Floor Types & Details
- Series 24 - Staircases & Lifts
- Series 27 - Roof Types & Details
- Series 31 - Window & Doors Types, Details & Schedules
- Series 35 - Reflected Ceiling Plans
- Series 36 - Balconies & External Metalwork
- Series 40 - Internal Finishes
- Series 43 - Floor Finishes
- Series 60 - Electrical Plans
- Series 67 - Fire Strategy Plans
- Series 70 - Flat Type Layouts
- Series 71 - Signage Plans
- Series 73 - Kitchen Layouts & Schedules
- Series 74 - Bathroom Layouts & Schedules
- Series 79 - Residents Facilities
- Series 82 - Commercial Units
- Series 83 - Offices

Refer to:  
03 Series Cladding plans for scoping extent,  
35 Series SW soffit plans (insulation & metalwork),  
36 Series for metalwork details &  
DDU / TFS NBS specification for metalwork elements

Revision	Description	Date	Drawn	Checked
C02	Updated Metalwork Issue	05.09.23	CS	JR
C01	Construction Issue	30.06.23	CS	ACS



77 Endell Street  
London WC2H 9DZ  
T +44 (0)20 7240 7766  
W designdeliveryunit.com

Client's Name  
St George North London Limited



Job Title  
Camden Goods Yard

Drawing Title  
Building B Metalwork Morrison's Plantroom & Substation

Scale  
As indicated @A1

Practice Project No.  
20226

Client Project Code  
CGYB0-DDU-B0-ZZ-DR-A-36827

Description	Rev
CONSTRUCTION	C02