


©Scott Brownrigg Ltd
This drawing is to be read in conjunction with all relevant architect's and other designers' drawings and associated specifications. Figured dimensions only are to be taken from this drawing. All dimensions are to be checked on site before any work is put in hand.
--- / ---

metres 1 2 3 4 5
SCALE BAR: 1:50

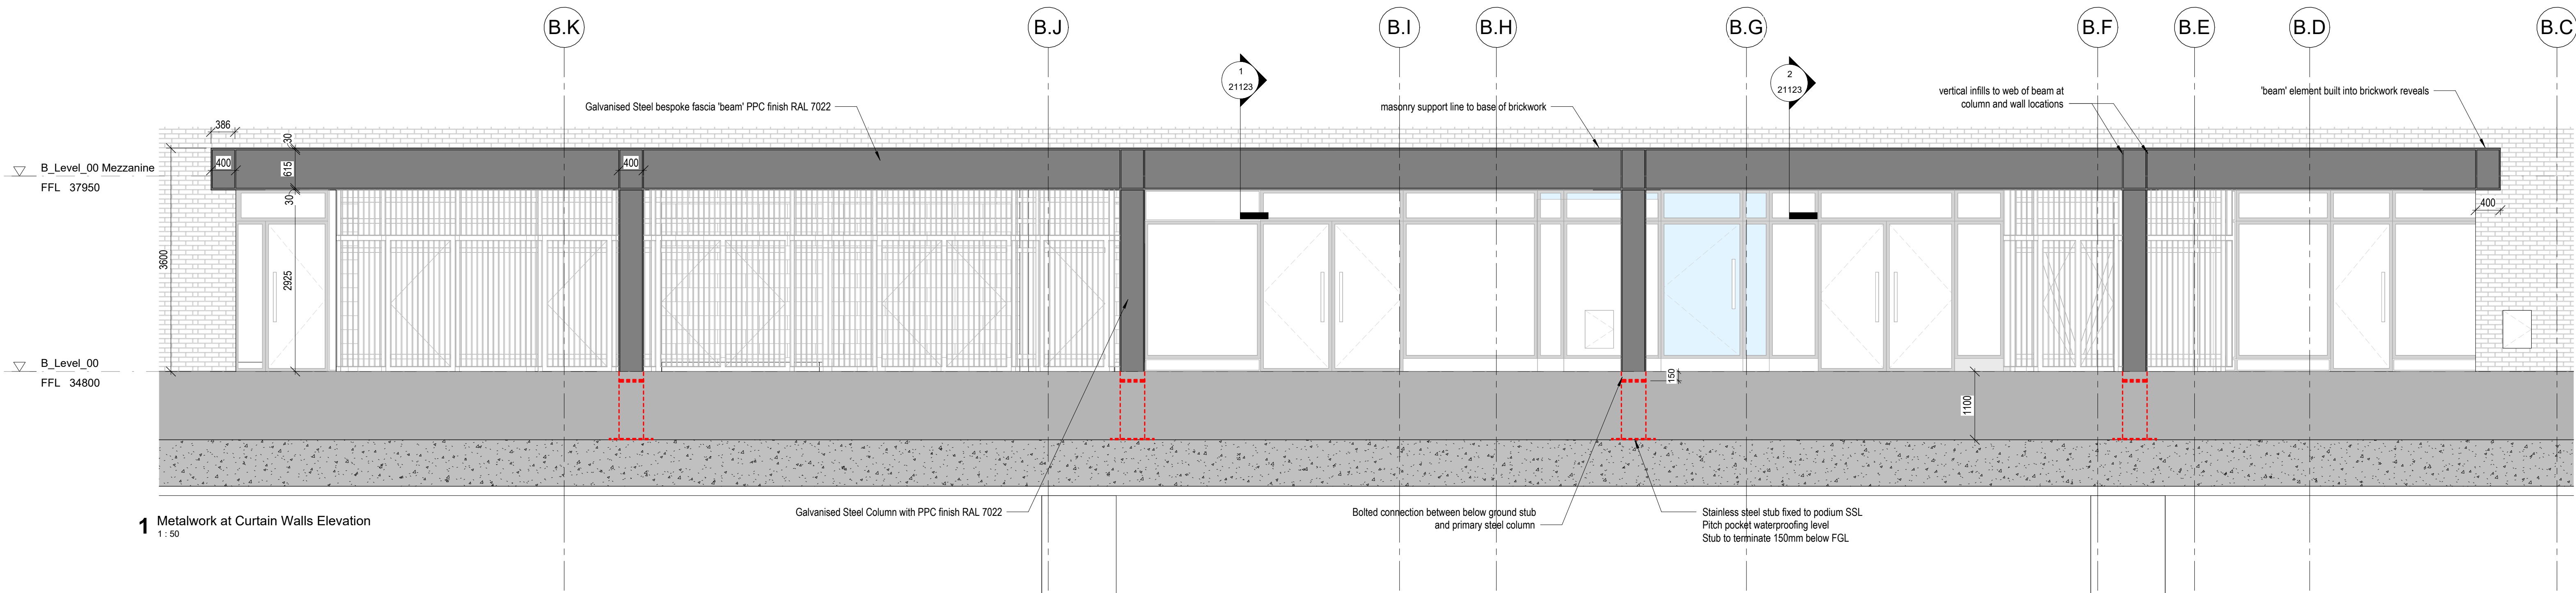

DRAWING SERIES

Series 00 - Accommodation Schedules
Series 00 - NBS Specification
Series 02 - Conveyance Plans
Series 03 - GA Plans, GA Setting out Plans & Marketing Plans
Series 04 - GA Sections
Series 05 - GA Elevations
Series 06 - Stage 2 Drawings
Series 07 - Bay Studies
Series 08 - 3D Views
Series 16 - Substructure
Series 24 - Staircases & Lifts
Series 21 - External Wall Types & Details
Series 22 - Internal Wall Types & Details
Series 24 - Staircases & Lifts
Series 27 - Roof Types & Details
Series 31 - Window & Doors Types, Details & Schedules
Series 35 - Reflected Ceiling Plans
Series 35 - Floor Types & Details
Series 36 - Balconies & External Metalwork
Series 43 - Internal Finishes
Series 43 - Floor Finishes
Series 60 - Electrical Plans
Series 67 - Fire Strategy Plans
Series 70 - Flat Type Layouts
Series 71 - Signage Plans
Series 73 - Kitchen Layouts & Schedules
Series 74 - Bathroom Layouts & Schedules
Series 76 - Residents Facilities
Series 82 - Commercial Units
Series 83 - Offices
Series 84 - Annex Plans


GENERAL NOTES

STRUCTURAL - For design, detailing and setting out of structural elements refer to Structural Engineers drawings.

SERVICES - For design, detailing & setting out of services, including SVPS, Gas, Water, Electricals & Telecoms etc refer to M&E Engineers and Structural Engineers drawings.

All information on this drawing must be read in conjunction with relevant series and specifications.

Refer to:
03 Series Cladding plans for scoping extent.
35 Series SW scuff plans (insulation & metalwork),
36 Series for metalwork details &
CDU / TFS NBS specification for metalwork elements

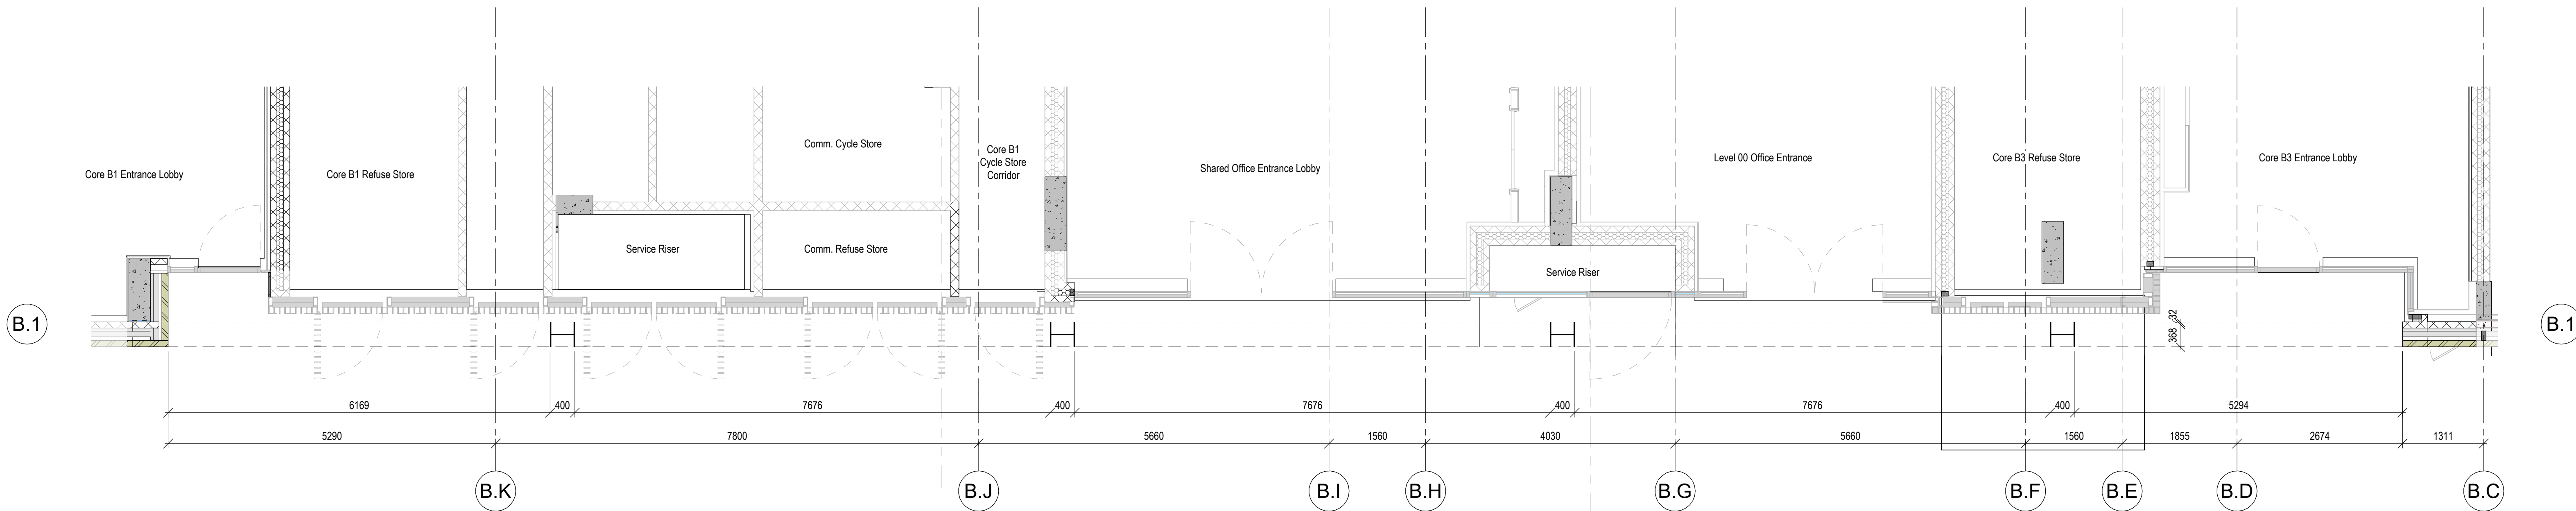

CO2	Updated Metalwork Issue	05.09.23	CS	JR
CO1	Construction Issue	30.06.23	CS	ACS
Revision	Description	Date	Drawn	Checked

design
delivery
unit

77 Endell Street
London WC2H 9DZ
T +44 (0)20 7240 7766
W designdeliveryunit.com

Clients Name

St George North London Limited



Job Title

Camden Goods Yard

Drawing Title

Building B Metalwork Moment Frame

Scale Practice Project No.

As indicated @A0 20226

Practice Project No.	Originator	Volume	Level	Type	Rev	Number
CGYB0-DDU-B0-ZZ-DR-A-36826						

Description	Rev
CONSTRUCTION	CO2

© Design Delivery 2023. All rights reserved. This drawing is the property of Design Delivery and is not to be reproduced or used in any way without the written authority of Design Delivery. All dimensions are to be checked on site before any work is put in hand.