




1 Elevation- Urban Farm Entrance Canopy  
1: 20

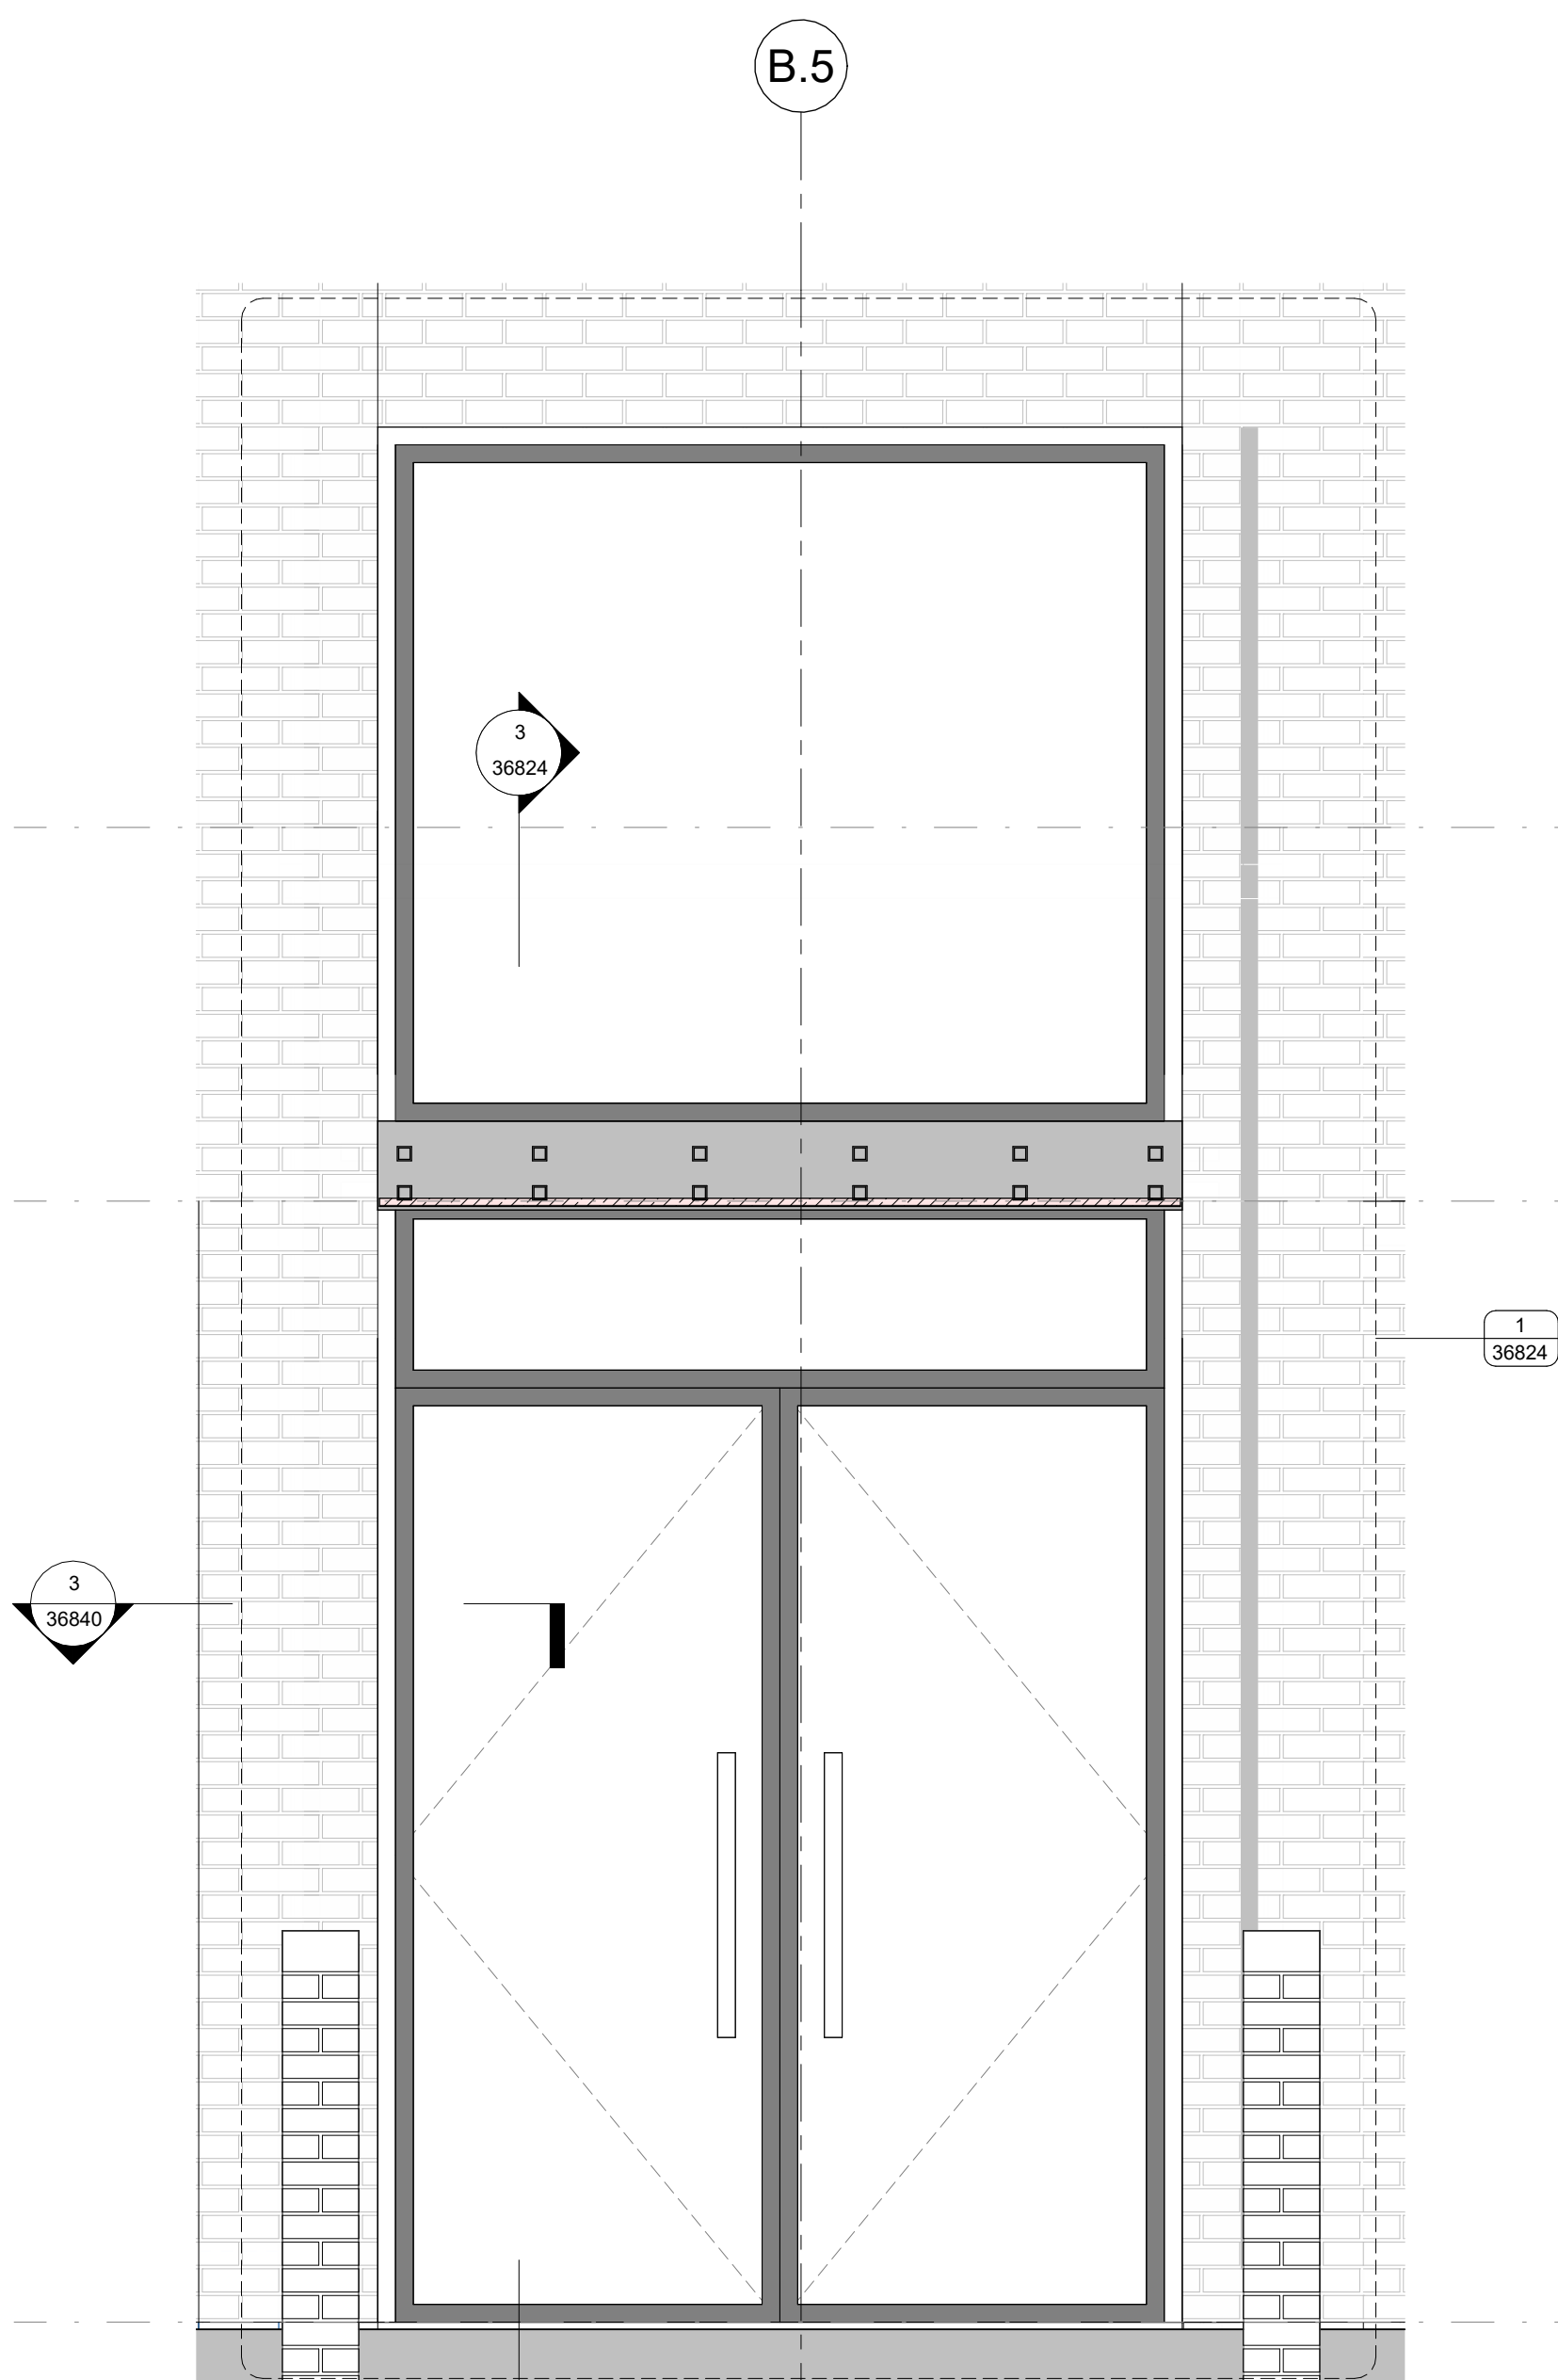


2 Section Through Entrance Canopy  
1: 20

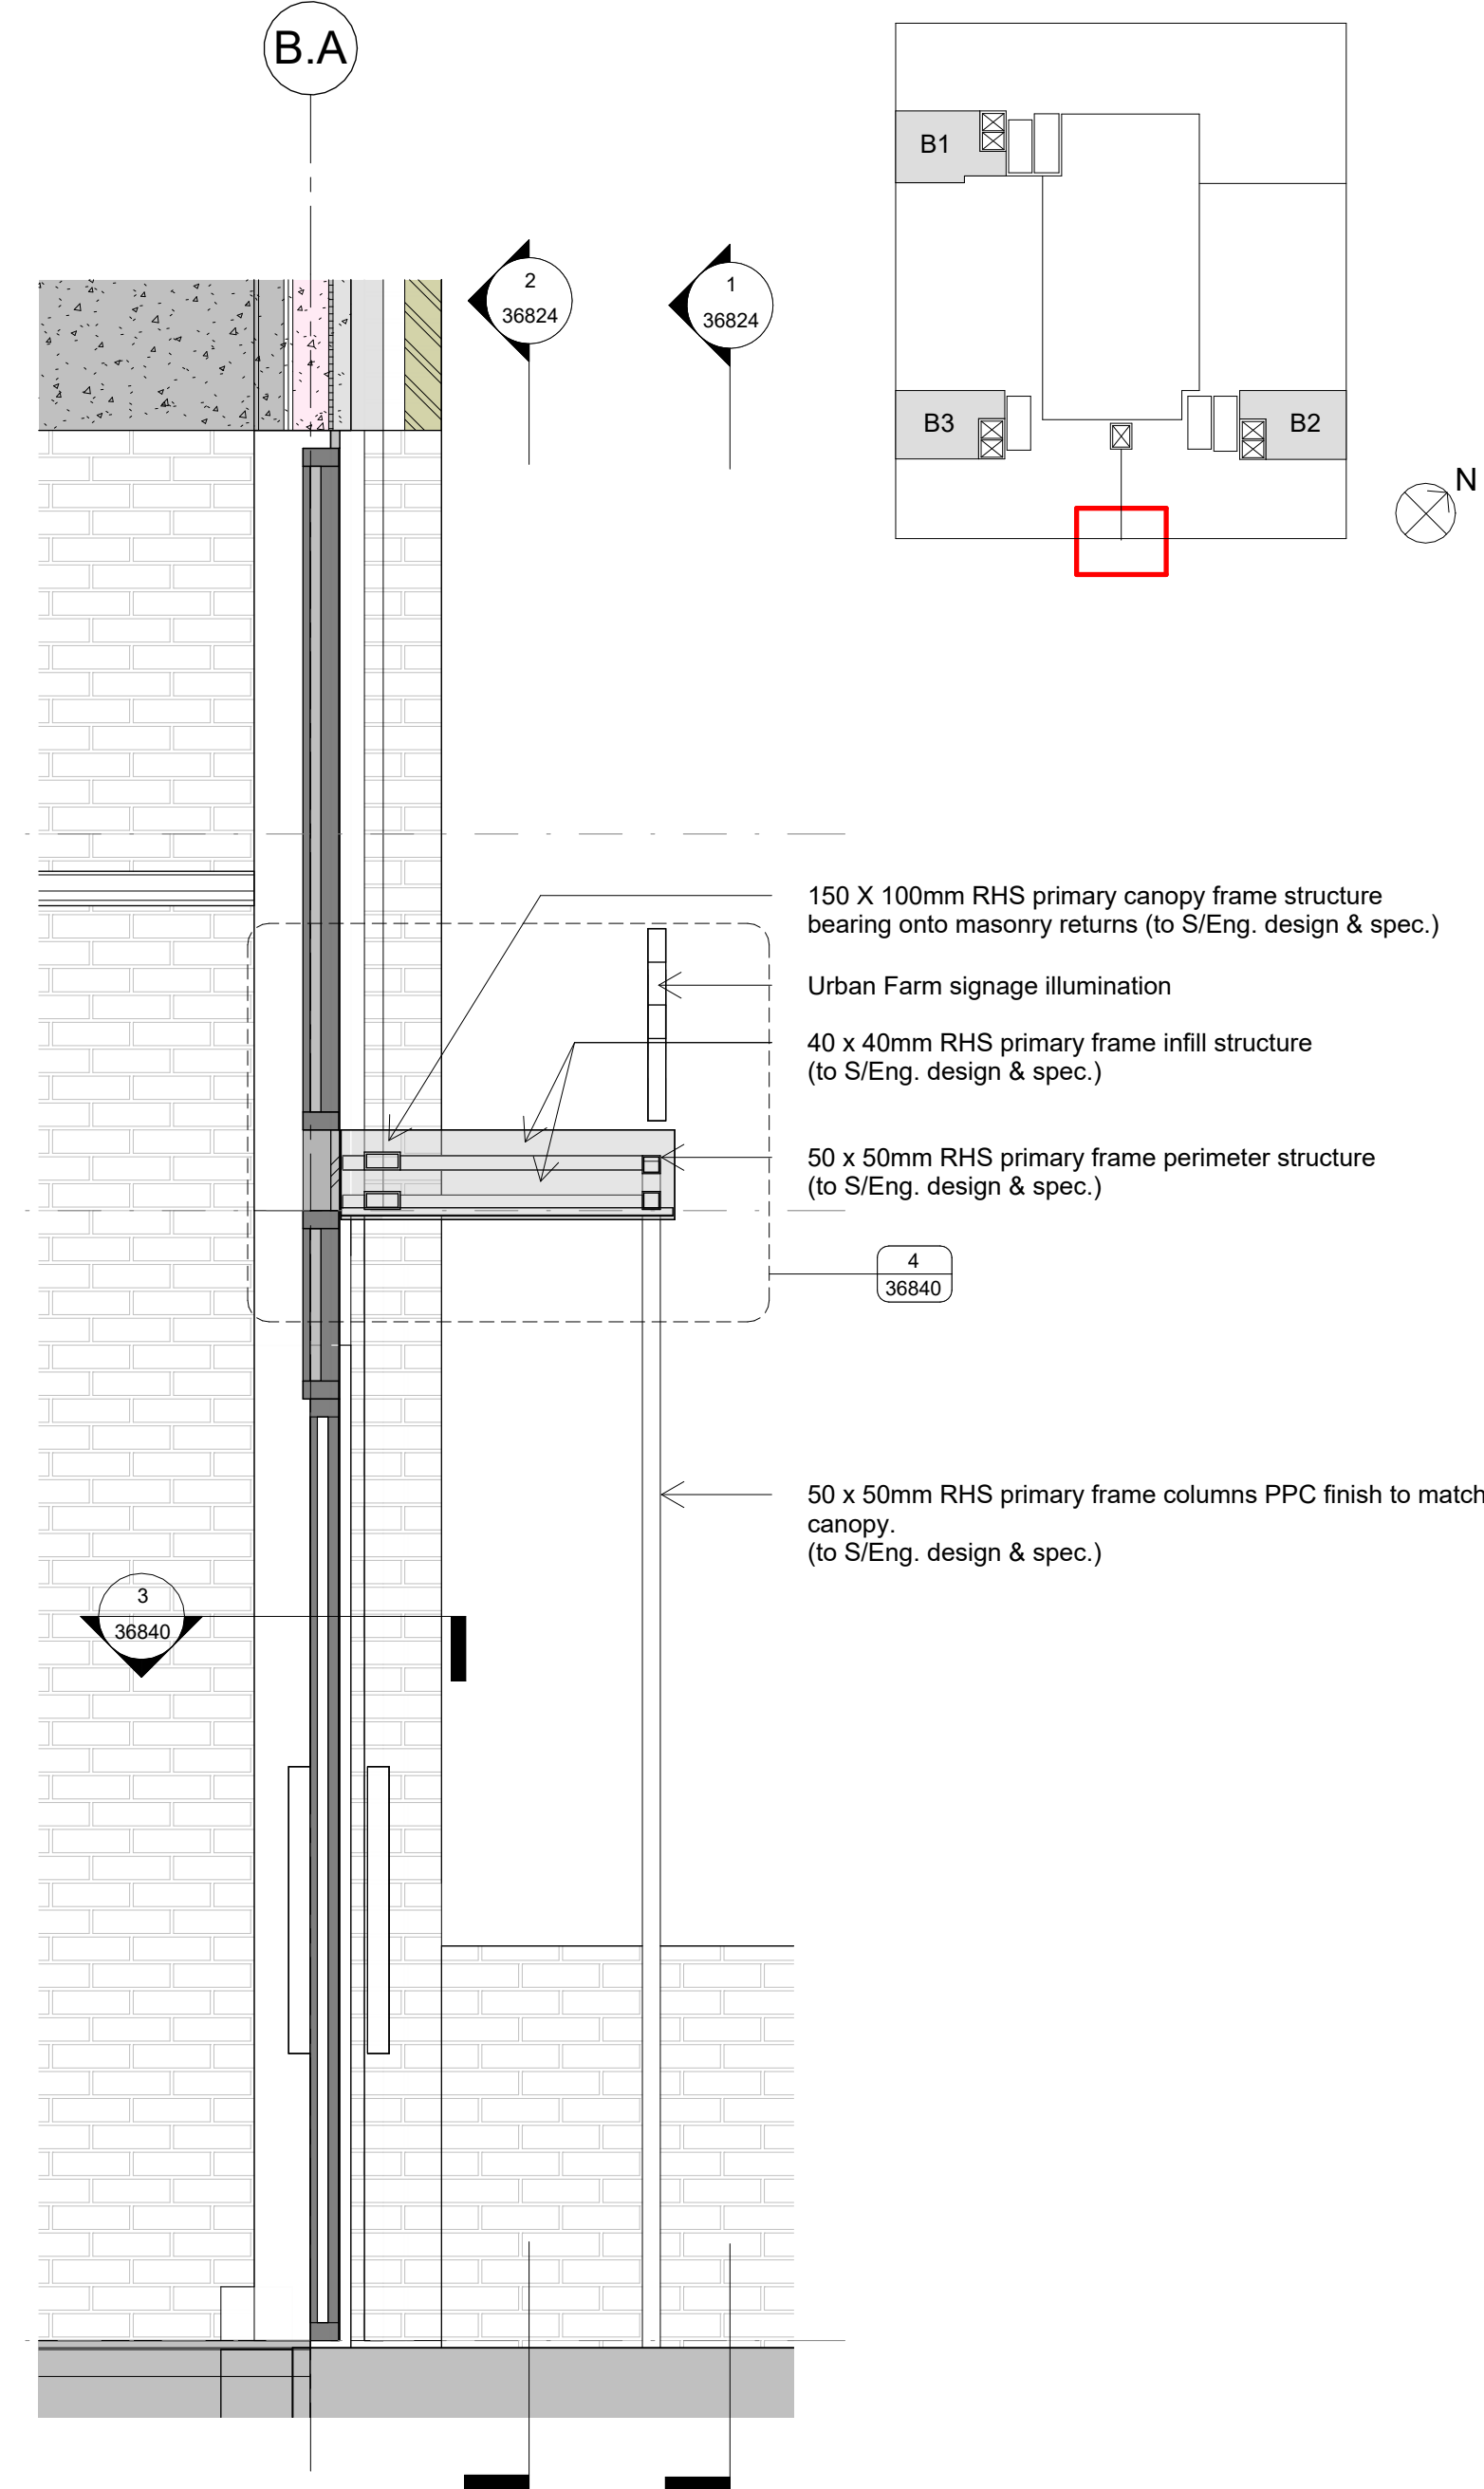


3 Cross Section Through Entrance Canopy  
1: 20

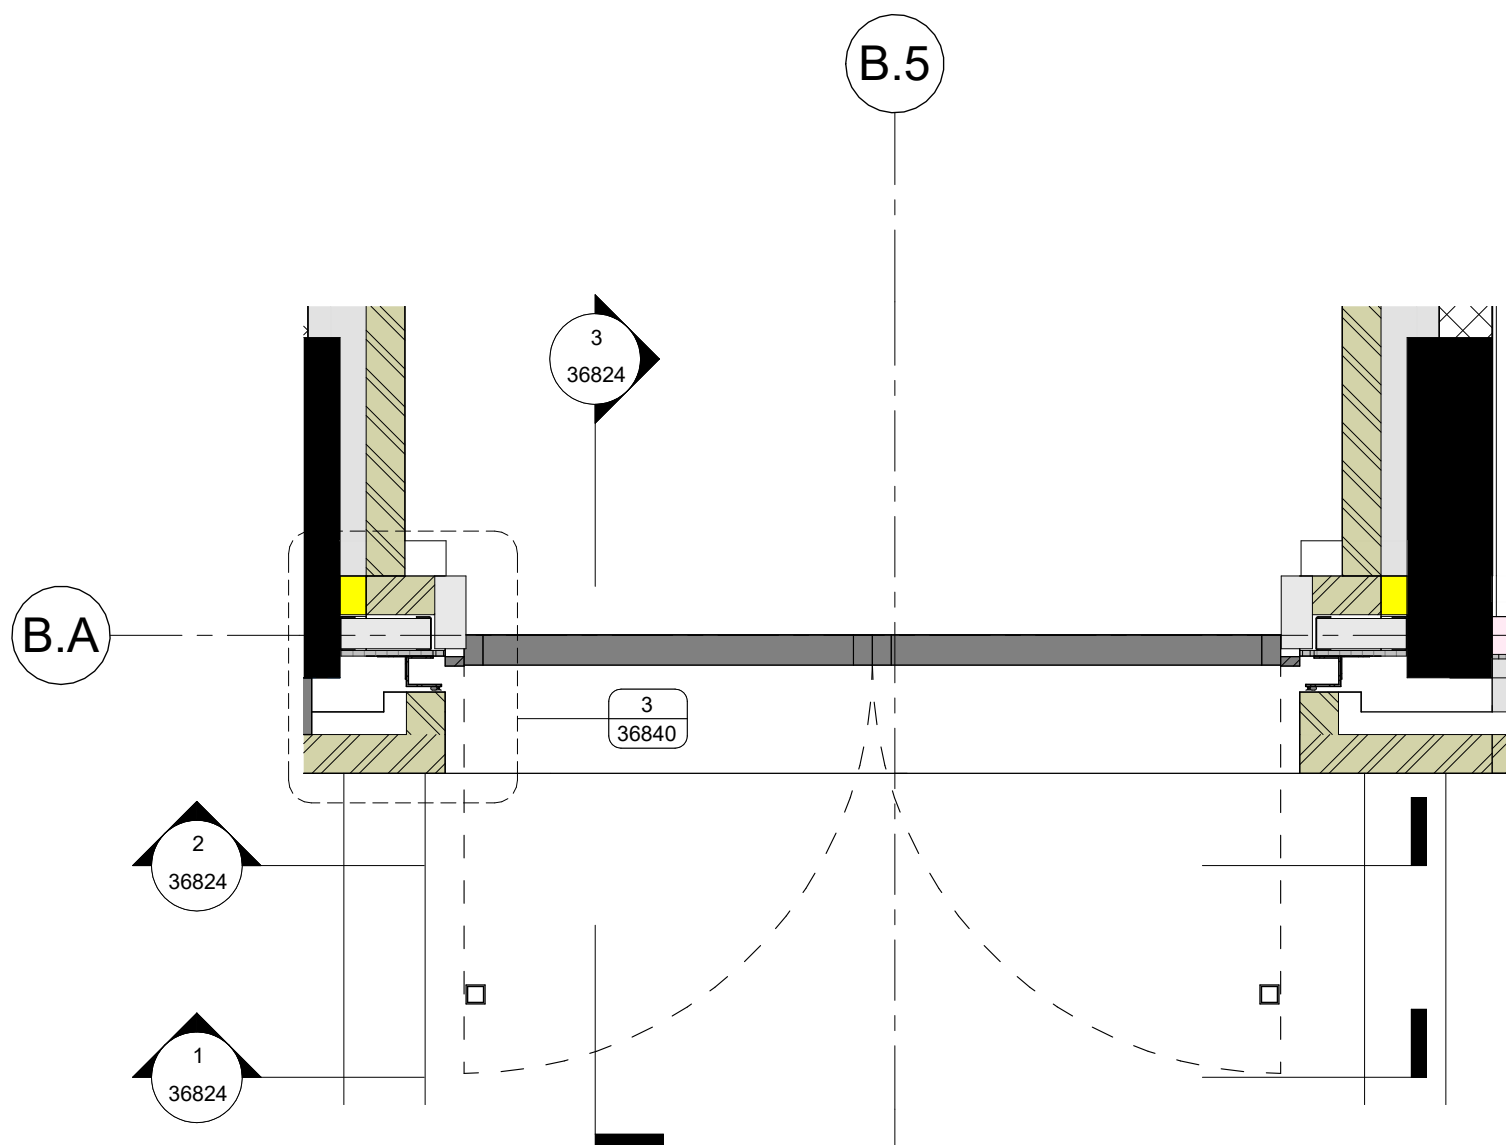

4 Urban Farm Canopy - Level 00  
1: 20

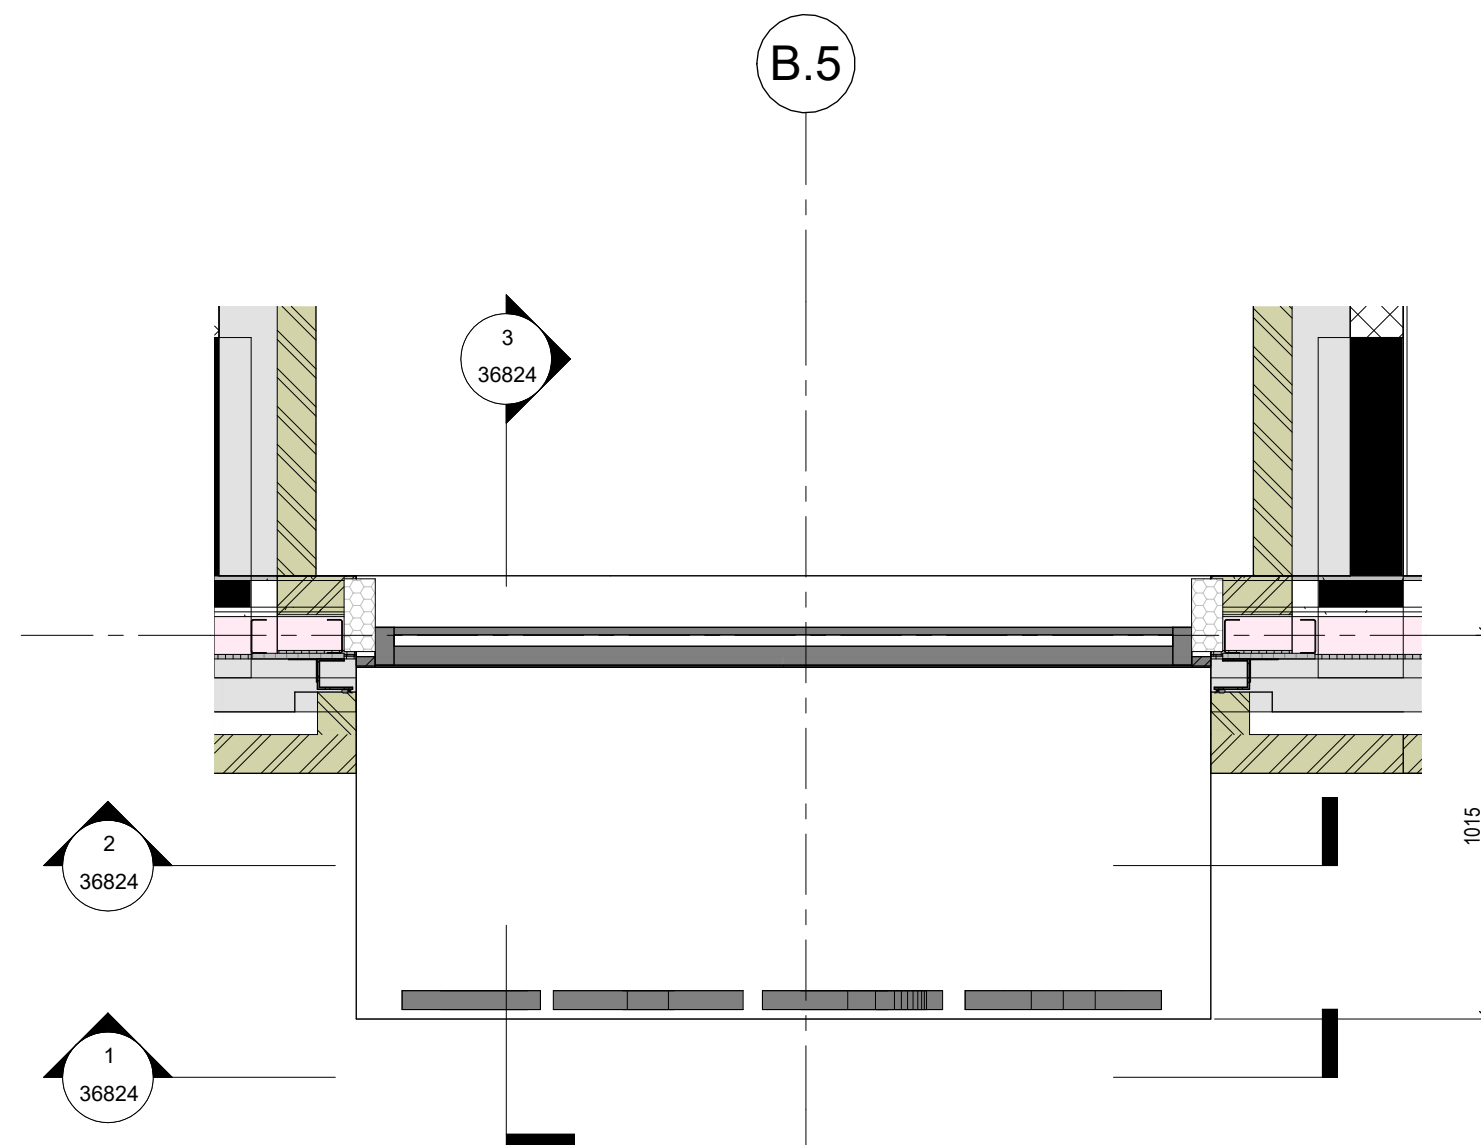

5 Urban Farm Canopy - Plan  
1: 20

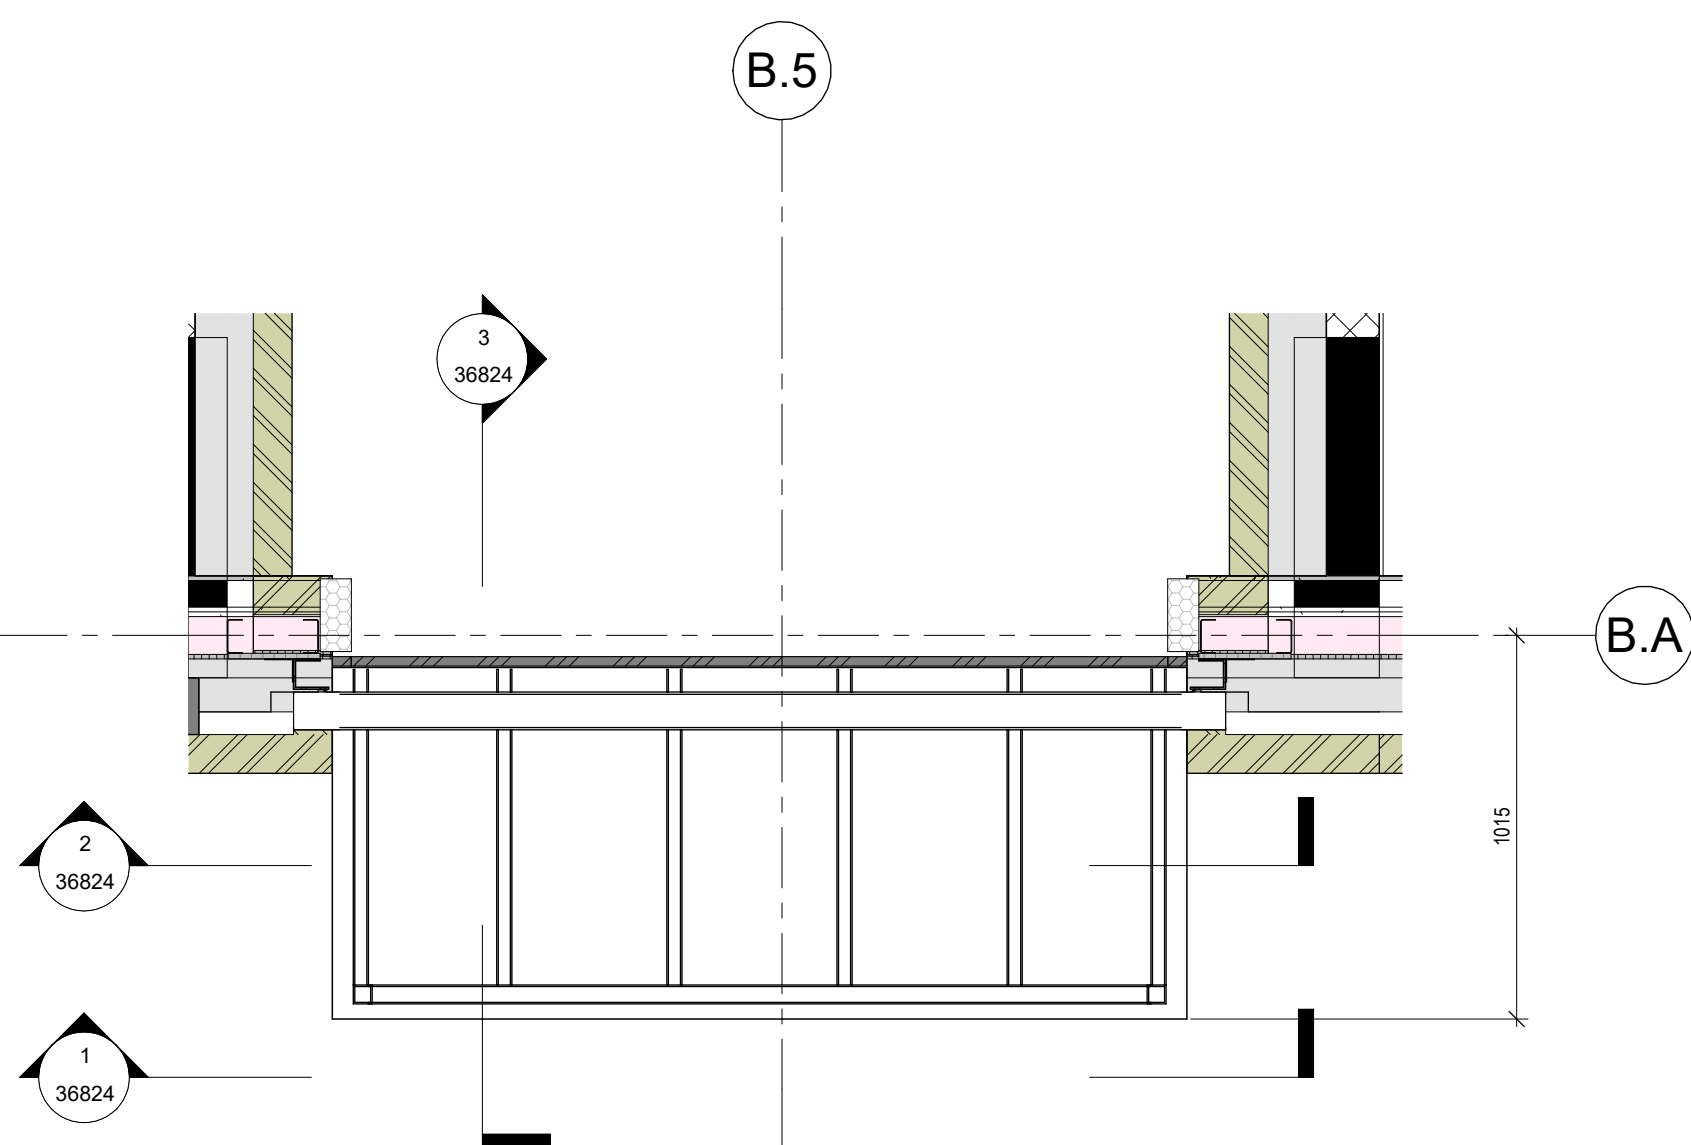

6 Urban Farm Canopy - Plan through Canopy Frame  
1: 20

©Design Delivery Unit Limited  
This drawing is to be read in conjunction with all relevant architect's and other designers' drawings and associated specifications. Figured dimensions only are to be taken from this drawing. All dimensions are to be checked on site before any work is put in hand.

SCALE BAR: 1:20

DRAWING SERIES	
Series 00 - Accommodation Schedules	
Series 00 - NBS Specification	
Series 02 - Conveyance Plans	
Series 03 - GA Plans, GA Setting out Plans & Marketing Plans	
Series 04 - GA Sections	
Series 05 - GA Elevations	
Series 06 - Stage 2 Drawings	
Series 07 - Bay Studies	
Series 09 - 3D Views	
Series 16 - Substructure	
Series 20 - Superstructure	
Series 21 - External Wall Types & Details	
Series 22 - Internal Wall Types & Details	
Series 23 - Floor Types & Details	
Series 24 - Staircases & Lifts	
Series 27 - Roof Types & Details	
Series 31 - Window & Doors Types, Details & Schedules	
Series 35 - Reflected Ceiling Plans	
Series 36 - Balconies & External Metalwork	
Series 40 - Internal Finishes	
Series 43 - Floor Finishes	
Series 60 - Electrical Plans	
Series 67 - Fire Strategy Plans	
Series 70 - Flat Type Layouts	
Series 71 - Signage Plans	
Series 73 - Kitchen Layouts & Schedules	
Series 74 - Bathroom Layouts & Schedules	
Series 79 - Residents Facilities	
Series 82 - Commercial Units	
Series 83 - Offices	

Refer to:  
03 Series Cladding plans for scoping extent,  
35 Series SW soffit plans (insulation & metalwork),  
36 Series for metalwork details &  
DDU / TFS NBS specification for metalwork elements

C02	Updated Metalwork Issue	05.09.23	CS	JR
C01	Construction Issue	30.06.23	CS	ACS
Revision	Description	Date	Drawn	Checked

design  
delivery  
unit

77 Endell Street  
London WC2H 9DZ  
T + 44 (0)20 7240 7766  
W designdeliveryunit.com

Client's Name  
St George North London Limited



Job Title  
Camden Goods Yard

Drawing Title  
Building B Metalwork Urban Farm  
Entrance Signage

Scale  
As indicated @A1

Practice Project No.  
20226

Client Project Code  
CGYB0-DDU-B0-ZZ-DR-A-36824

Description  
CONSTRUCTION

Rev  
C02

© Design Delivery Unit Ltd retain copyright of this drawing. It may not be copied, altered or reproduced in any way without their written authority.