




1 MW-B-03 - Elevation  
1:20

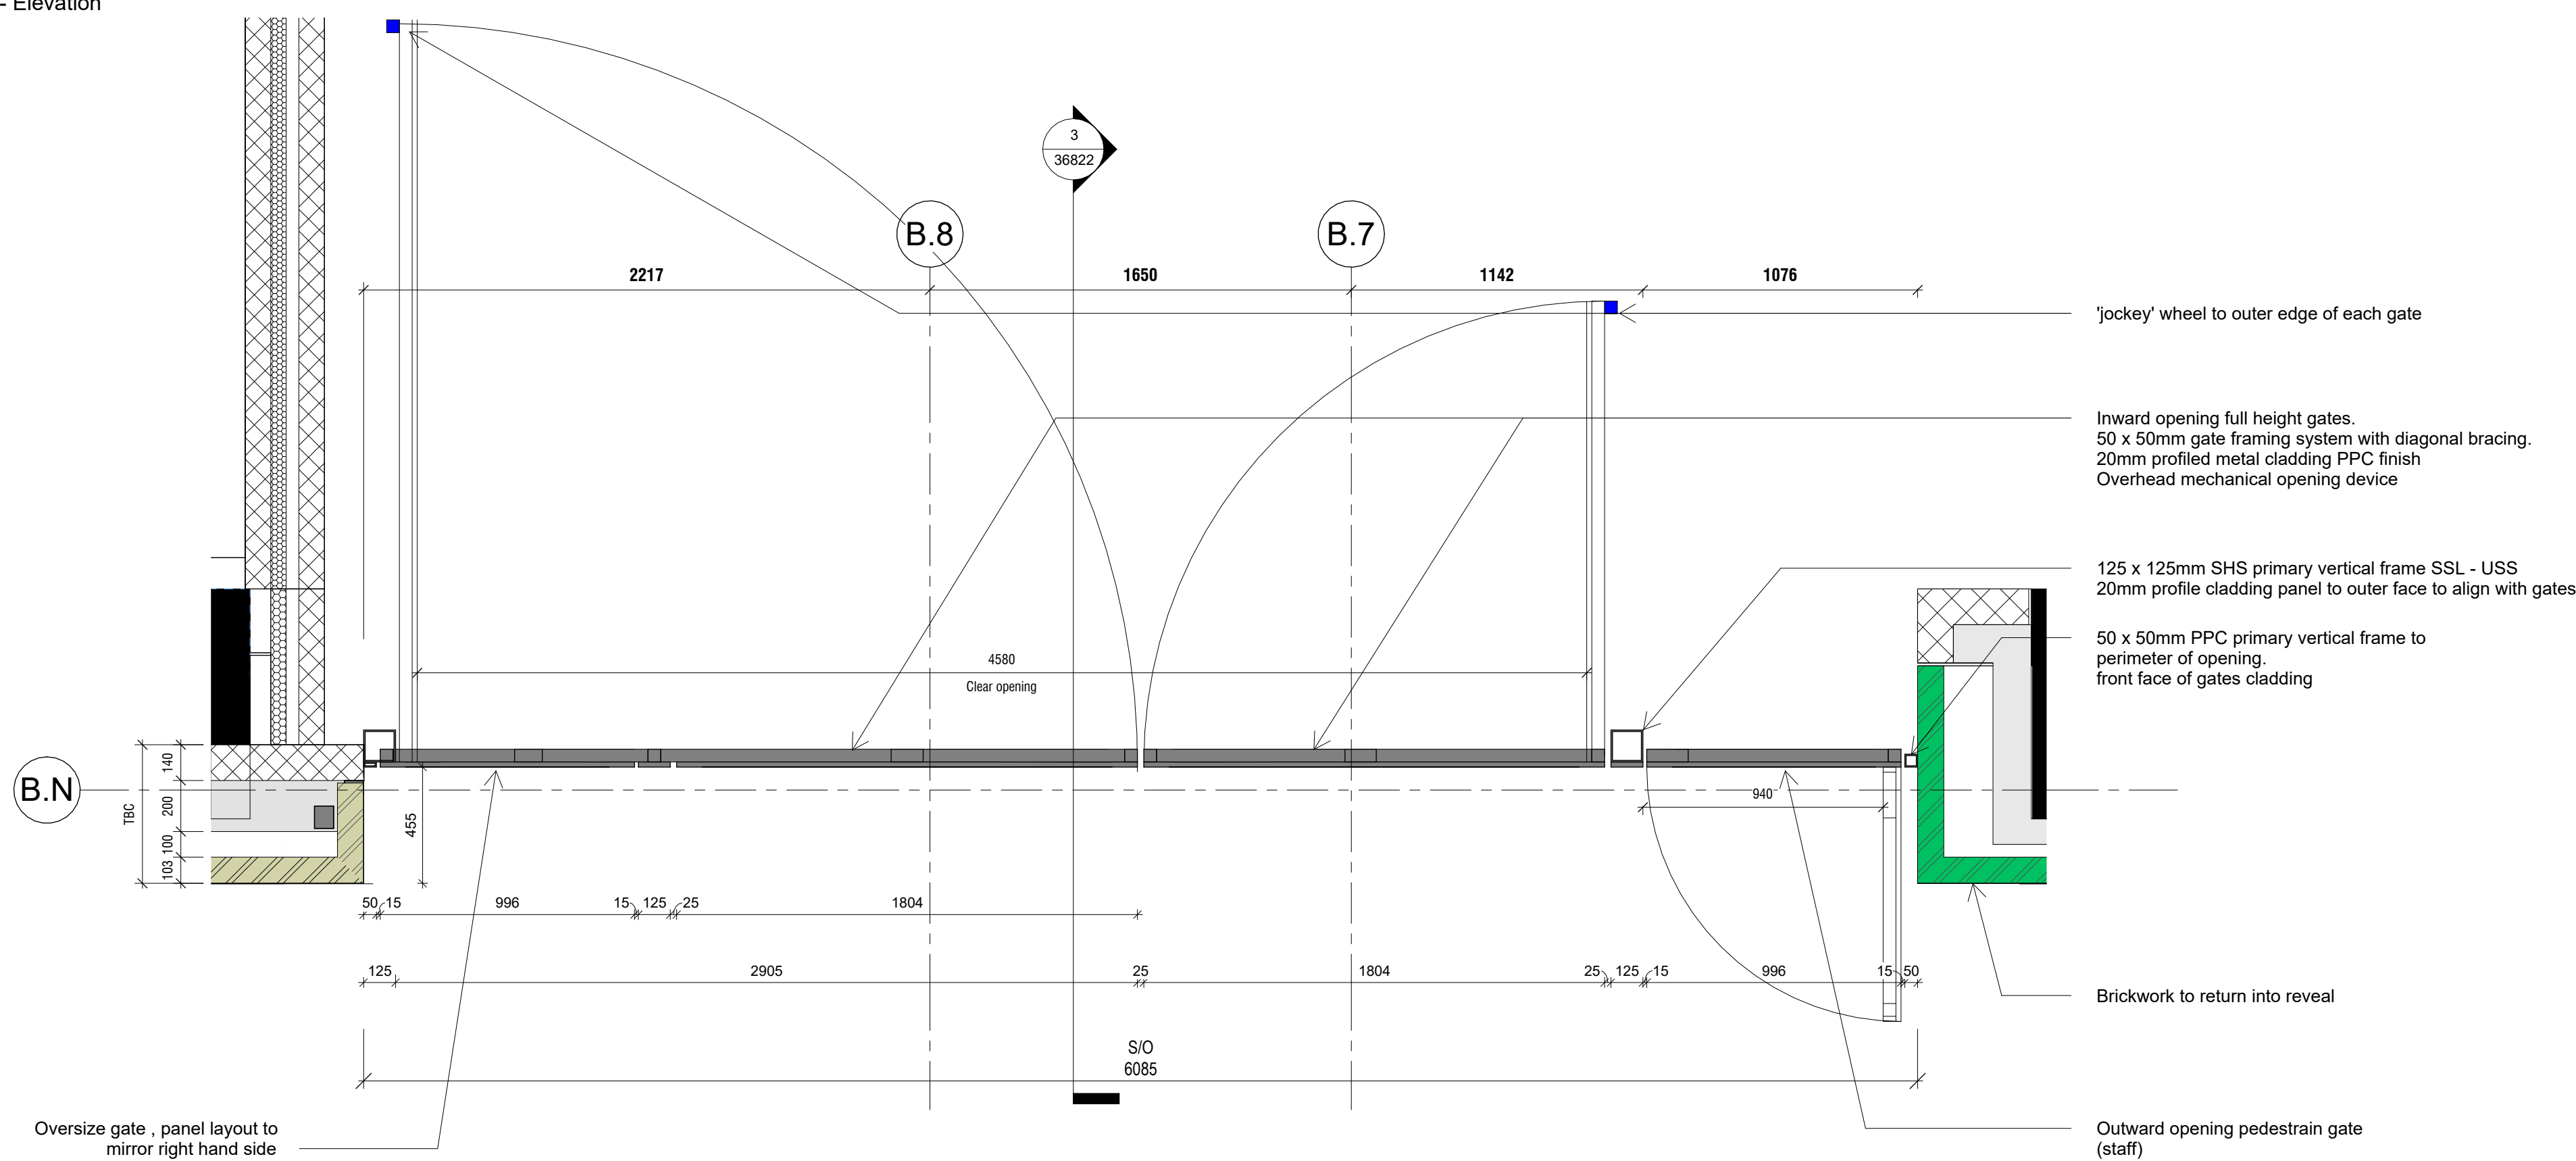

2 MW-B-03 - Plan  
1:20

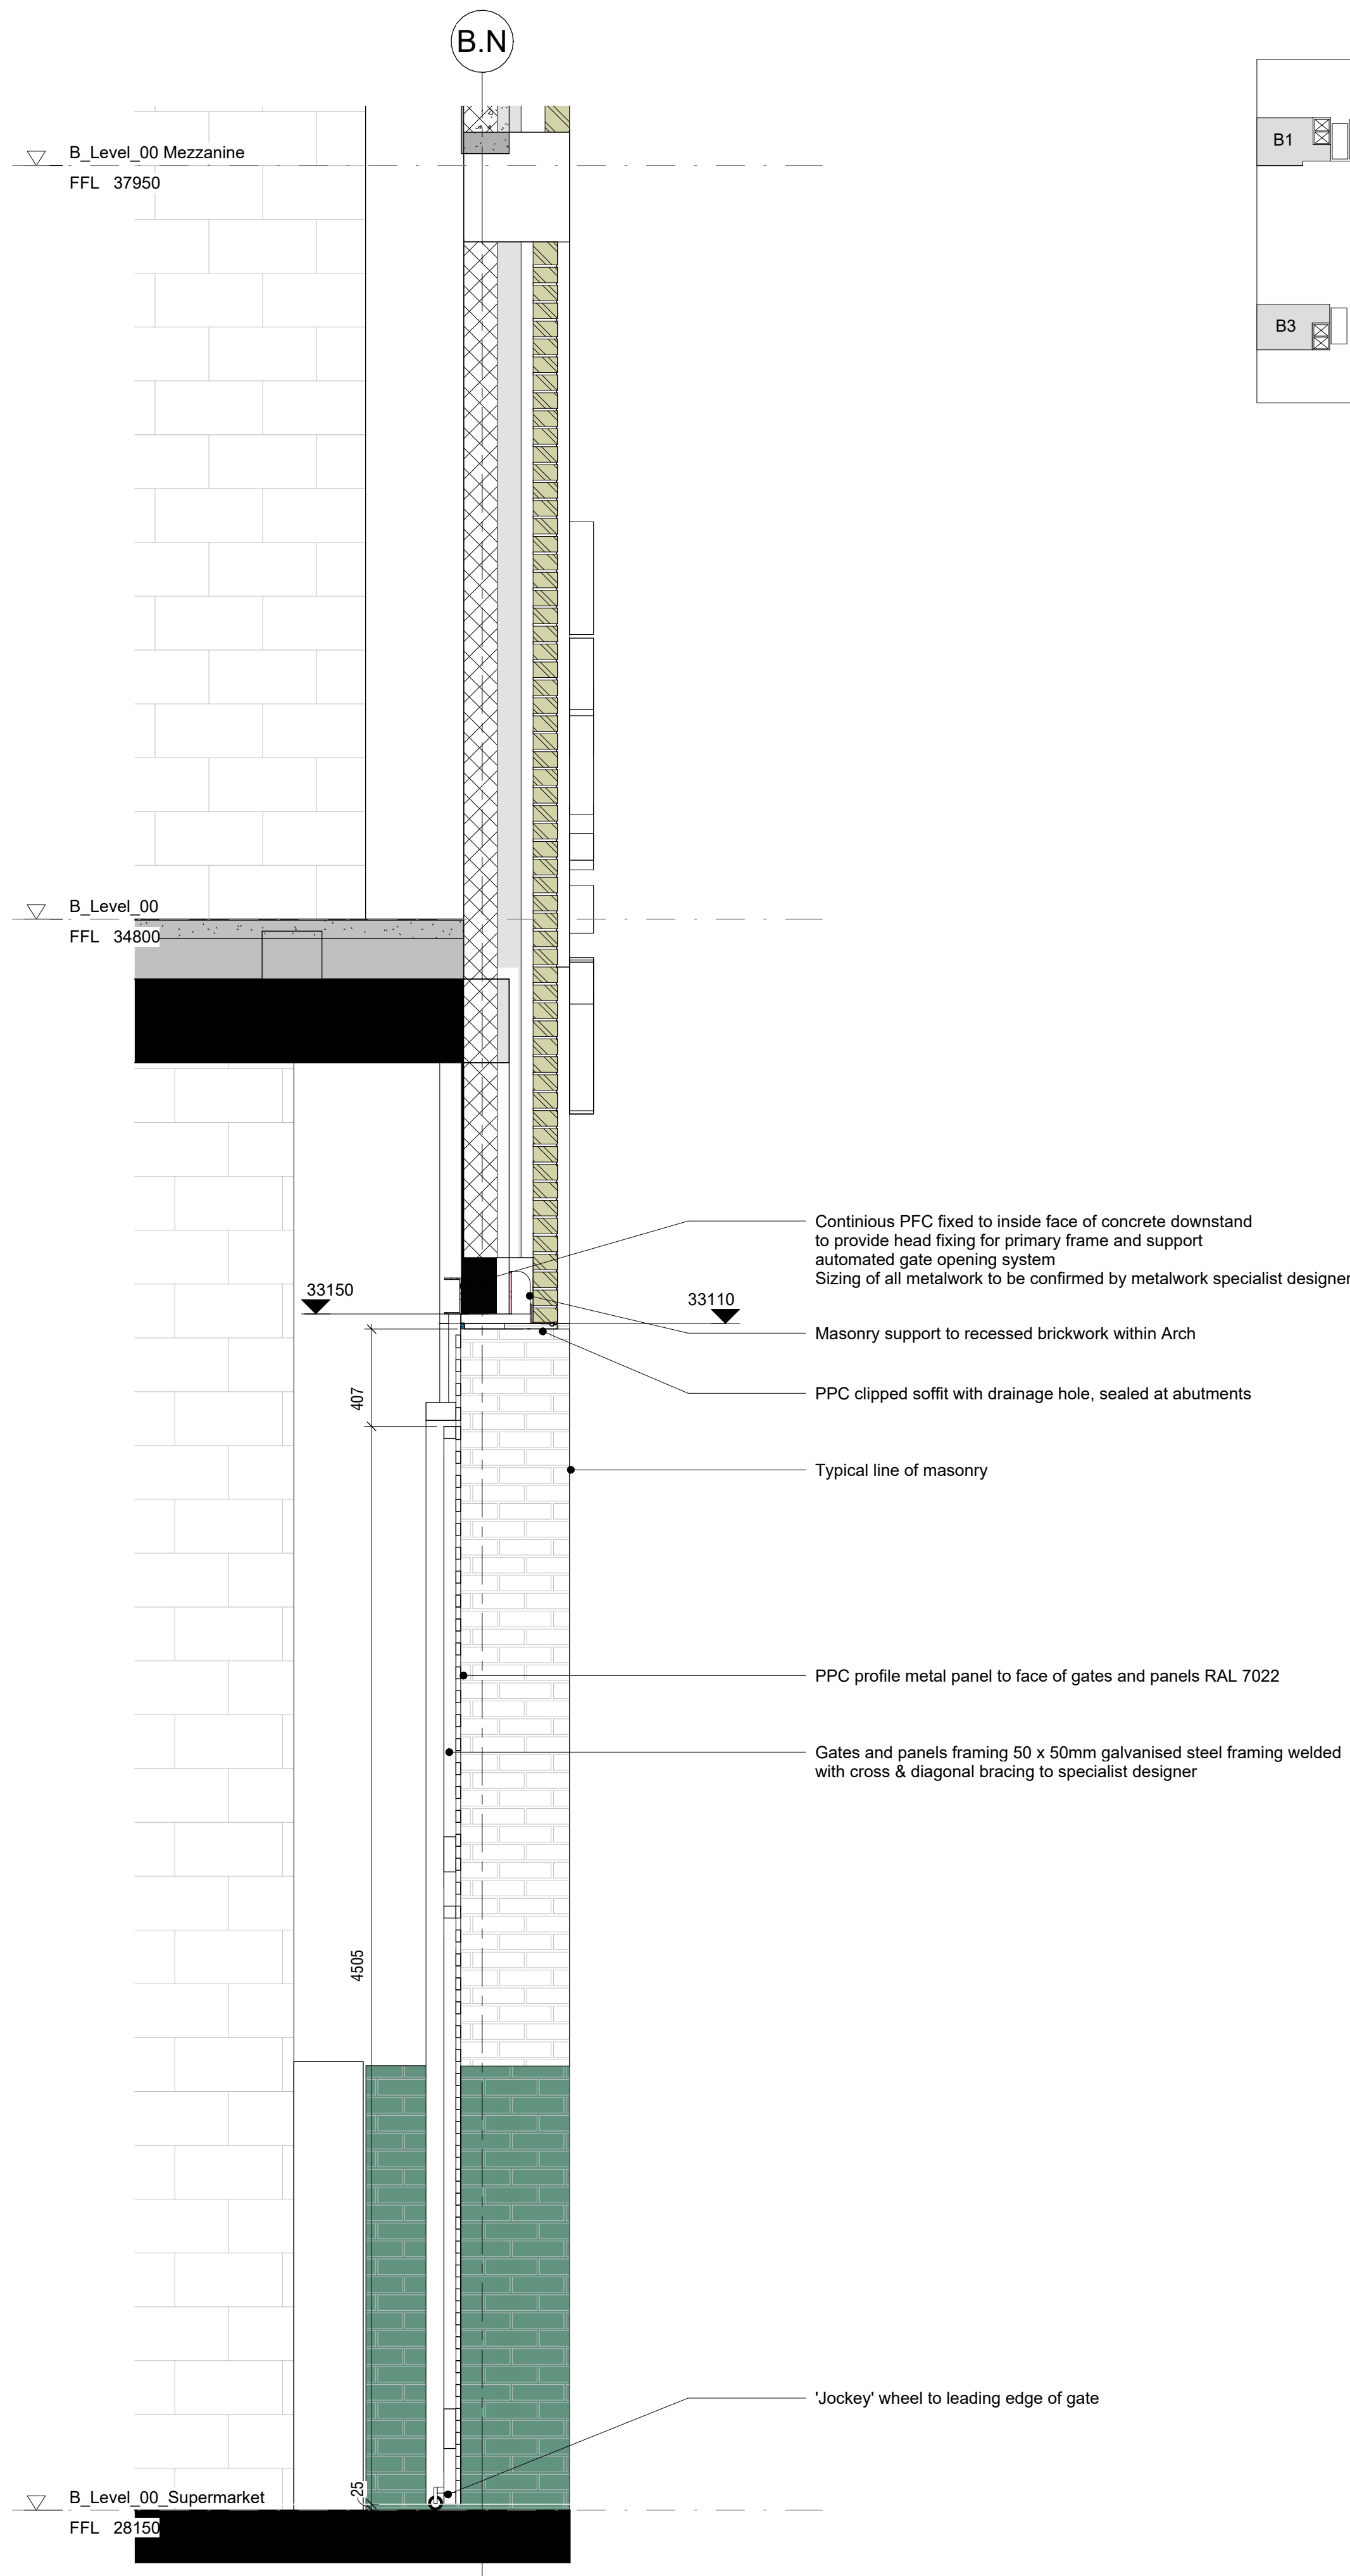

3 MW-B-3 - Section  
1:20

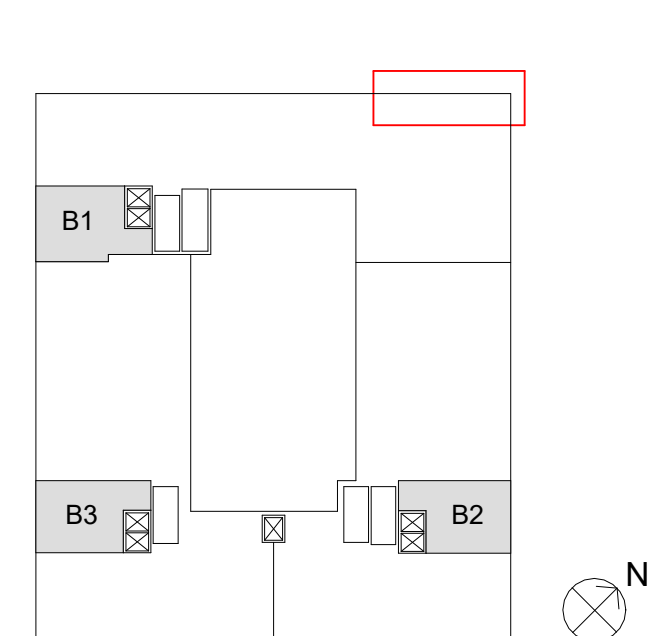

©Scott Browning Ltd  
This drawing is to be read in conjunction with all relevant architect's and other designers' drawings and associated specifications. Figured dimensions only are to be taken from this drawing. All dimensions are to be checked on site before any work is put in hand.

SCALE BAR: 1:20

- DRAWING SERIES**
- Series 00 - Accommodation Schedules
  - Series 00 - NBS Specification
  - Series 02 - Conveyance Plans
  - Series 03 - GA Plans, GA Setting out Plans & Marketing Plans
  - Series 04 - GA Sections
  - Series 05 - GA Elevations
  - Series 06 - Stage 2 Drawings
  - Series 07 - Bay Studies
  - Series 16 - Substructure
  - Series 20 - Superstructure
  - Series 21 - External Wall Types & Details
  - Series 22 - Internal Wall Types & Details
  - Series 24 - Staircases & Lifts
  - Series 27 - Roof Types & Details
  - Series 31 - Window & Doors Types, Details & Schedules
  - Series 35 - Reflected Ceiling Plans
  - Series 36 - Floor Types & Details
  - Series 36 - Balconies & External Metalwork
  - Series 40 - Internal Finishes
  - Series 43 - Floor Finishes
  - Series 60 - Electrical Plans
  - Series 67 - Fire Strategy Plans
  - Series 70 - Flat Type Layouts
  - Series 71 - Signage Plans
  - Series 73 - Kitchen Layouts & Schedules
  - Series 74 - Bathroom Layouts & Schedules
  - Series 79 - Residents Facilities
  - Series 82 - Commercial Units
  - Series 83 - Offices
  - Series 84 - Area Plans

**GENERAL NOTES**

**STRUCTURAL** - For design, detailing and setting out of structural elements refer to Structural Engineers drawings.

**SERVICES** - For design, detailing & setting out of services, including SVPS, Gas, Water, Electricals & Telecoms etc refer to M&E Engineers and Structural Engineers drawings.

All information on this drawing must be read in conjunction with relevant series and specifications.

Note: All steel sizes are indicative and subject to specialist design

Refer to:  
03 Series Cladding plans for scoping extent.  
35 Series SW soffit plans (insulation & metalwork),  
36 Series for metalwork details &  
DDU / ITS NBS specification for metalwork elements

|           |                         |          |       |         |
|-----------|-------------------------|----------|-------|---------|
| CO2       | Updated Metalwork Issue | 05.09.23 | CS    | JR      |
| CO1       | Construction Issue      | 30.06.23 | CS    | ACS     |
| Revisions | Description             | Date     | Drawn | Checked |

**design  
delivery  
unit**

77 Endell Street  
London WC2H 9DZ  
T +44 (0)20 7240 7766  
W designdeliveryunit.com

Clients Name  
**St George North London Limited**



Job Title  
**Camden Goods Yard**

Drawing Title  
**Building B Metalwork Morrisons Service Yard Entrance**

Scale  
**As indicated @A0**

Practice Project No.  
**20226**

Practice Project No. Originator Volume Level Type Rev Number  
**CGYB0-DDU-B0-ZZ-DR-A-36822**

Description  
**CONSTRUCTION**

Rev  
**CO2**

© Design Delivery 2023. All rights reserved. This drawing is the property of Design Delivery and is not to be copied, altered or reproduced in any way without the written authority of Design Delivery. Design Delivery is not responsible for any errors or omissions in this drawing.