


2 MWB2 - Plan
1:20

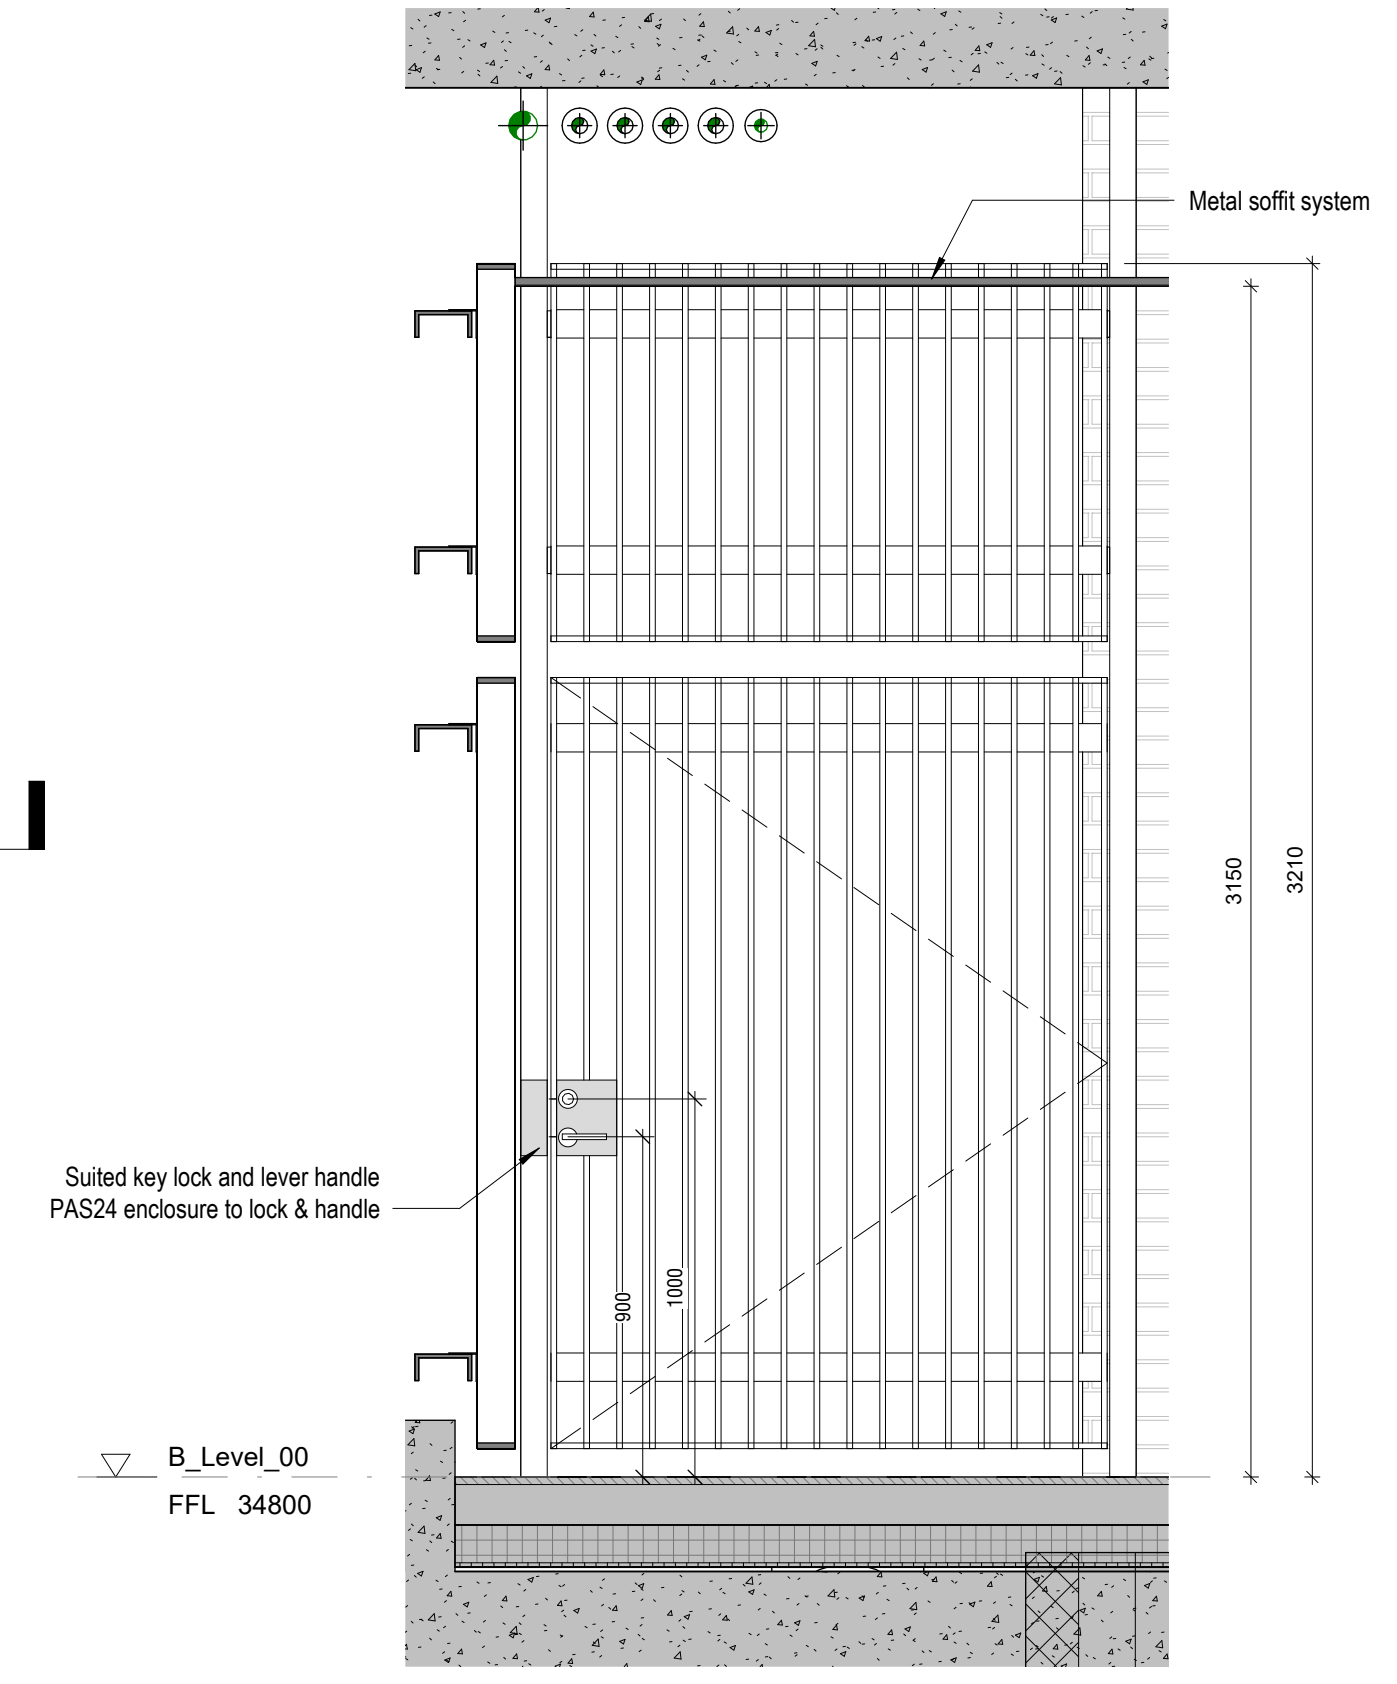

4 MWB2 - Section1
1:20

DRAWING SERIES

- Series 00 - Accommodation Schedules
- Series 00 - NBS Specification
- Series 02 - Conference Plans
- Series 03 - GA Plans, GA Setting out Plans & Marketing Plans
- Series 04 - GA Sections
- Series 05 - GA Elevations
- Series 06 - Stage 2 Drawings
- Series 07 - Sky Studies
- Series 08 - 3D Views
- Series 10 - Substructure
- Series 24 - Staircases & Lifts
- Series 21 - External Wall Types & Details
- Series 22 - Internal Wall Types & Details
- Series 23 - Window & Doors Types, Details & Schedules
- Series 35 - Reflected Ceiling Plans
- Series 35 - Floor Types & Details
- Series 36 - Balconies & External Metalwork
- Series 43 - Internal Finishes
- Series 43 - Floor Finishes
- Series 60 - Electrical Plans
- Series 67 - Fire Strategy Plans
- Series 70 - Flat Type Layouts
- Series 71 - Garage Plans
- Series 73 - Kitchen Layouts & Schedules
- Series 74 - Bathroom Layouts & Schedules
- Series 76 - Residents Facilities
- Series 82 - Commercial Units
- Series 83 - Offices
- Series 84 - Area Plans


GENERAL NOTES

STRUCTURAL - For design, detailing and setting out of structural elements refer to Structural Engineers drawings.


SERVICES - For design, detailing and setting out of services, including SVTs, Gas, Water, Electrical & Telecoms etc refer to M&E Engineers and Structural Engineers drawings.

All information on this drawing must be read in conjunction with relevant series and specifications.

Note: All steel sizes are indicative and subject to specialist design
 Refer to:
 03 Series Cladding plans for scoping extent.
 35 Series SW soffit plans (insulation & metalwork),
 36 Series for metalwork details &
 DDU / TFS NBS specification for metalwork elements

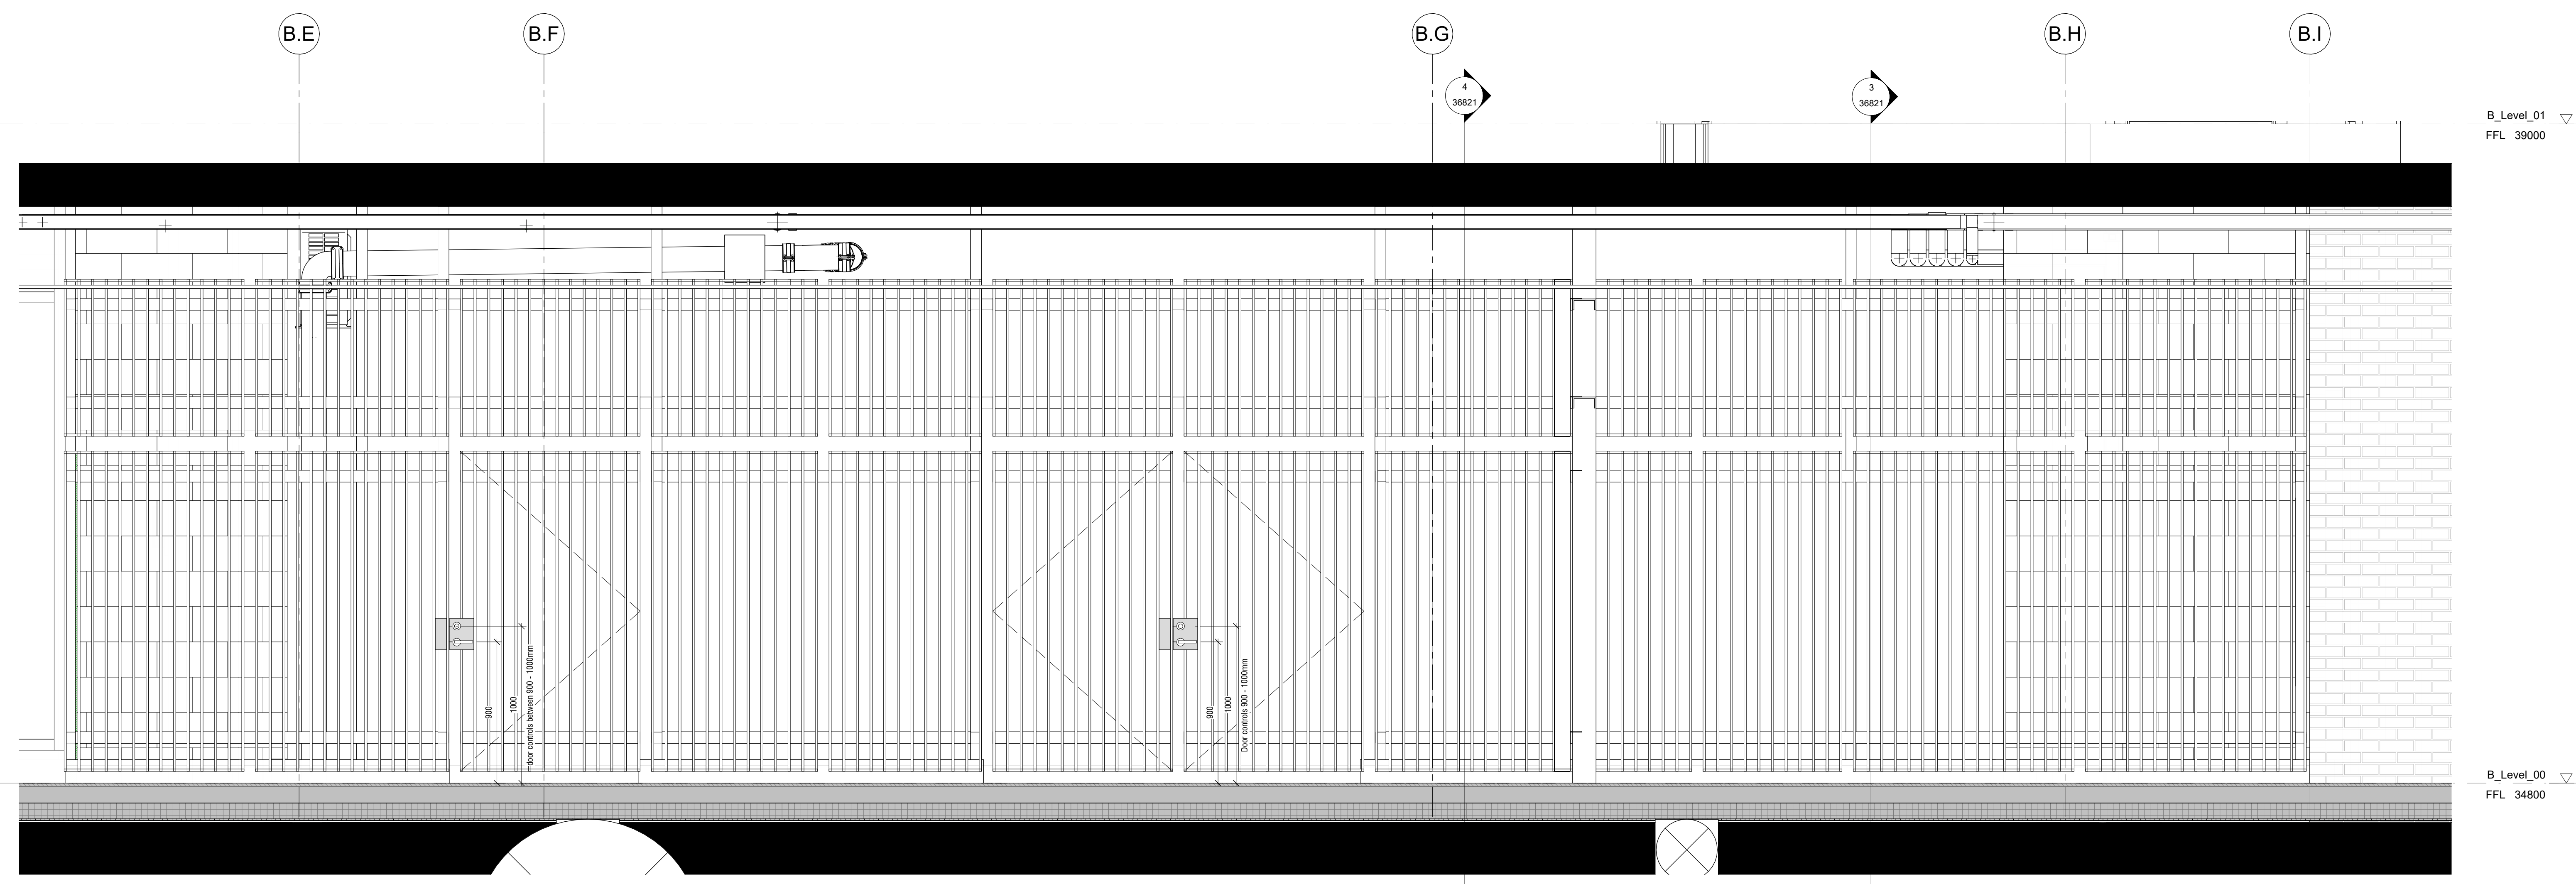

1 MWB2 - Elevation
1:20

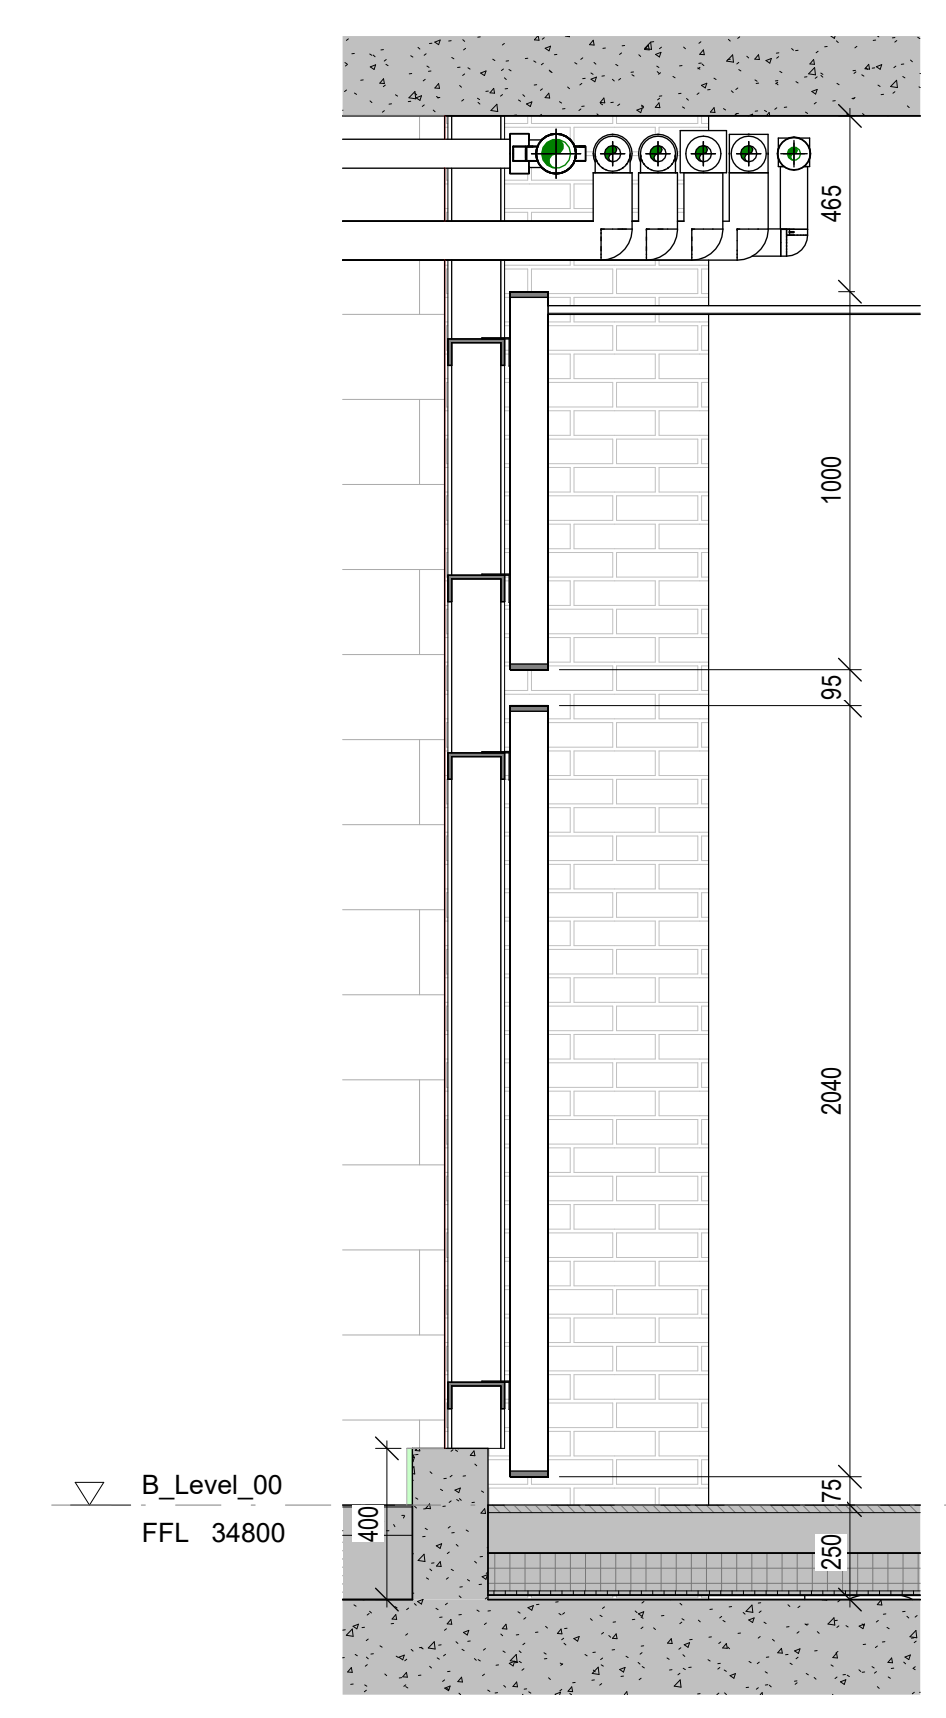

3 MWB2 - Section
1:20

Revision	Description	Date	Drawn	Checked
C02	Updated Metalwork Issue	05.09.23	CS	JR
C01	Construction Issue	30.06.23	CS	ACS

design delivery unit

77 Endell Street
 London WC2H 9DZ
 T +44 (0)20 7240 7766
 W designdeliveryunit.com

Client's Name
St George North London Limited



200 Tab
Camden Goods Yard

Drawing Title
Building B Metalwork Core B2

Scale
As indicated @A0 Project No. **20226**

Package Project No.	Original	Issue	Level	Type	Rev	Author
CGYB0-DDU-80-ZZ-DR-A-36821						

Drawn
CONSTRUCTION Rev
C02