




Core B3 Plantscreen - South-West Elevation
1 : 50

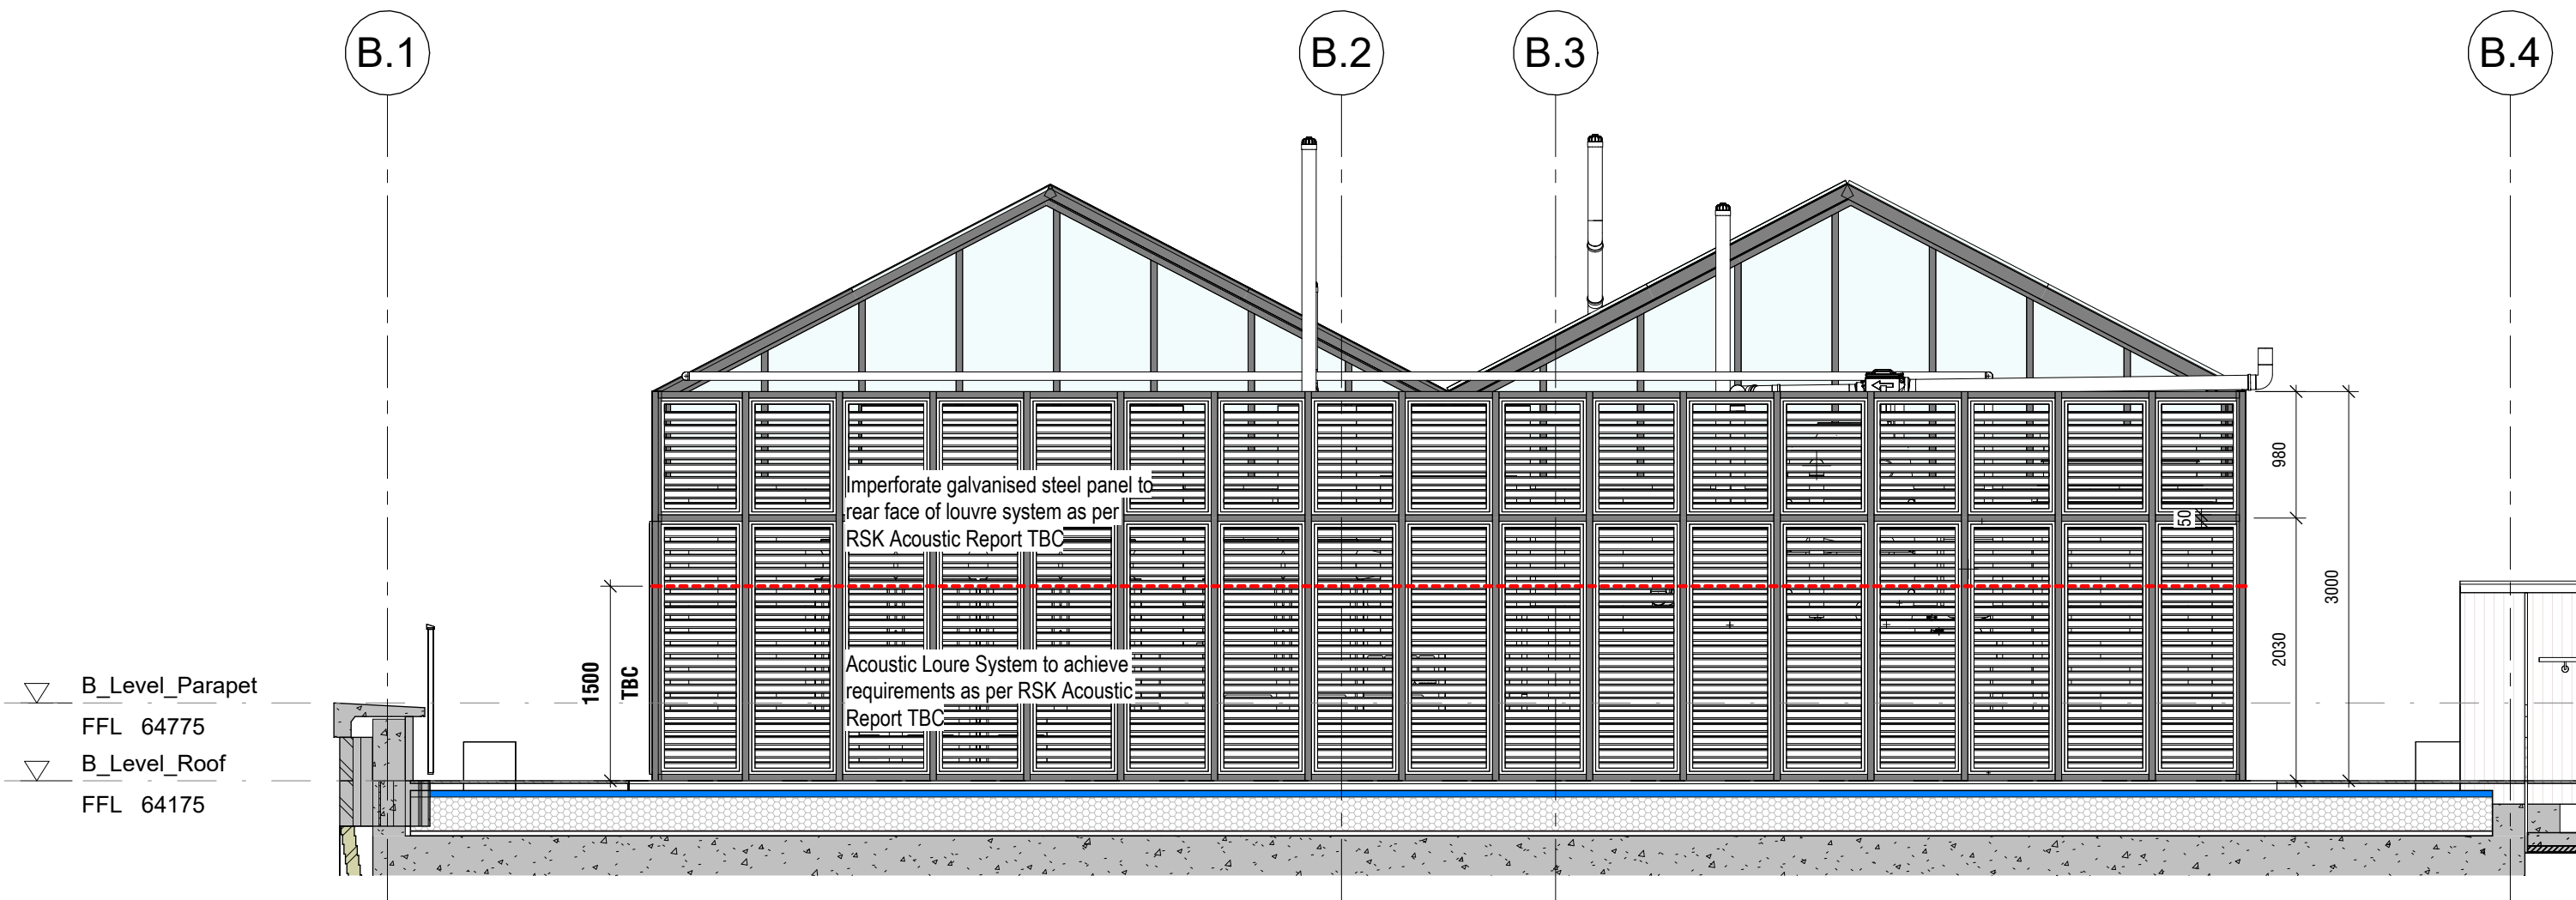

Core B3 Plantscreen - South Elevation
1 : 50

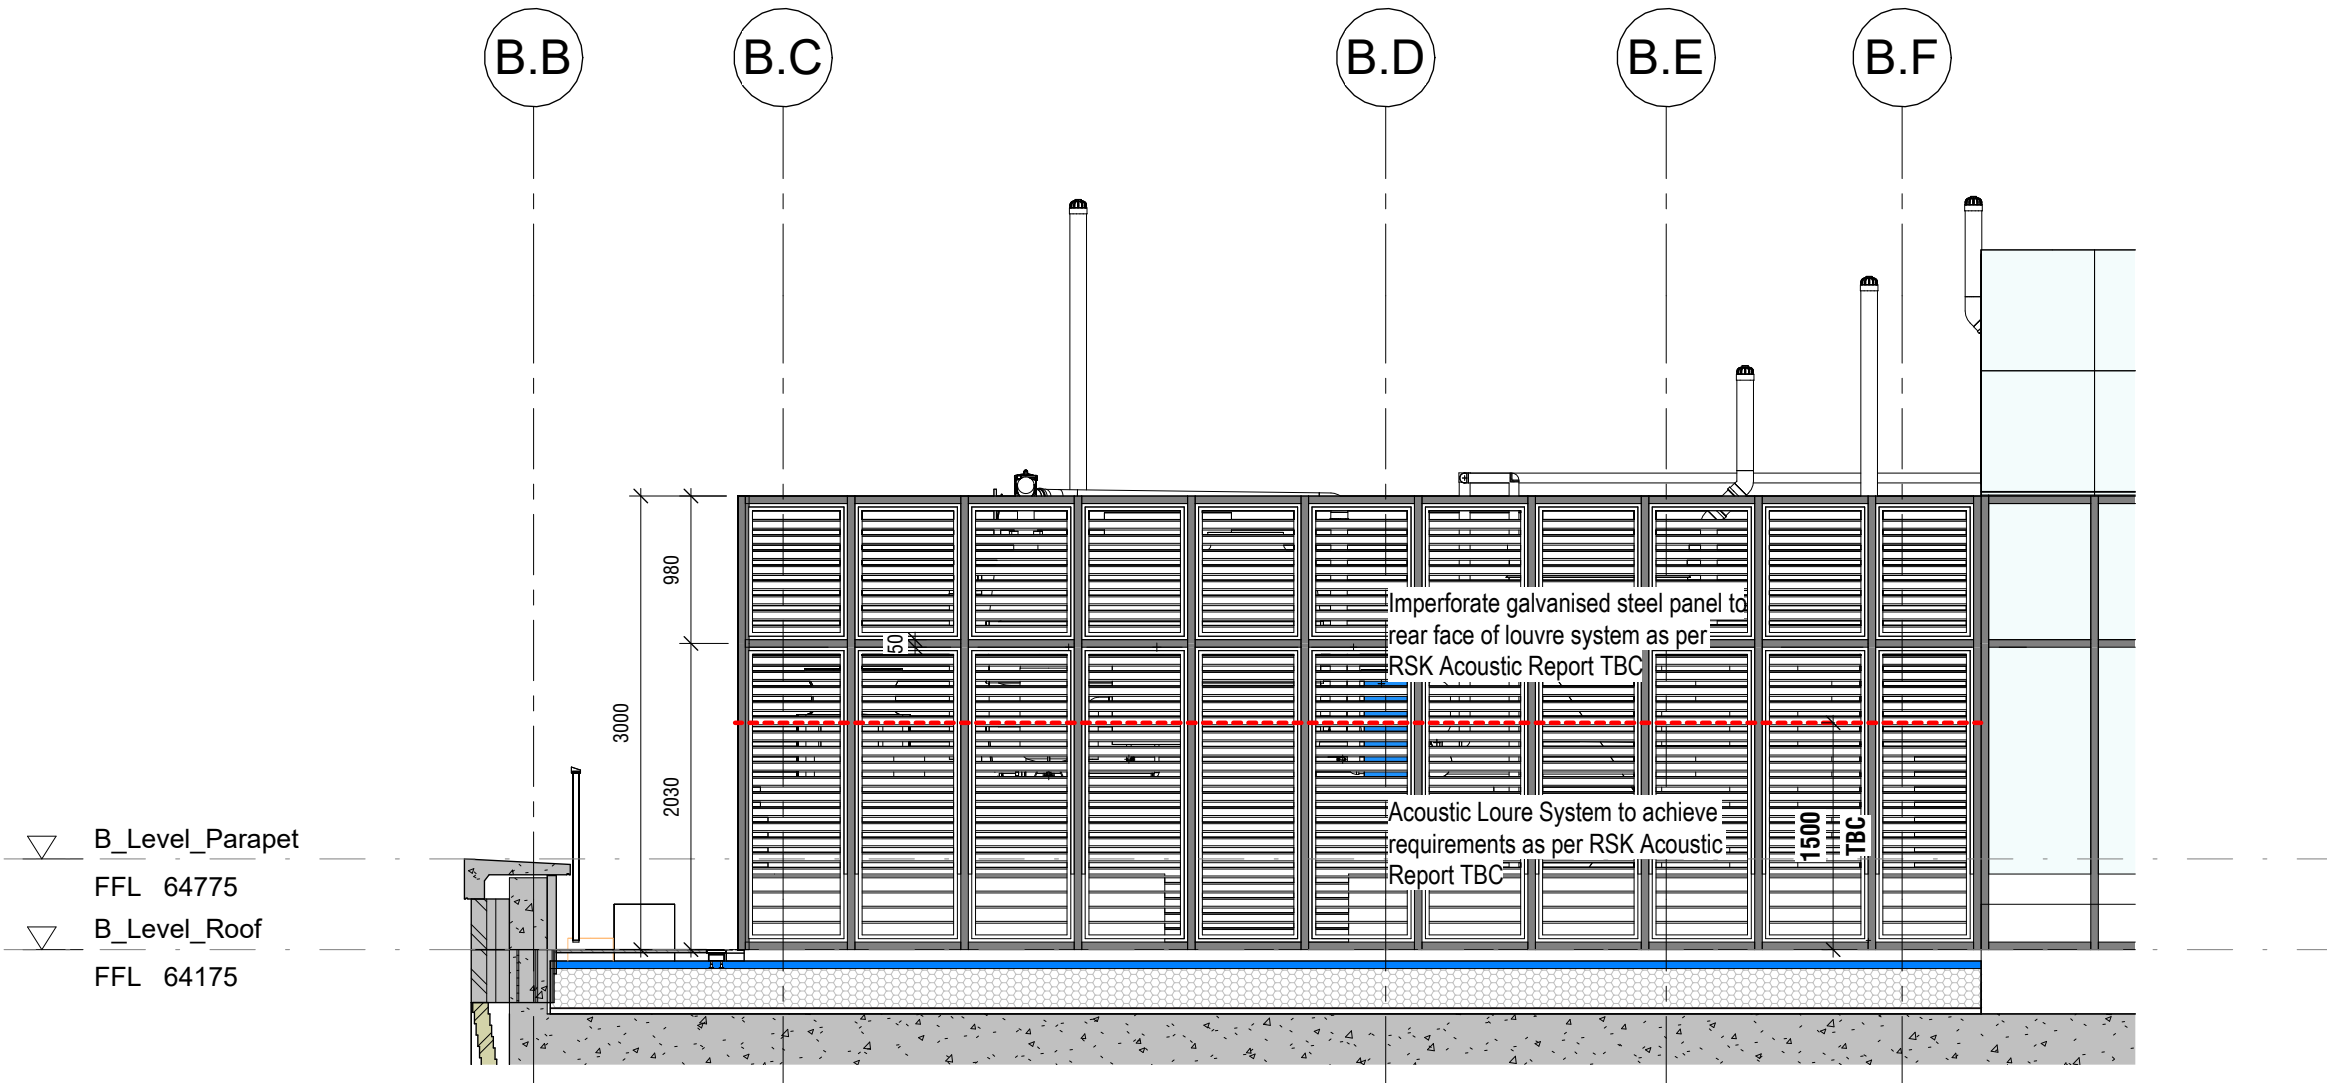

Core B3 Plantscreen - South-East Elevation
1 : 50

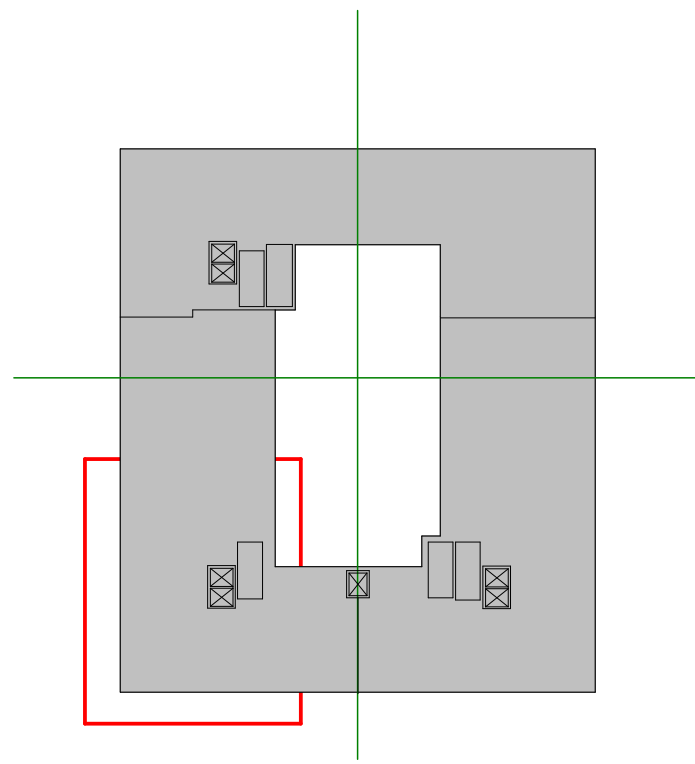

©Design Delivery Unit Limited
This drawing is to be read in conjunction with all relevant architect's and other designers' drawings and associated specifications. Figured dimensions only are to be taken from this drawing. All dimensions are to be checked on site before any work is put in hand.

metres 1 2 3 4 5
SCALE BAR: 1:50

- DRAWING SERIES**
- Series 00 - Accommodation Schedules
 - Series 00 - NBS Specification
 - Series 02 - Conveyance Plans
 - Series 03 - GA Plans, GA Setting out Plans & Marketing Plans
 - Series 04 - GA Sections
 - Series 05 - GA Elevations
 - Series 06 - Stage 2 Drawings
 - Series 07 - Bay Studies
 - Series 09 - 3D Views
 - Series 16 - Substructure
 - Series 20 - Superstructure
 - Series 21 - External Wall Types & Details
 - Series 22 - Internal Wall Types & Details
 - Series 23 - Floor Types & Details
 - Series 24 - Staircases & Lifts
 - Series 27 - Roof Types & Details
 - Series 31 - Window & Doors Types, Details & Schedules
 - Series 35 - Reflected Ceiling Plans
 - Series 36 - Balconies & External Metalwork
 - Series 40 - Internal Finishes
 - Series 43 - Floor Finishes
 - Series 60 - Electrical Plans
 - Series 67 - Fire Strategy Plans
 - Series 70 - Flat Type Layouts
 - Series 71 - Signage Plans
 - Series 73 - Kitchen Layouts & Schedules
 - Series 74 - Bathroom Layouts & Schedules
 - Series 79 - Residents Facilities
 - Series 82 - Commercial Units
 - Series 83 - Offices

- GENERAL NOTES**
- SETTING OUT - DO NOT SCALE** from this drawing, use figured dimensions ONLY. If in doubt, ASK! Dimensions are shown to structural face generally, or to finished face of ducts and lining. All dimensions are shown in millimeters unless otherwise indicated. Angular dimensions are shown in decimal degrees to the nearest whole degree. Where items are to be fabricated off-site, site dimensions are to be used and confirmed prior to ordering or manufacturing.
- STRUCTURAL** - For design, detailing and setting out of structural elements refer to Structural Engineers drawings.
- SERVICES** - For design, detailing & setting out of services, including SVP's, Gas, Water, Electrics & Telecoms etc refer to M&E Engineers and Structural Engineers drawings.
- All information on this drawing must be read in conjunction with relevant series and specifications.

Revision	Description	Date	Drawn	Checked
C01	Construction Issue	30.06.23	CS	ACS

design
delivery
unit

77 Endell Street
London WC2H 9DZ
T +44 (0)20 7240 7766
W designdeliveryunit.com

Client's Name
St George North London Limited



Job Title
Camden Goods Yard

Drawing Title
Building B Core B3 Roof Plant Louvre
Screen - Elevations

Scale
1 : 50 @A1

Practice Project No.
20226

Client Project Code
CGYB0-DDU-B0-ZZ-DR-A-36813

Description	Rev
CONSTRUCTION	C01