

Note:

- The colours shown on soffits and decking are indicatively for clarity of scope.
- Contractor to set out all decking boards, final decking board to be no less than 85mm, extruded deck receiver to be utilised as appropriate.
- Aluminum soffits to be set out to allow 20mm perimeter shadow gap and 13mm between panelling.
- Dimensions shown approximate only, subject to site dimensions.
- ** denotes critical dimension

metres 1 2 3 4 5
 SCALE BAR: 1:50

DRAWING SERIES

- Series 00 - Accommodation Schedules
- Series 01 - NBS Specification
- Series 02 - Conveyance Plans
- Series 03 - GA Plans, GA Setting out Plans & Marketing Plans
- Series 04 - GA Sections
- Series 05 - GA Elevations
- Series 06 - Stage 2 Drawings
- Series 07 - Bay Studies
- Series 09 - 3D Views
- Series 16 - Substructure
- Series 20 - Superstructure
- Series 21 - External Wall Types & Details
- Series 22 - Internal Wall Types & Details
- Series 23 - Floor Types & Details
- Series 24 - Staircases & Lifts
- Series 27 - Roof Types & Details
- Series 31 - Window & Doors Types, Details & Schedules
- Series 35 - Reflected Ceiling Plans
- Series 36 - Balconies & External Metalwork
- Series 40 - Internal Finishes
- Series 43 - Floor Finishes
- Series 60 - Electrical Plans
- Series 67 - Fire Strategy Plans
- Series 70 - Flat Type Layouts
- Series 71 - Signage Plans
- Series 73 - Kitchen Layouts & Schedules
- Series 74 - Bathroom Layouts & Schedules
- Series 79 - Residents Facilities
- Series 82 - Commercial Units
- Series 83 - Offices

Refer to:
 03 Series Cladding plans for scoping extent,
 35 Series SW soffit plans (insulation & metalwork),
 36 Series for metalwork details &
 DDU / TFS NBS specification for metalwork elements

Revision	Description	Date	Drawn	Checked
C02	Updated Metalwork Issue	05.09.23	CS	JR
C01	Construction Issue	30.06.23	CS	ACS



77 Endell Street
 London WC2H 9DZ
 T +44 (0)20 7240 7766
 W designdeliveryunit.com

Client's Name
St George North London Limited



Job Title
Camden Goods Yard


Drawing Title
Building B Aluminium Decking & Soffit Sheet3

Scale
As indicated @A1


Practice Project No.
20226

Client Project Code
CGYB0-DDU-B0-ZZ-DR-A-36623


Description	Rev
CONSTRUCTION	C02

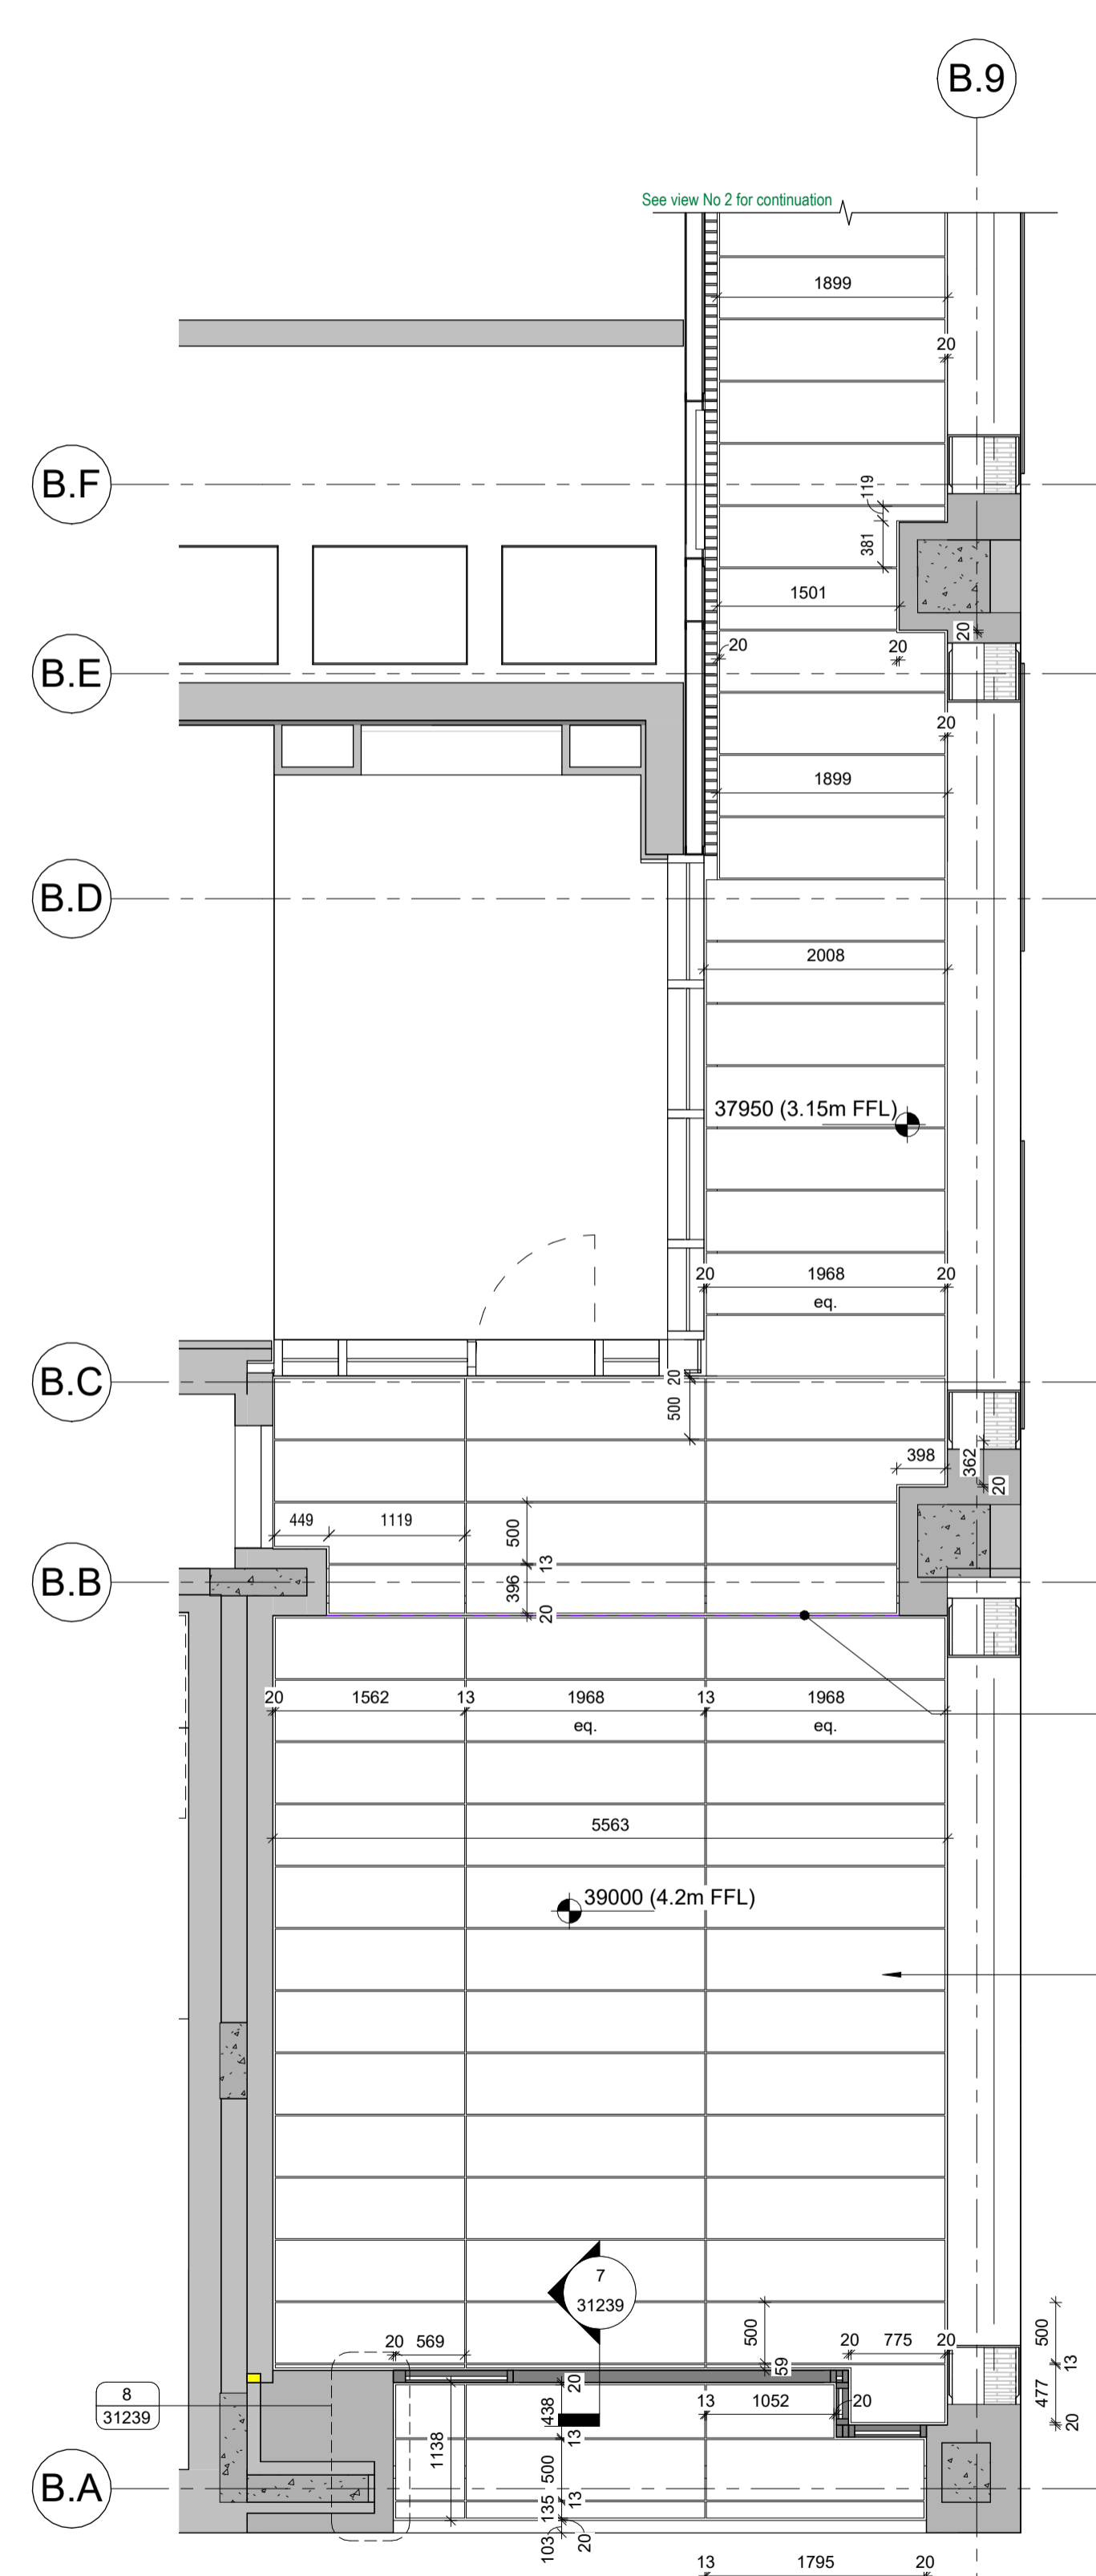

1 Building B – Level 00 – Entrance Terrace – RCP (1/3)
 1 : 50

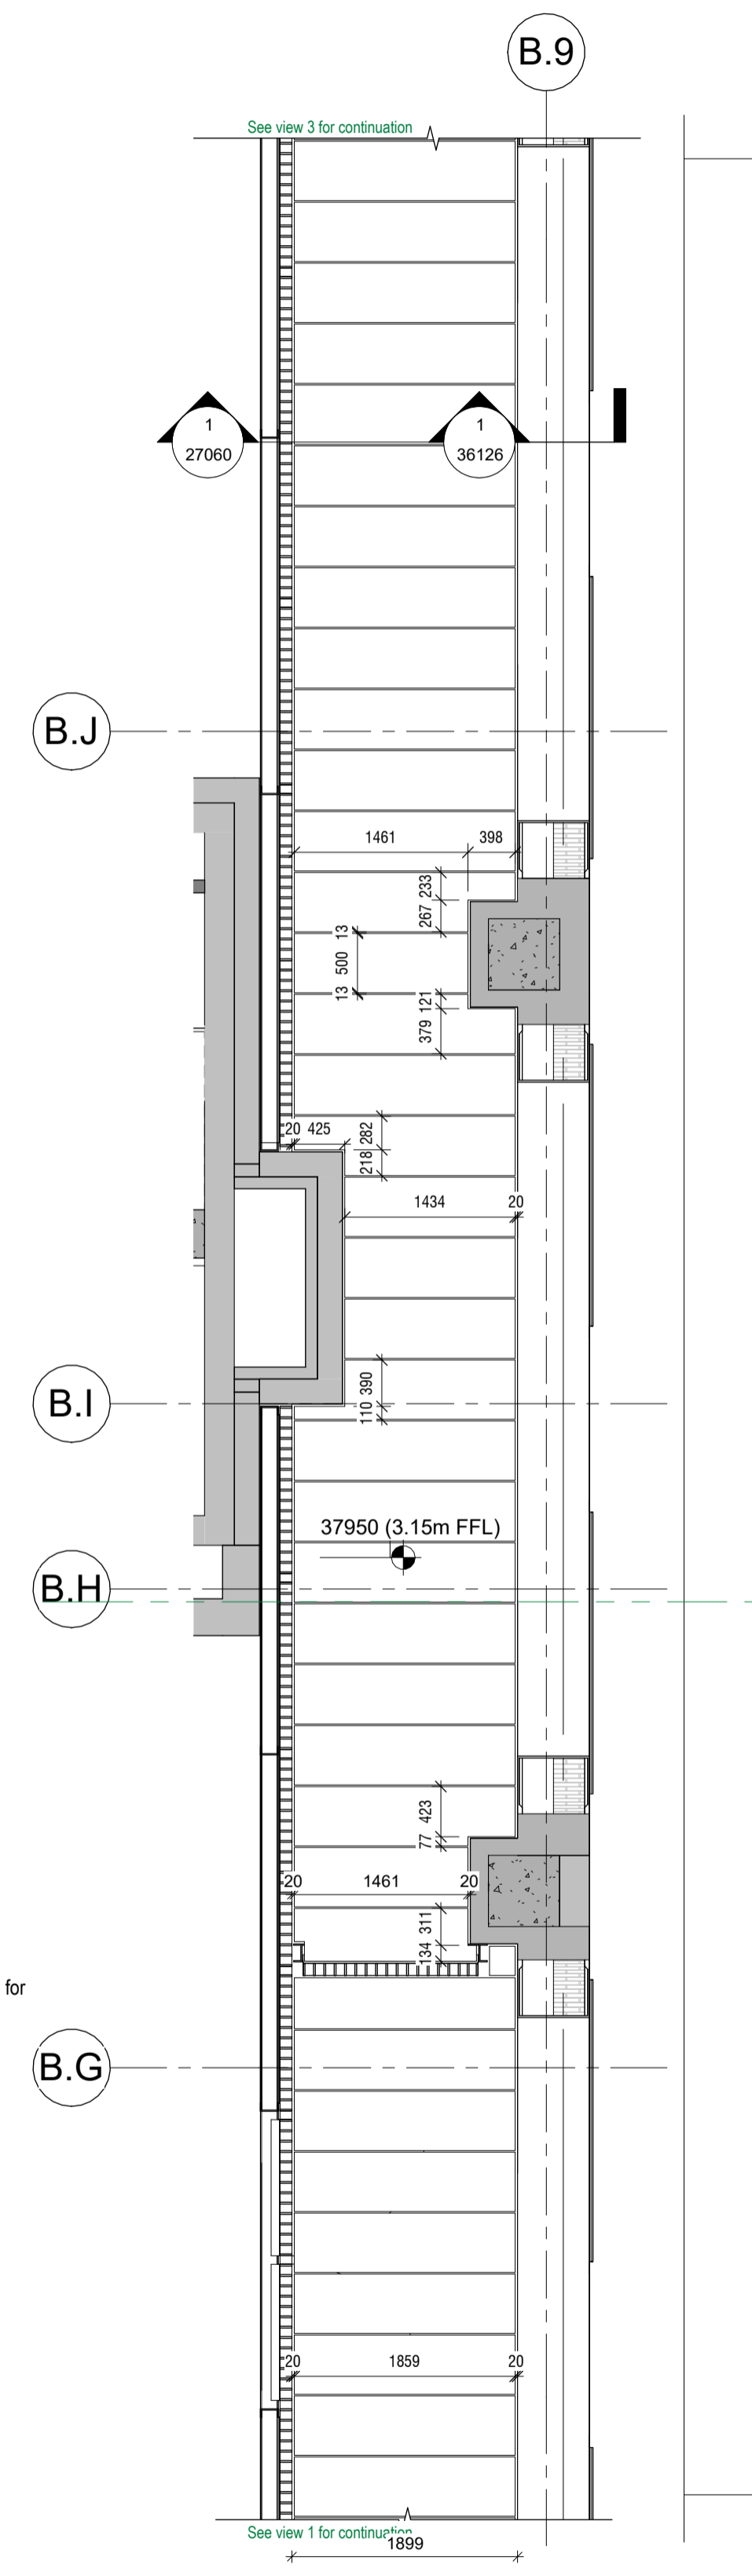

2 Building B – Level 00 – Entrance Terrace – RCP (2/3)
 1 : 50

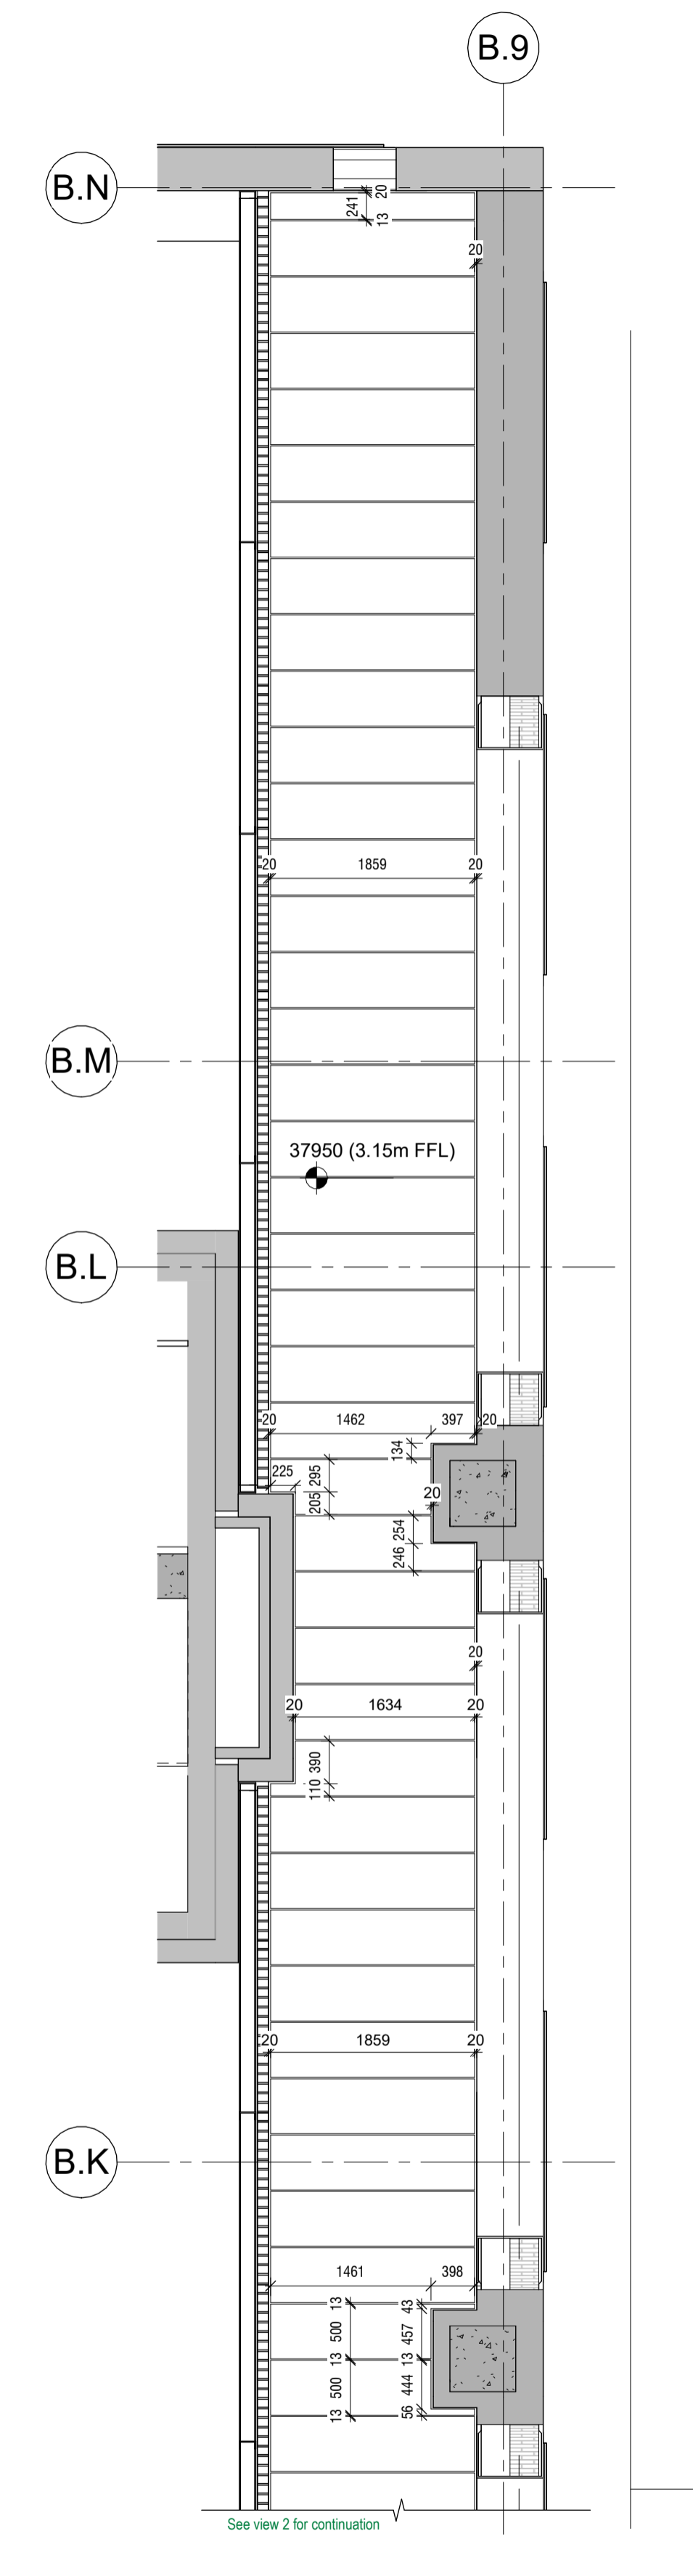

3 Building B – Level 00 – Entrance Terrace – RCP (3/3)
 1 : 50