

DETAILS APPLICABLE FOR Building B  
APPLICABLE TO BALCONY TYPE BTB2  
APPLICABLE FOR BTF9 FOR DEEP REVEAL (900MM) DETAIL ONLY


Brickwork and Blockwork

For elements of facade refer to hyperlinks with specification document:


CGY00-PTA-XXX-XX-SP-AR-00010

Ss\_25\_13\_50\_51


00 - Masonry wall leaf systems Type A - Facing Brickwork

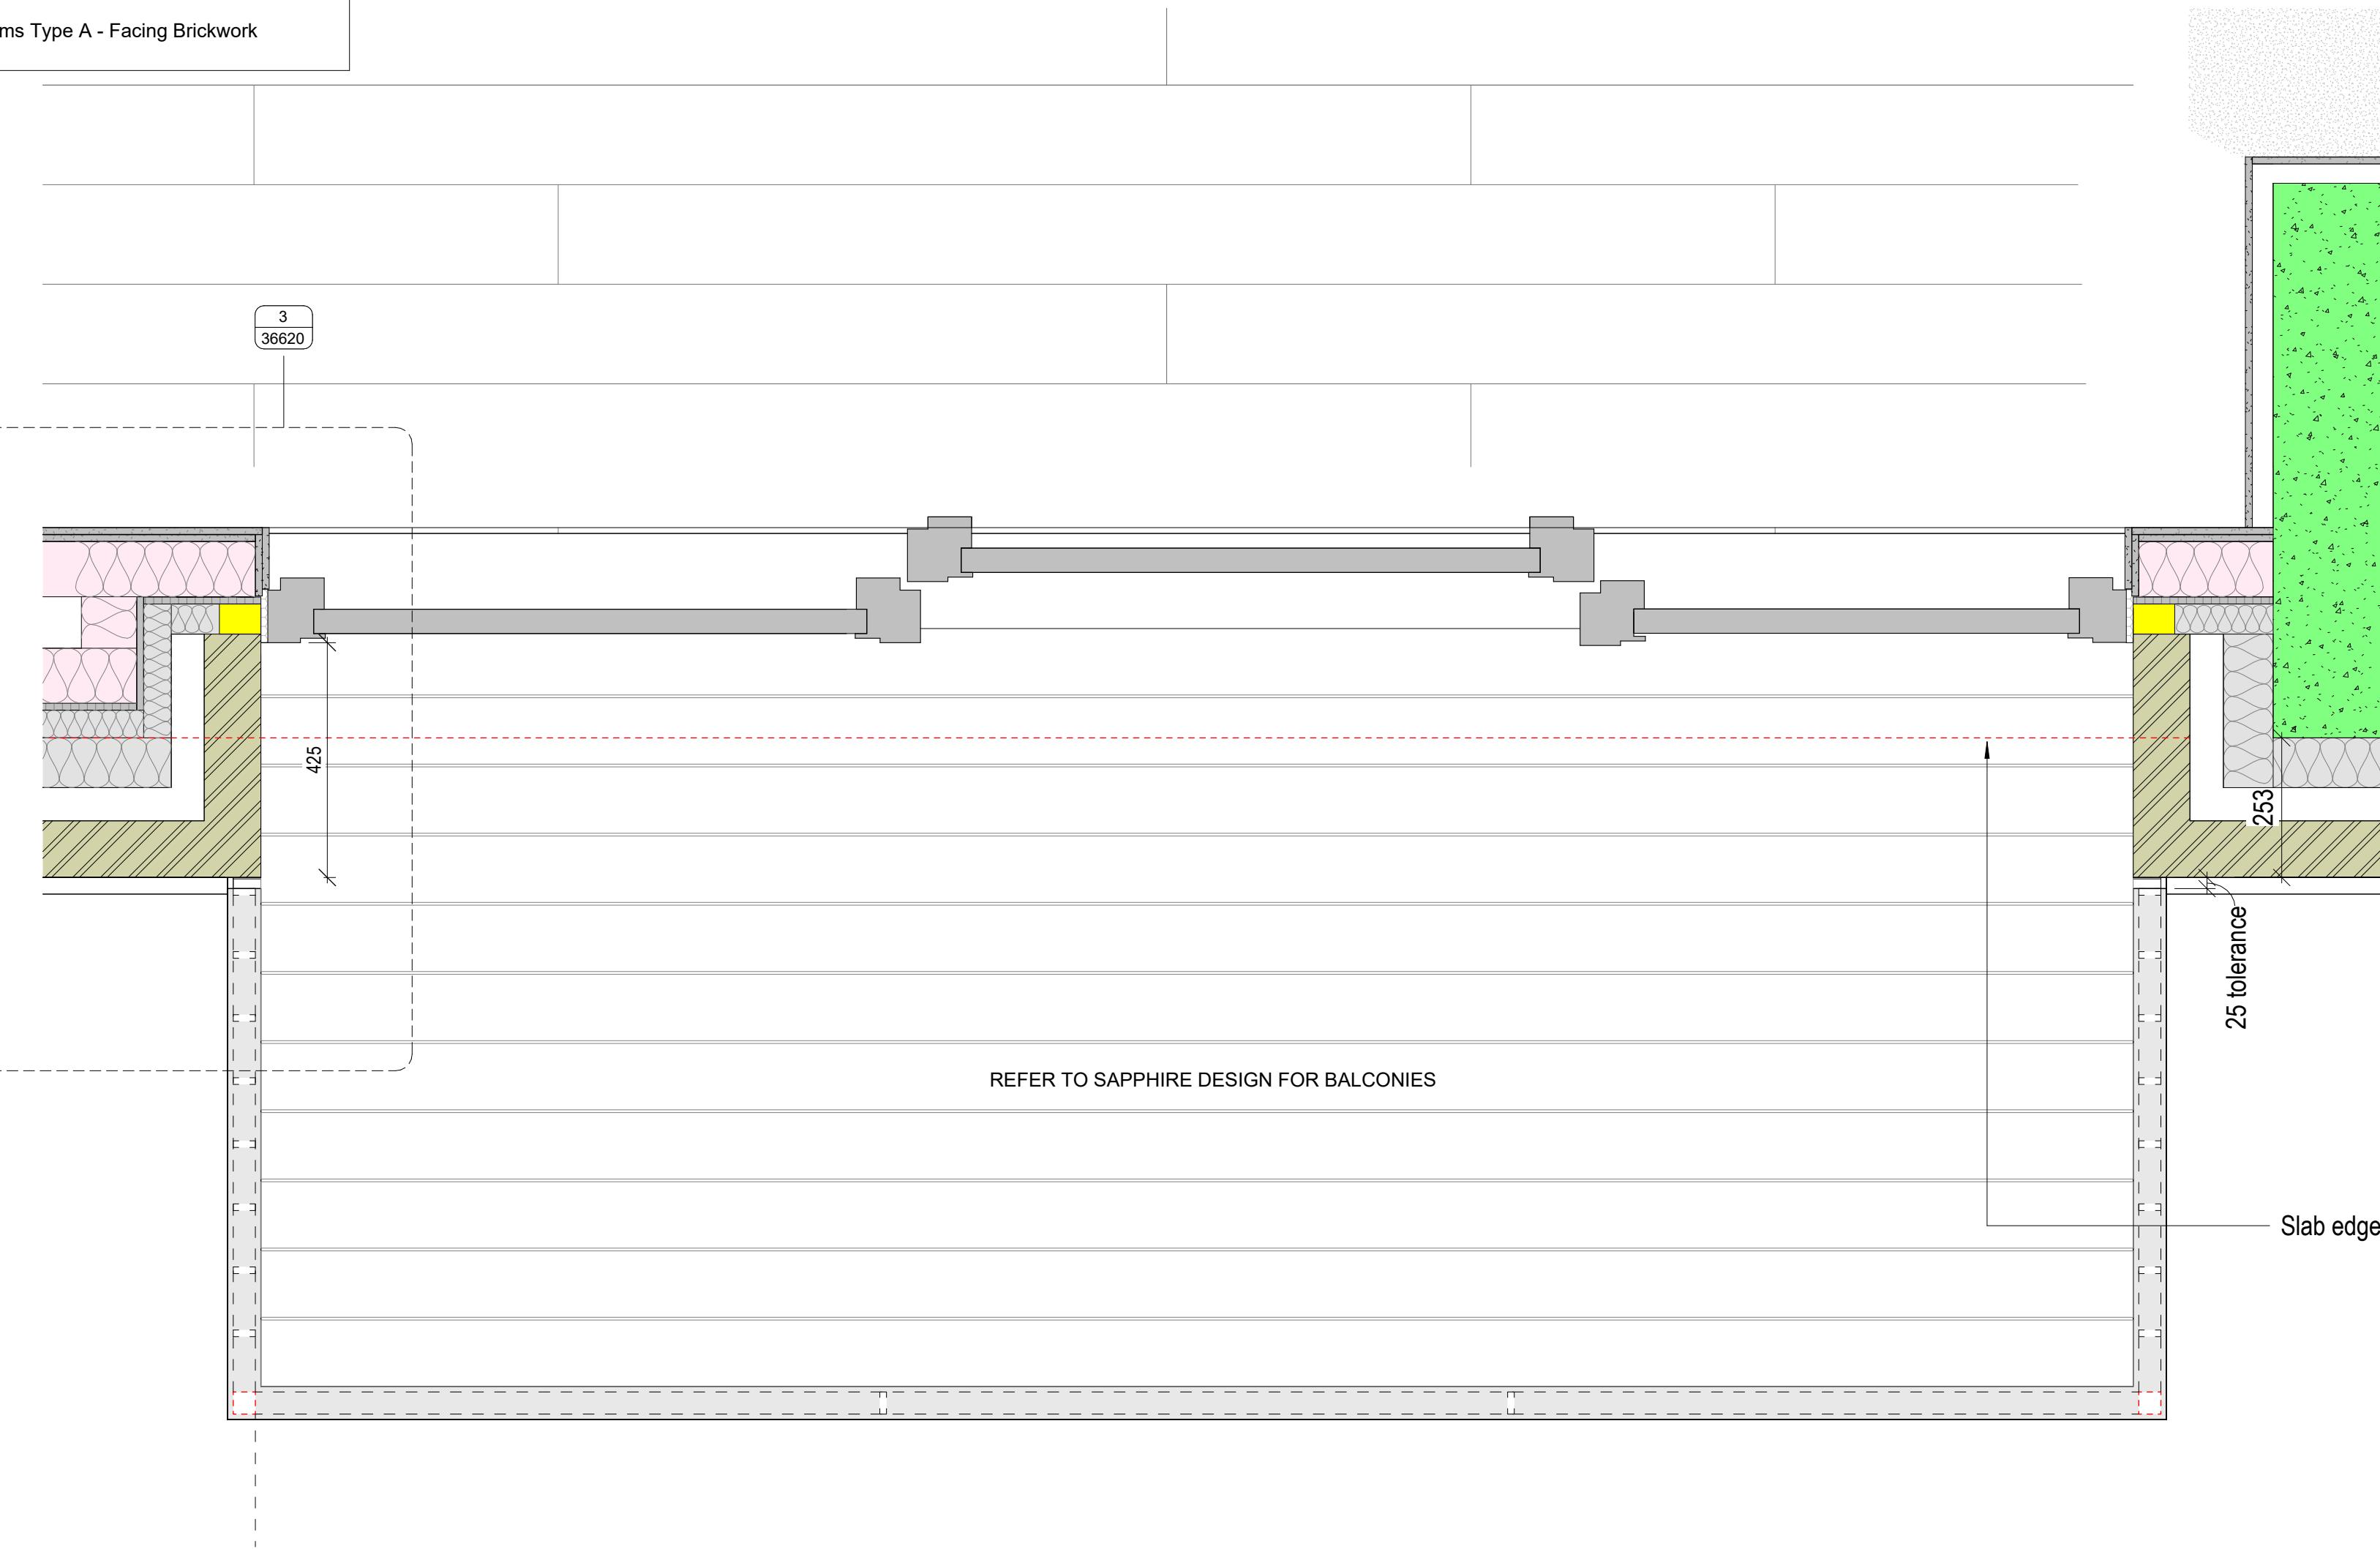

1 Balcony plan - Flat metal front panel  
1 : 10

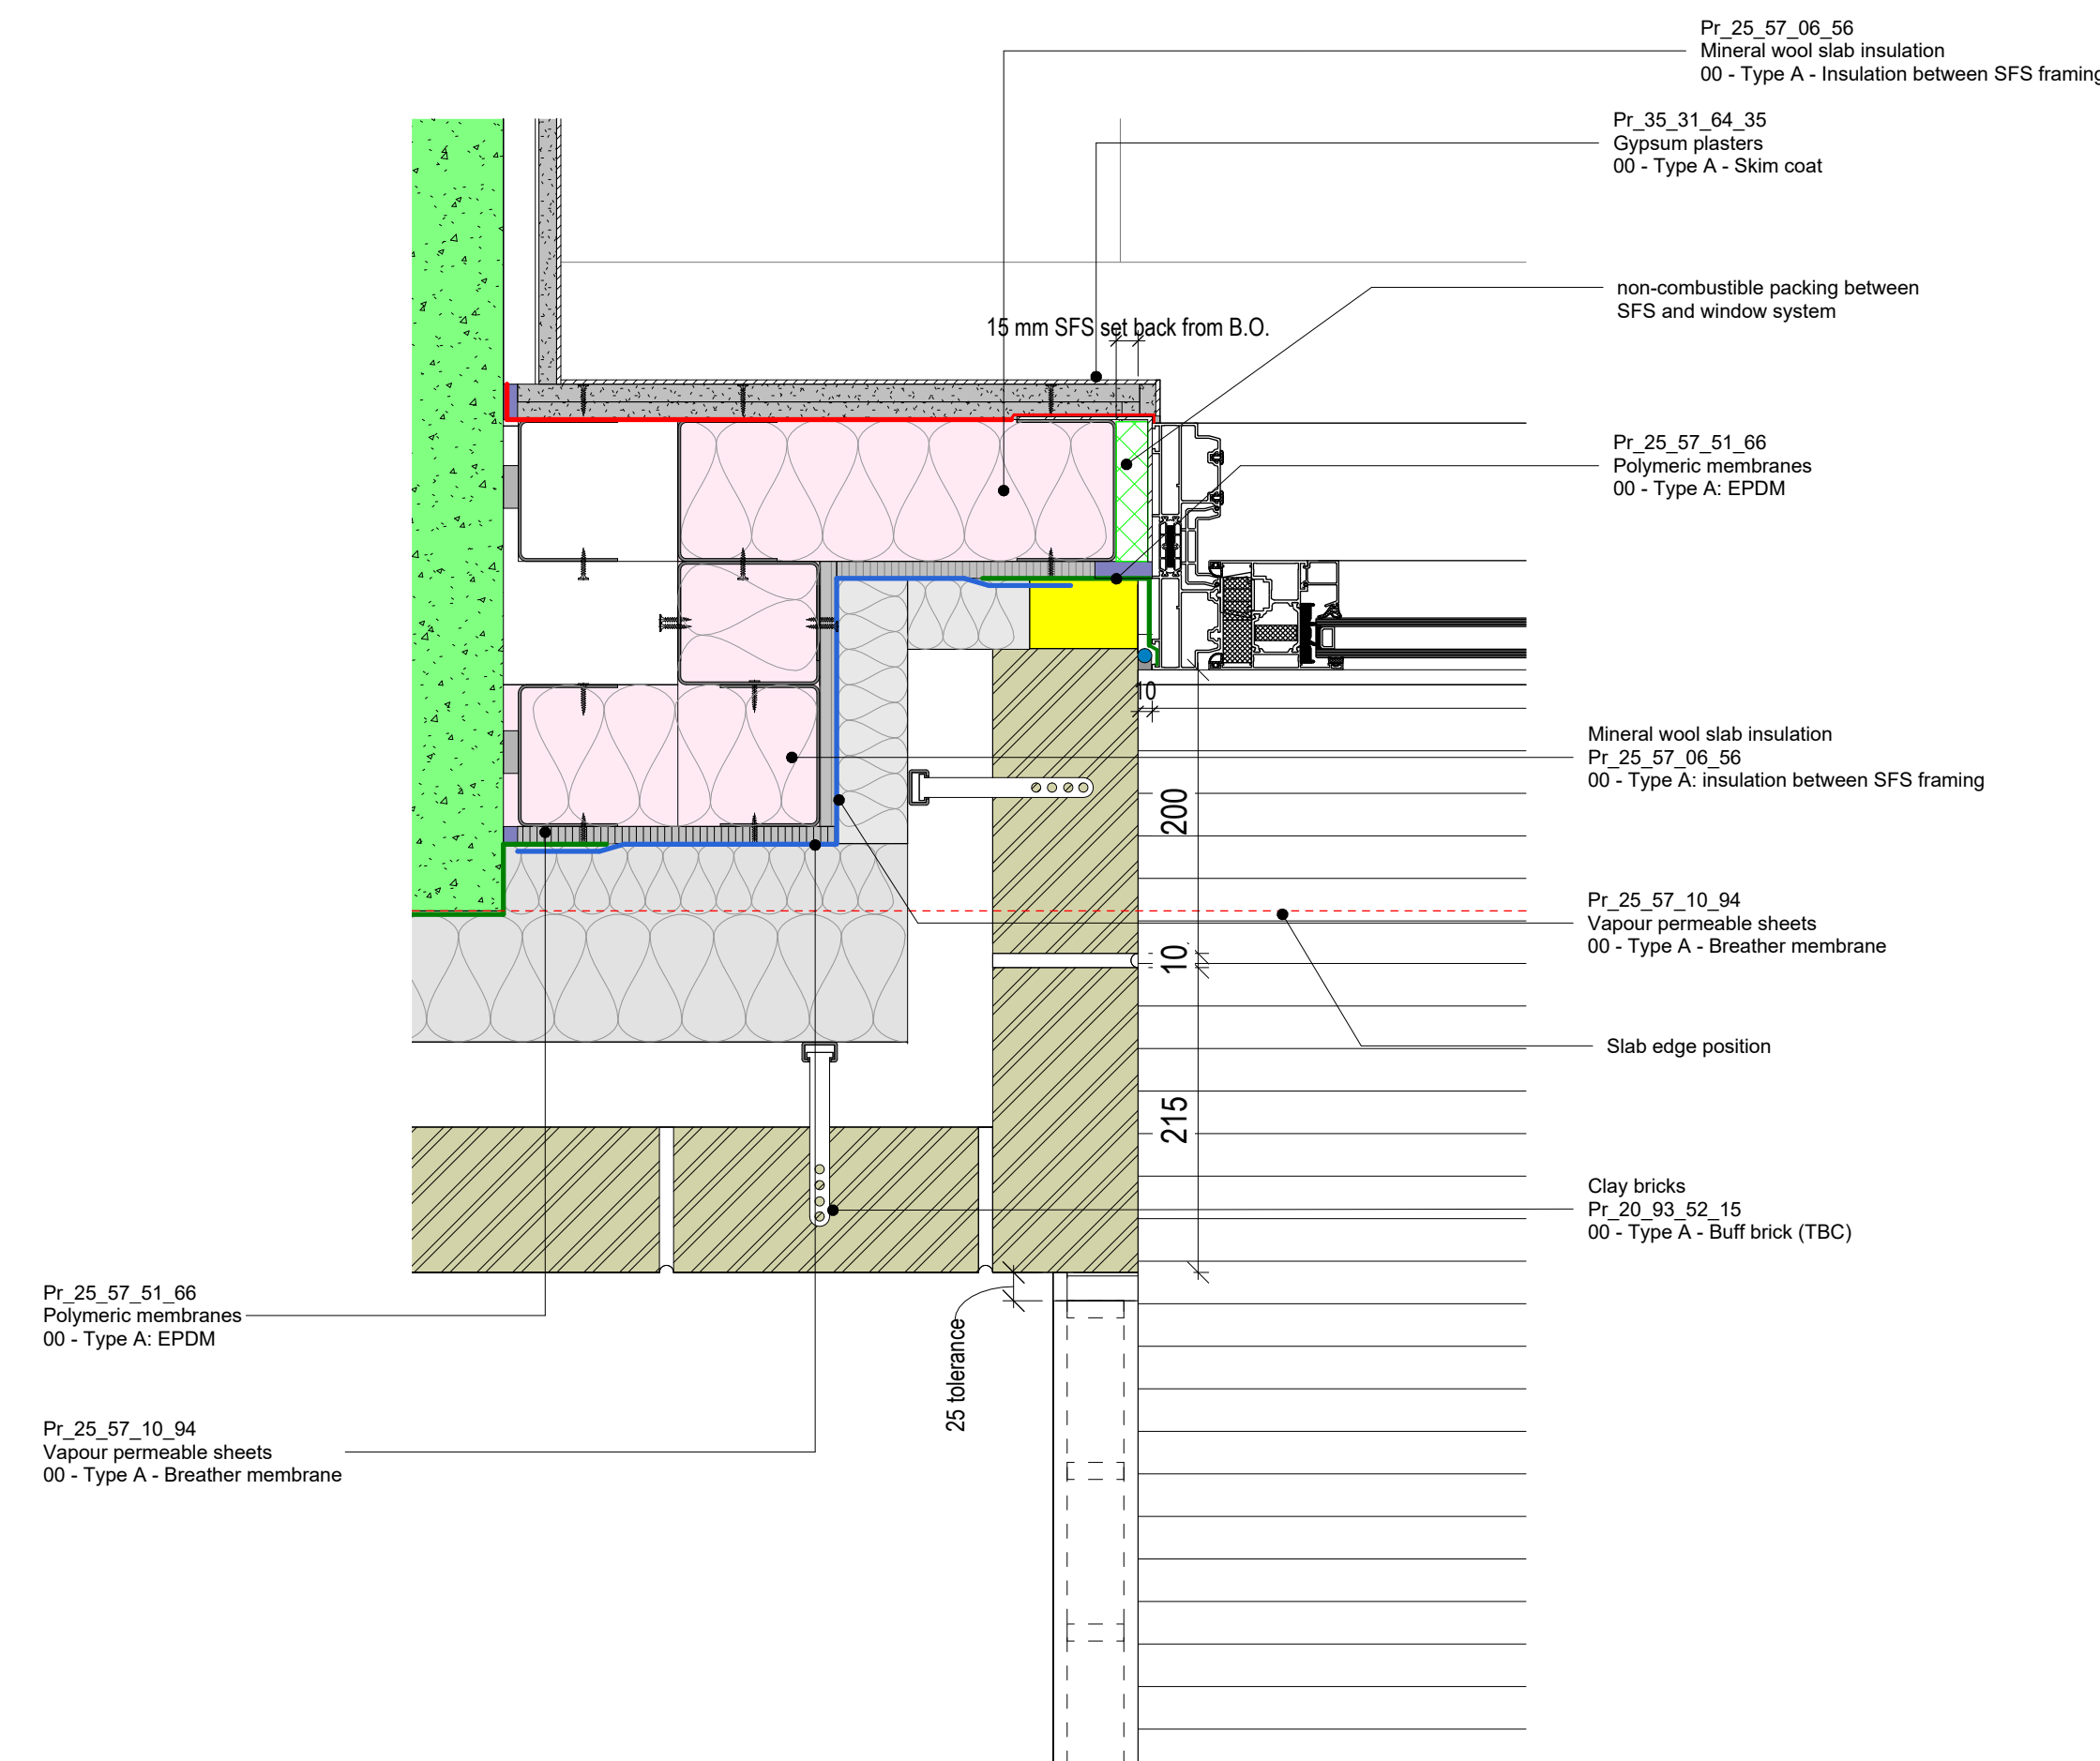

3 Flat metal front panel - Handrail jamb detail  
1 : 5

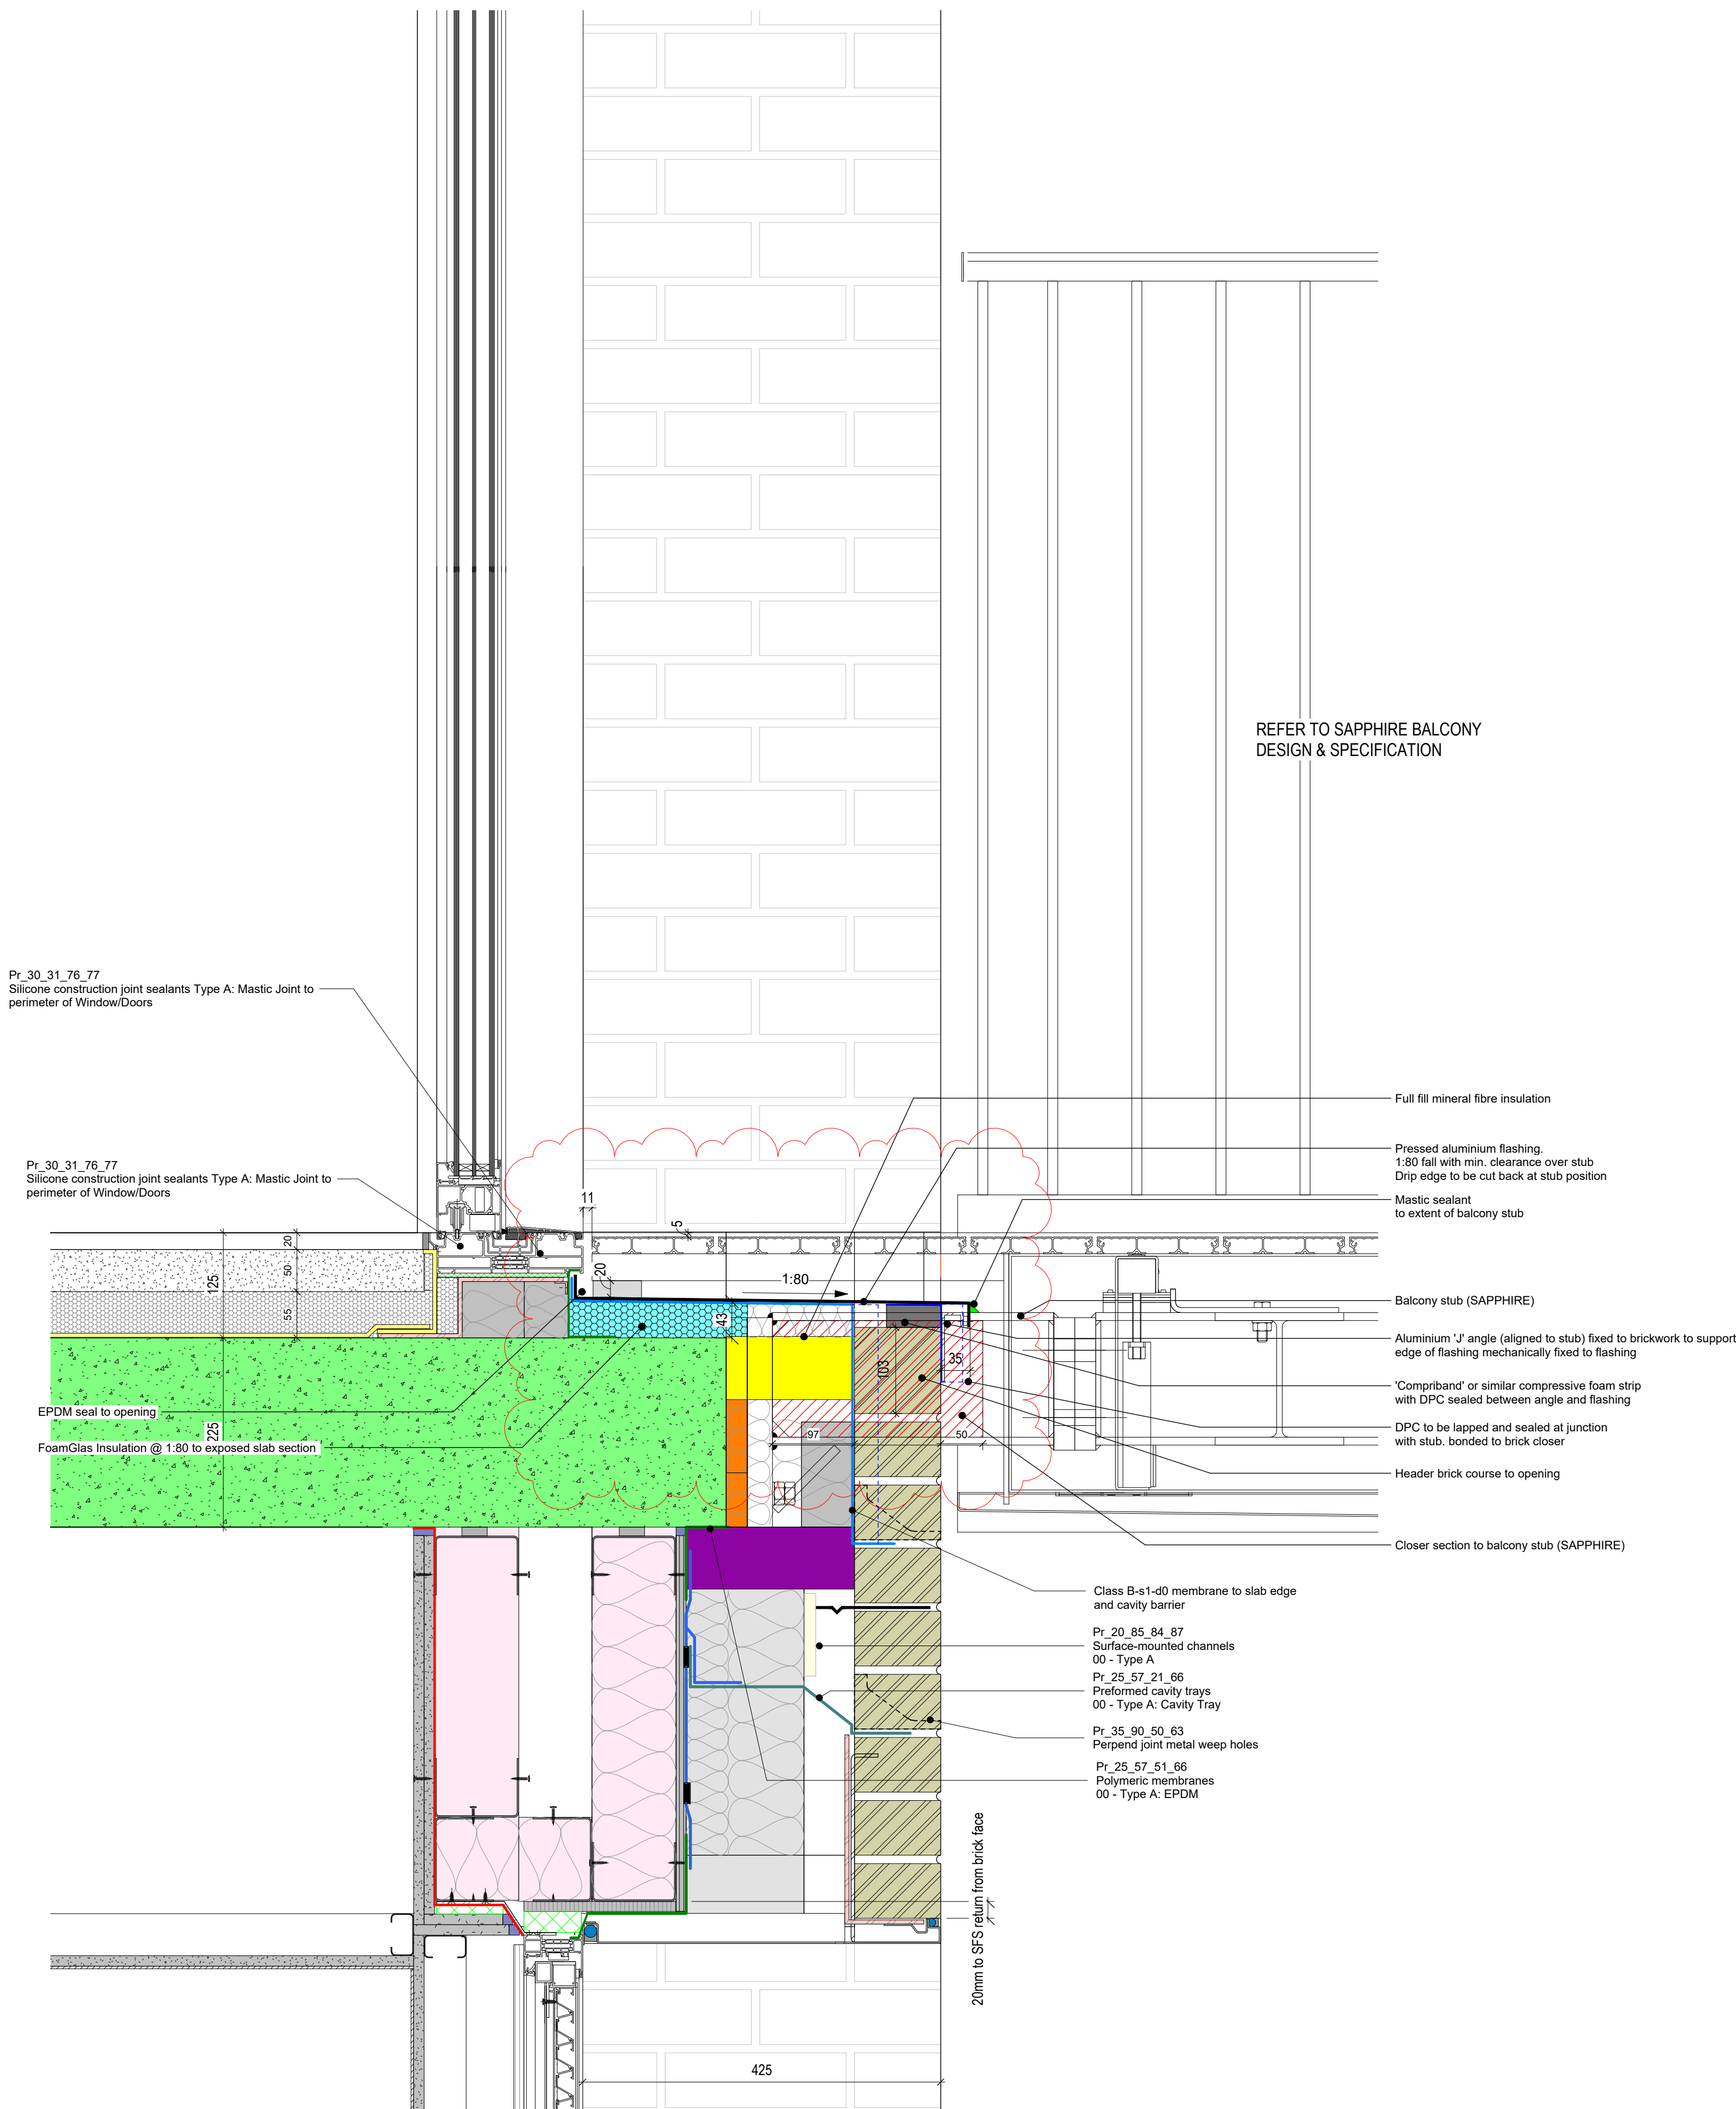

2 Balcony section detail - Flat metal front panel @ masonry support  
1 : 5

©Scott Browning Ltd  
This drawing is to be read in conjunction with all relevant architect's and other designers' drawings and associated specifications. Figured dimensions only are to be taken from this drawing. All dimensions are to be checked on site before any work is put in hand.

mm 100 200 300 400 500  
SCALE BAR: 1:5

BALCONIES

For balcony locations and instance references refer to 03 Series.

For balcony types, details and schedules refer to 36 Series.

For bolt-on balcony specification refer to:  
Ss\_25\_60\_05\_05 Balustrades and guarding systems - Bolt on Balconies.

For balcony connection details refer to Structural Engineers' information.

Detailed design to be developed by specialist subcontractor.

DRAWING SERIES

Series 00 - Accommodation Schedules  
Series 00 - NBS Specification  
Series 02 - Conveyance Plans  
Series 03 - GA Plans, GA Setting out Plans & Marketing Plans  
Series 04 - GA Sections  
Series 05 - GA Elevations  
Series 06 - Stage 2 Drawings  
Series 07 - Bay Studies  
Series 08 - 3D Views  
Series 16 - Substructure  
Series 20 - Superstructure  
Series 21 - External Wall Types & Details  
Series 22 - Internal Wall Types & Details  
Series 24 - Staircases & Lifts  
Series 27 - Roof Types & Details  
Series 31 - Window & Doors Types, Details & Schedules  
Series 35 - Reflected Ceiling Plans  
Series 36 - Floor Types & Details  
Series 36 - Balconies & External Metalwork  
Series 40 - Internal Finishes  
Series 43 - Floor Finishes  
Series 60 - Electrical Plans  
Series 67 - Fire Strategy Plans  
Series 70 - Flat Type Layouts  
Series 71 - Signage Plans  
Series 73 - Kitchen Layouts & Schedules  
Series 74 - Bathroom Layouts & Schedules  
Series 75 - Residents Facilities  
Series 82 - Commercial Units  
Series 83 - Offices  
Series 84 - Area Plans

GENERAL NOTES

STRUCTURAL - For design, detailing and setting out of structural elements refer to Structural Engineers drawings.

SERVICES - For design, detailing & setting out of services, including SVPs, Gas, Water, Electricals & Telecoms etc refer to M&E Engineers and Structural Engineers drawings.

All information on this drawing must be read in conjunction with relevant series and specifications.

Refer to:  
03 Series Cladding plans for scoping extent,  
35 Series SW soffit plans (insulation & metalwork),  
36 Series for metalwork details &  
DDU / TFS NBS specification for metalwork elements

C06	Updated Metalwork Issue	05.09.23	CS	JR
C05	Updates to flashing following Balcony mtp. 24.08.23	24.08.23	CS	BC
C04	Updates following package presentation	04.08.23	CS	ACS
C03	Amended to Client change to Windows & Balconies	26.07.23	CS	ACS
C02	Updates following NHBC workshop	27.04.23	CS	ACS
C01	CONSTRUCTION ISSUE	29.03.23	CS	ACS
Revision	Description	Date	Drawn	Checked

design  
delivery  
unit

77 Endell Street  
London WC2H 9DZ  
T +44 (0)20 7240 7766  
W designdeliveryunit.com

Clients Name

St George North London Limited



JOB Title

Camden Goods Yard

Drawing Title

Building B Balcony Details Flat Metal Front Panel

Scale

As indicated @A0

Practice Project No.

20226

Practice Project No.	Originator	Volume	Level	Type	Rev	Number
CGYB0-DDU-B0-ZZ-DR-A-36620						

CONSTRUCTION

Rev

C06

© Design Delivery 2023. All other copyright of the drawing is to be agreed, checked or reported to the relevant authority before any work is put in hand.