




1 Lifts Tower - View 1  
1 : 50

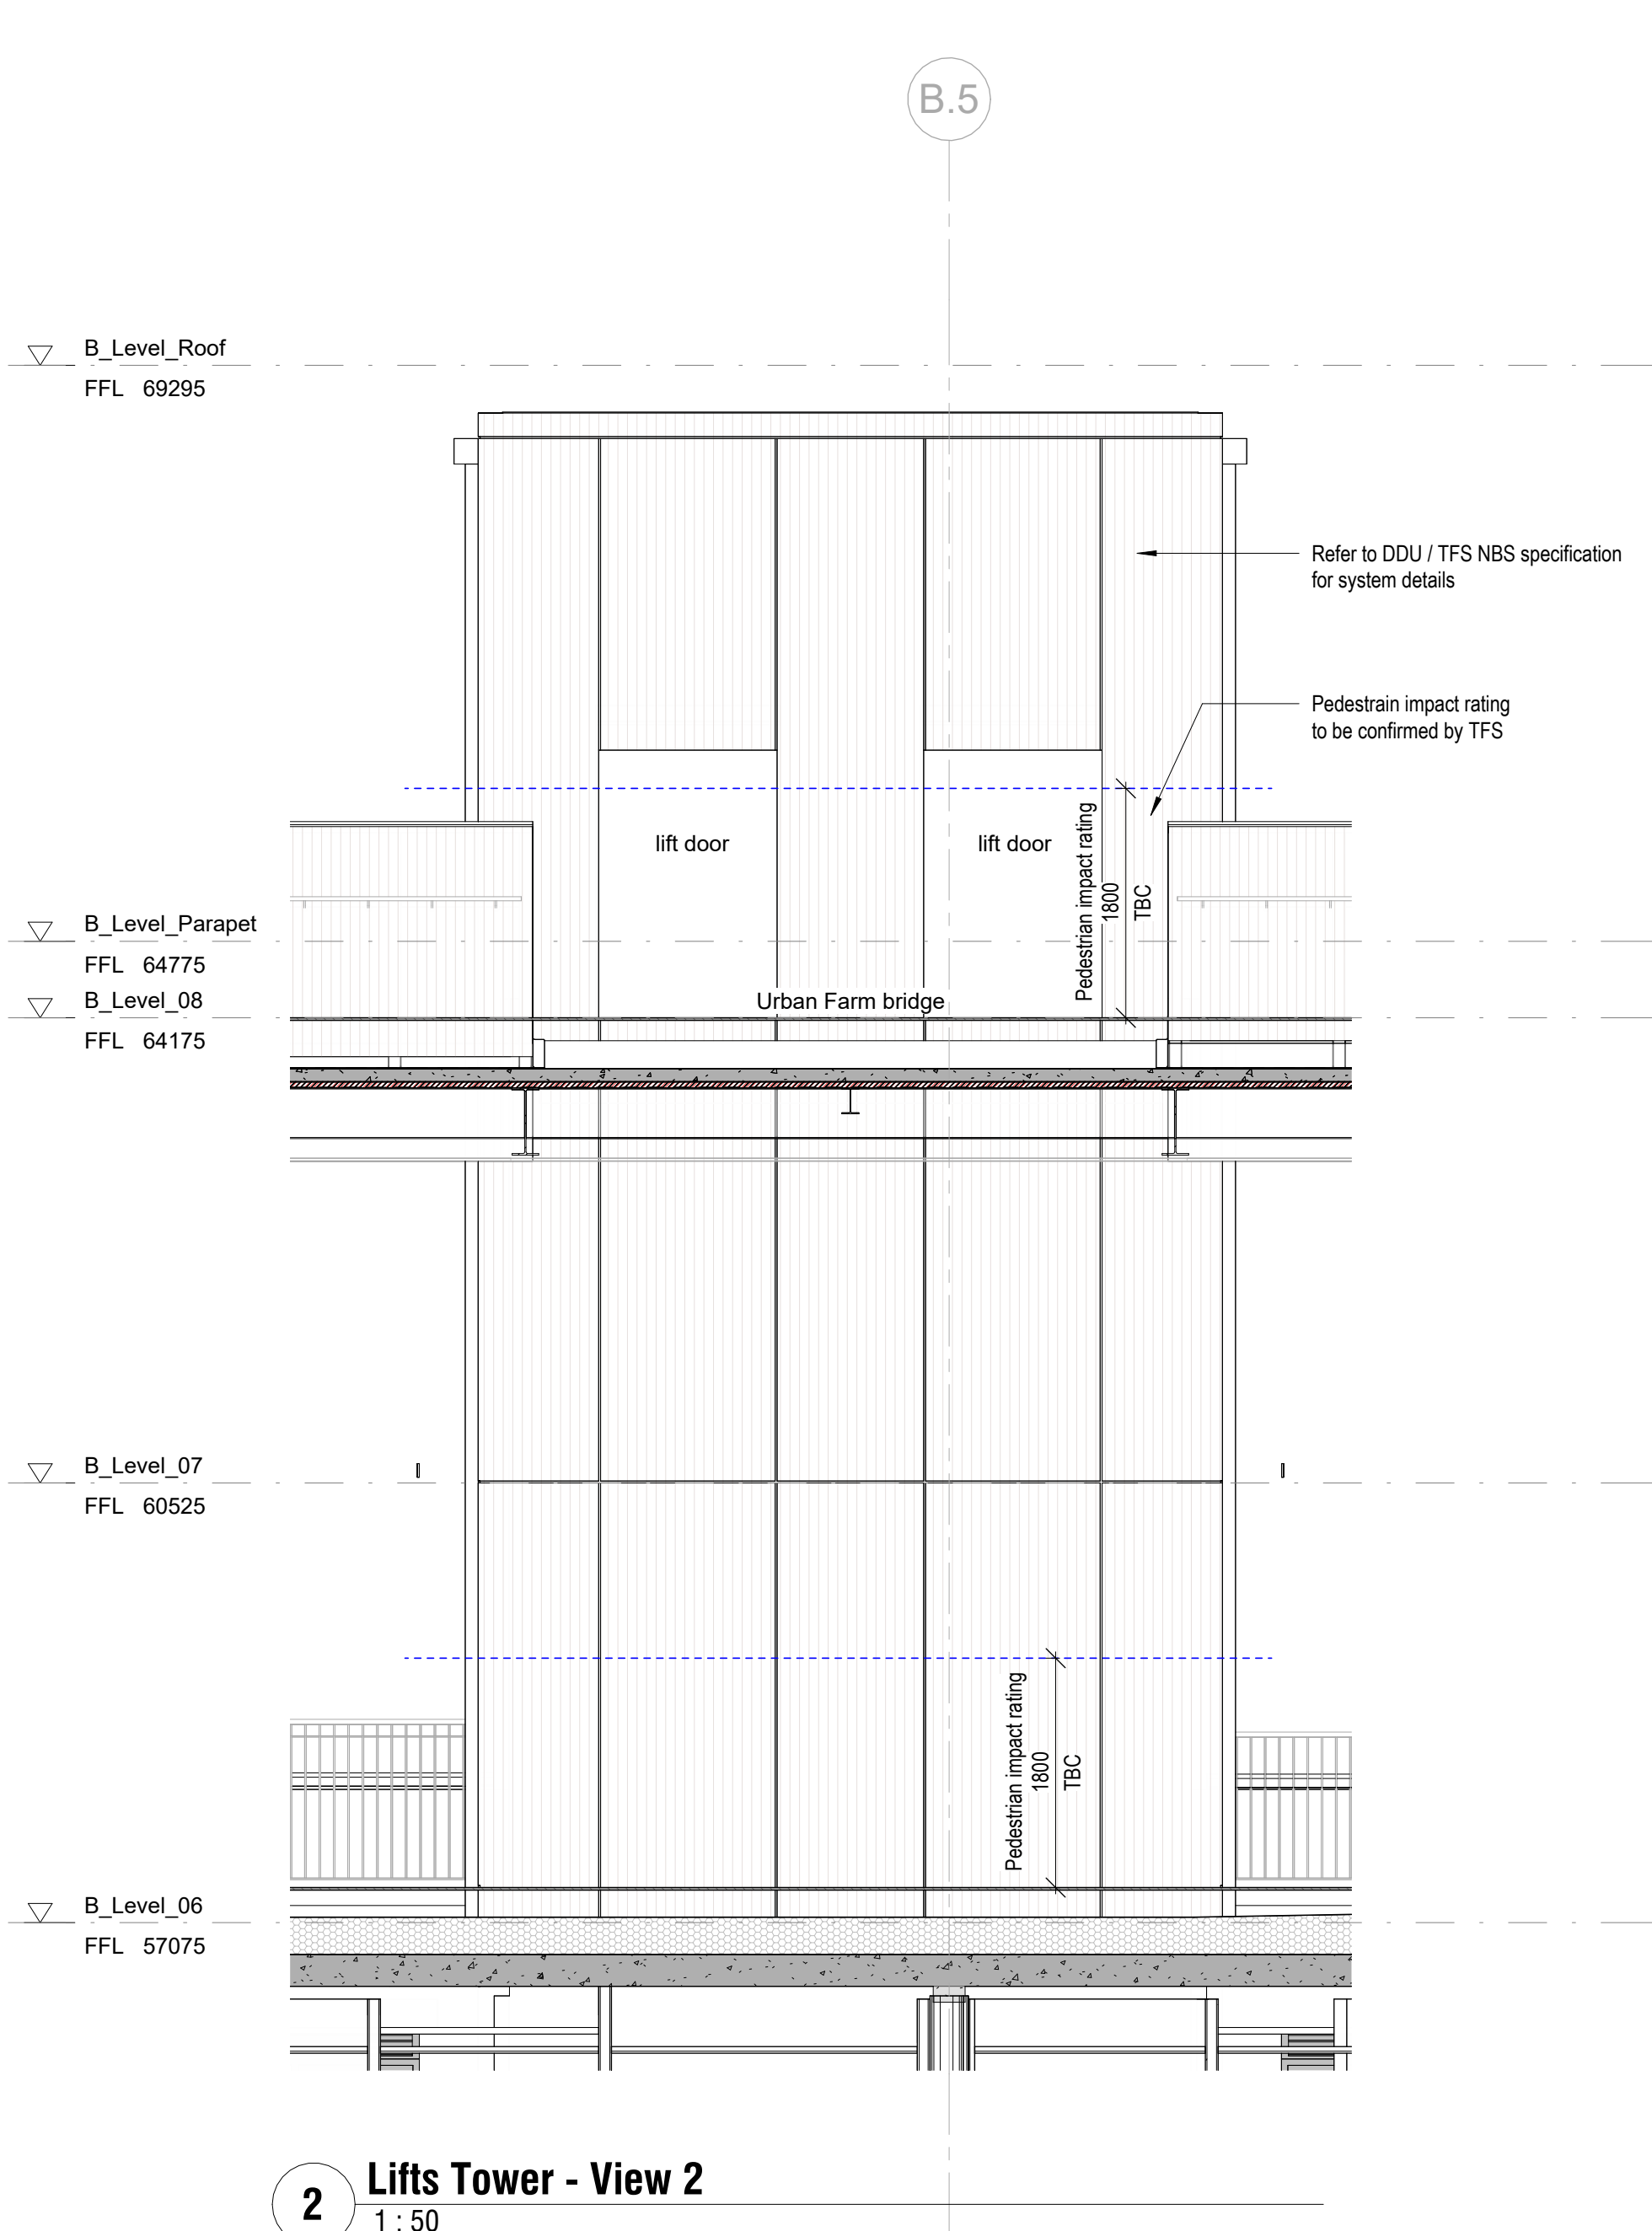


2 Lifts Tower - View 2  
1 : 50

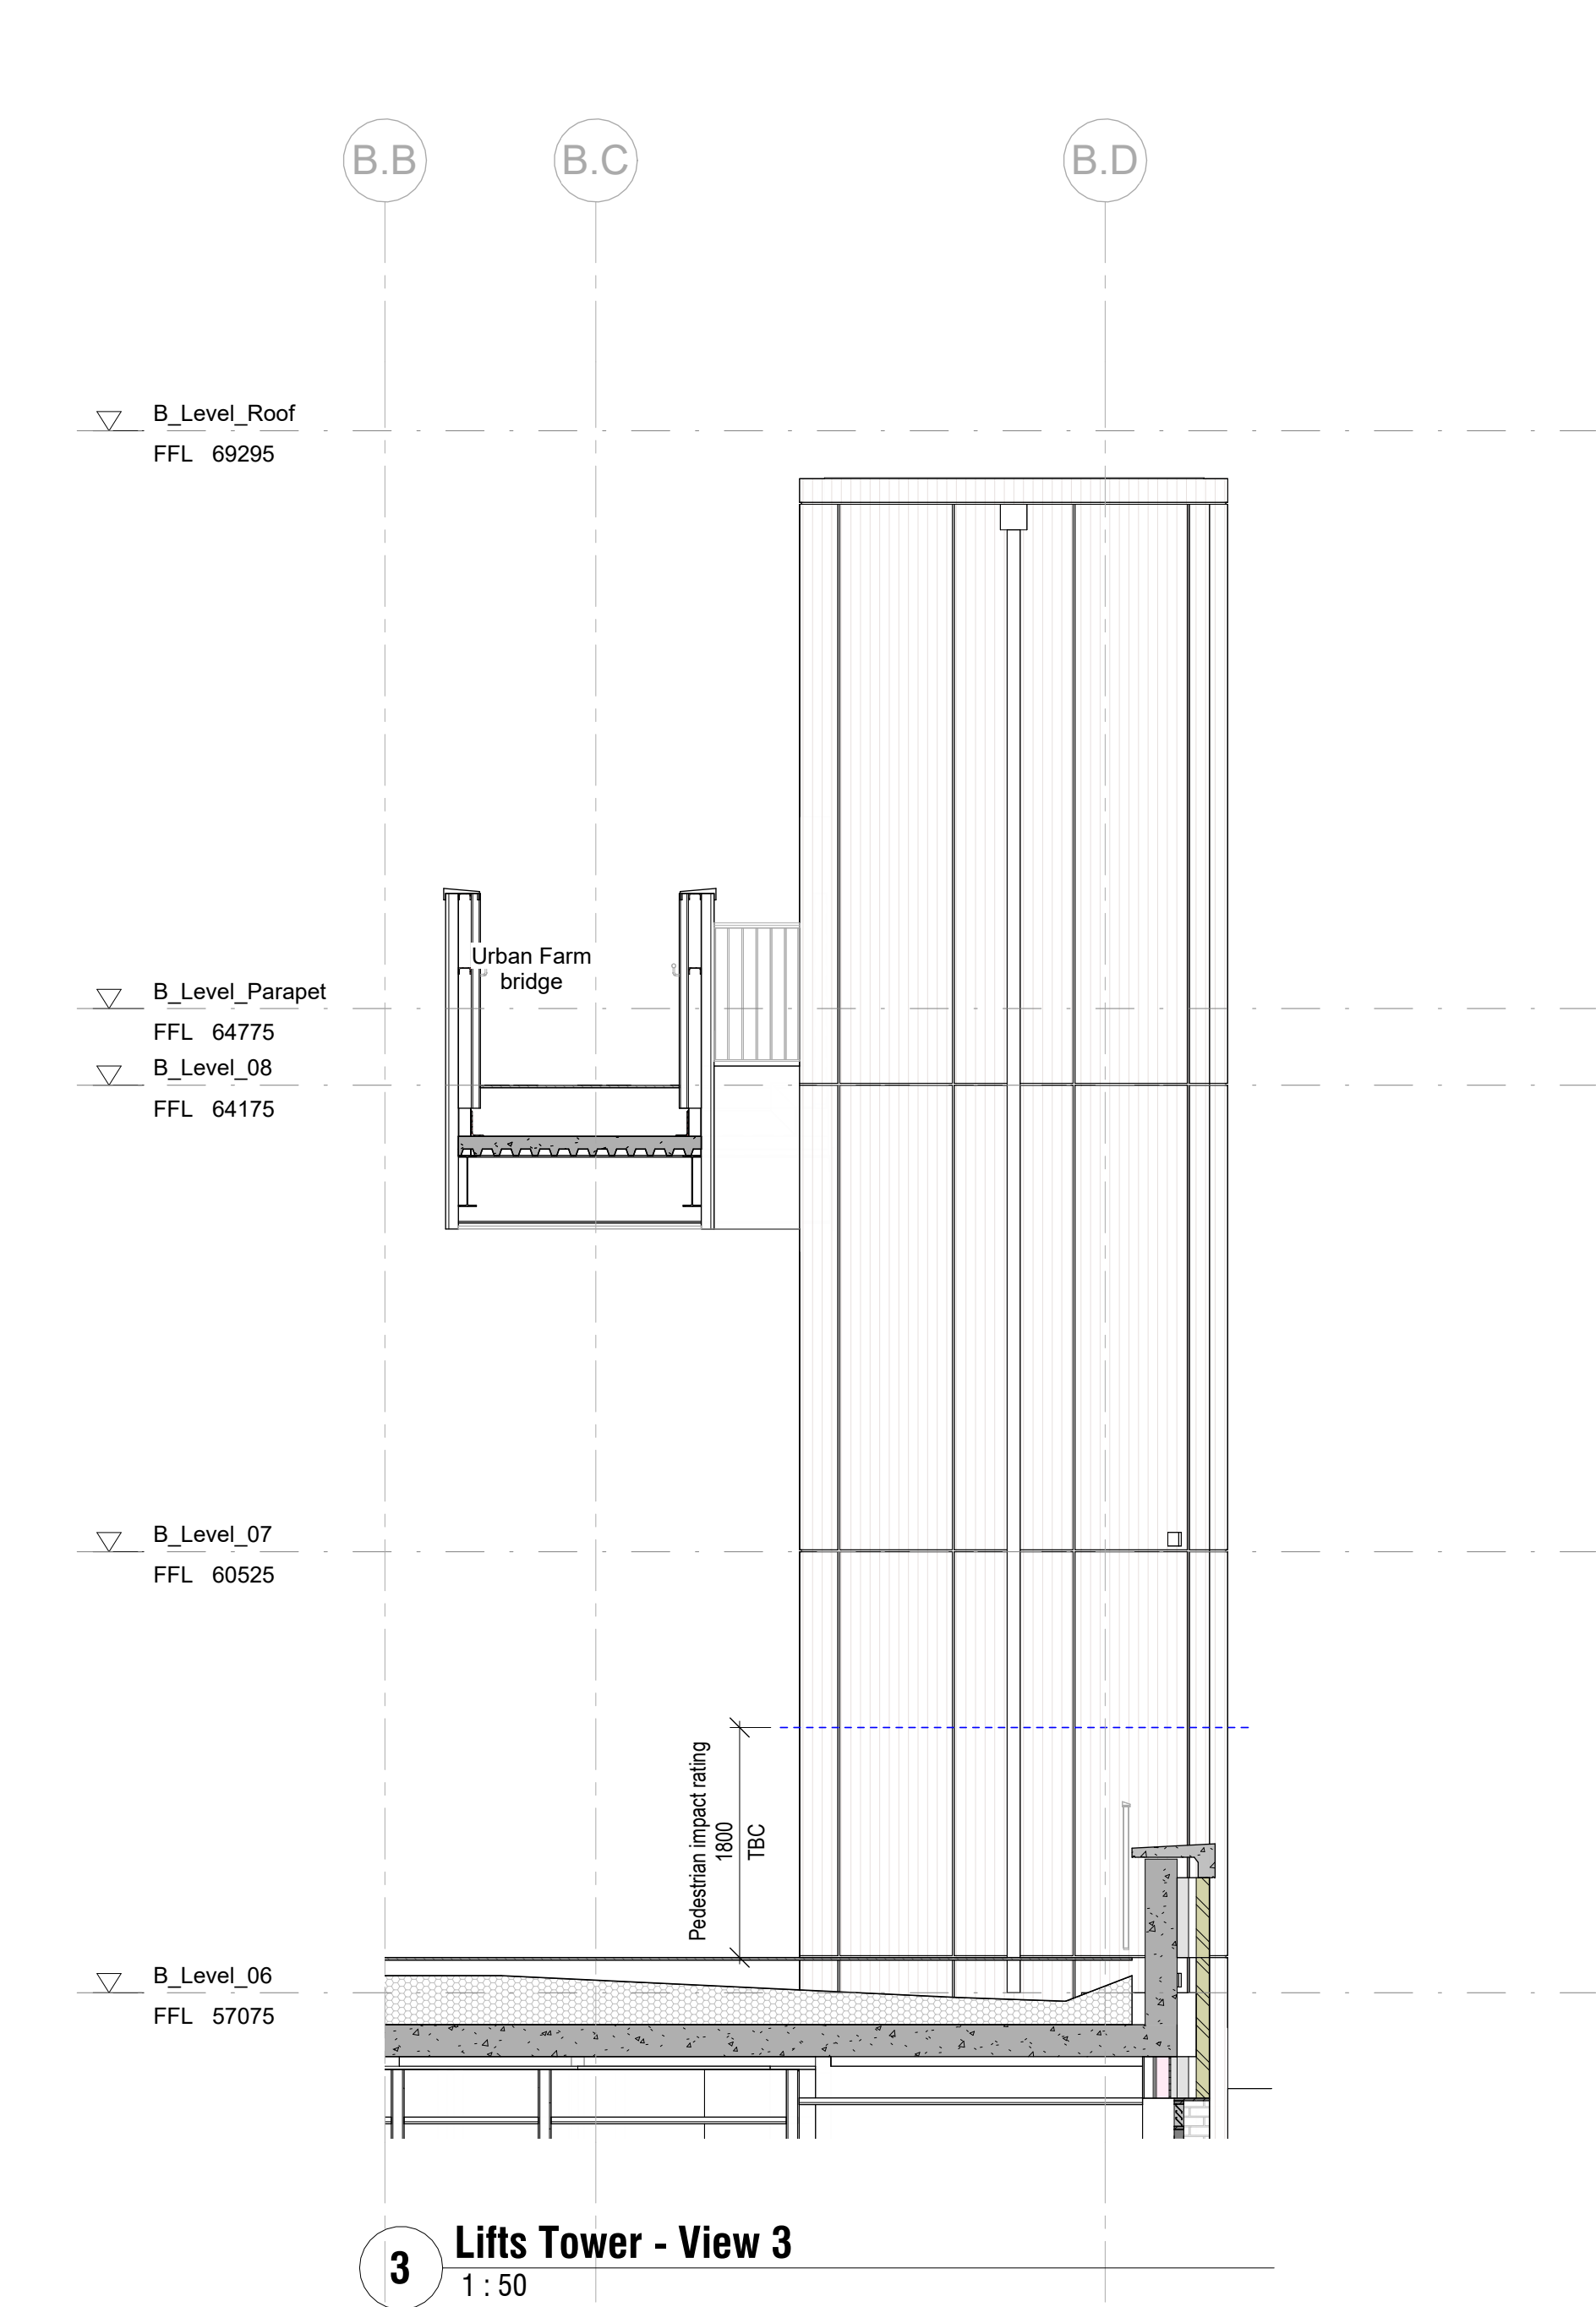


3 Lifts Tower - View 3  
1 : 50

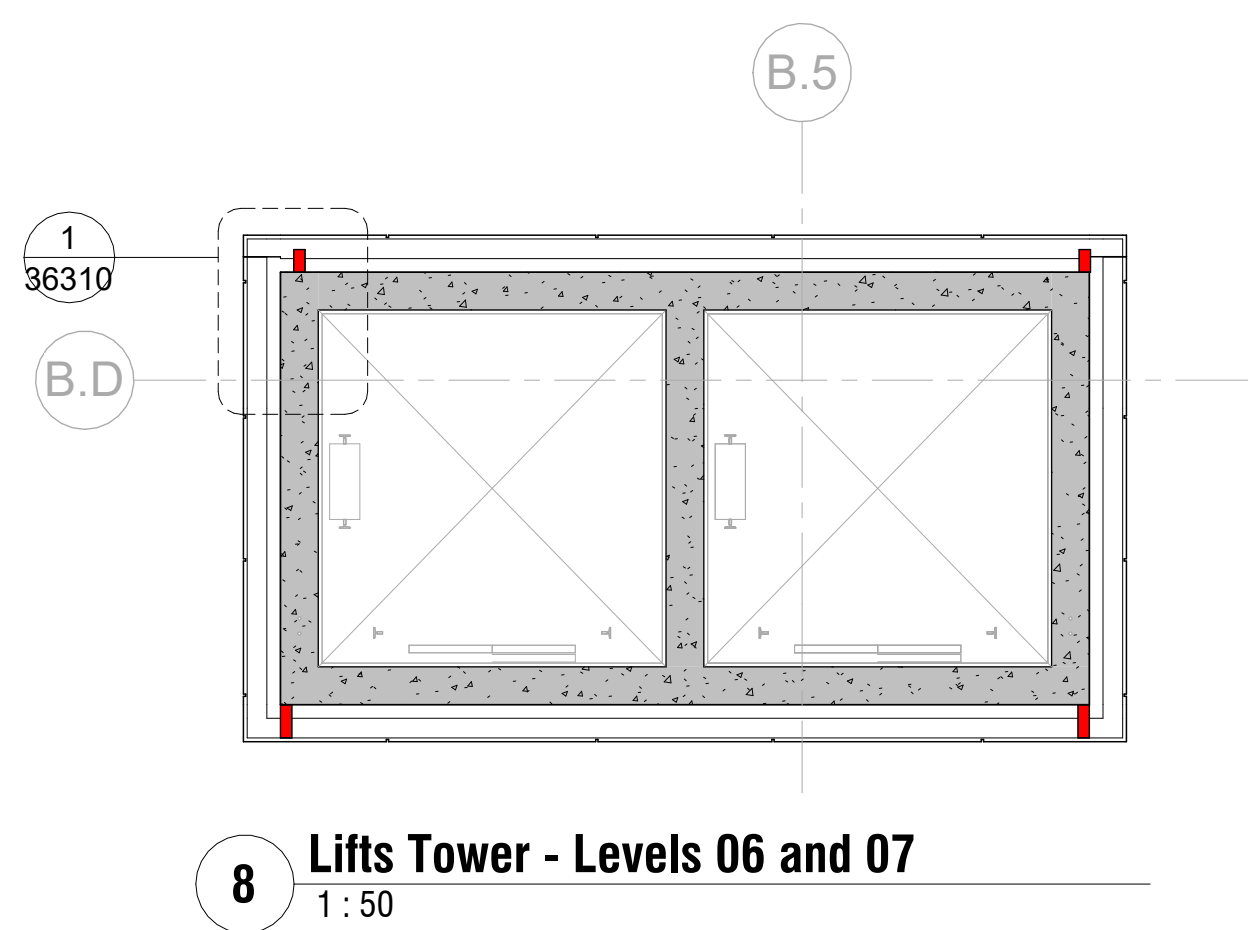


8 Lifts Tower - Levels 06 and 07  
1 : 50

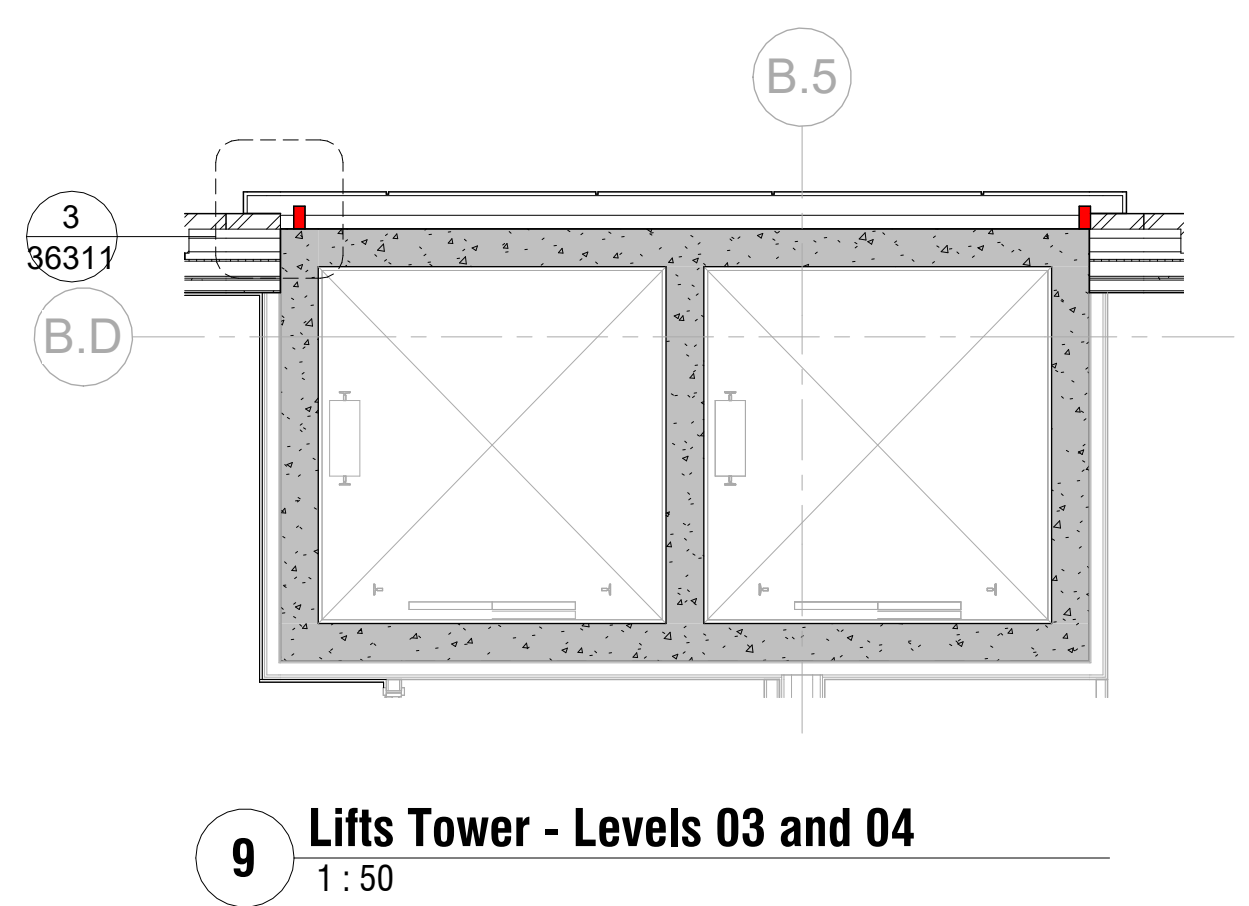


9 Lifts Tower - Levels 03 and 04  
1 : 50

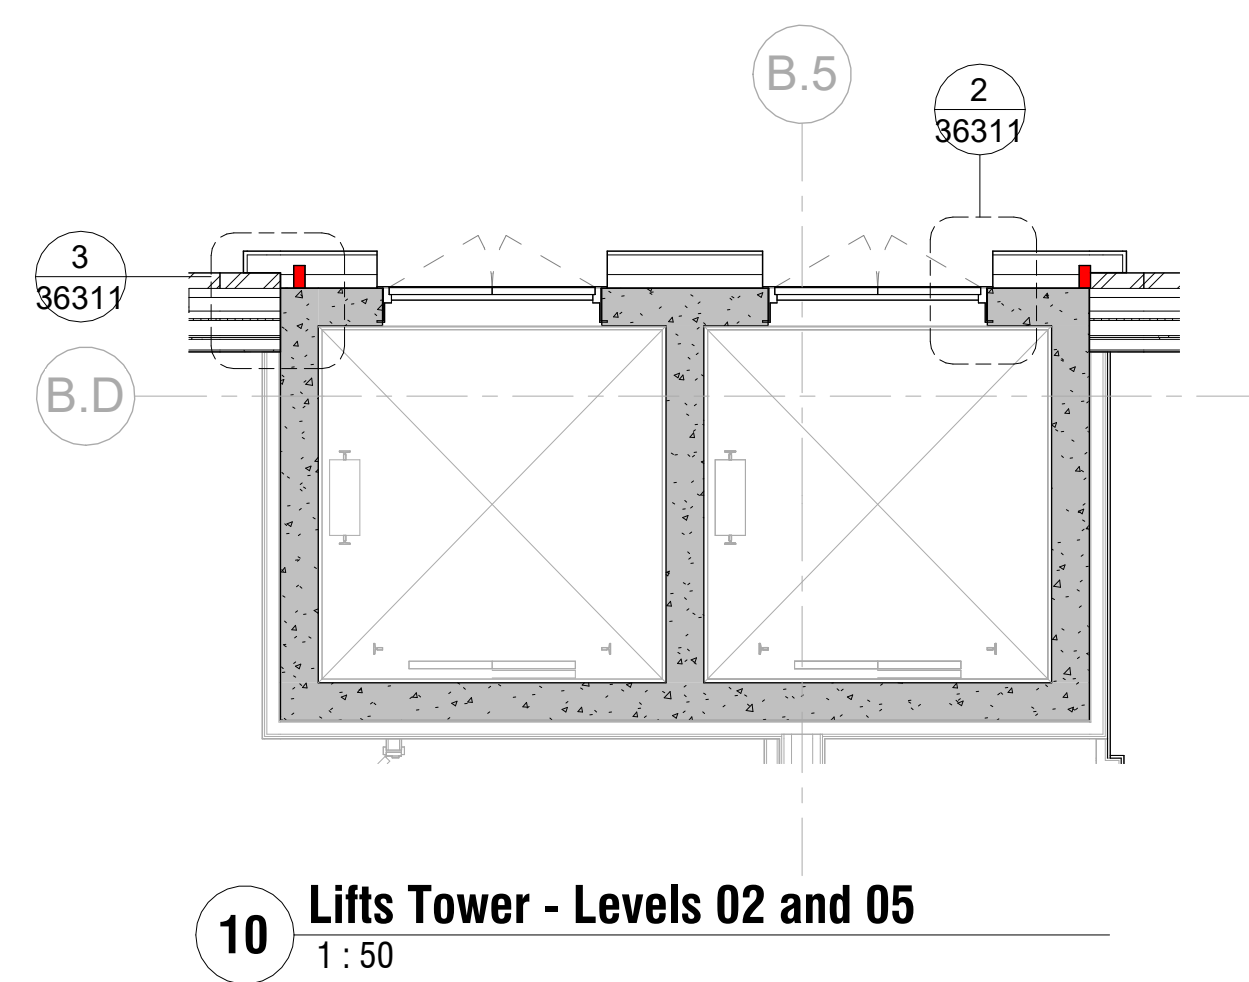


10 Lifts Tower - Levels 02 and 05  
1 : 50

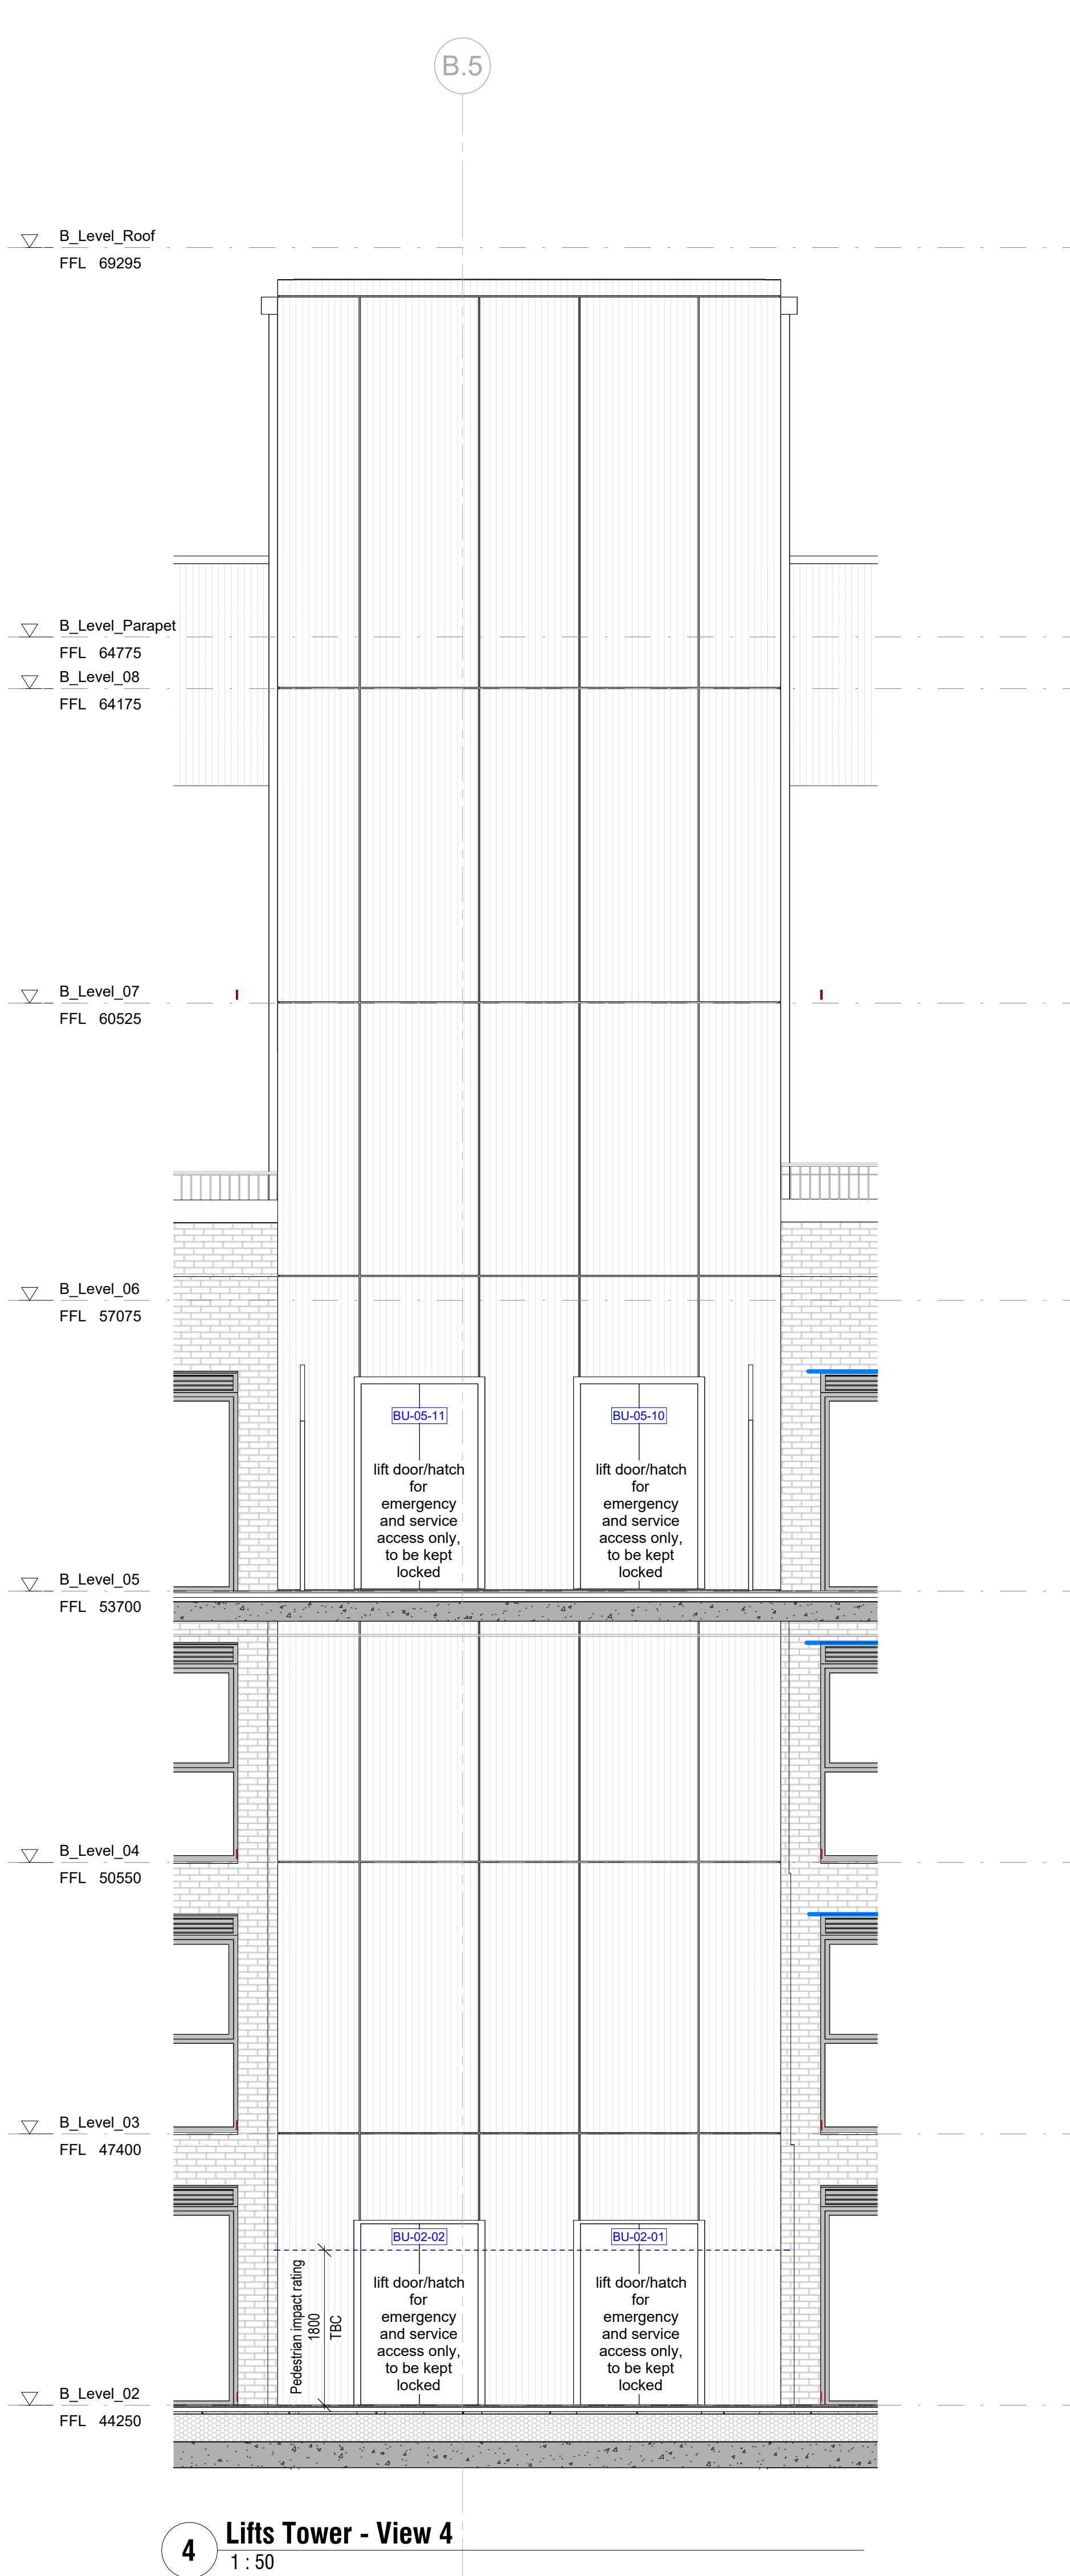

4 Lifts Tower - View 4  
1 : 50

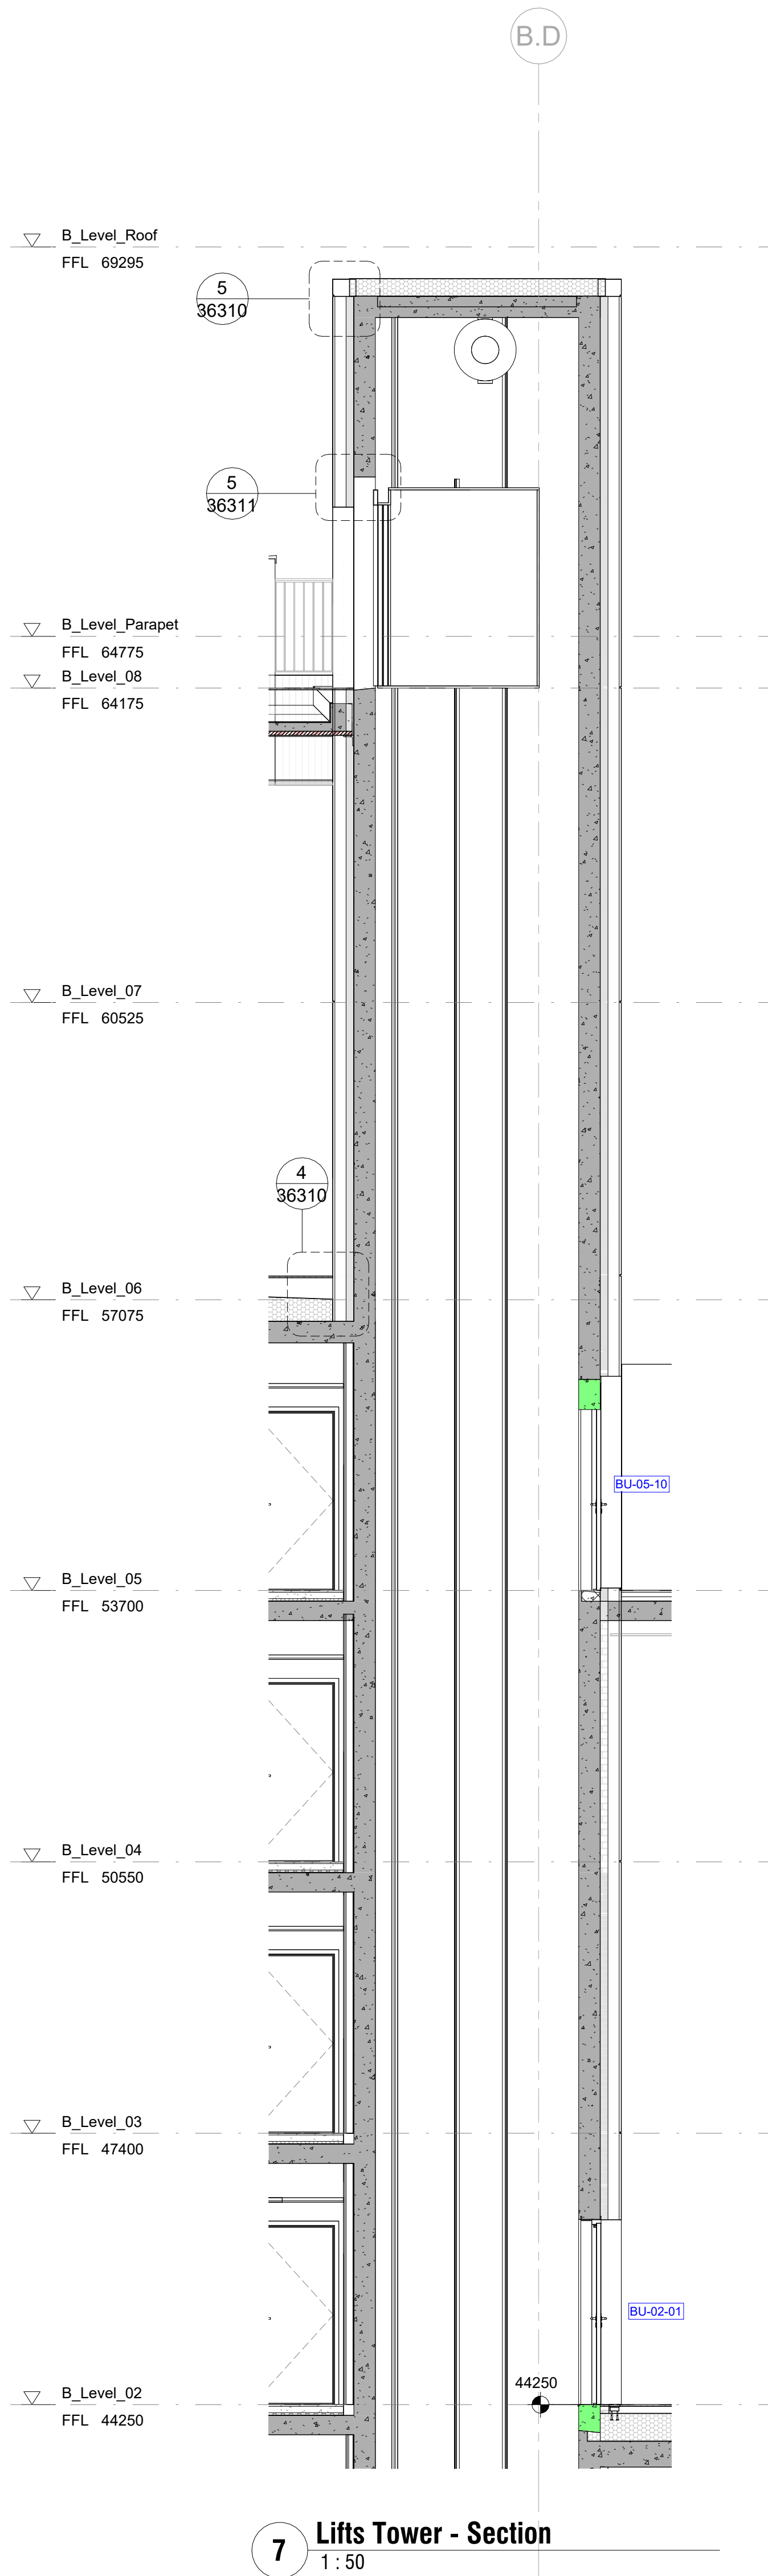

7 Lifts Tower - Section  
1 : 50

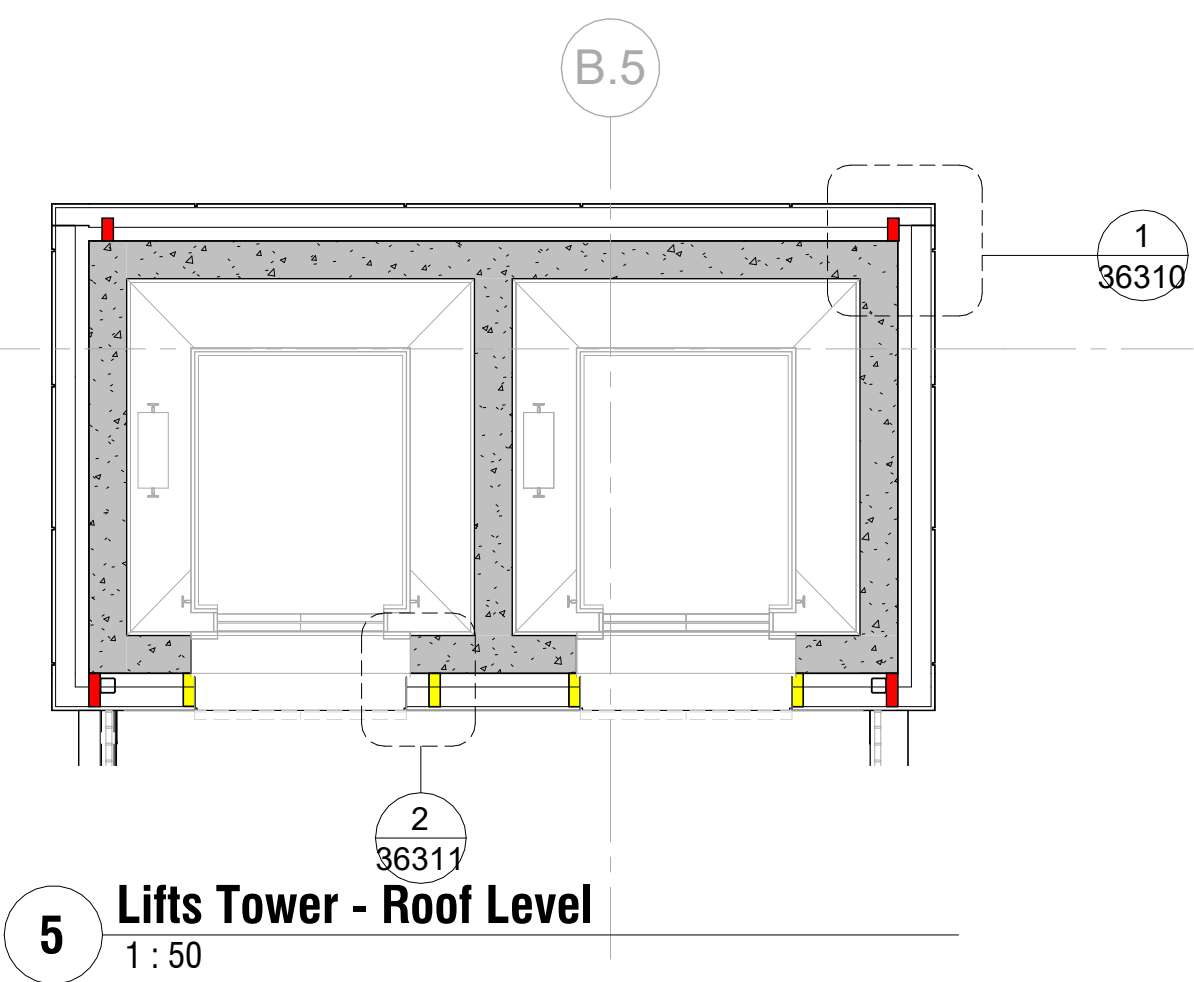

5 Lifts Tower - Roof Level  
1 : 50

©Scott Browning Ltd  
This drawing is to be read in conjunction with all relevant architect's and other designers' drawings and associated specifications. Figured dimensions only are to be taken from this drawing. All dimensions are to be checked on site before any work is put in hand.

0 1 2 3 4 5  
SCALE BAR: 1:50

#### DRAWING SERIES

Series 00 - Accommodation Schedules  
Series 00 - NBS Specification  
Series 02 - Convenience Plans  
Series 03 - GA Plans, GA Setting out Plans & Marketing Plans  
Series 04 - GA Sections  
Series 05 - GA Elevations  
Series 06 - Stage 2 Drawings  
Series 07 - Bay Studies  
Series 08 - 3D Views  
Series 16 - Substructure  
Series 20 - Superstructure  
Series 21 - External Wall Types & Details  
Series 22 - Internal Wall Types & Details  
Series 24 - Staircases & Lifts  
Series 27 - Roof Types & Details  
Series 31 - Window & Doors Types, Details & Schedules  
Series 35 - Reflected Ceiling Plans  
Series 35 - Floor Types & Details  
Series 36 - Balconies & External Metalwork  
Series 40 - Internal Finishes  
Series 43 - Floor Finishes  
Series 47 - Electrical Plans  
Series 67 - Fire Strategy Plans  
Series 71 - Signage Plans  
Series 73 - Kitchen Layouts & Schedules  
Series 74 - Bathroom Layouts & Schedules  
Series 79 - Residents Facilities  
Series 82 - Commercial Units  
Series 83 - Offices  
Series 84 - Area Plans

#### GENERAL NOTES

STRUCTURAL - For design, detailing and setting out of structural elements refer to Structural Engineers drawings.  
SERVICES - For design, detailing & setting out of services, including SVPs, Gas, Water, Electricals & Telecoms etc refer to M&E Engineers and Structural Engineers drawings.  
All information on this drawing must be read in conjunction with relevant series and specifications.

Refer to:  
03 Series Cladding plans for scoping extent,  
35 Series SW soffit plans (insulation & metalwork),  
36 Series for metalwork details &  
DDU / TFS NBS specification for metalwork elements

CO2	Updated Metalwork Issue	05.09.23	CS	JR
CO1	Construction Issue	30.06.23	CS	ACS
Revision	Description	Date	Drawn	Checked

design  
delivery  
unit

77 Endell Street  
London WC2H 9DZ  
T +44 (0)20 7240 7766  
W designdeliveryunit.com

Client's Name  
St George North London Limited



Job Title  
Camden Goods Yard

Drawing Title  
Building B Urban Farm Lifts Tower

Scale  
As indicated @A0  
Practice Project No.  
20226

CGYB0-DDU-B0-ZZ-DR-A-36303

CONSTRUCTION  
C02