




1 South Escape Staircase - View 1
1:50

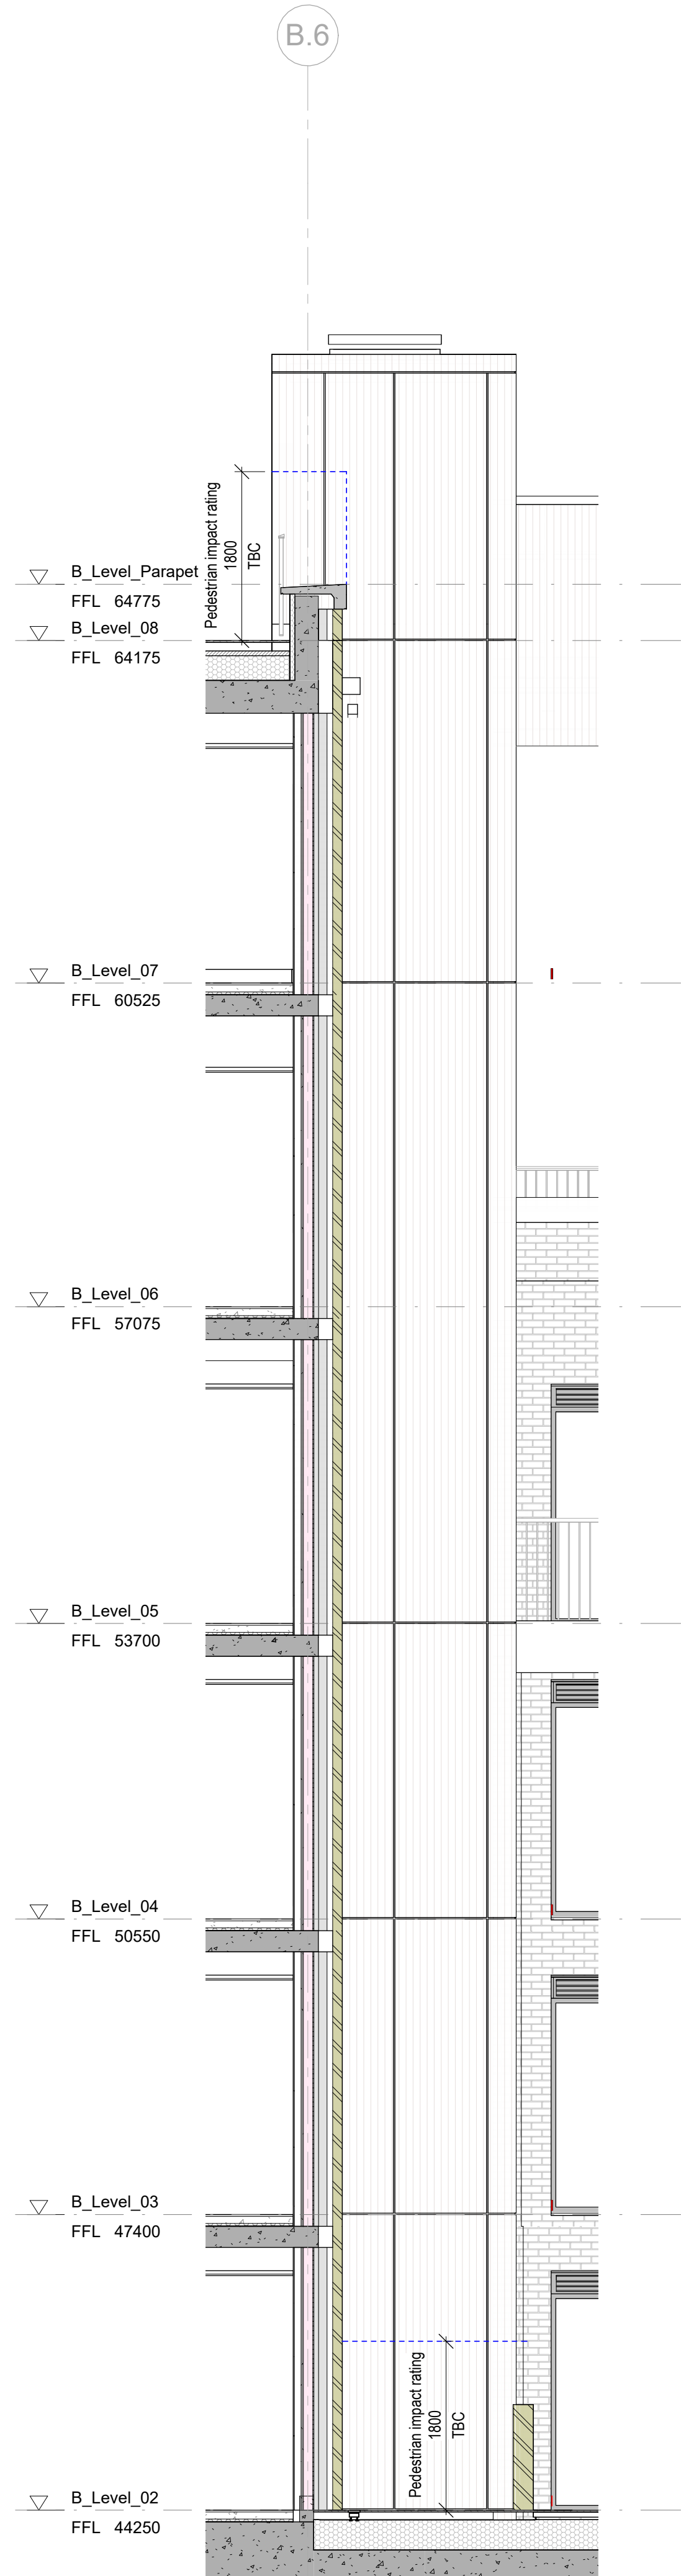


4 South Escape Staircase - View 4
1:50

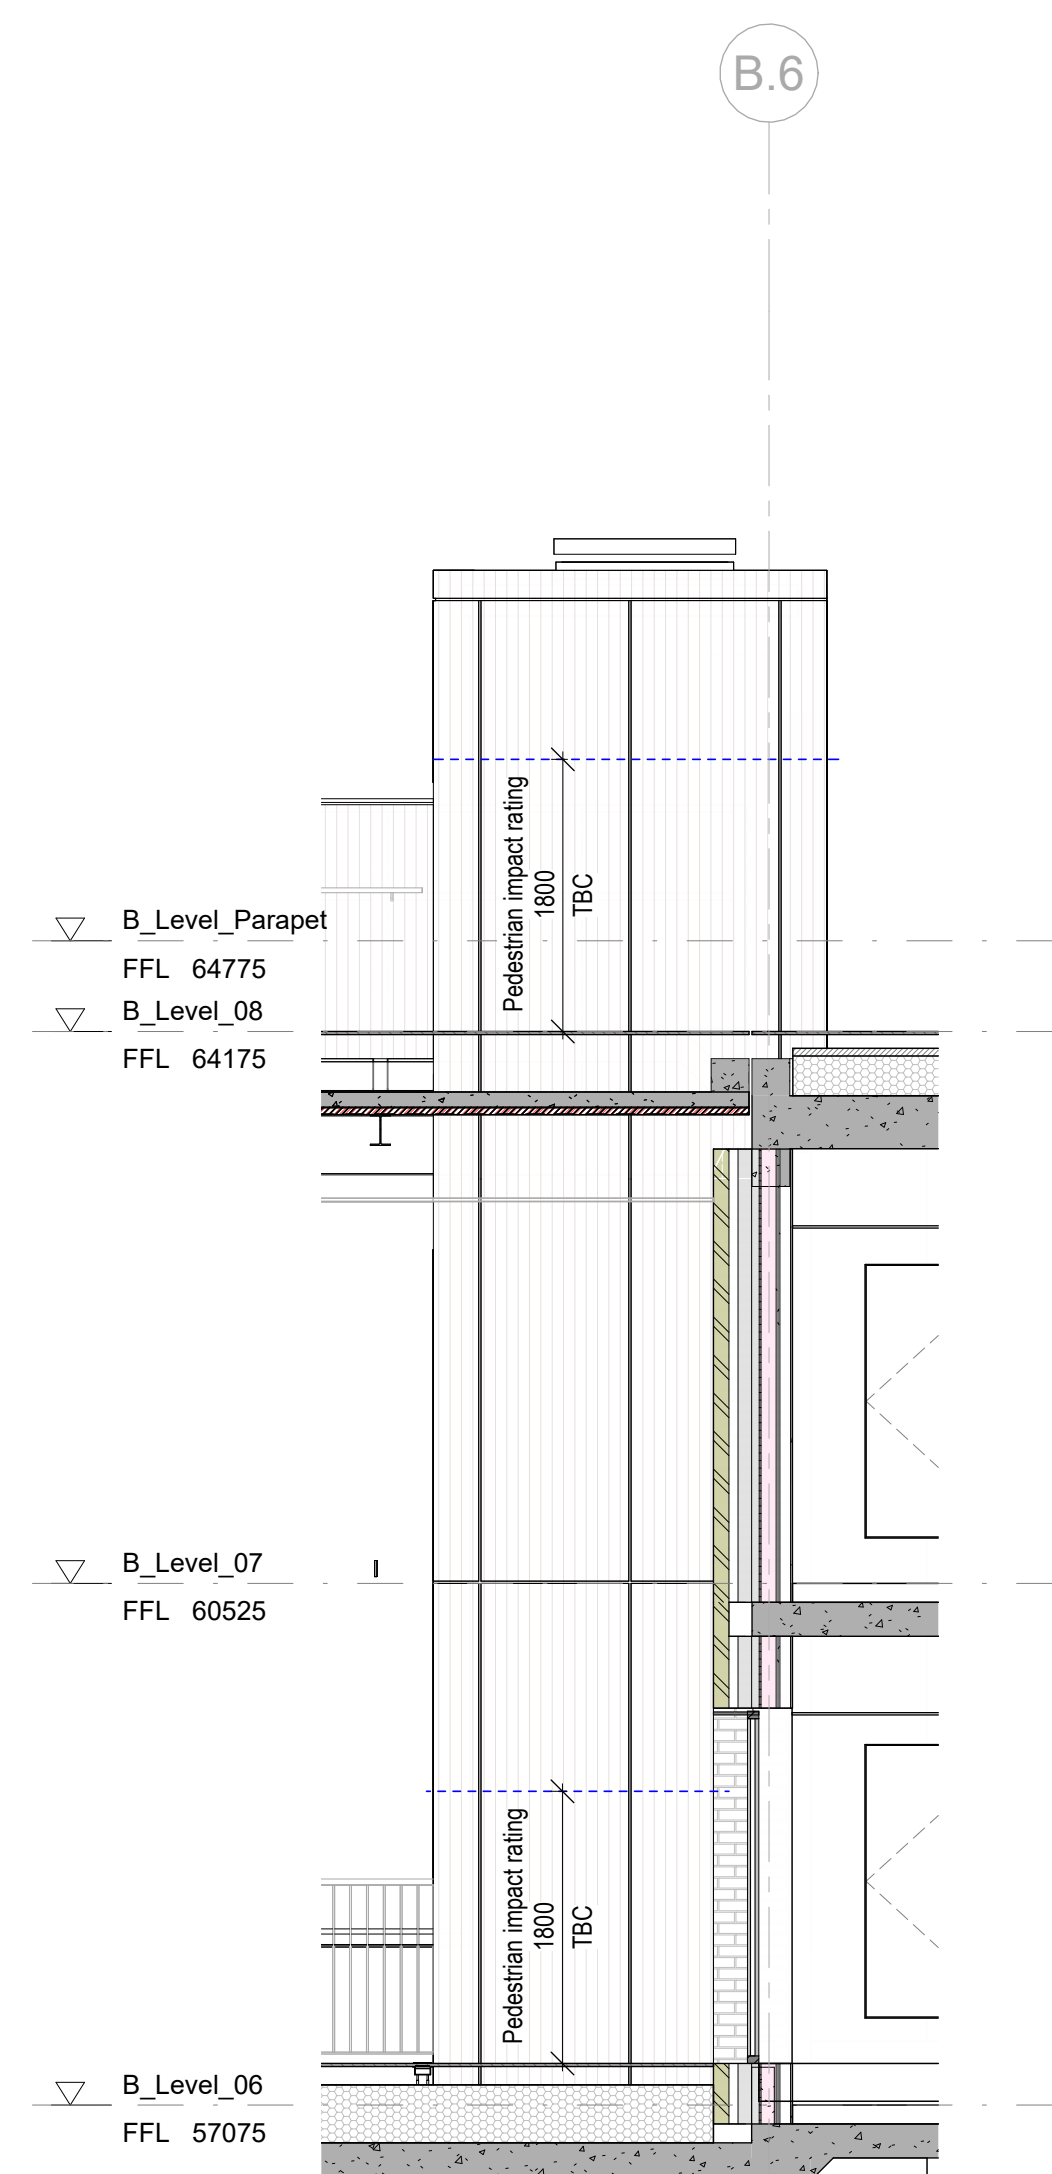


2 South Escape Staircase - View 2
1:50

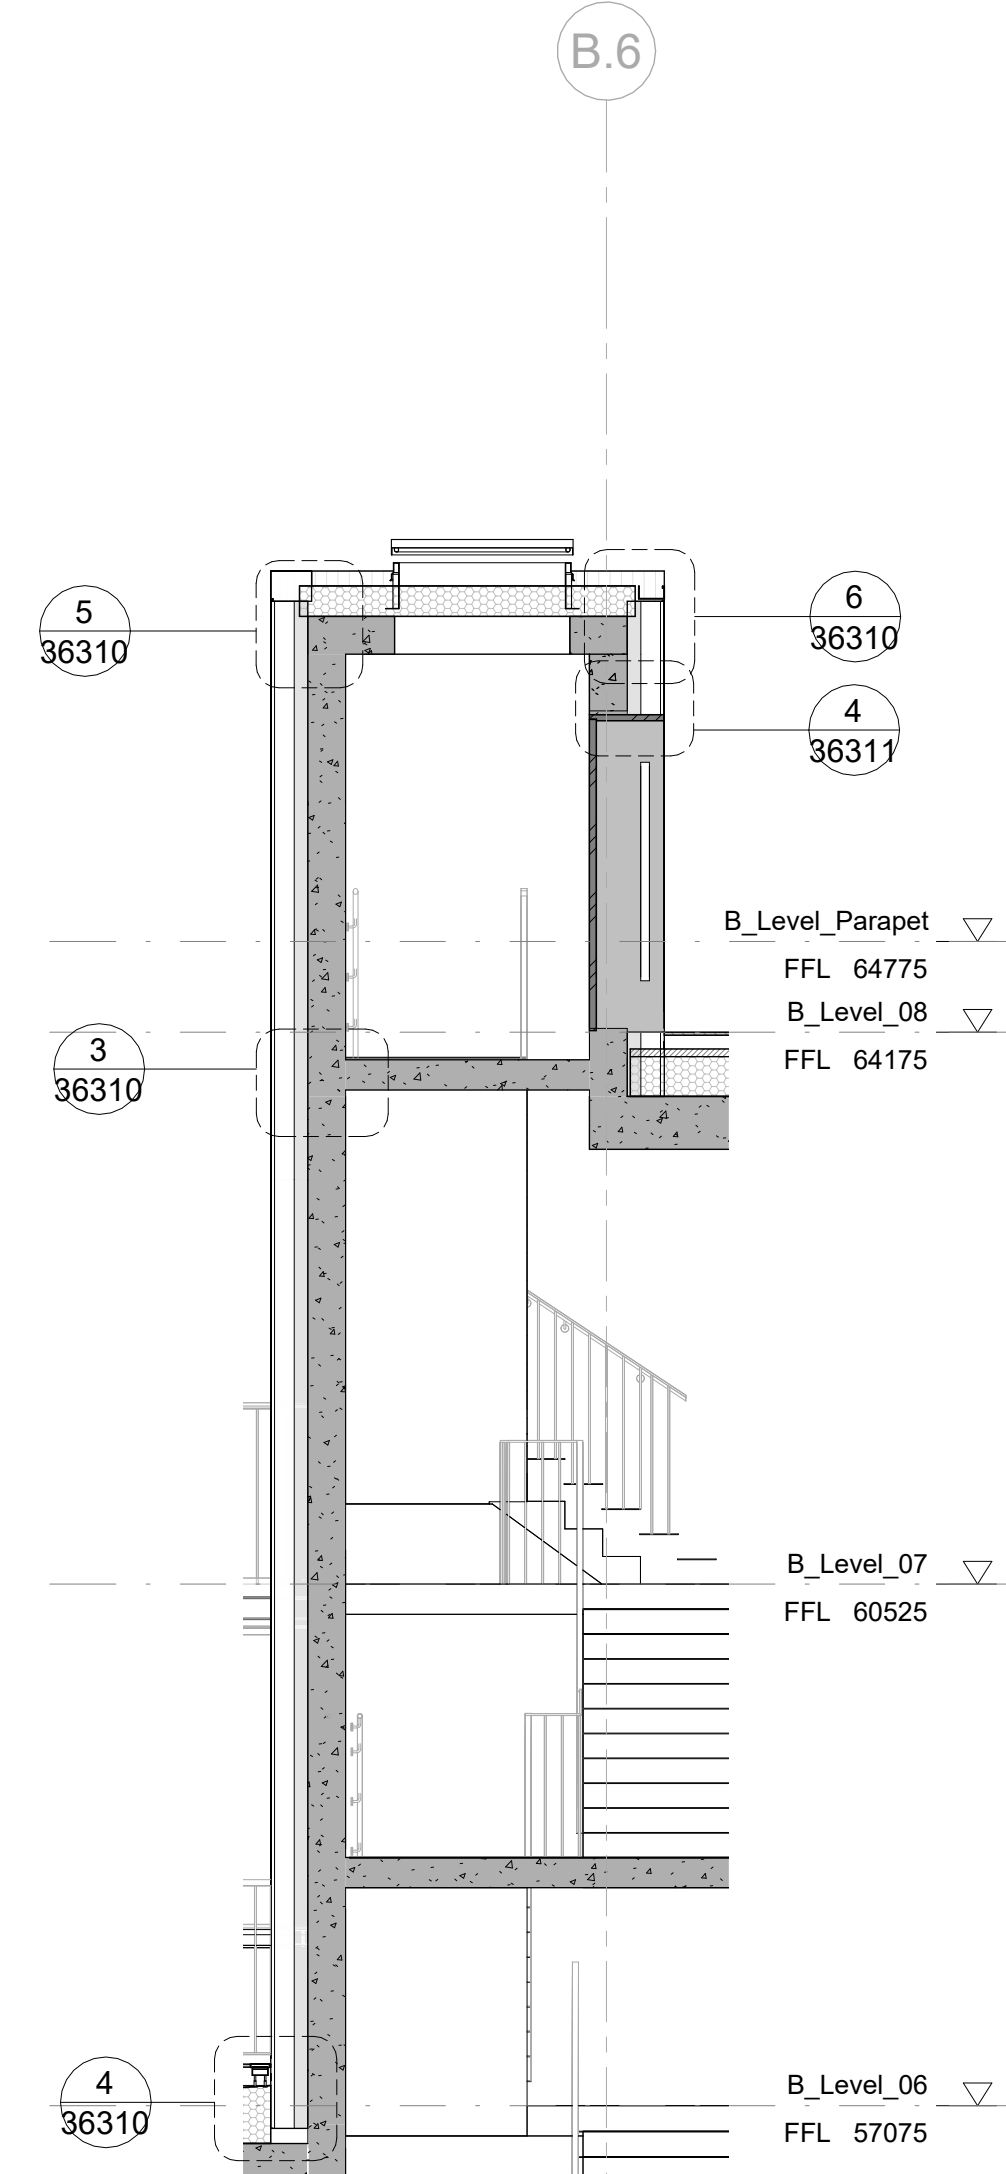


8 South Escape Staircase - Section
1:50

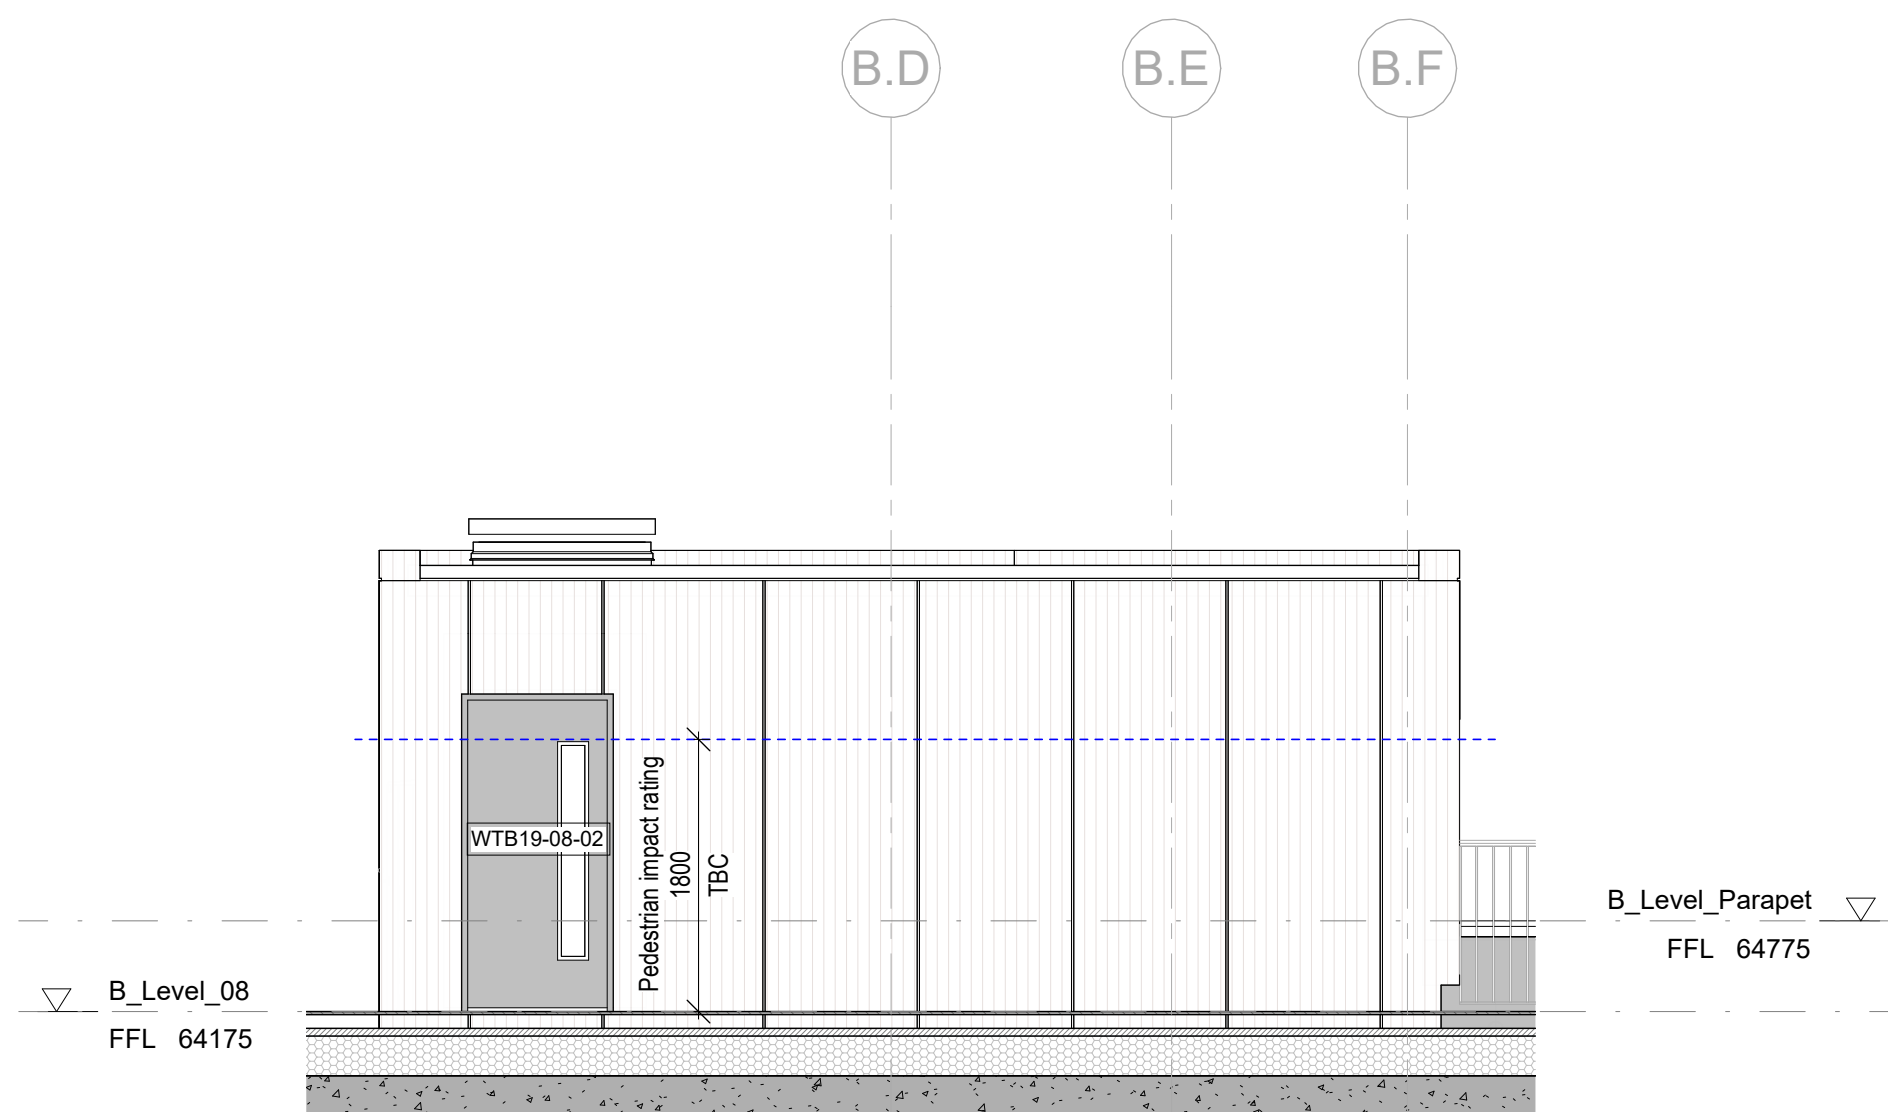


3 South Escape Staircase - View 3
1:50

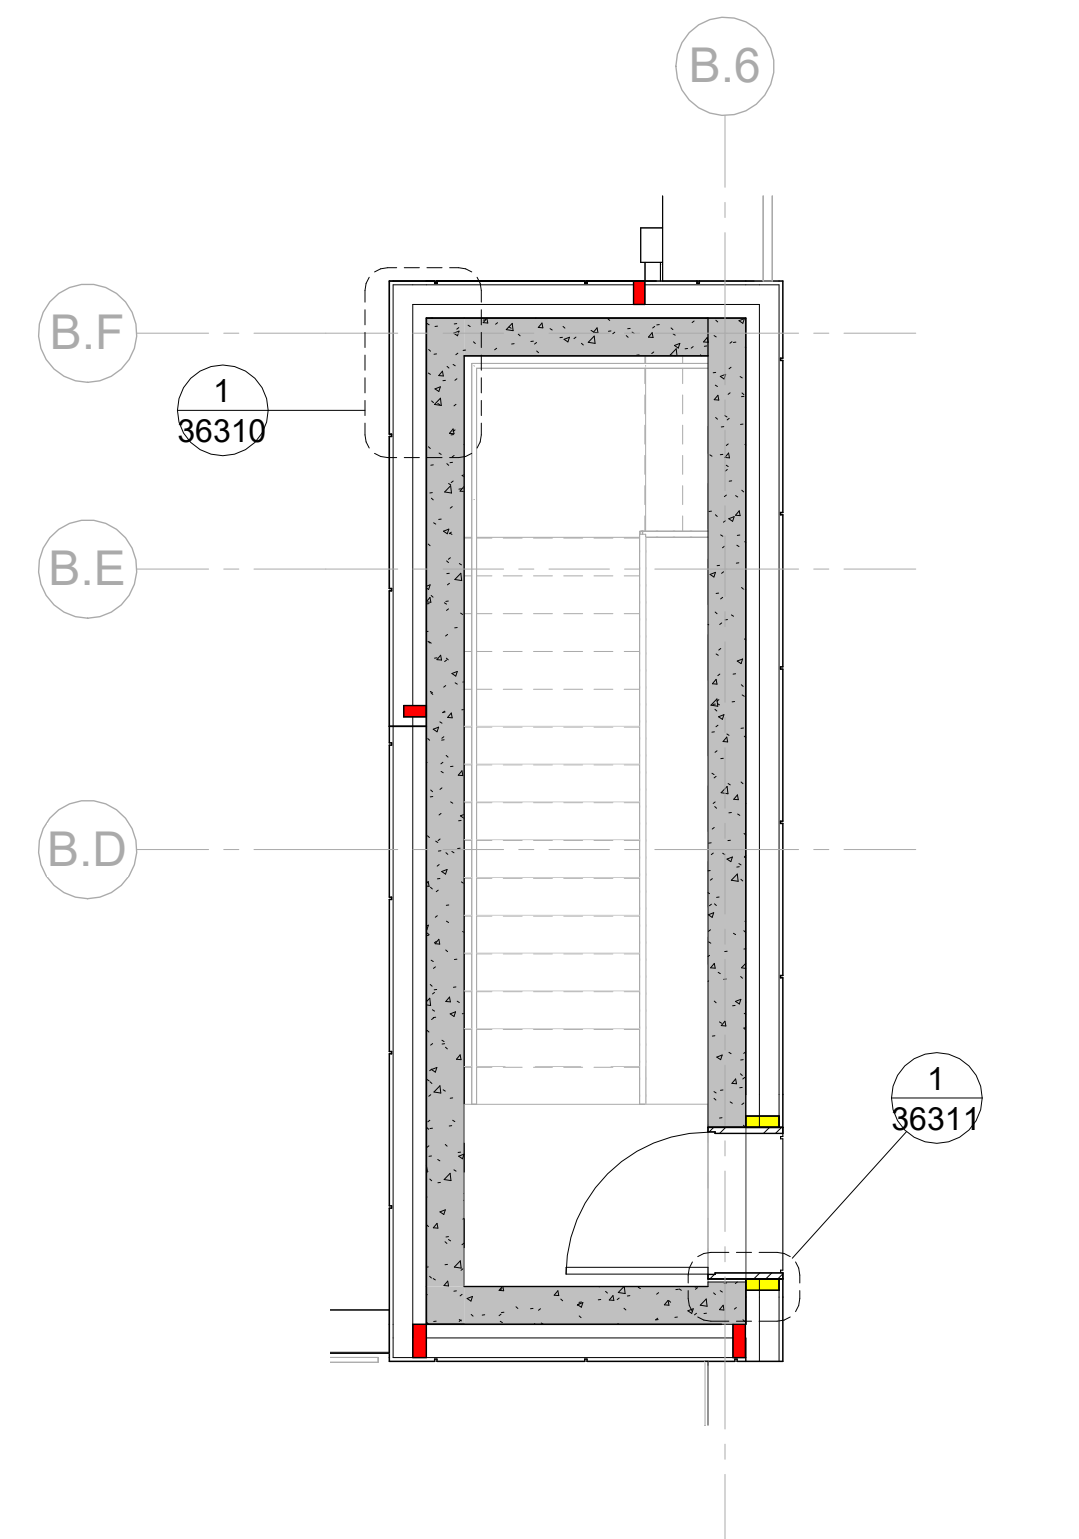

5 South Escape Staircase - Roof Level
1:50

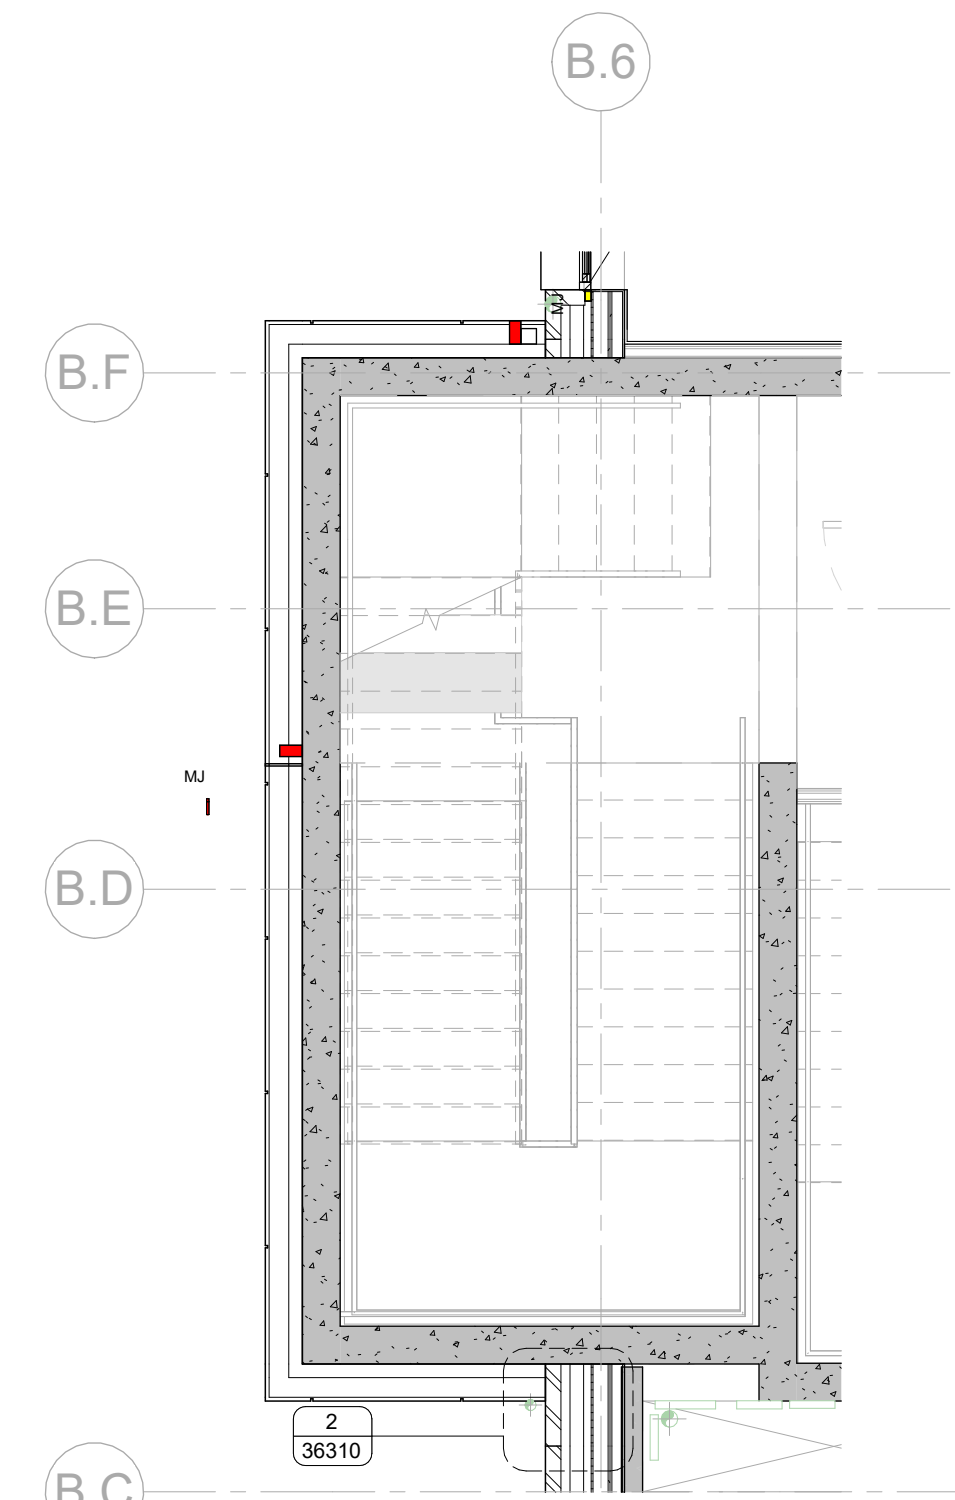

7 South Escape Staircase - Levels 06 and 07
1:50

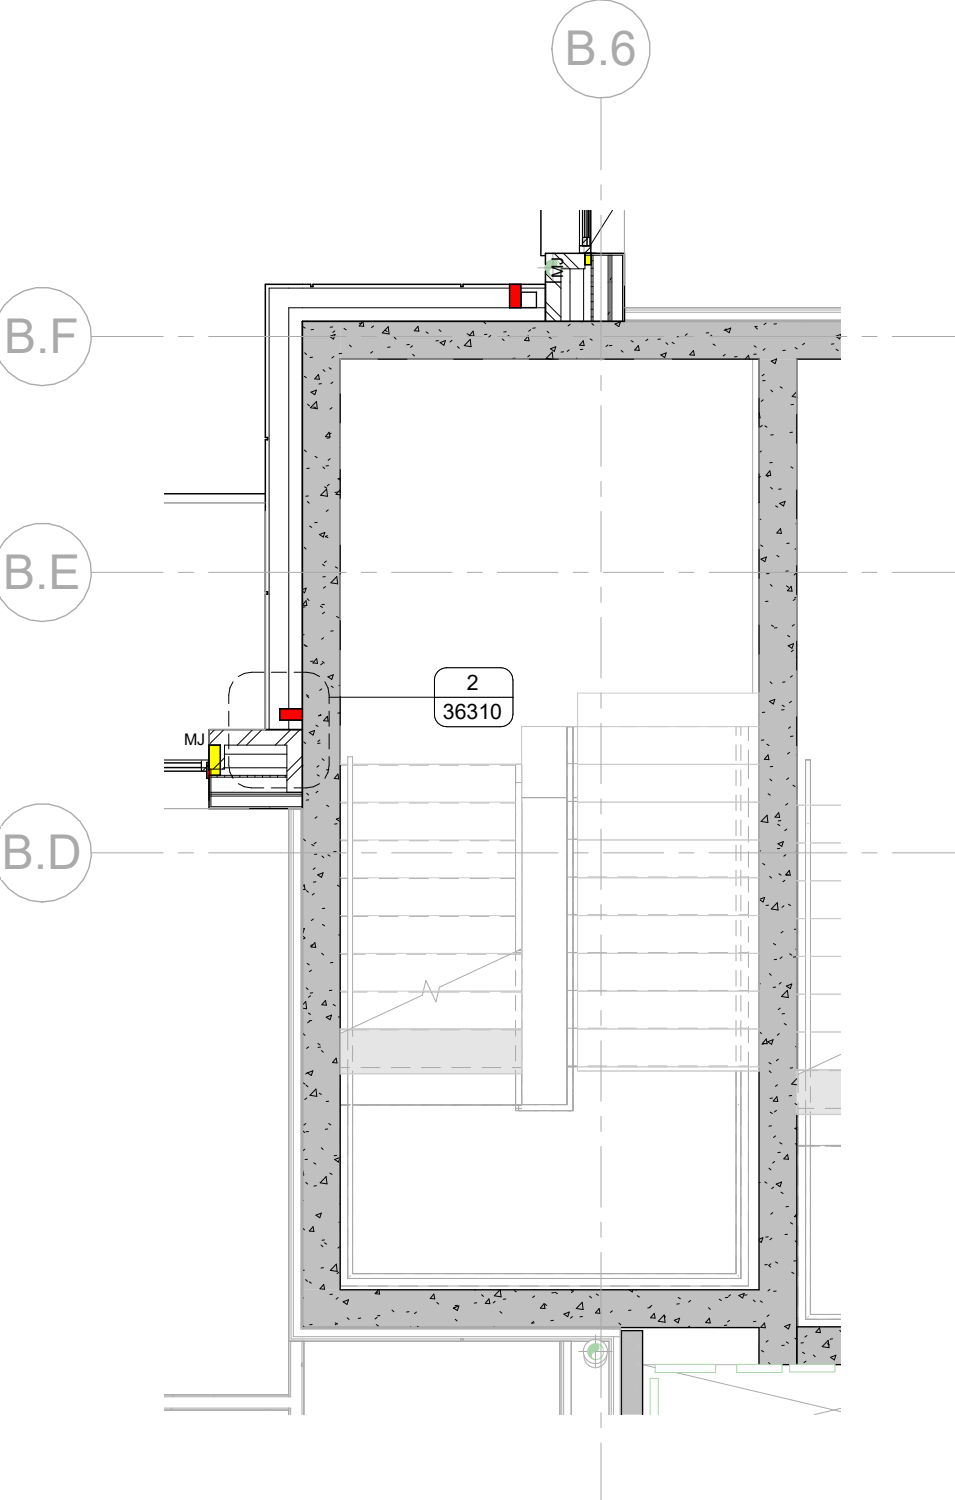

6 B_Level_05 - South Escape Stairs
1:50

©Scott Brownrigg Ltd
This drawing is to be read in conjunction with all relevant architect's and other designers' drawings and associated specifications. Figured dimensions only are to be taken from this drawing. All dimensions are to be checked on site before any work is put in hand.

SCALE BAR: 1:50

- DRAWING SERIES**
- Series 00 - Accommodation Schedules
 - Series 00 - NBS Specification
 - Series 02 - Conveyance Plans
 - Series 03 - GA Plans, GA Setting out Plans & Marketing Plans
 - Series 04 - GA Sections
 - Series 05 - GA Elevations
 - Series 06 - Stage 2 Drawings
 - Series 07 - Bay Studies
 - Series 08 - 3D Views
 - Series 16 - Substructure
 - Series 20 - Superstructure
 - Series 21 - External Wall Types & Details
 - Series 22 - Internal Wall Types & Details
 - Series 24 - Staircases & Lifts
 - Series 27 - Roof Types & Details
 - Series 31 - Window & Doors Types, Details & Schedules
 - Series 35 - Reflected Ceiling Plans
 - Series 36 - Floor Types & Details
 - Series 38 - Balconies & External Metalwork
 - Series 40 - Internal Finishes
 - Series 43 - Floor Finishes
 - Series 60 - Electrical Plans
 - Series 67 - Fire Strategy Plans
 - Series 70 - Flat Type Layouts
 - Series 71 - Signage Plans
 - Series 73 - Kitchen Layouts & Schedules
 - Series 74 - Bathroom Layouts & Schedules
 - Series 76 - Residents Facilities
 - Series 82 - Commercial Units
 - Series 83 - Offices
 - Series 84 - Area Plans

GENERAL NOTES

STRUCTURAL - For design, detailing and setting out of structural elements refer to Structural Engineers drawings.

SERVICES - For design, detailing & setting out of services, including SVPs, Gas, Water, Electricals & Telecoms etc refer to M&E Engineers and Structural Engineers drawings.

All information on this drawing must be read in conjunction with relevant series and specifications.

Refer to:
03 Series Cladding plans for scoping extent,
35 Series SW soffit plans (insulation & metalwork),
38 Series for metalwork details &
DDU / TFS NBS specification for metalwork elements

CO2	Updated Metalwork Issue	05.09.23	CS	JR
CO1	Construction Issue	30.06.23	CS	ACS

Revisions Description Date Drawn Checked

design
delivery
unit

77 Endell Street
London WC2H 9DZ
T +44 (0)20 7240 7766
W designdeliveryunit.com

Clients Name
St George North London Limited



Job Title
Camden Goods Yard

Drawing Title
Building B Urban Farm South Escape
Staircase

Scale
As indicated @A0

Practice Project No.
20226

Practice Project No. Originator Volume Level Type Rev Number
CGYB0-DDU-B0-ZZ-DR-A-36302

Description
CONSTRUCTION

Rev
CO2

© Design Delivery 2023. All rights reserved. This drawing is to be read in conjunction with all relevant architect's and other designers' drawings and associated specifications. Figured dimensions only are to be taken from this drawing. All dimensions are to be checked on site before any work is put in hand.